


Church

School

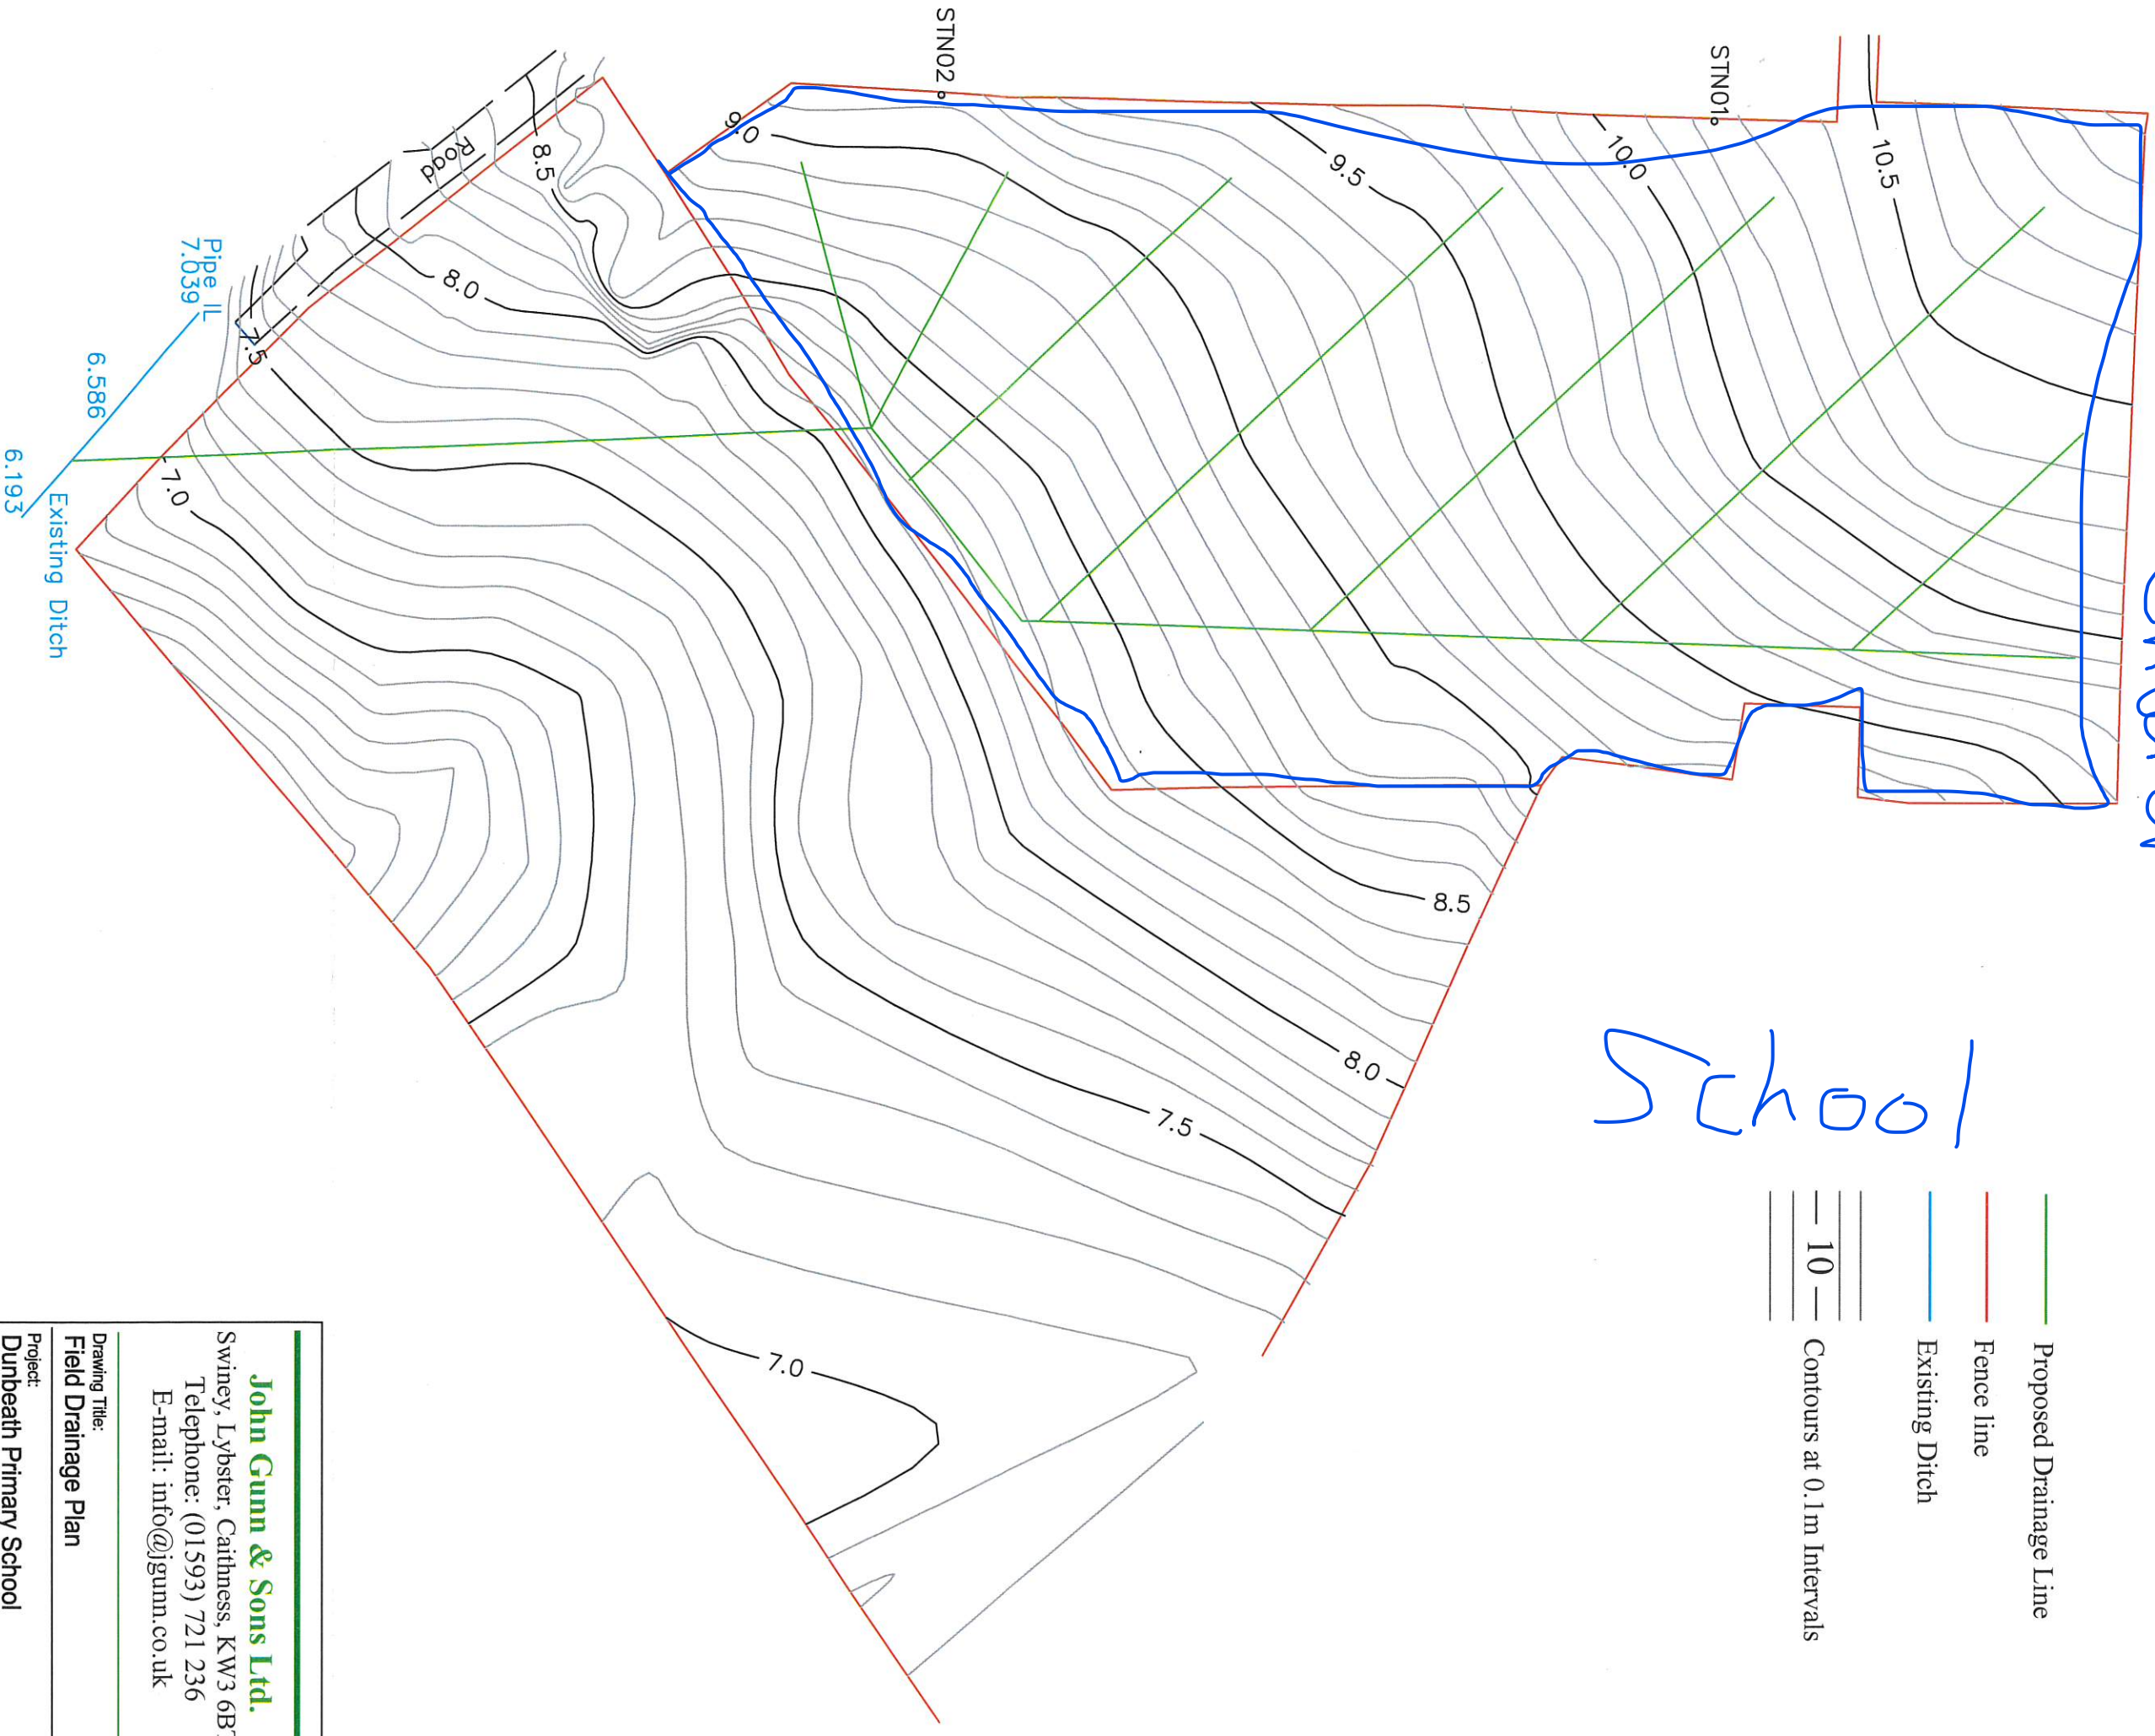

- Proposed Drainage Line
- Fence line
- Existing Ditch
- Contours at 0.1m Intervals

John Gunn & Sons Ltd.
 Swiney, Lybster, Caithness, KW3 6BT
 Telephone: (01593) 721 236
 E-mail: info@jgunn.co.uk

Drawing Title:
Field Drainage Plan

Project:
Dunbeath Primary School

Drawing No: JGUNN001 | Revision:
A

Drawn By: CAH

Approved By: DDS

Date: 29/11/2019

Scale: 1:500 @ A3