



SUDS STATEMENT
 SURFACE WATER DRAINAGE FROM WITHIN PLOTS, INCLUDING ROOFS, DRIVEWAYS AND HARDSTANDINGS, TO DRAIN TO SOAKAWAYS DESIGNED TO BRE 365.
 SURFACE WATER DRAINAGE FROM ROADS AND FOOTPATHS TO BE DESIGNED WITH 3 LEVELS OF TREATMENT AS REQUIRED BY BEST PRACTICE GUIDELINES. TREATMENT WILL INCLUDE SEDIMENT REMOVAL BY TRAPPED GULLIES, SILT AND HYDROCARBON REMOVAL WITHIN FILTER DRAIN AND FURTHER COMPACTION REMOVAL IN CATCHPIPS AND PARTIAL SOAKAWAYS.

LEGEND	
RG	Road Gully
RE	Rodding Eye
CP	Catchpit, Refer Detail
DK	Dropped Kerb
S/A	Surface Water Soakaway

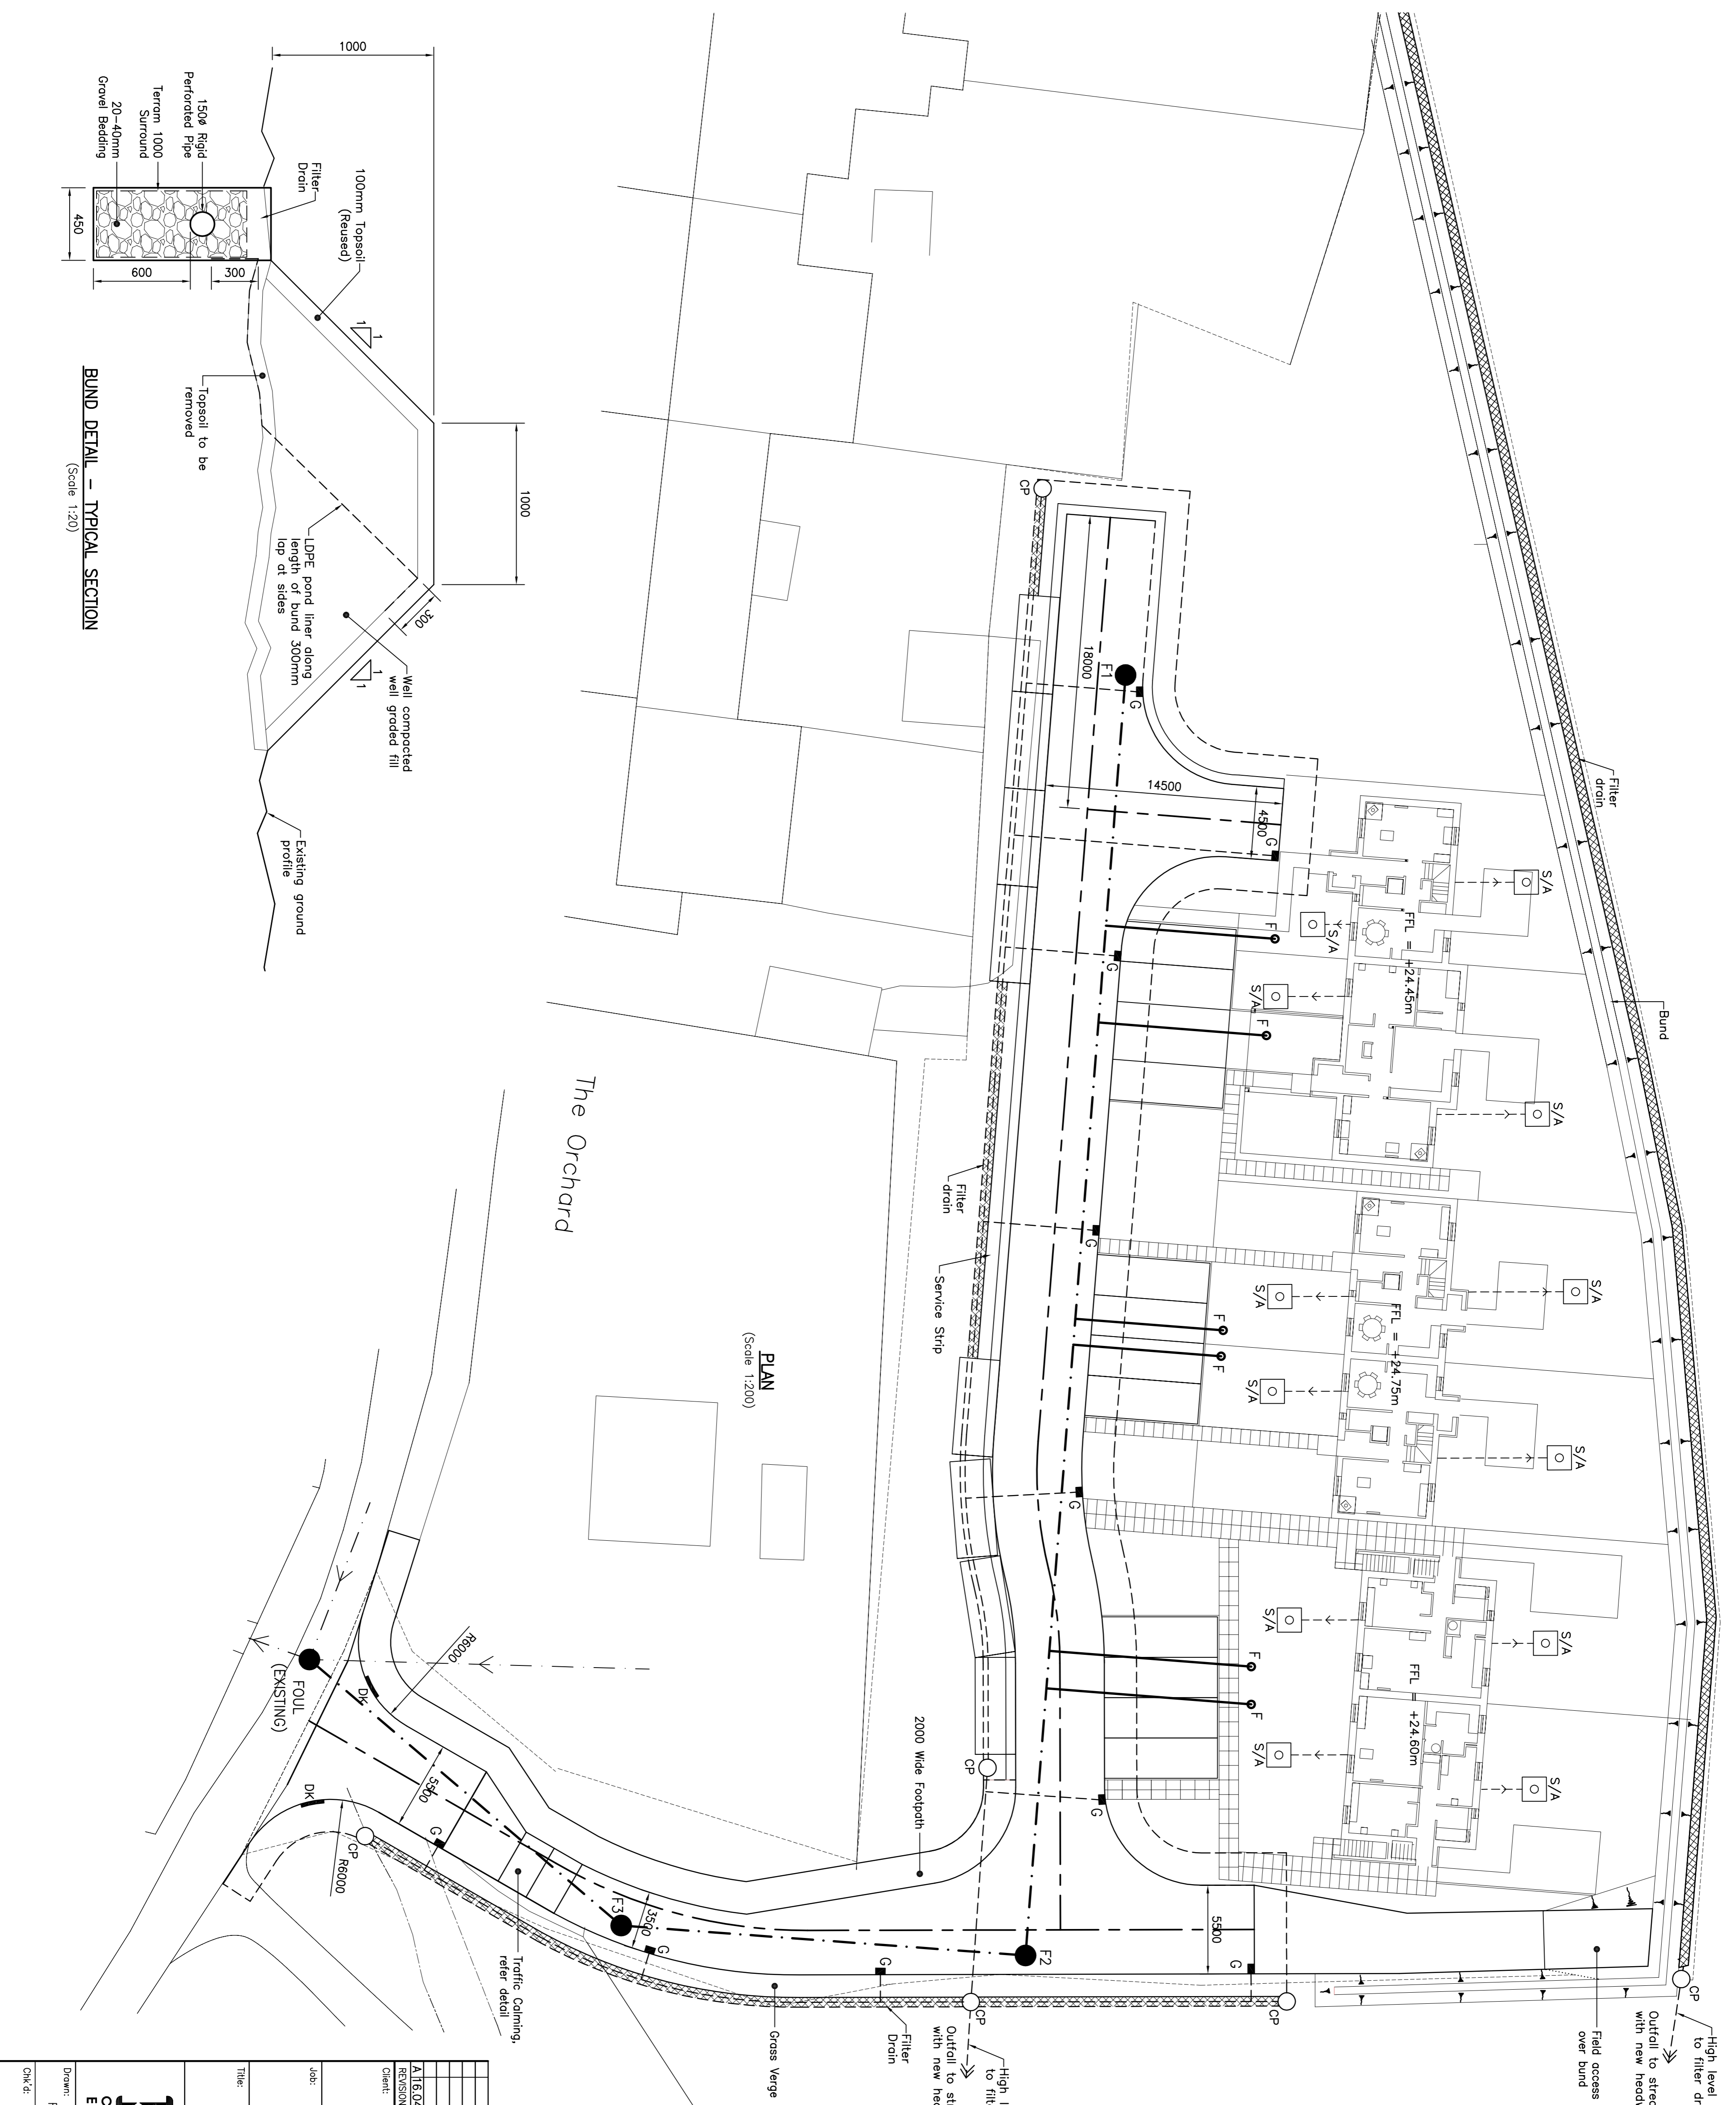

PLAN
 (Scale 1:200)

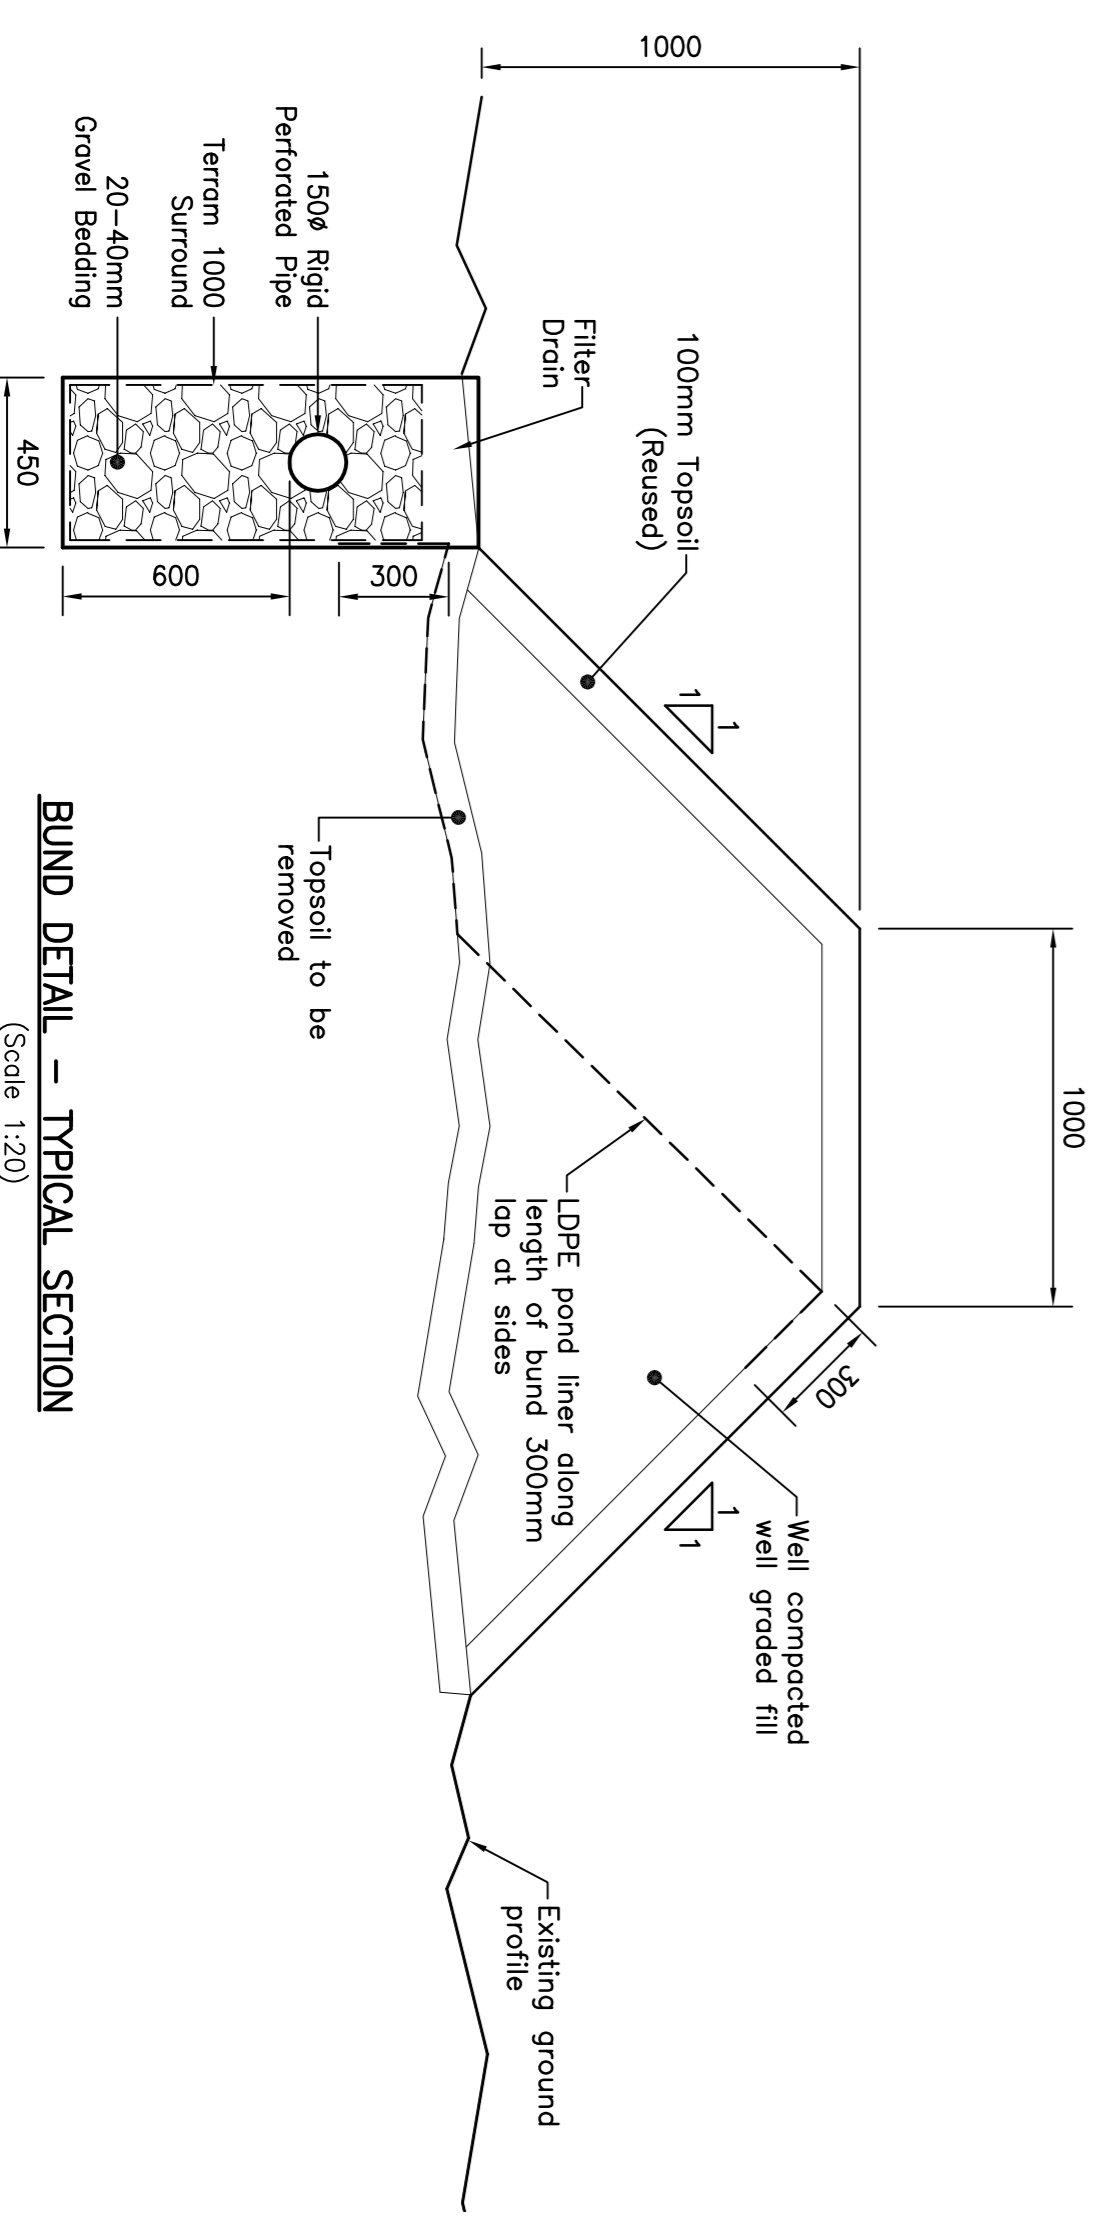

BUND DETAIL - TYPICAL SECTION
 (Scale 1:20)

Client:	LOCHALSH AND SKYE HOUSING ASSOCIATION
Job:	HOUSING DEVELOPMENT BALMACARA SQUARE
Title:	ROAD AND DRAINAGE LAYOUT
Revisions:	A/16.04.13 GENERAL UPDATE FOR PLANNING
Drawn:	RM
Scale:	As Shown
Date:	05.12.12
Checked:	

KWA
Consulting Engineers

Alpha Court
DINGWALL

Tel: (01349) 853333 Fax: (01349) 853888
 Email: enquiries@kwa.co.uk

Drawing No: **KWA/07246/101A**