


ALL DIMENSIONS TO BE CHECKED ON SITE. NO DIMENSIONS TO BE SCALED FROM THIS DRAWING. DRAWING IS TO BE READ IN CONJUNCTION WITH RELEVANT CONSULTANTS DRAWINGS.

SITE KEY PLAN

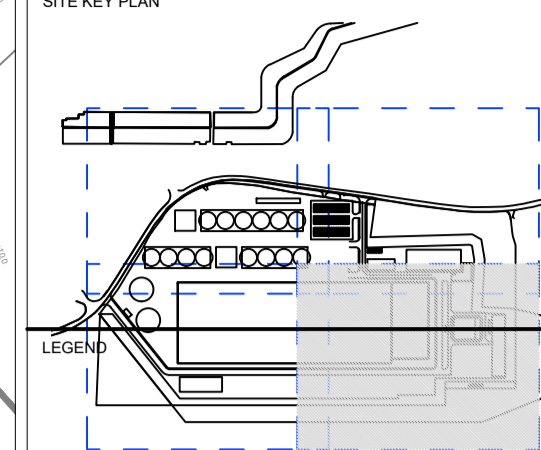

- SITE BOUNDARY
- EXISTING FOUL SEWER
- EXISTING COMBINED SEWER
- EXISTING STORM SEWER
- EXISTING WATERMAIN
- EXISTING WATERMAIN REMOVED
- EXISTING GAS MAIN
- EXISTING TELECOM CABLES
- EXISTING ELECTRICAL CABLE
- PROPOSED FOUL SEWER
- PROPOSED SURFACE WATER
- PROPOSED (INT.) SURFACE WATER
- PROPOSED WATERMAIN
- PROPOSED FIRE MAIN
- PROPOSED GULLY RUN
- PROPOSED GAS MAIN
- PROPOSED DUCT
- PROPOSED ELECTRICAL
- EXISTING STORM MANHOLE
- PROPOSED STORM MANHOLE
- ARMSTRONG JUNCTION
- LIGHTING POINT
- SLUICE VALVE
- PROPOSED WATER HYDRANT
- EXISTING FOUL MANHOLE
- PROPOSED FOUL MANHOLE
- PROPOSED GULLY
- FIRE HYDRANTS
- MINI PILLAR
- RAINWATER DOWNPIPE
- RAINWATER DOWNPIPE (AT LOWER LEVEL)
- Rain Water Harvester

**SUMITOMO ELECTRIC** STA CABLE FACTORY NIGG, TAIN IV19 1QU

**eda** ARCHITECTS EDA Architects Ltd Omagh Enterprise Centre, 41 Corrush Ind Est, Omagh BT78 5LU eoghan@eda-architects.com

REVISIONS

NO.	DATE	DESCRIPTION	BY	CHK	DRN

P01	21/08/23	ISSUED FOR PLANNING	DC	DG
REV DATE	DESCRIPTION	CHK	DRN	

STATUS: PLANNING

PROJECT: SEIUK - CL

PROJECT ADDRESS: -

DISCIPLINE: CIVIL

DWG TITLE: Firemain - Zone 3

DWG NO: S-264-EUR-EXT-ZZ-DR-CS-2263

STATUS CODE: C4


PROJECT NO: S-264 DATE: 21/08/23

DRAWN / CHECKED: DG SCALE NO: 1:500

REVISION NUMBER

P01

**EUROPLAN GROUP**  
 Parkview House, Beechill Office Campus, Clonskeagh, Dublin 4, Eire.  
 Tel: +353 1 2606578  
 staprojectteam@europlanservices.com

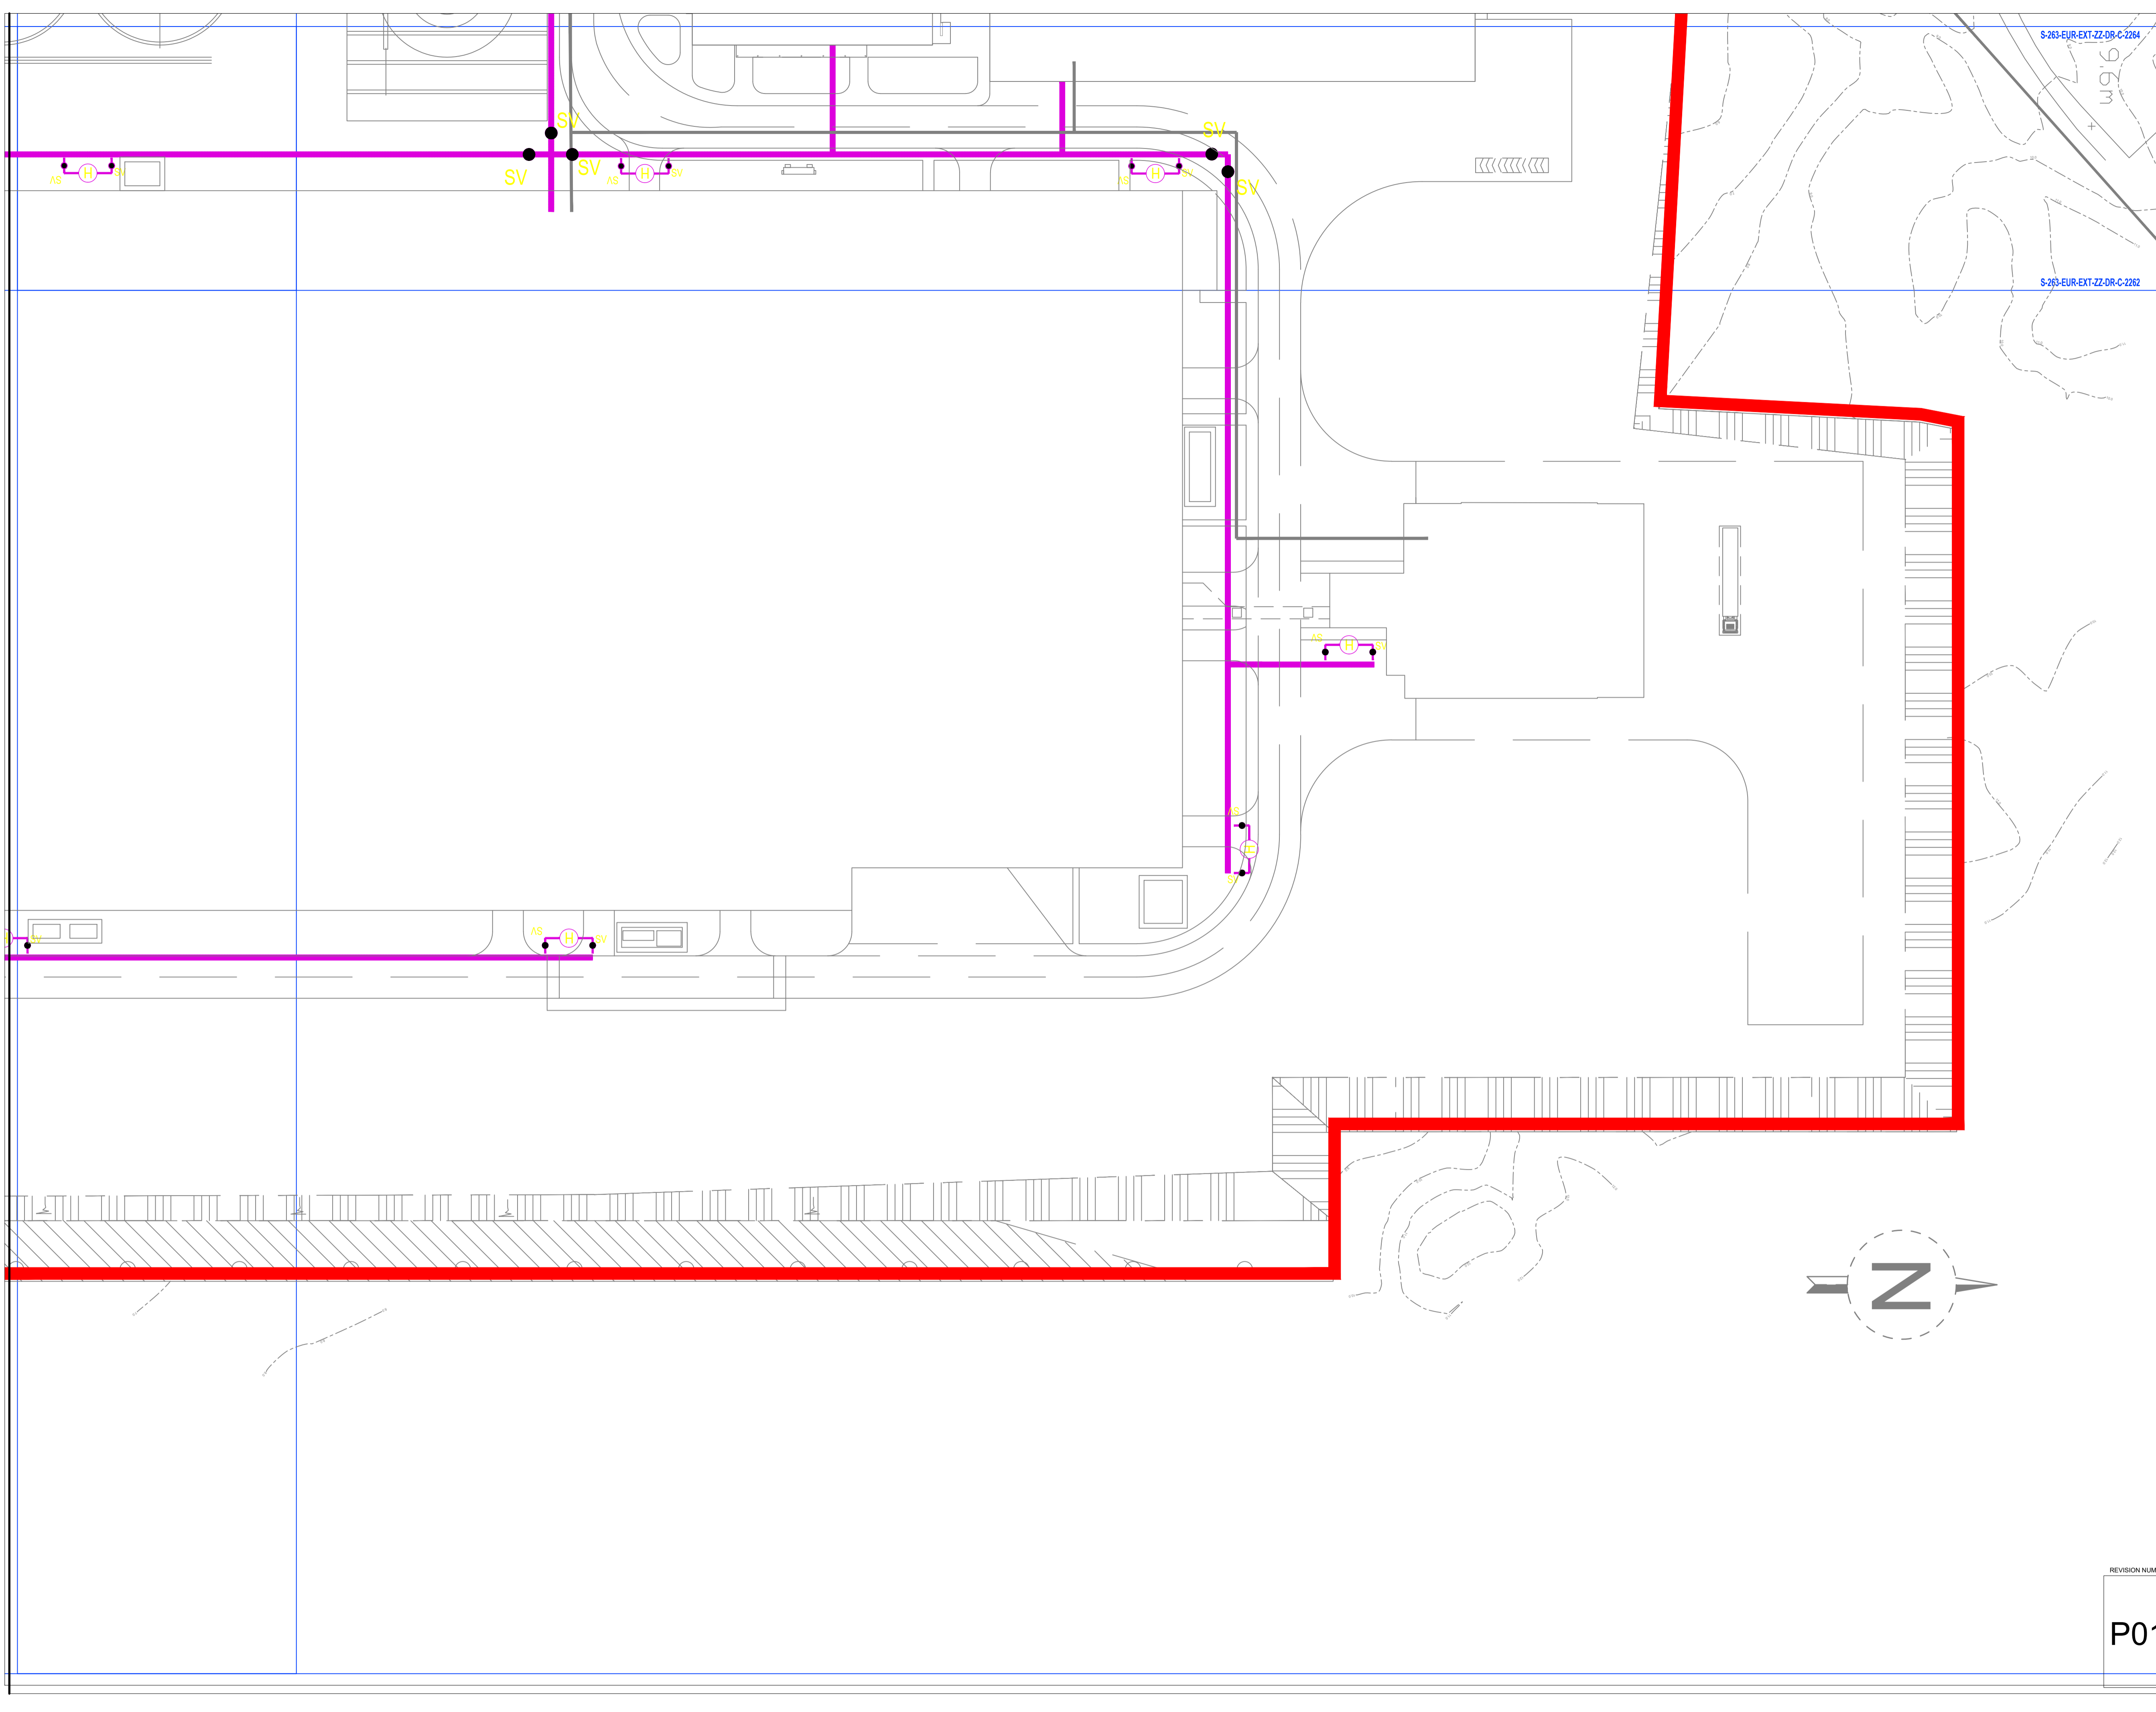


ALL DIMENSIONS TO BE CHECKED ON SITE  
NO DIMENSIONS TO BE SCALED FROM THIS  
DRAWING DRAWING IS TO BE READ IN  
CONJUNCTION WITH RELEVANT  
CONSULTANTS DRAWINGS

A1

SITE KEY PLAN

LEGEND

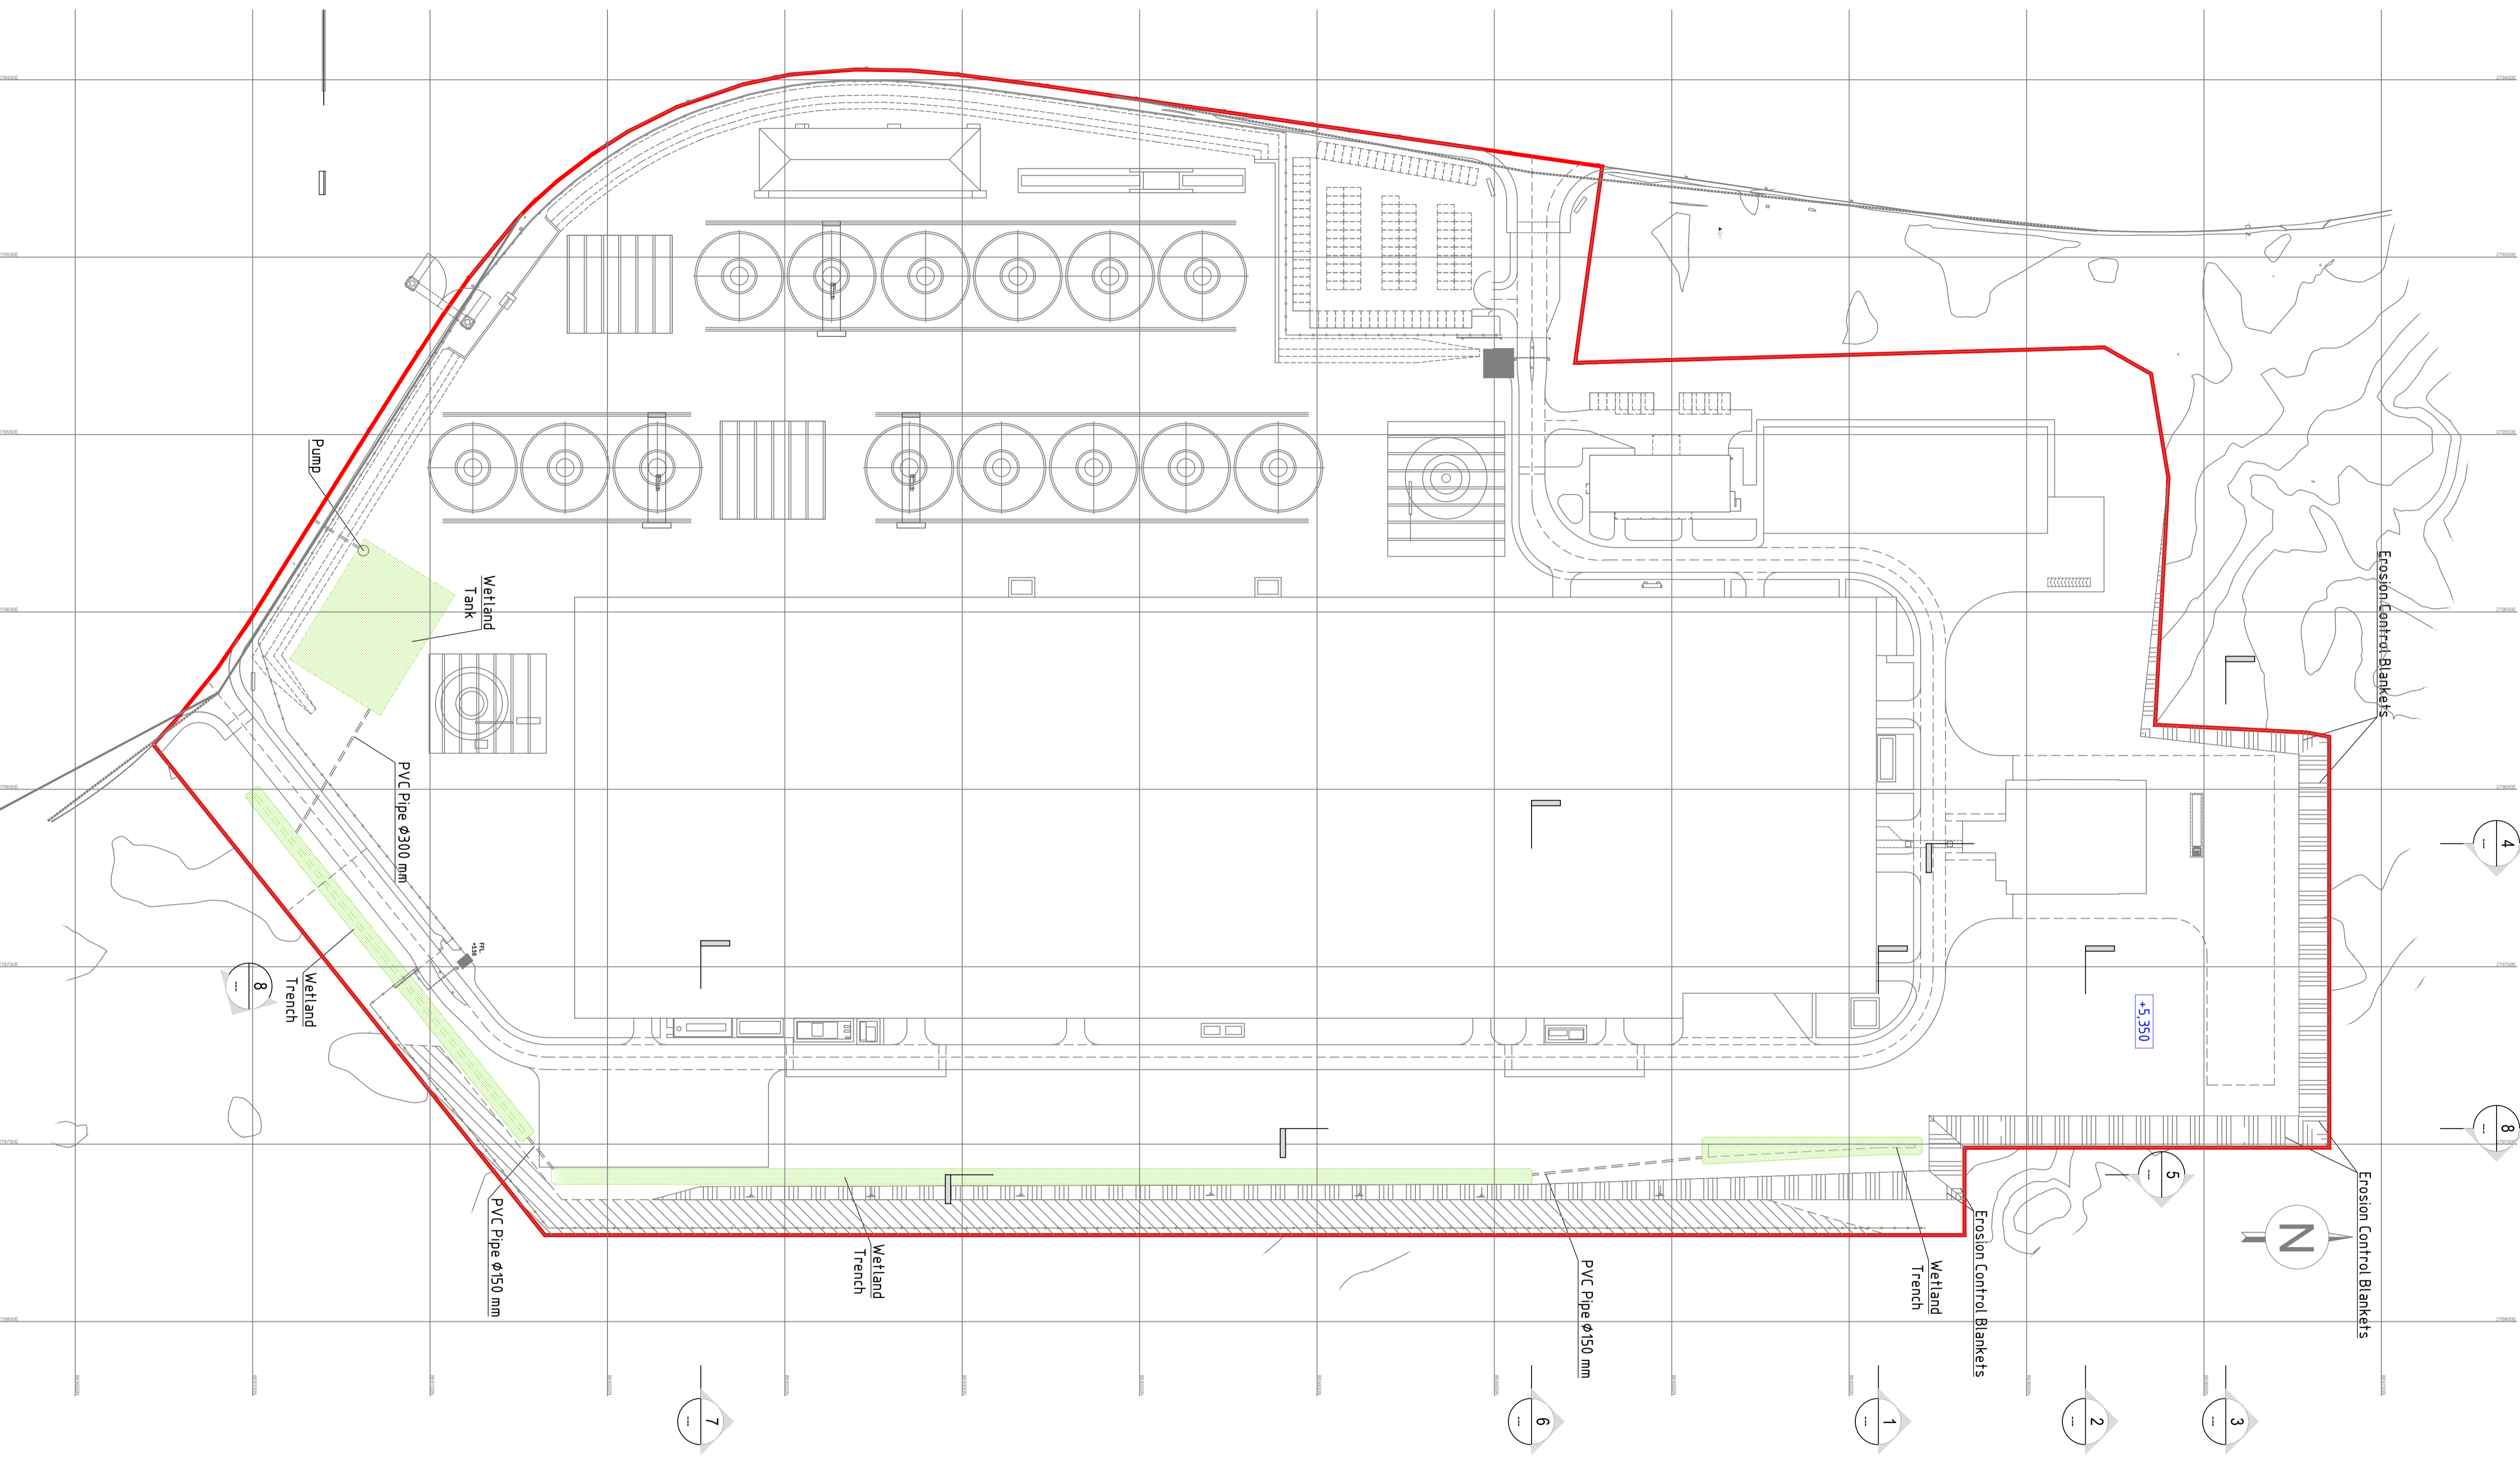

**SUMITOMO ELECTRIC** SEUK CL  
NIGG, TAIN IV19 1QU

**eda ARCHITECTS**  
EDA Architects Ltd  
Omagh Enterprise Centre,  
41 Gortrush Ind Est,  
Omagh BT78 5LJ  
eoghan@eda-architects.com

REVISIONS

NO.	DATE	DESCRIPTION	CHK	DRN



P01	21/08/23	ISSUED FOR PLANNING	DC	DG
REV	DATE	DESCRIPTION	CHK	DRN
STATUS				
PLANNING				
PROJECT				
SEIUK - CL				
PROJECT ADDRESS				
-				
DISCIPLINE				
CIVIL				
DWG TITLE				
SITE SECTIONS - LOCATION PLAN				
-				
DWG NO.				
S-264-EUR-EXT-ZZ-DR-CS-6300				
STATUS CODE				
C4				
PROJECT NO.		DATE		
S-264		21/08/23		
DRAWN / CHECKED		SCALE NO.		
DG -		(@A1) 1:500		

REFER TO DRAWINGS S-264-EUR-EXT-ZZ-DR-CS-6301 to  
S-264-EUR-EXT-ZZ-DR-CS-6310 FOR SITE CROSS SECTIONS

REVISION NUMBER

**P01**

**EUROPLAN GROUP**  
Parkview House, Beechill Office Campus,  
Clonskeagh, Dublin 4, Eire.  
Tel: +353 1 2606578  
staprojectteam@euoplanservices.com

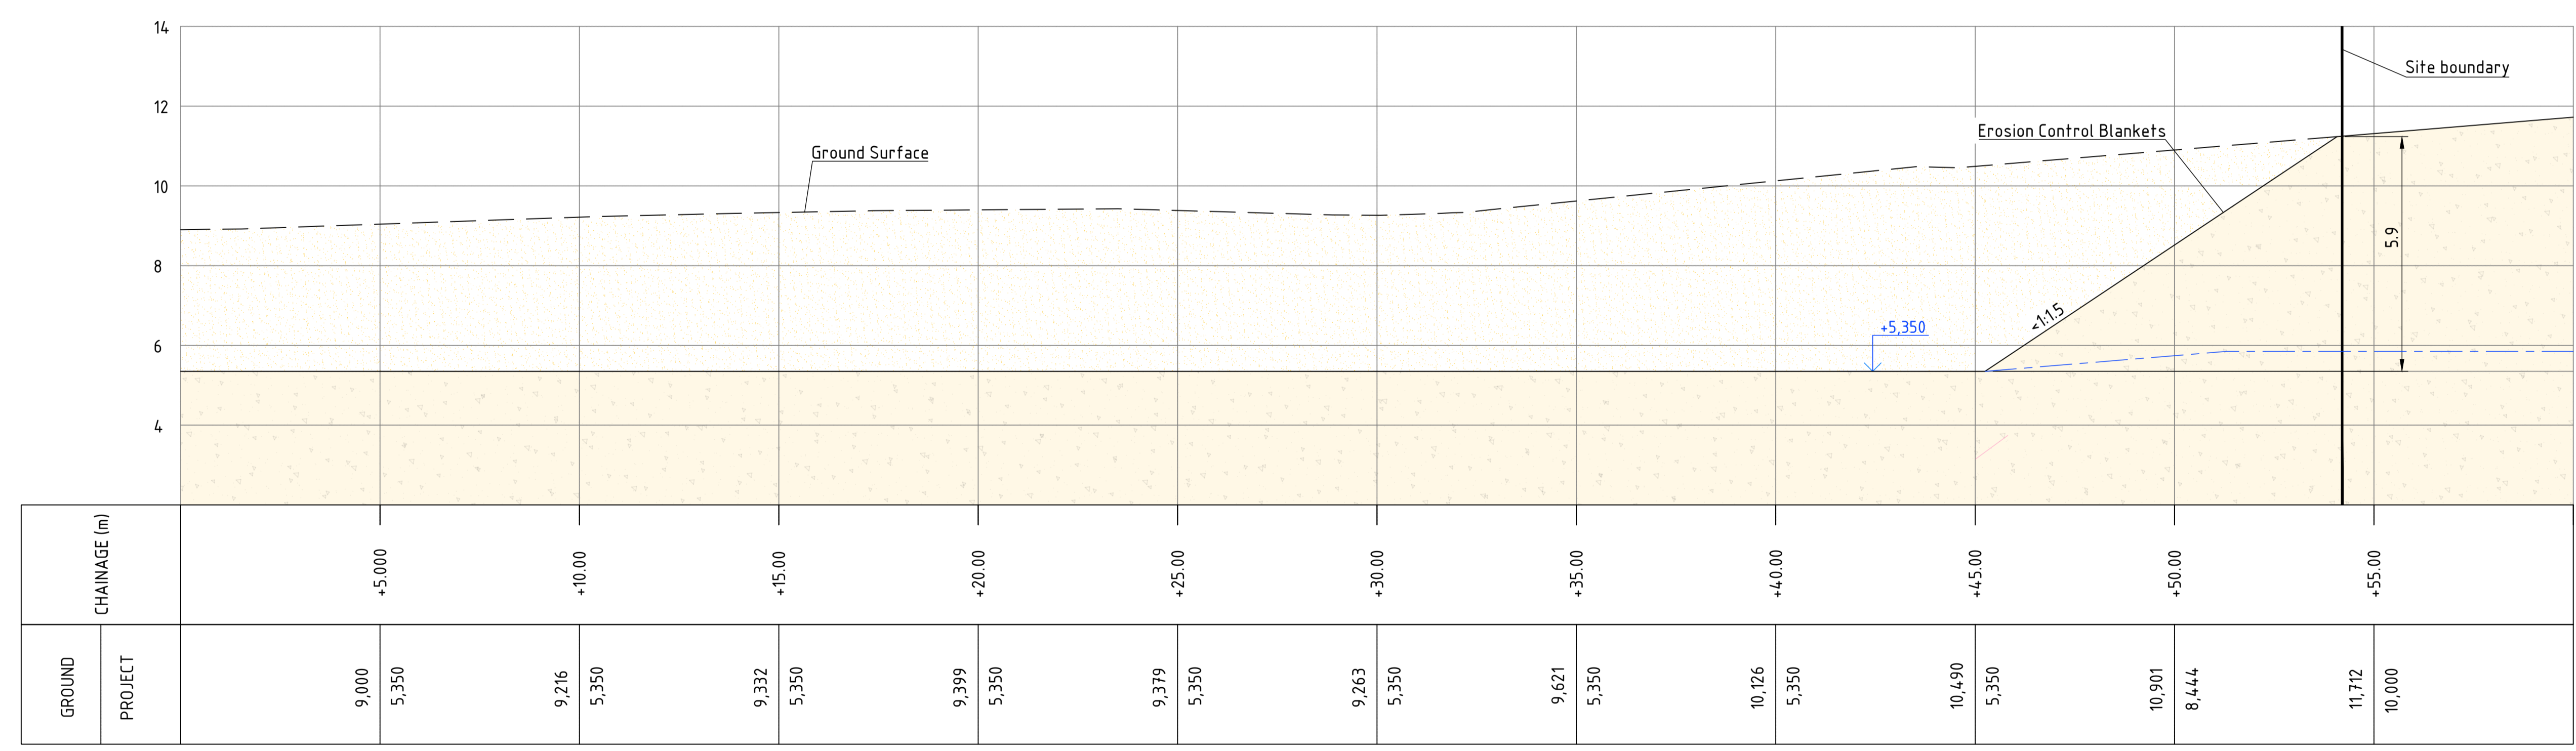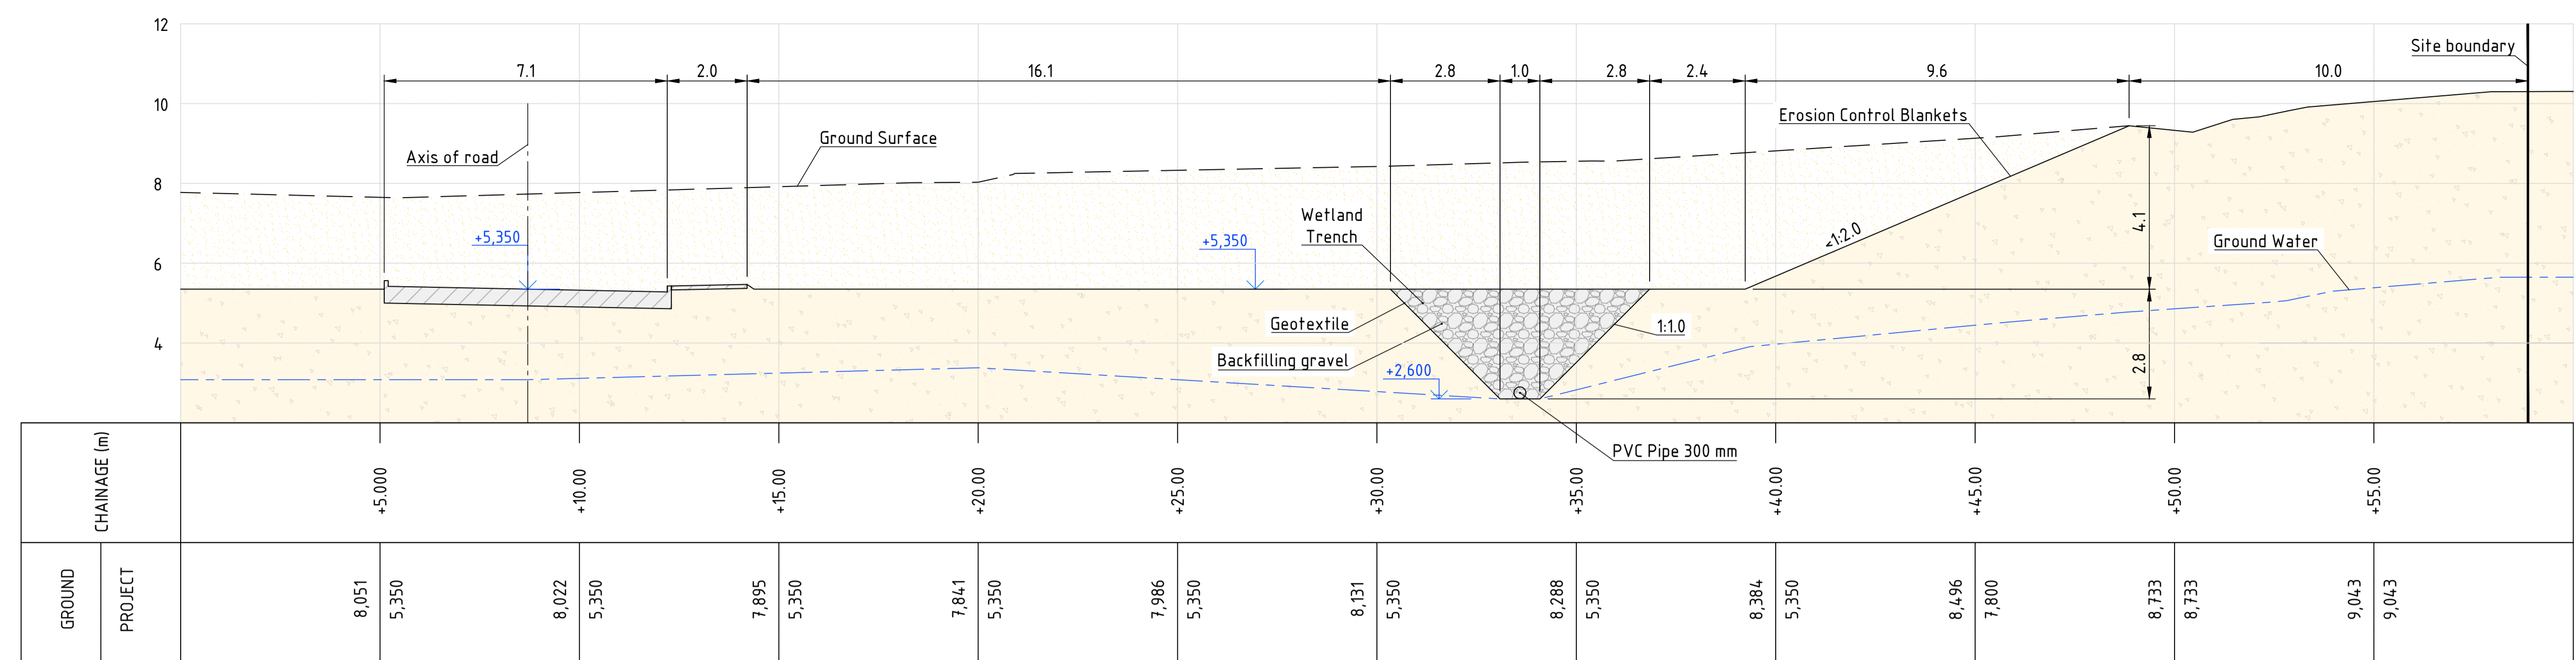

SITE KEY PLAN

LEGEND

**SUMITOMO ELECTRIC** SEUK CL  
NIGG, TAIN IV19 1QU

**eda ARCHITECTS**  
EDA Architects Ltd  
Omagh Enterprise Centre,  
41 Gortrush Ind Est,  
Omagh BT78 5LJ  
eoghan@eda-architects.com

REVISIONS

NO.	DATE	DESCRIPTION	BY	CHKD

P01	21/08/23	ISSUED FOR PLANNING	DC	DG
REV DATE	DESCRIPTION	CKH	DRN	
STATUS				
PLANNING				
PROJECT				
SEIUK - CL				
PROJECT ADDRESS				
-				
DISCIPLINE				
CIVIL				
DWG TITLE				
SITE SECTIONS - SHEET 1				
-				
DWG NO.				
S-264-EUR-EXT-ZZ-DR-CS-6301				
STATUS CODE				
C4				
PROJECT NO.		DATE		
S-264		21/08/23		
DRAWN / CHECKED		SCALE NO.		
DG -		(@A1) 1:100		


REVISION NUMBER

**P01**

**EUROPLAN GROUP**  
Parkview House, Beechill Office Campus,  
Clonskeagh, Dublin 4, Eire.  
Tel: +353 1 2606578  
staprojectteam@europlanservices.com


SITE KEY PLAN

LEGEND

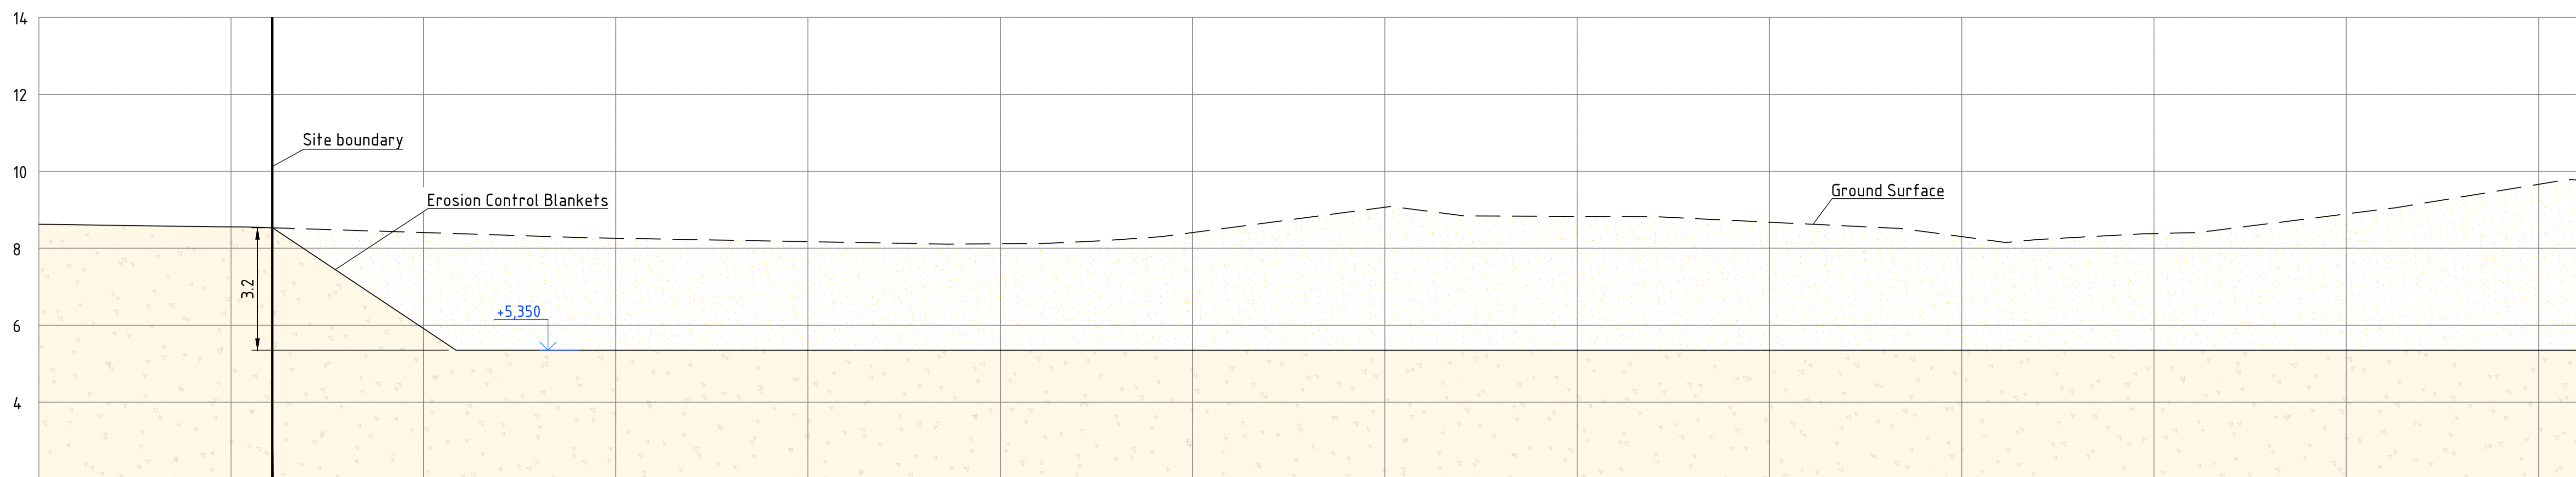

GROUND PROJECT	CHAINAGE (m)
8.533	+5.000
8.533	+5.000
8.415	+10.000
5.350	+10.000
8.261	+15.000
5.350	+15.000
8.173	+20.000
5.350	+20.000
8.117	+25.000
5.350	+25.000
8.408	+30.000
5.350	+30.000
5.350	+35.000
5.350	+35.000
8.829	+40.000
5.350	+40.000
8.679	+45.000
5.350	+45.000
8.303	+50.000
5.350	+50.000
8.382	+55.000
5.350	+55.000
8.892	+60.000
5.350	+60.000
9.663	+65.000
5.350	+65.000

Section 3-3  
1:100

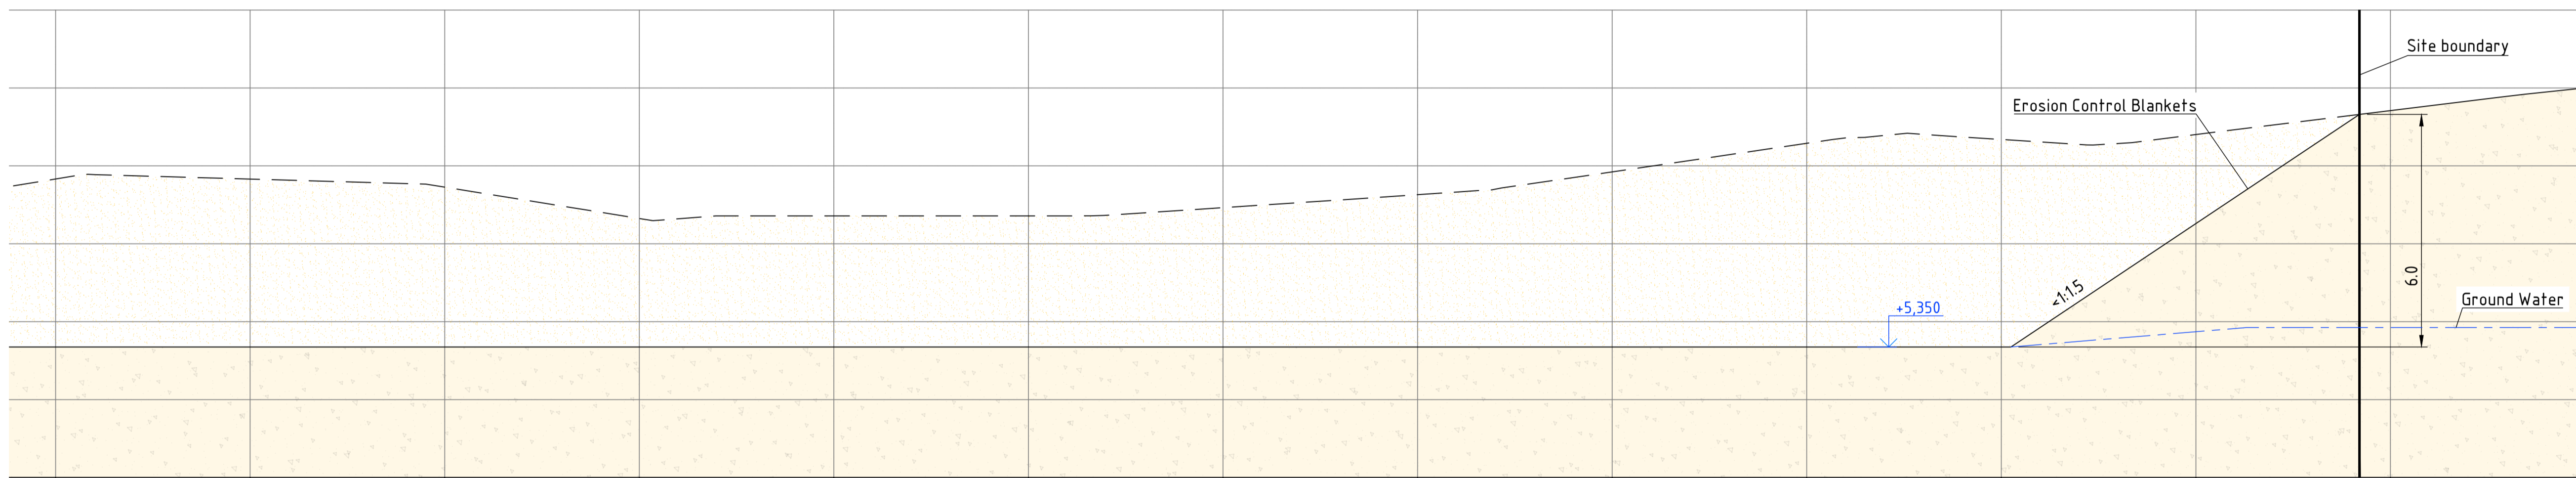

GROUND PROJECT	CHAINAGE (m)
9.663	+65.000
5.350	+70.000
9.661	+70.000
5.350	+75.000
9.453	+75.000
5.350	+80.000
8.649	+80.000
5.350	+85.000
8.716	+85.000
5.350	+90.000
8.716	+90.000
5.350	+95.000
8.927	+95.000
5.350	+100.000
9.260	+100.000
5.350	+105.000
9.846	+105.000
5.350	+110.000
10.579	+110.000
5.350	+115.000
10.677	+115.000
5.350	+120.000
10.805	+120.000
9.518	+125.000
11.419	+125.000
11.419	+125.000

Section 3-3 (continuation)  
1:100

**SUMITOMO ELECTRIC** **SEUK CL**  
NIGG, TAIN IV19 1QU

**eda ARCHITECTS**  
EDA Architects Ltd  
Omagh Enterprise Centre,  
41 Gortrush Ind Est,  
Omagh BT78 5LU  
eoghan@eda-architects.com

REVISIONS

NO.	DATE	DESCRIPTION	CHK	DRN

P01	21/08/23	ISSUED FOR PLANNING	DC	DG
REV	DATE	DESCRIPTION	CHK	DRN
STATUS				
PLANNING				
PROJECT				
SEIUK - CL				
PROJECT ADDRESS				
-				
DISCIPLINE				
CIVIL				
DWG TITLE				
SITE SECTIONS - SHEET 2				
-				
DWG NO.				
S-264-EUR-EXT-ZZ-DR-CS-6302				
STATUS CODE				
C4				
PROJECT NO.		DATE		
S-264		21/08/23		
DRAWN / CHECKED		SCALE NO.		
DG -		(@A1) 1:100		

REVISION NUMBER

**P01**


**EUROPLAN GROUP**  
Parkview House, Beechill Office Campus,  
Clonskeagh, Dublin 4, Eire.  
Tel: +353 1 2606578  
staprojectteam@euoplanservices.com

ALL DIMENSIONS TO BE CHECKED ON SITE. NO DIMENSIONS TO BE SCALED FROM THIS DRAWING. DRAWING IS TO BE READ IN CONJUNCTION WITH RELEVANT CONSULTANTS DRAWINGS.


A1

SITE KEY PLAN

LEGEND

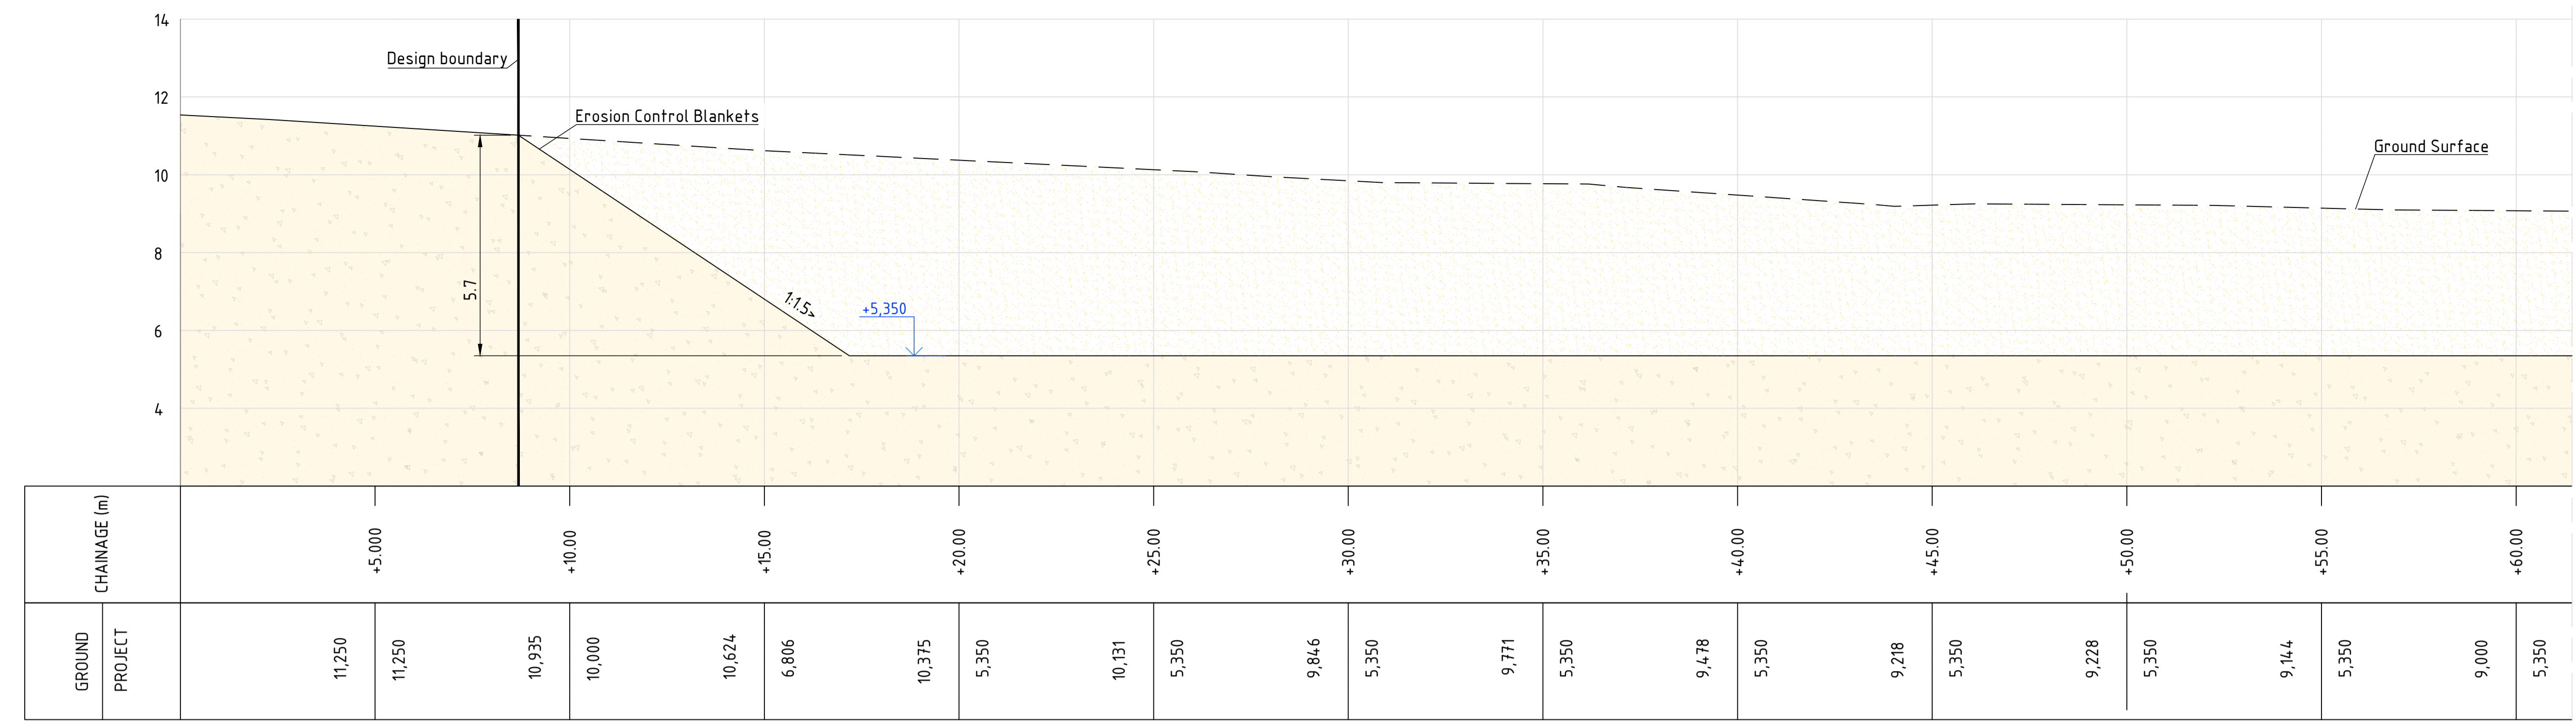

Section 4-4  
1:100

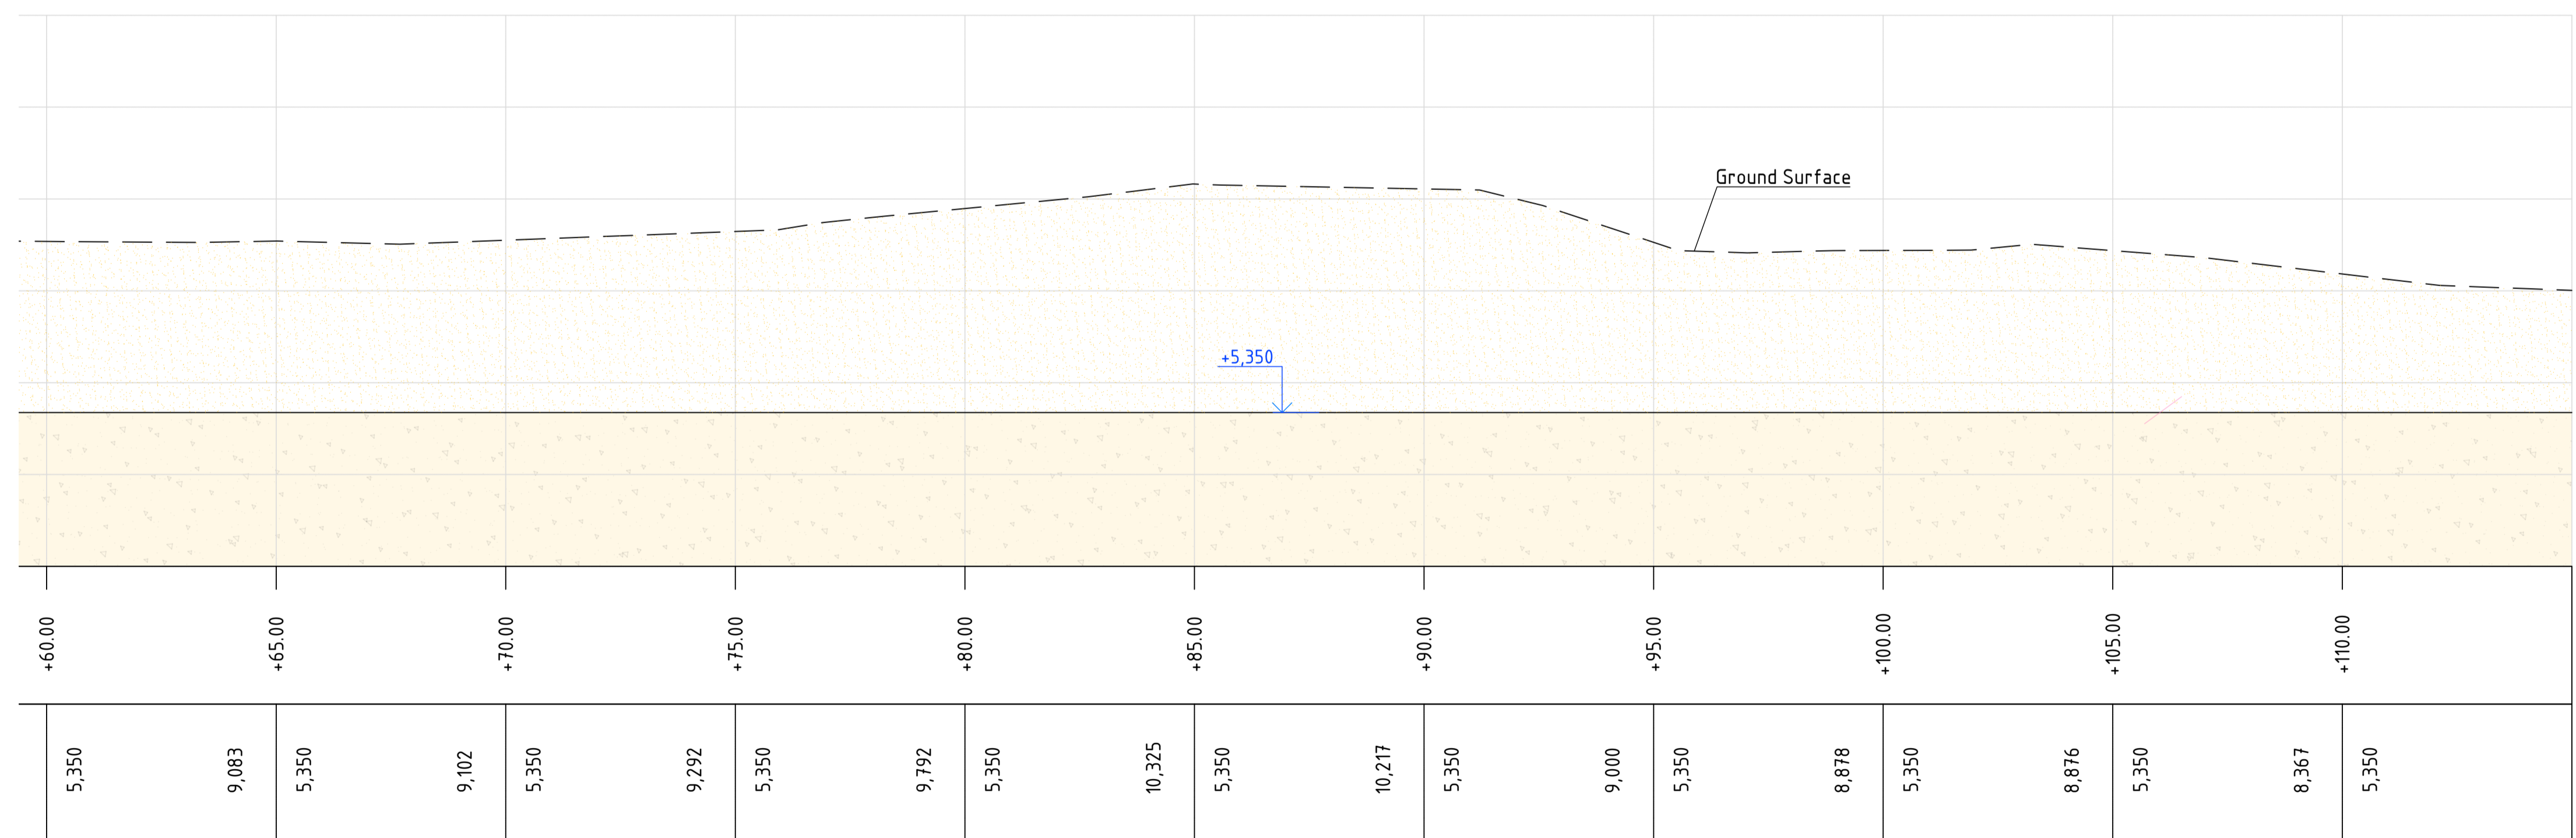

Section 4-4 (continuation)  
1:100

**SUMITOMO ELECTRIC** SEUK CL  
NIGG, TAIN IV19 1QU

**eda ARCHITECTS**  
EDA Architects Ltd  
Omagh Enterprise Centre,  
41 Gortrush Ind Est,  
Omagh BT78 5LJ  
eoghan@eda-architects.com

REVISIONS

NO.	DATE	DESCRIPTION	CHK	DRN

P01	21/08/23	ISSUED FOR PLANNING	DC	DG
REV	DATE	DESCRIPTION	CHK	DRN
STATUS				
PLANNING				
PROJECT				
SEIUK - CL				
PROJECT ADDRESS				
-				
DISCIPLINE				
CIVIL				
DWG TITLE				
SITE SECTIONS - SHEET 3				
-				
DWG NO.				
S-264-EUR-EXT-ZZ-DR-CS-6303				
STATUS CODE				
C4				
PROJECT NO.		DATE		
S-264		21/08/23		
DRAWN / CHECKED		SCALE NO.		
DG -		(@A1) 1:100		

REVISION NUMBER

**P01**


**EUROPLAN GROUP**  
Parkview House, Beechill Office Campus,  
Clonskeagh, Dublin 4, Eire.  
Tel: +353 1 2606578  
staprojectteam@euoplanservices.com

ALL DIMENSIONS TO BE CHECKED ON SITE. NO DIMENSIONS TO BE SCALED FROM THIS DRAWING. DRAWING IS TO BE READ IN CONJUNCTION WITH RELEVANT CONSULTANTS DRAWINGS.


A1

SITE KEY PLAN


LEGEND

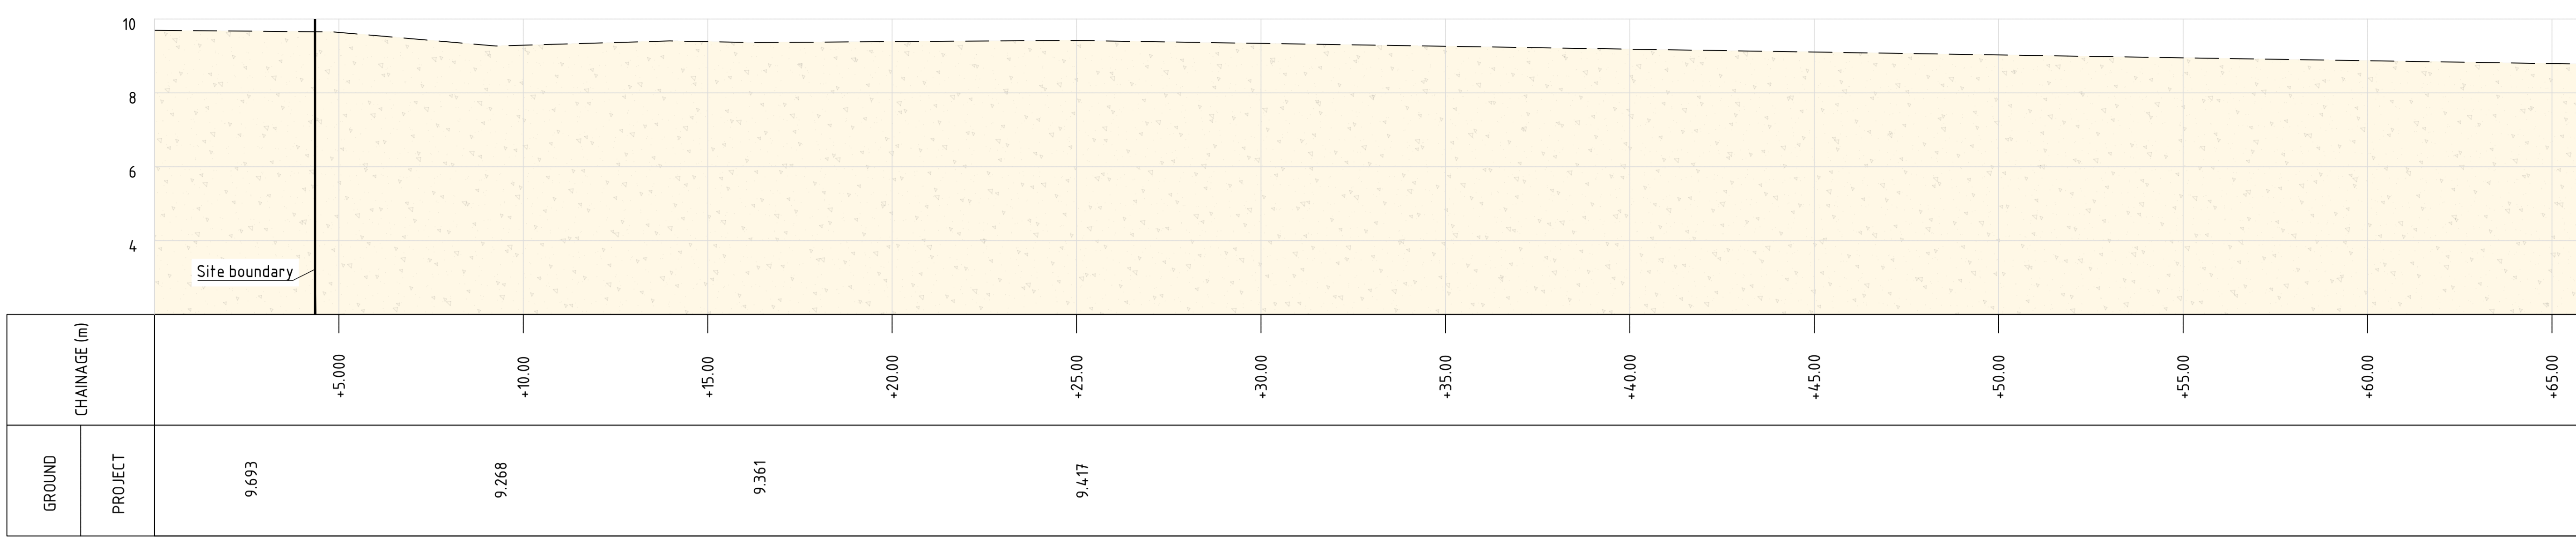

Section 5-5  
1:100

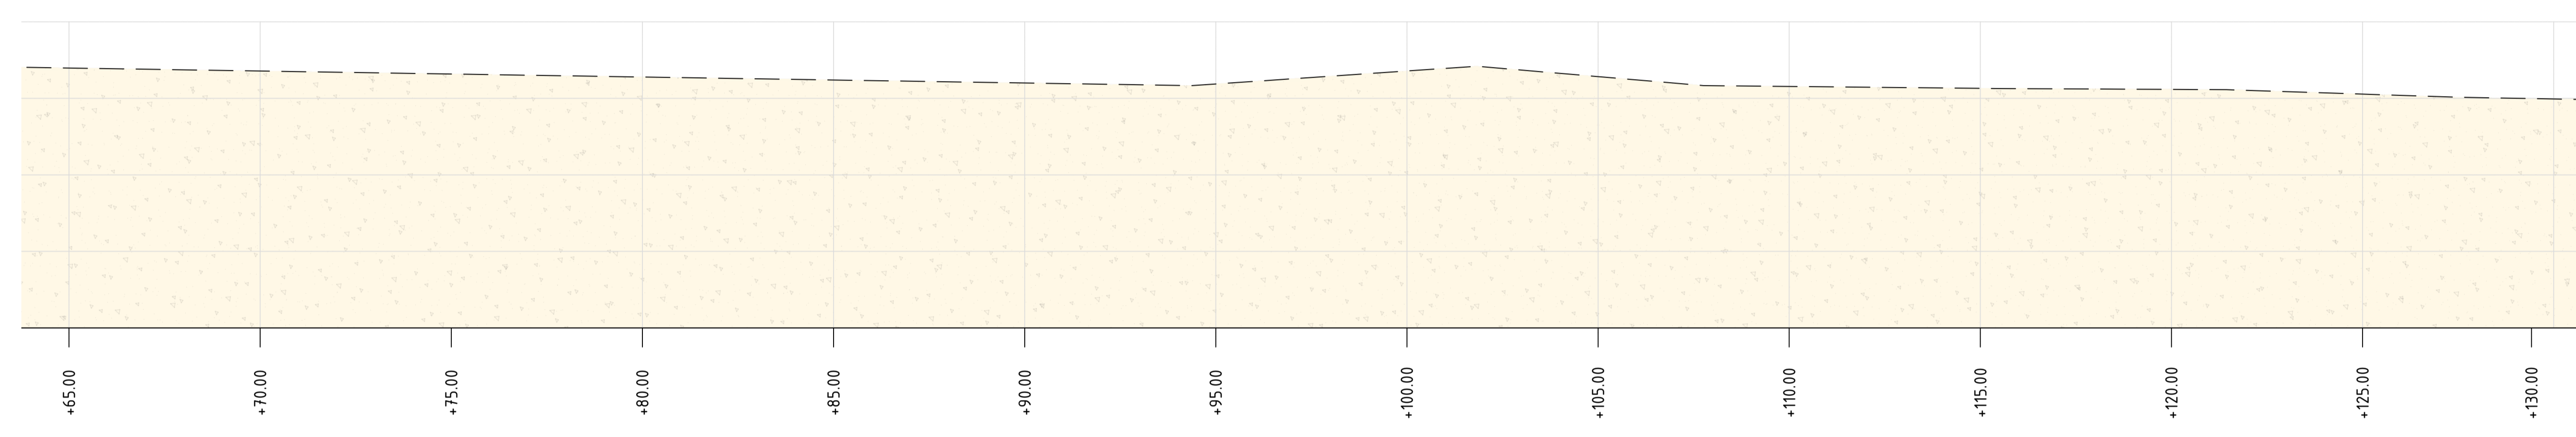

Section 5-5 (continuation)  
1:100

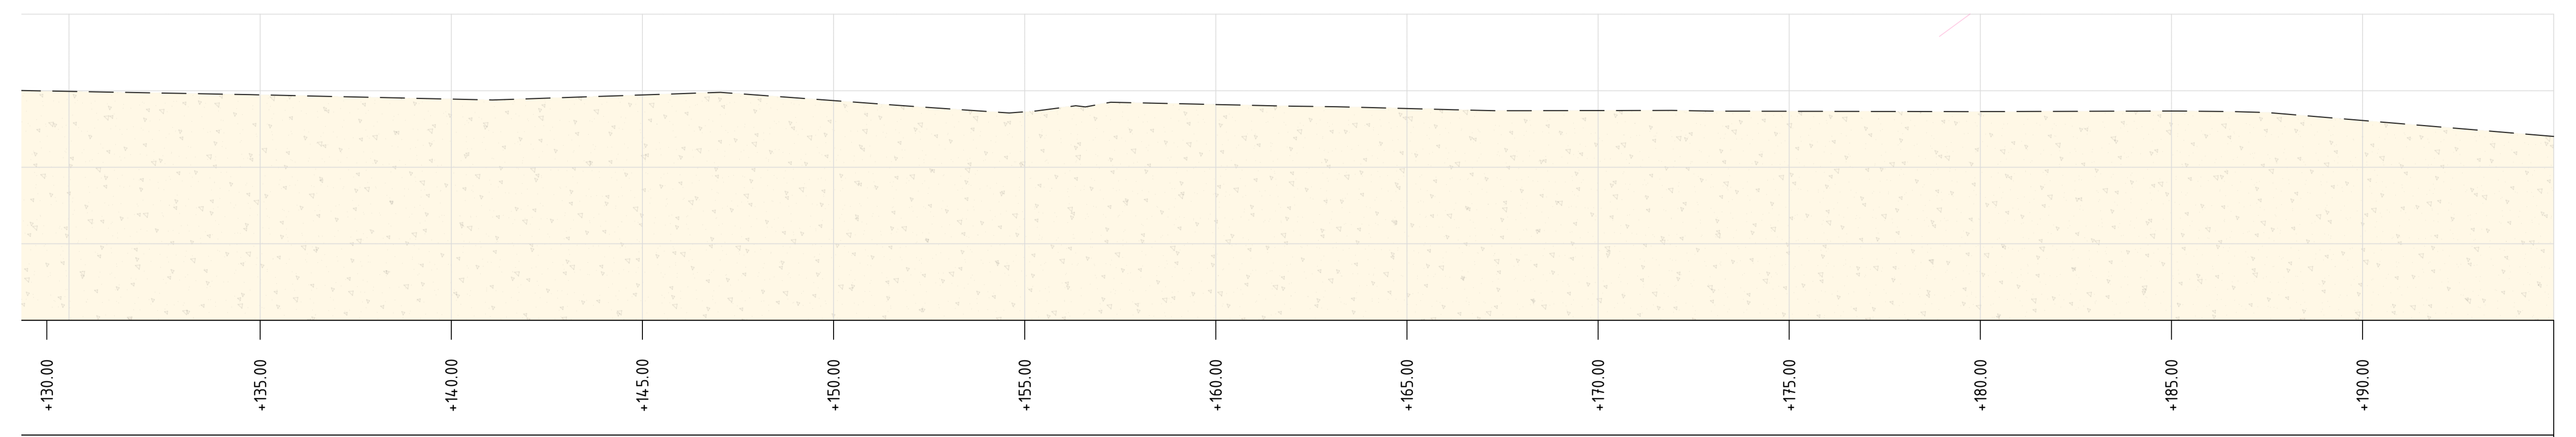

Section 5-5 (continuation)  
1:100

REVISIONS

REV. NO.	DATE	DESCRIPTION	CHK	DRN

P01 21/08/23 ISSUED FOR PLANNING DC DG

REV. DATE DESCRIPTION CHK DRN

STATUS PLANNING

PROJECT SEIUK - CL

PROJECT ADDRESS -

DISCIPLINE CIVIL

DWG TITLE SITE SECTIONS - SHEET 4

-

DWG NO. S-264-EUR-EXT-ZZ-DR-CS-6304

STATUS CODE C4

PROJECT NO. S-264 DATE 21/08/23

DRAWN / CHECKED DG - SCALE NO. (@A1) 1:100

REVISION NUMBER


P01




Parkview House, Beechill Office Campus,  
Clonskeagh, Dublin 4, Eire.  
Tel: +353 1 2606578  
staprojectteam@euoplanservices.com

SITE KEY PLAN

LEGEND

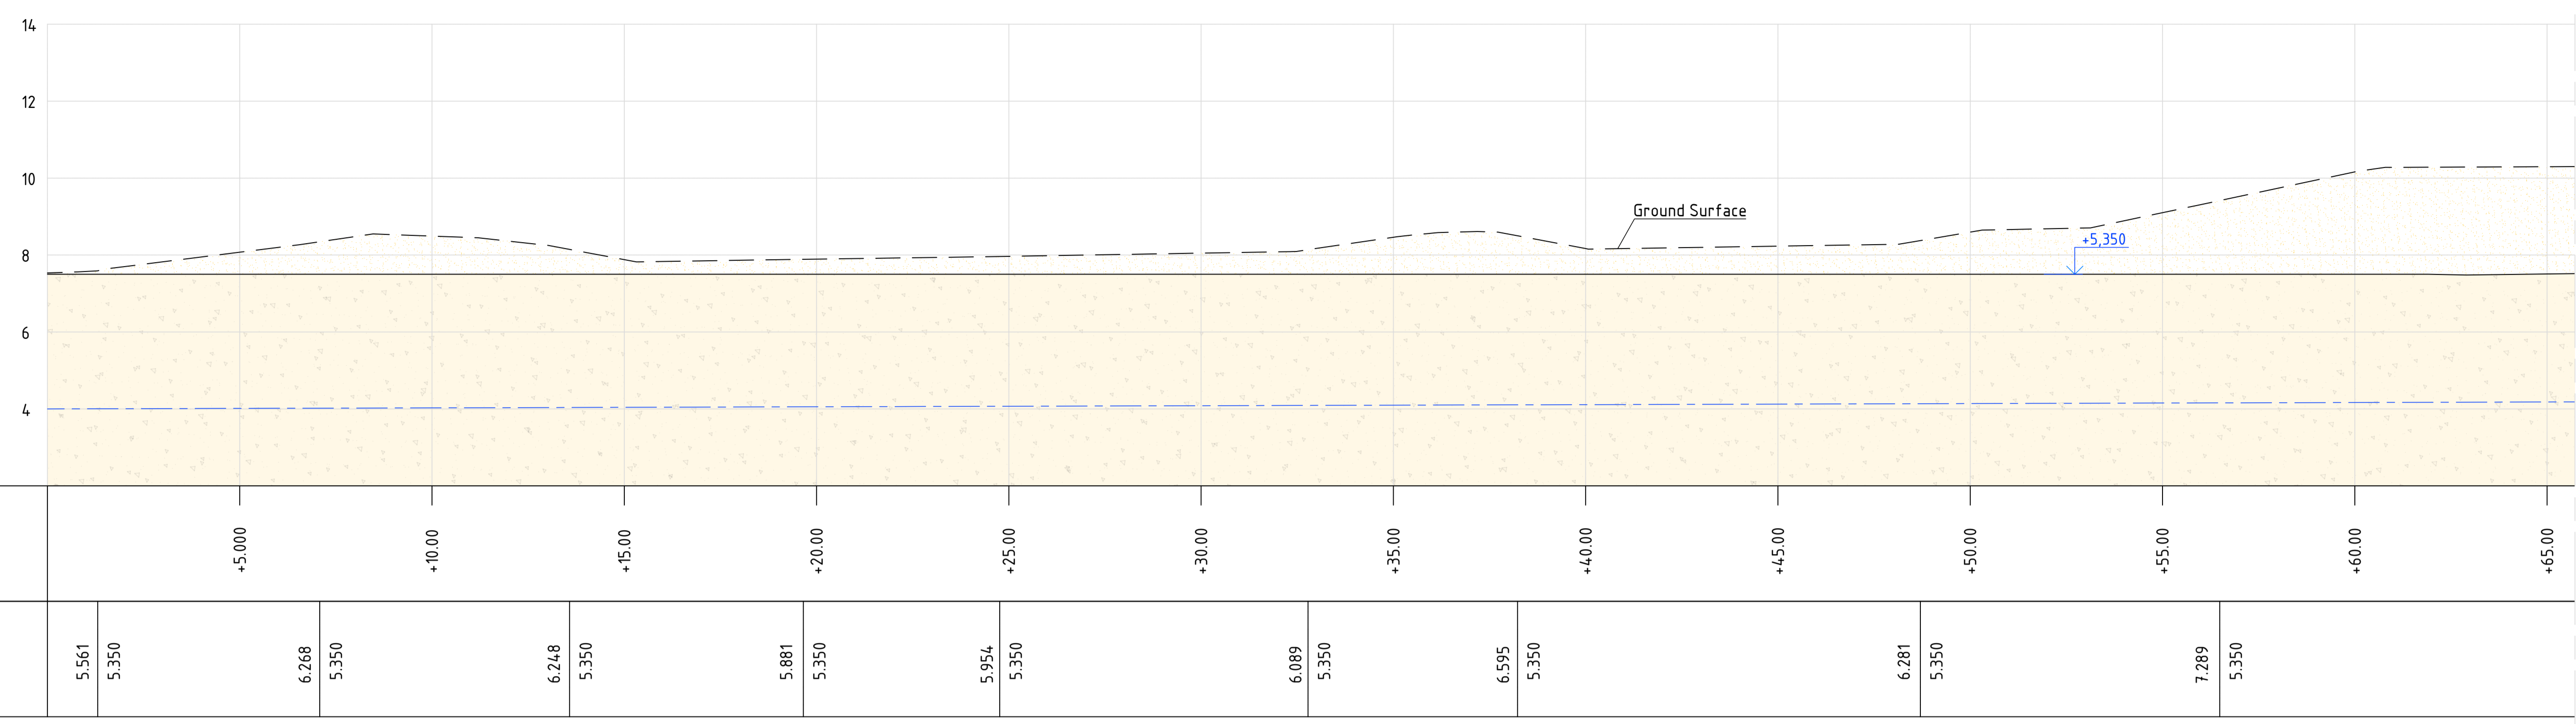

Section 6-6  
1:100

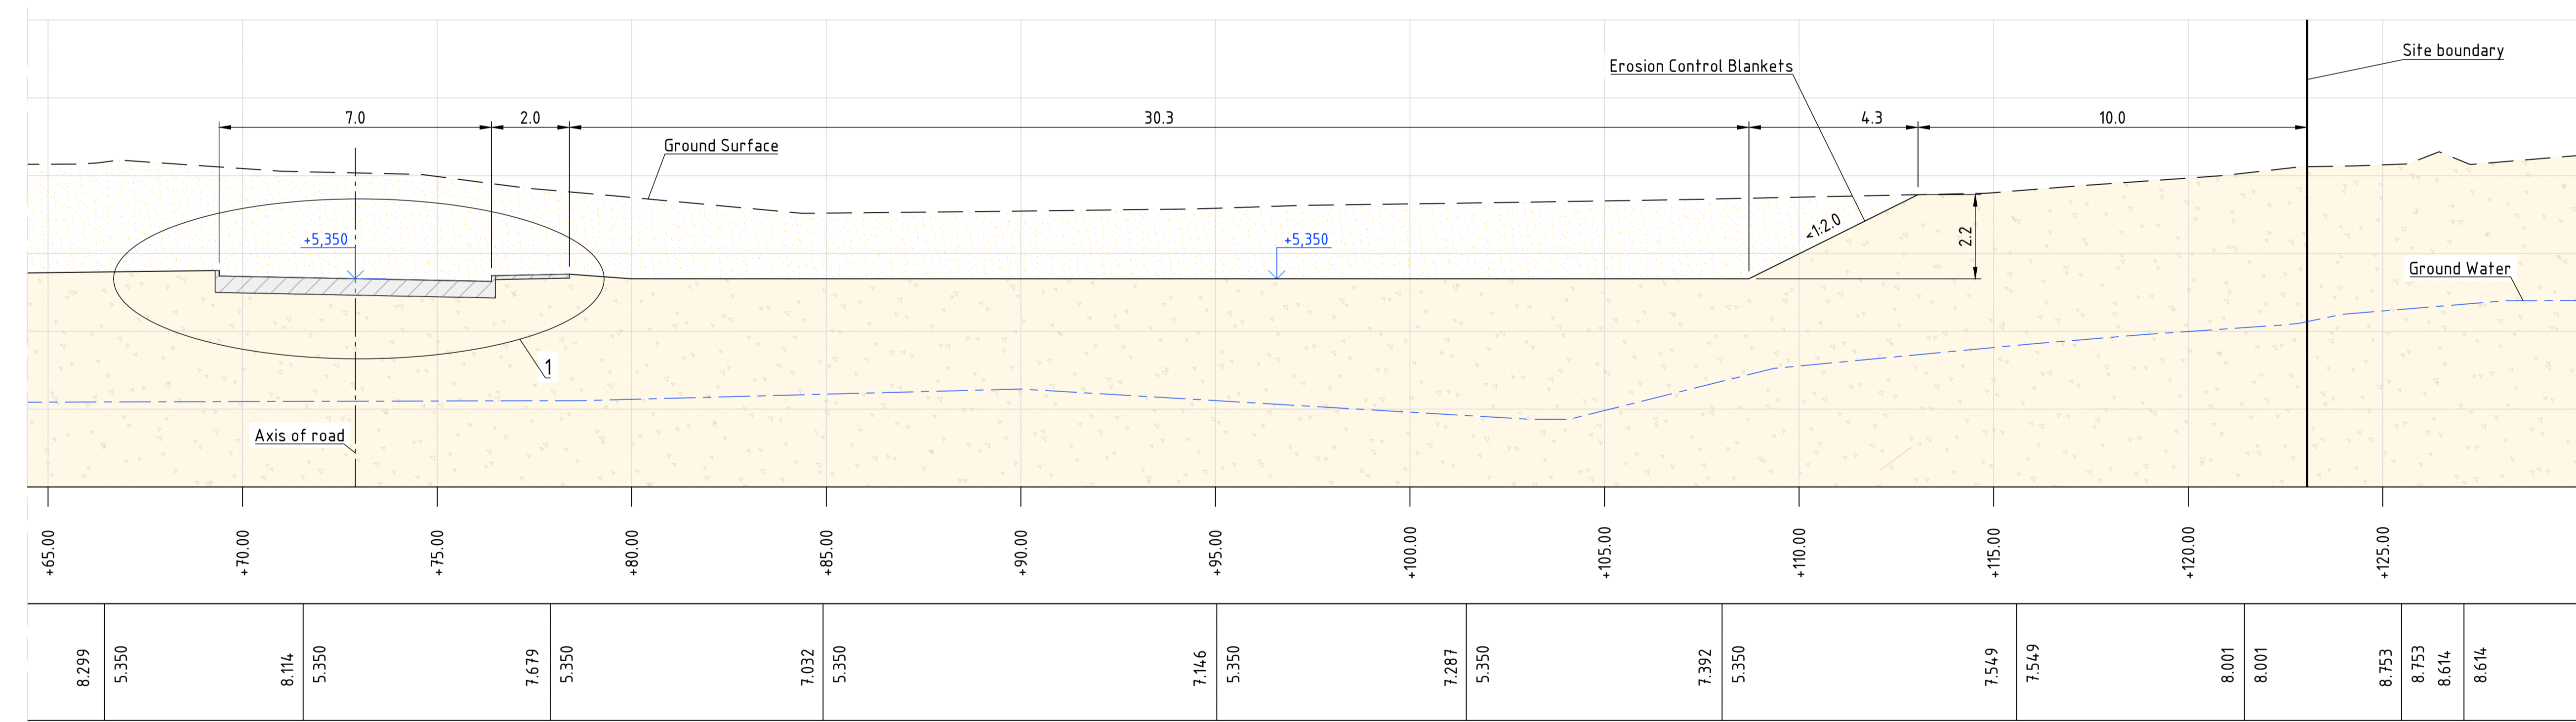

Section 6-6 (continuation)  
1:100

REVISIONS

NO.	DATE	DESCRIPTION	CHK	DRN

P01 21/08/23 ISSUED FOR PLANNING DC DG

REV DATE DESCRIPTION CKH DRN

STATUS PLANNING

PROJECT SEIUK - CL

PROJECT ADDRESS -

DISCIPLINE CIVIL

DWG TITLE SITE SECTIONS - SHEET 5

DWG NO. S-264-EUR-EXT-ZZ-DR-CS-6305

STATUS CODE C4

PROJECT NO. S-264 DATE 21/08/23

DRAWN / CHECKED DG - SCALE NO. (@A1) 1:100

REVISION NUMBER


**P01**

**EUROPLAN GROUP**

Parkview House, Beechill Office Campus, Clonskeagh, Dublin 4, Eire. Tel: +353 1 2606578 [staprojectteam@euoplanservices.com](mailto:staprojectteam@euoplanservices.com)


SITE KEY PLAN

LEGEND

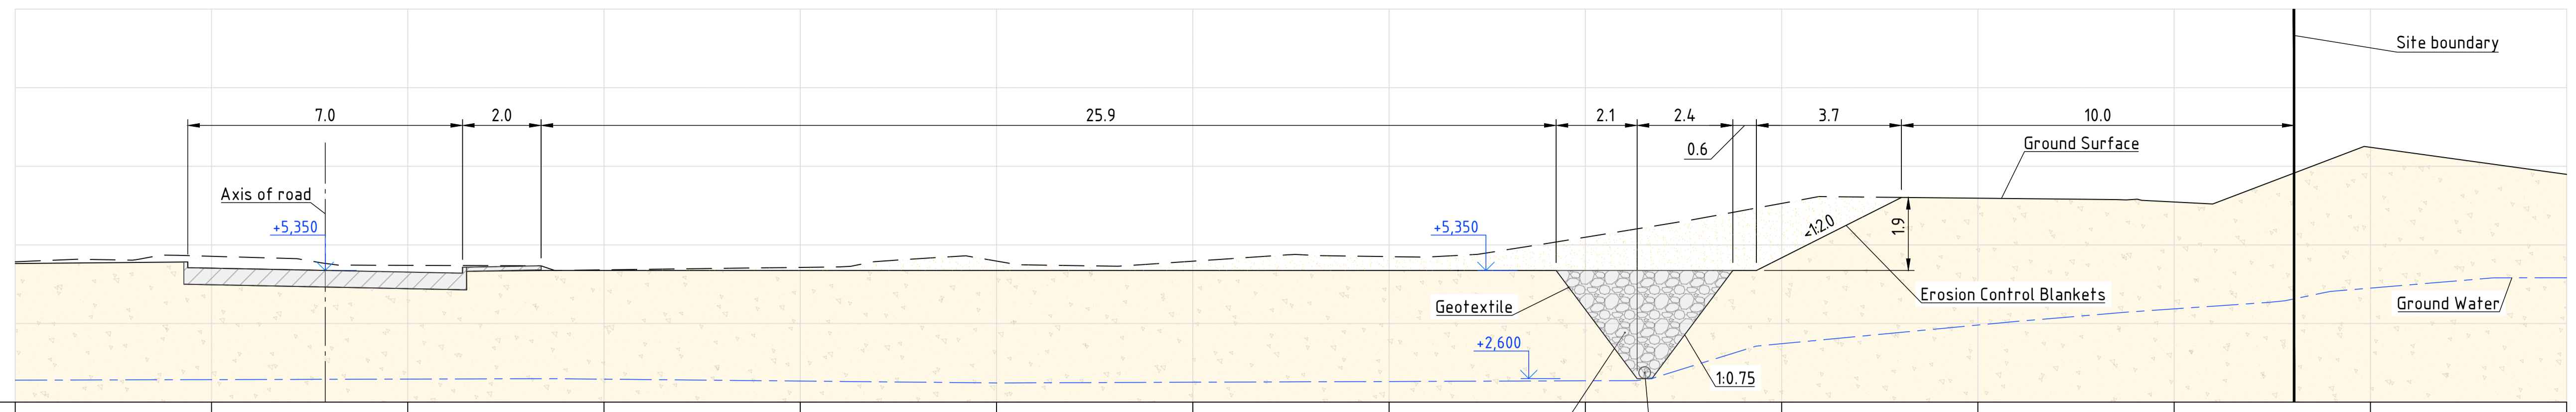

CHAINAGE (m)	GROUND PROJECT
+5.000	5.635
+10.000	5.350
+15.000	5.649
+20.000	5.350
+25.000	5.440
+30.000	5.350
+35.000	5.457
+40.000	6.052
+45.000	7.229
+50.000	7.153
+55.000	7.153
+60.000	8.505

Section 7-7  
1:100

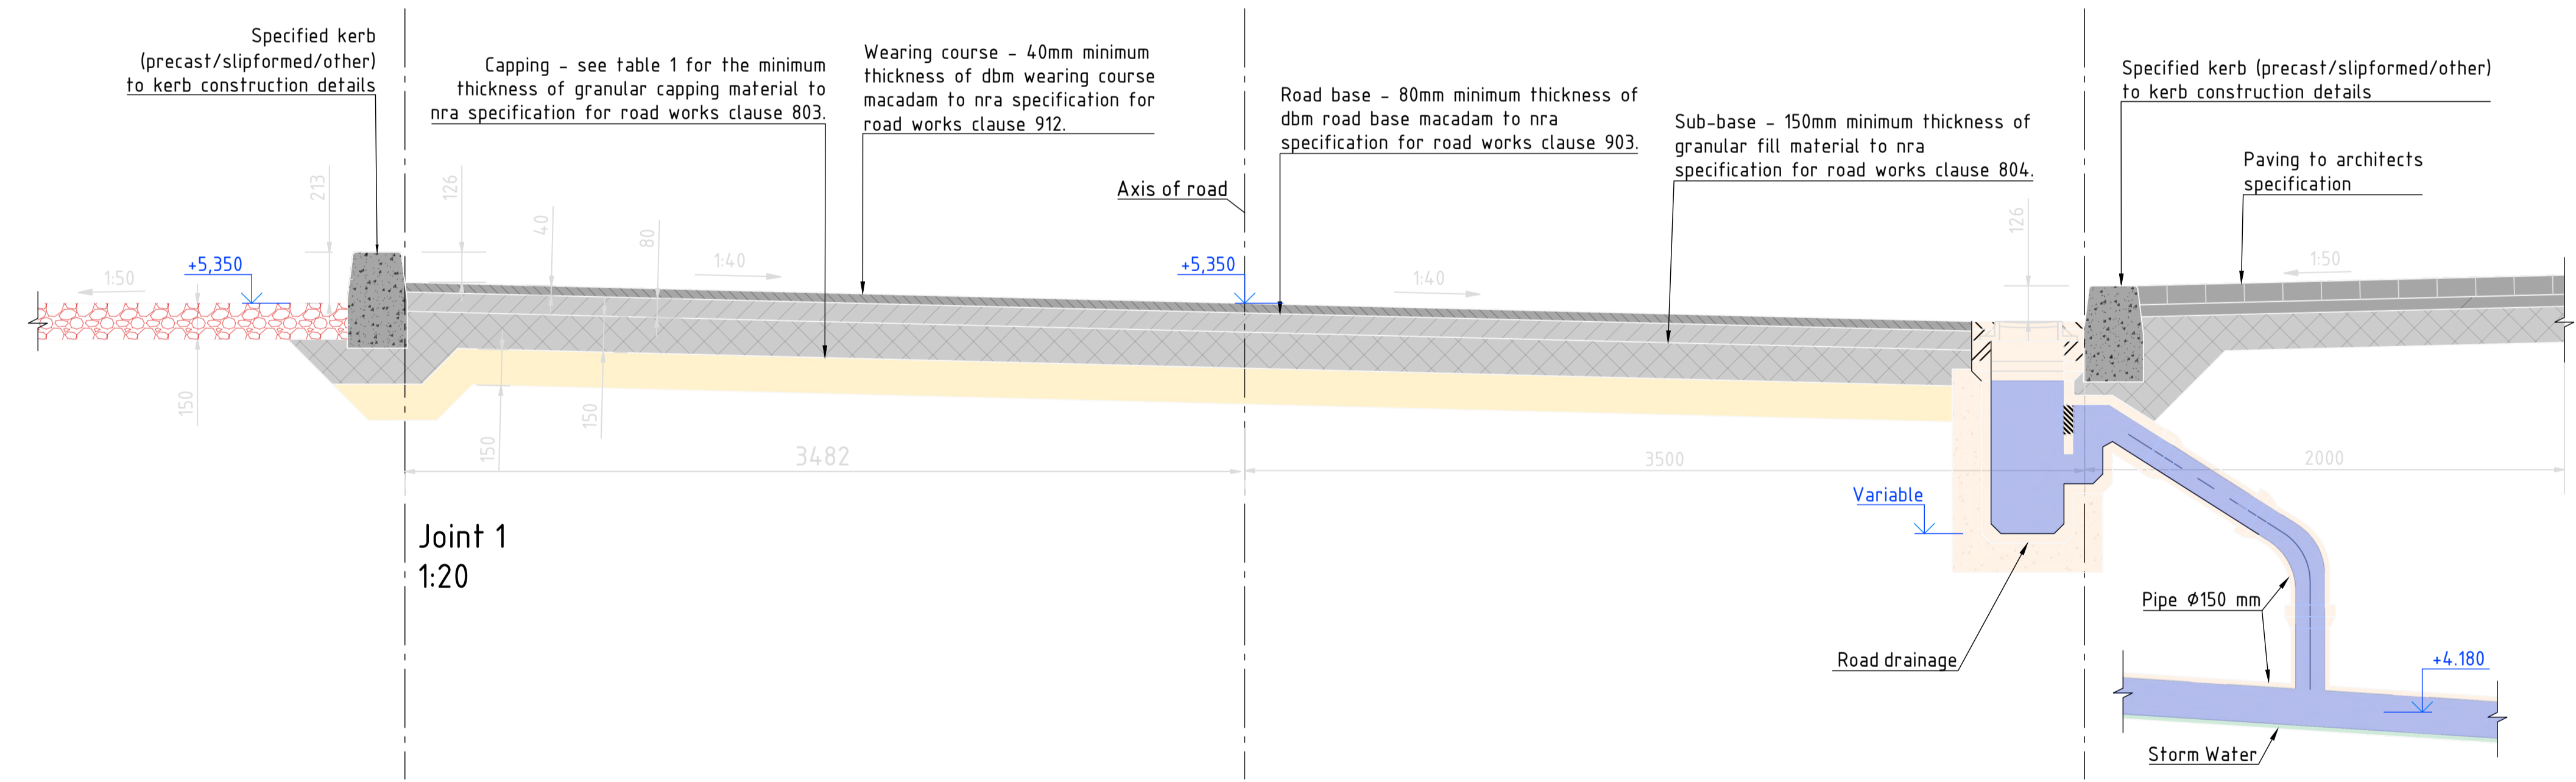

Joint 1  
1:20

REVISIONS

REV	DATE	DESCRIPTION	CHK	DRN

P01 21/08/23 ISSUED FOR PLANNING DC DG

REV DATE DESCRIPTION CHK DRN

STATUS PLANNING

PROJECT SEIUK - CL

PROJECT ADDRESS -

DISCIPLINE CIVIL

DWG TITLE SITE SECTIONS - SHEET 6

-

DWG NO. S-264-EUR-EXT-ZZ-DR-CS-6306

STATUS CODE C4

PROJECT NO. S-264

DATE 21/08/23

DRAWN / CHECKED DG -

SCALE NO. (@A1) 1:100

REVISION NUMBER

**P01**

**EUROPLAN GROUP**

Parkview House, Beechill Office Campus, Clonskeagh, Dublin 4, Eire. Tel: +353 1 2606578. [staprojectteam@europlanservices.com](mailto:staprojectteam@europlanservices.com)






ALL DIMENSIONS TO BE CHECKED ON SITE. NO DIMENSIONS TO BE SCALED FROM THIS DRAWING. DRAWING IS TO BE READ IN CONJUNCTION WITH RELEVANT CONSULTANTS DRAWINGS.

A1

SITE KEY PLAN

LEGEND

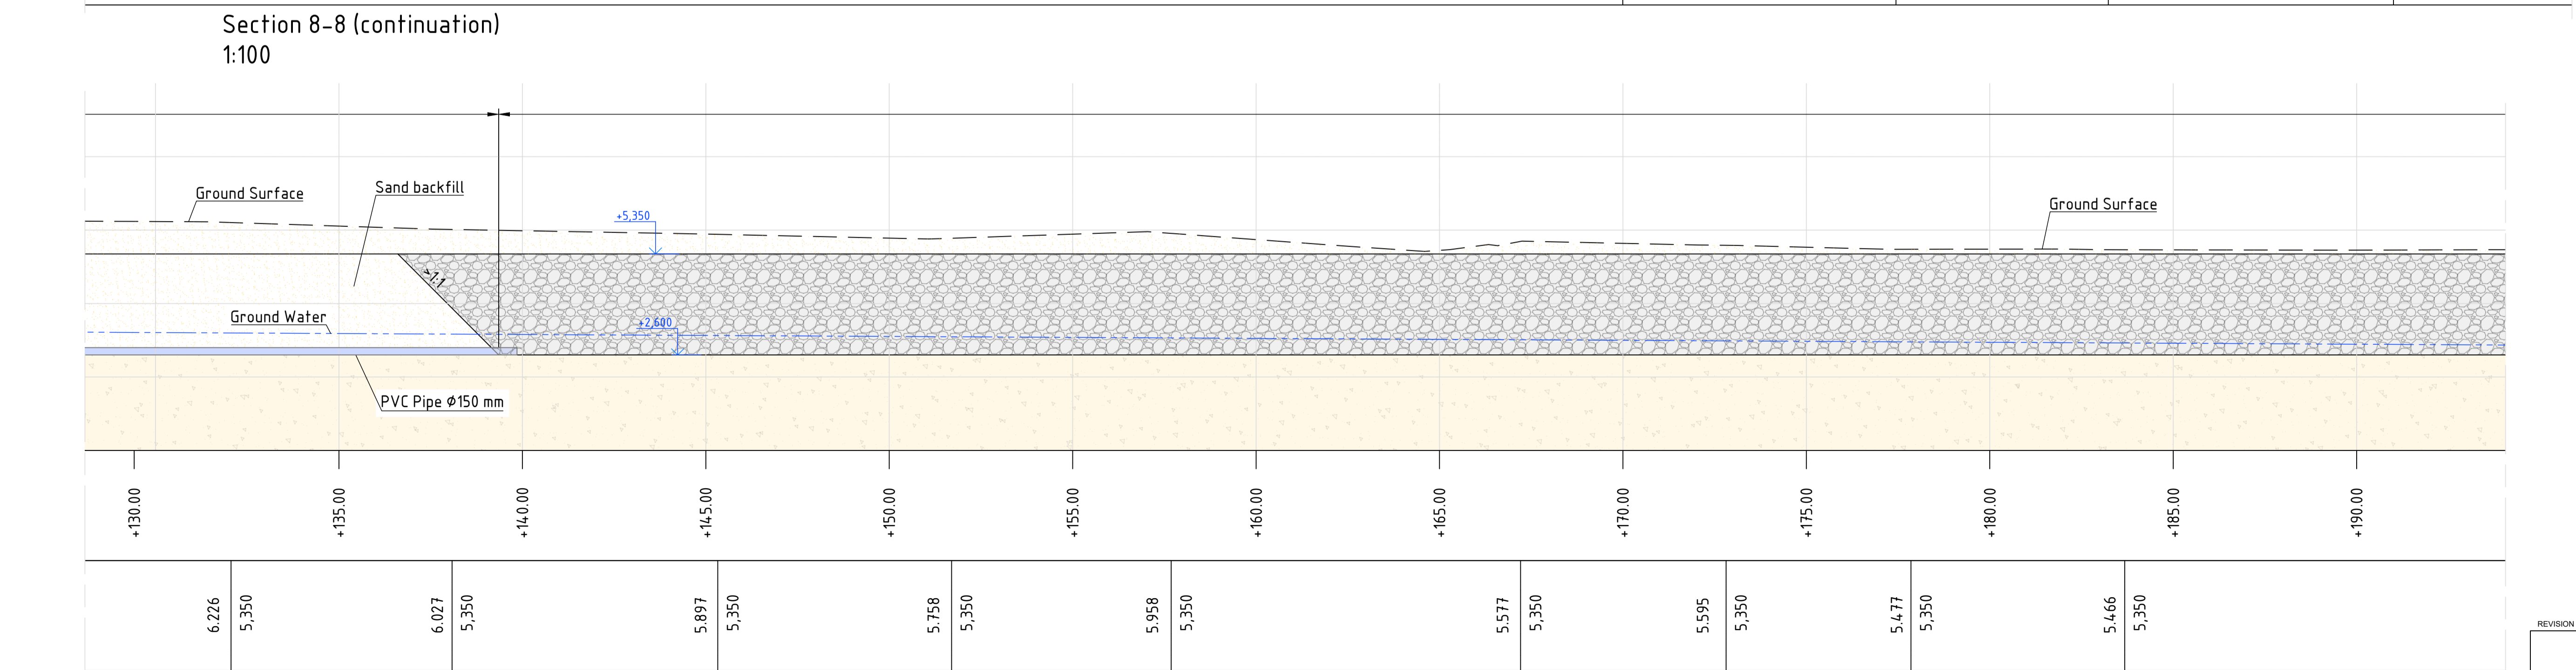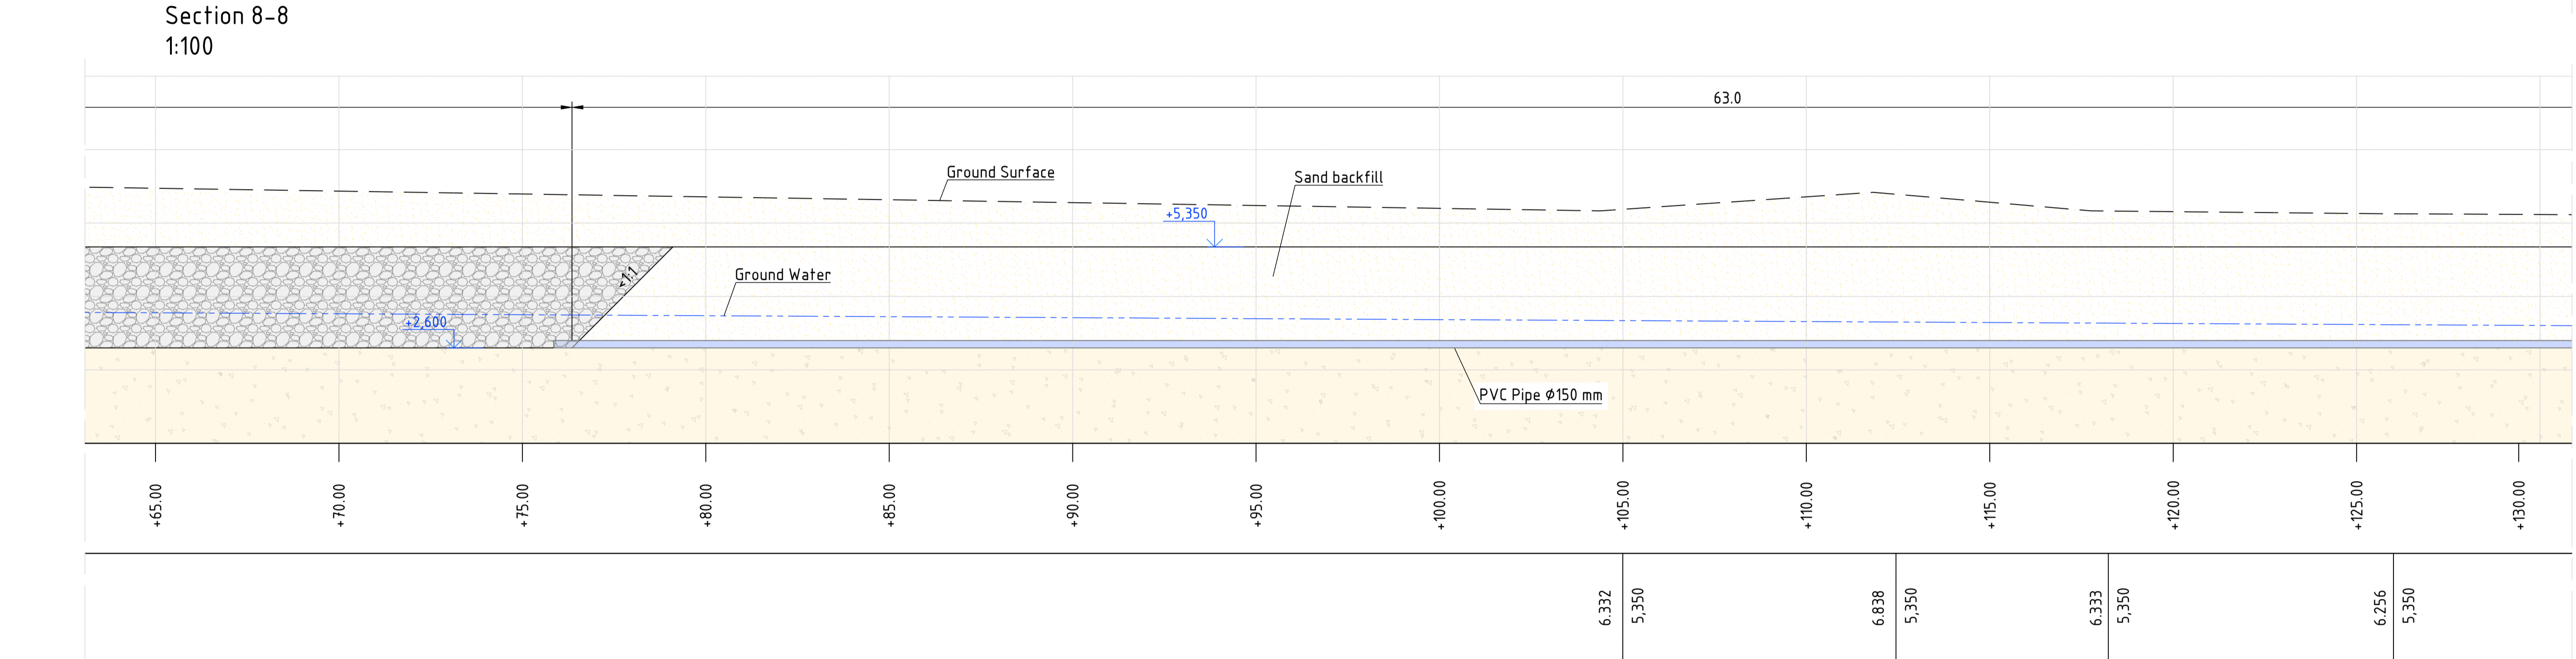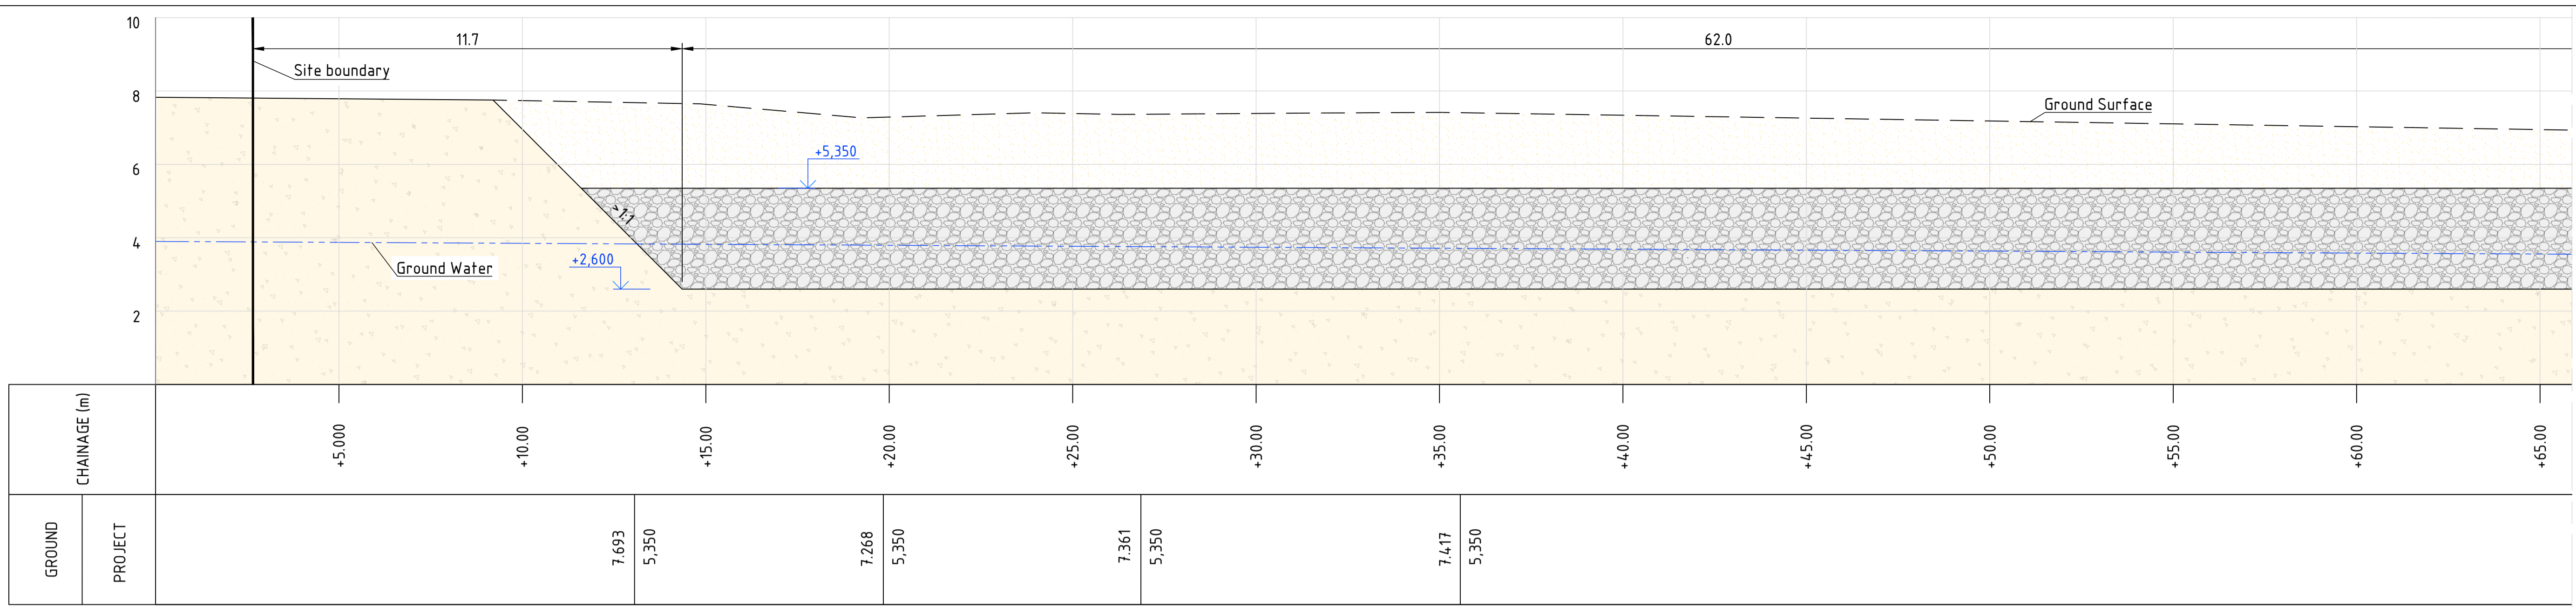

REVISIONS

REV	DATE	DESCRIPTION	CHK	DRN
P01	21/08/23	ISSUED FOR PLANNING	DC	DG

STATUS  
PLANNING

PROJECT  
SEIUK - CL

PROJECT ADDRESS  
-

DISCIPLINE  
CIVIL

DWG TITLE  
SITE SECTIONS - SHEET 7

DWG NO.  
S-264-EUR-EXT-ZZ-DR-CS-6307

STATUS CODE  
C4

PROJECT NO.  
S-264

DATE  
21/08/23

DRAWN / CHECKED  
DG -

SCALE NO.  
(@A1) 1:100

REVISION NUMBER

P01




Parkview House, Beechill Office Campus,  
Clonskeagh, Dublin 4, Eire.  
Tel: +353 1 2606578  
staprojectteam@euoplanservices.com




ALL DIMENSIONS TO BE CHECKED ON SITE. NO DIMENSIONS TO BE SCALED FROM THIS DRAWING. DRAWING IS TO BE READ IN CONJUNCTION WITH RELEVANT CONSULTANTS DRAWINGS.

SITE KEY PLAN


LEGEND

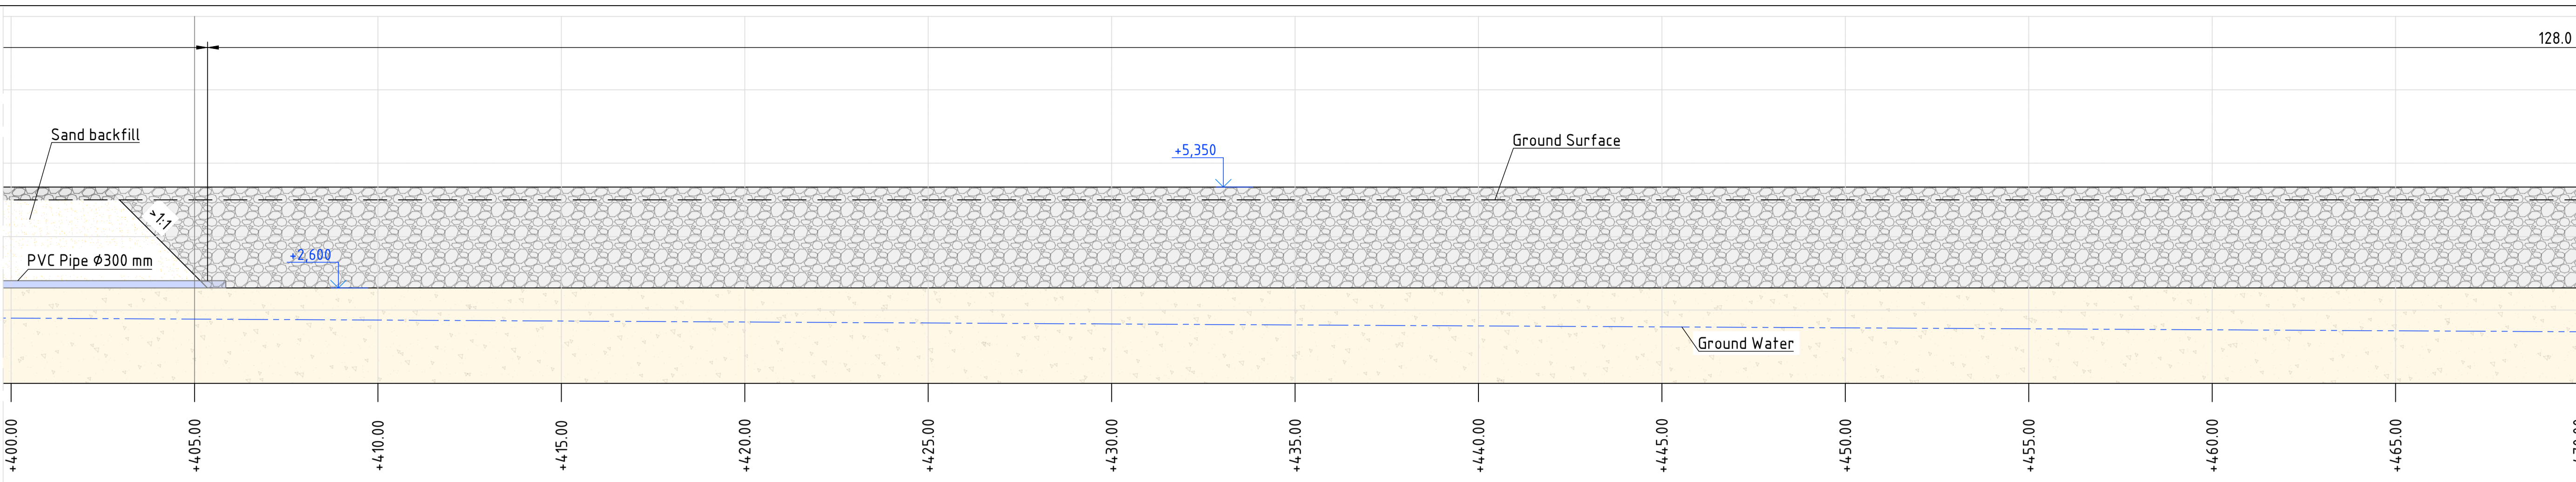

Section 8-8 (continuation)  
1:100

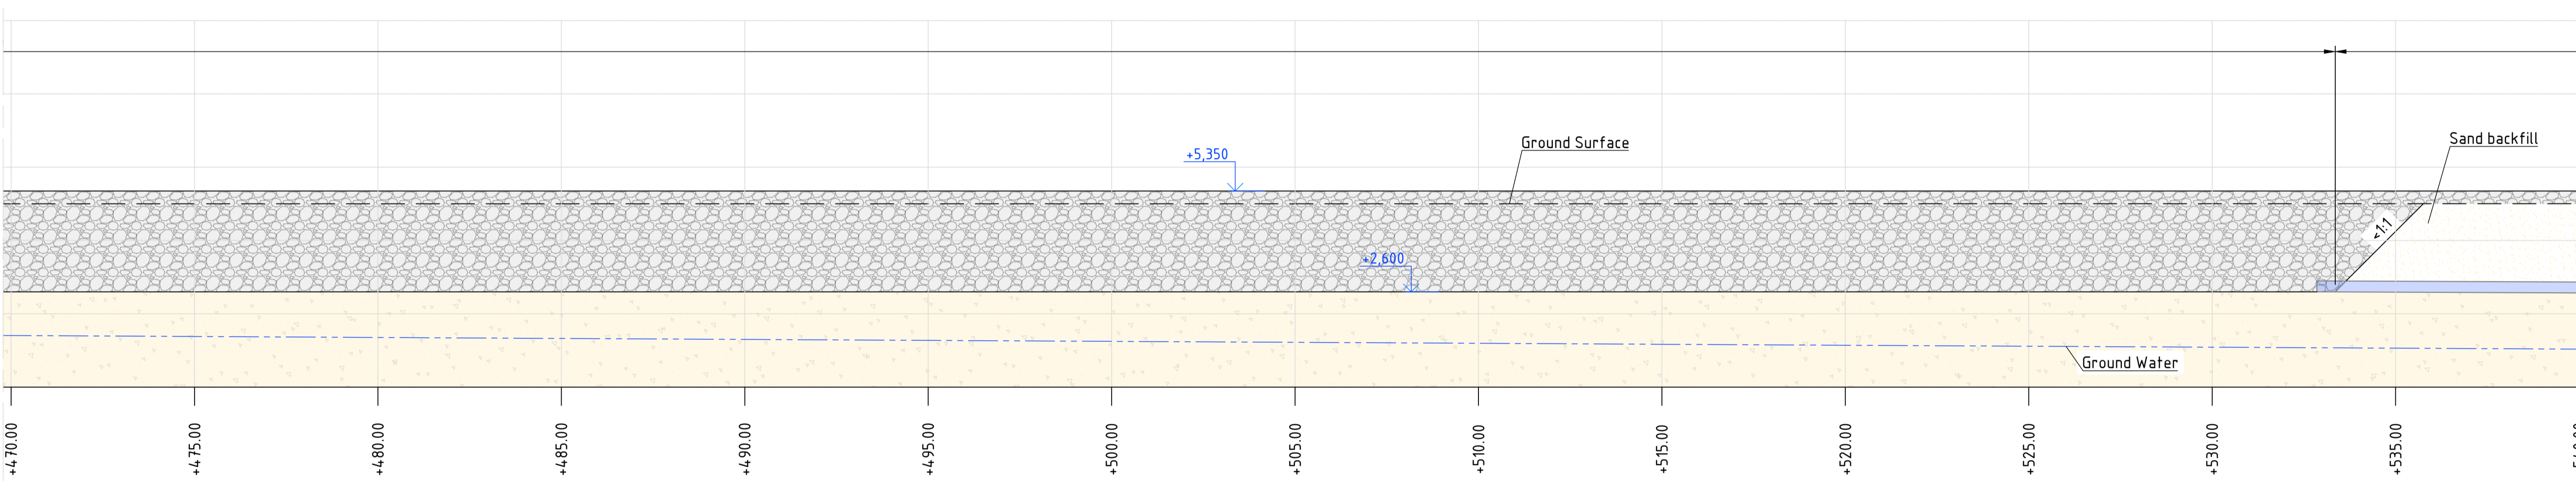

Section 8-8 (continuation)  
1:100

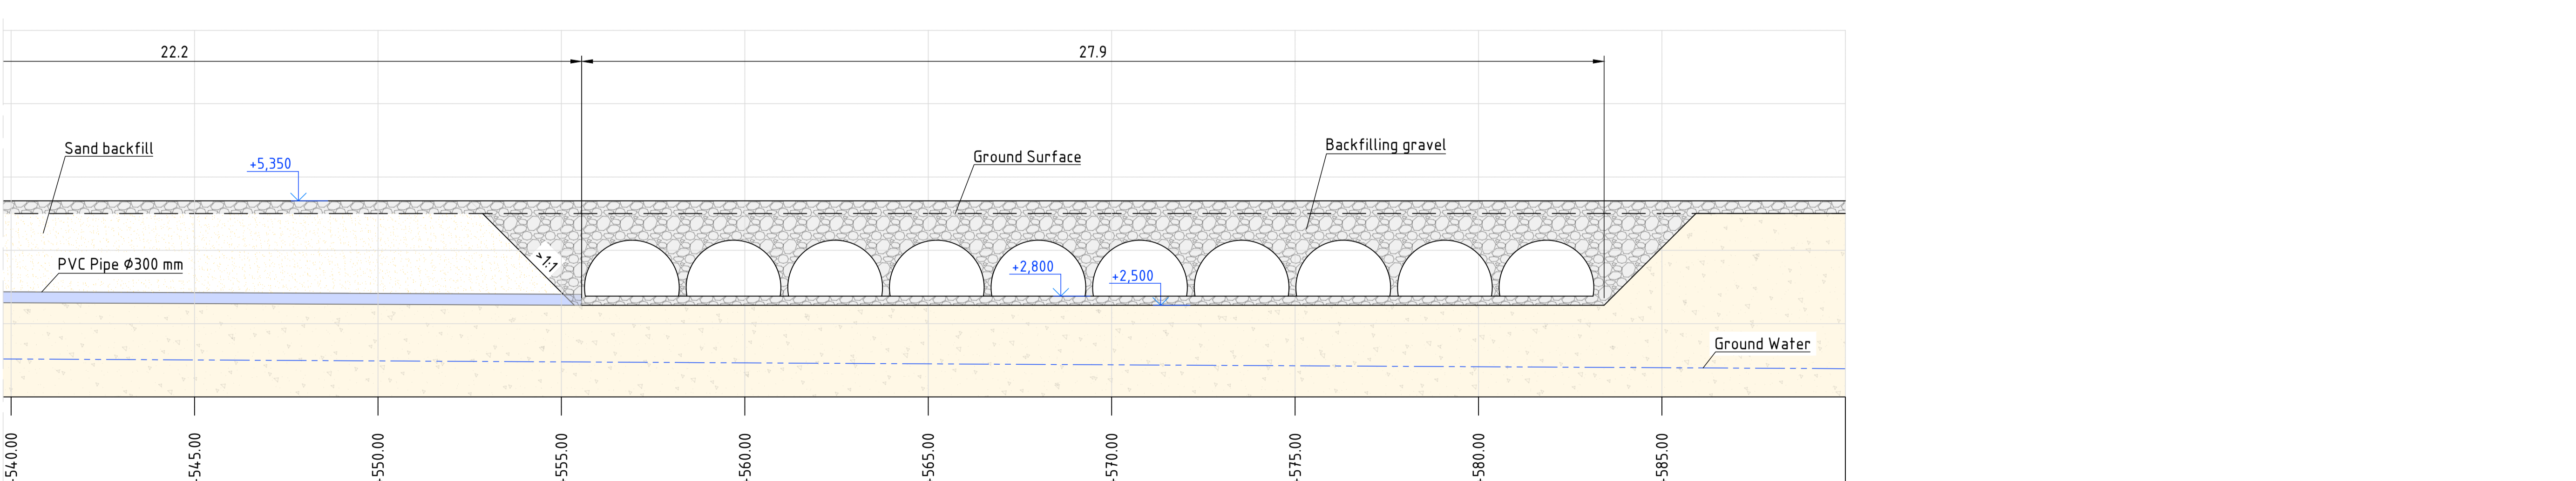

Section 8-8 (continuation)  
1:100

REVISIONS

REV. NO.	DATE	DESCRIPTION	CHK	DRN

P01 21/08/23 ISSUED FOR PLANNING DC DG

REV. DATE DESCRIPTION CHK DRN

STATUS

PLANNING

PROJECT SEIUK - CL

PROJECT ADDRESS -

DISCIPLINE CIVIL

DWG TITLE

SITE SECTIONS - SHEET 9

-

DWG NO.

S-264-EUR-EXT-ZZ-DR-CS-6309

STATUS CODE

C4

PROJECT NO.

S-264

DATE

21/08/23

DRAWN / CHECKED

DG -

SCALE NO.


((@A1) 1:100

REVISION NUMBER


P01



Parkview House, Beechill Office Campus,  
Clonskeagh, Dublin 4, Eire.  
Tel: +353 1 2606578  
staprojectteam@euoplanservices.com

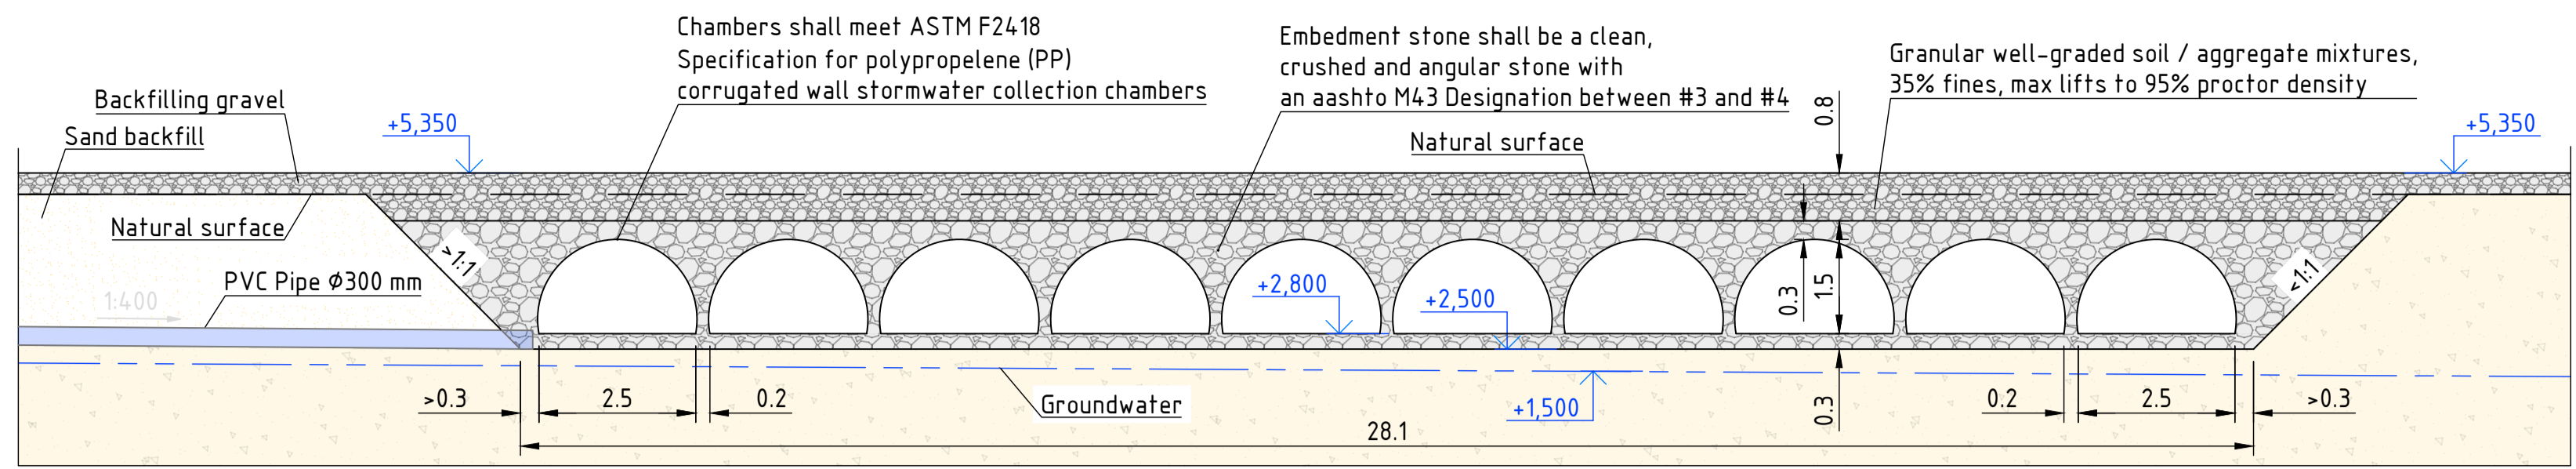

Section 9-9  
1:100

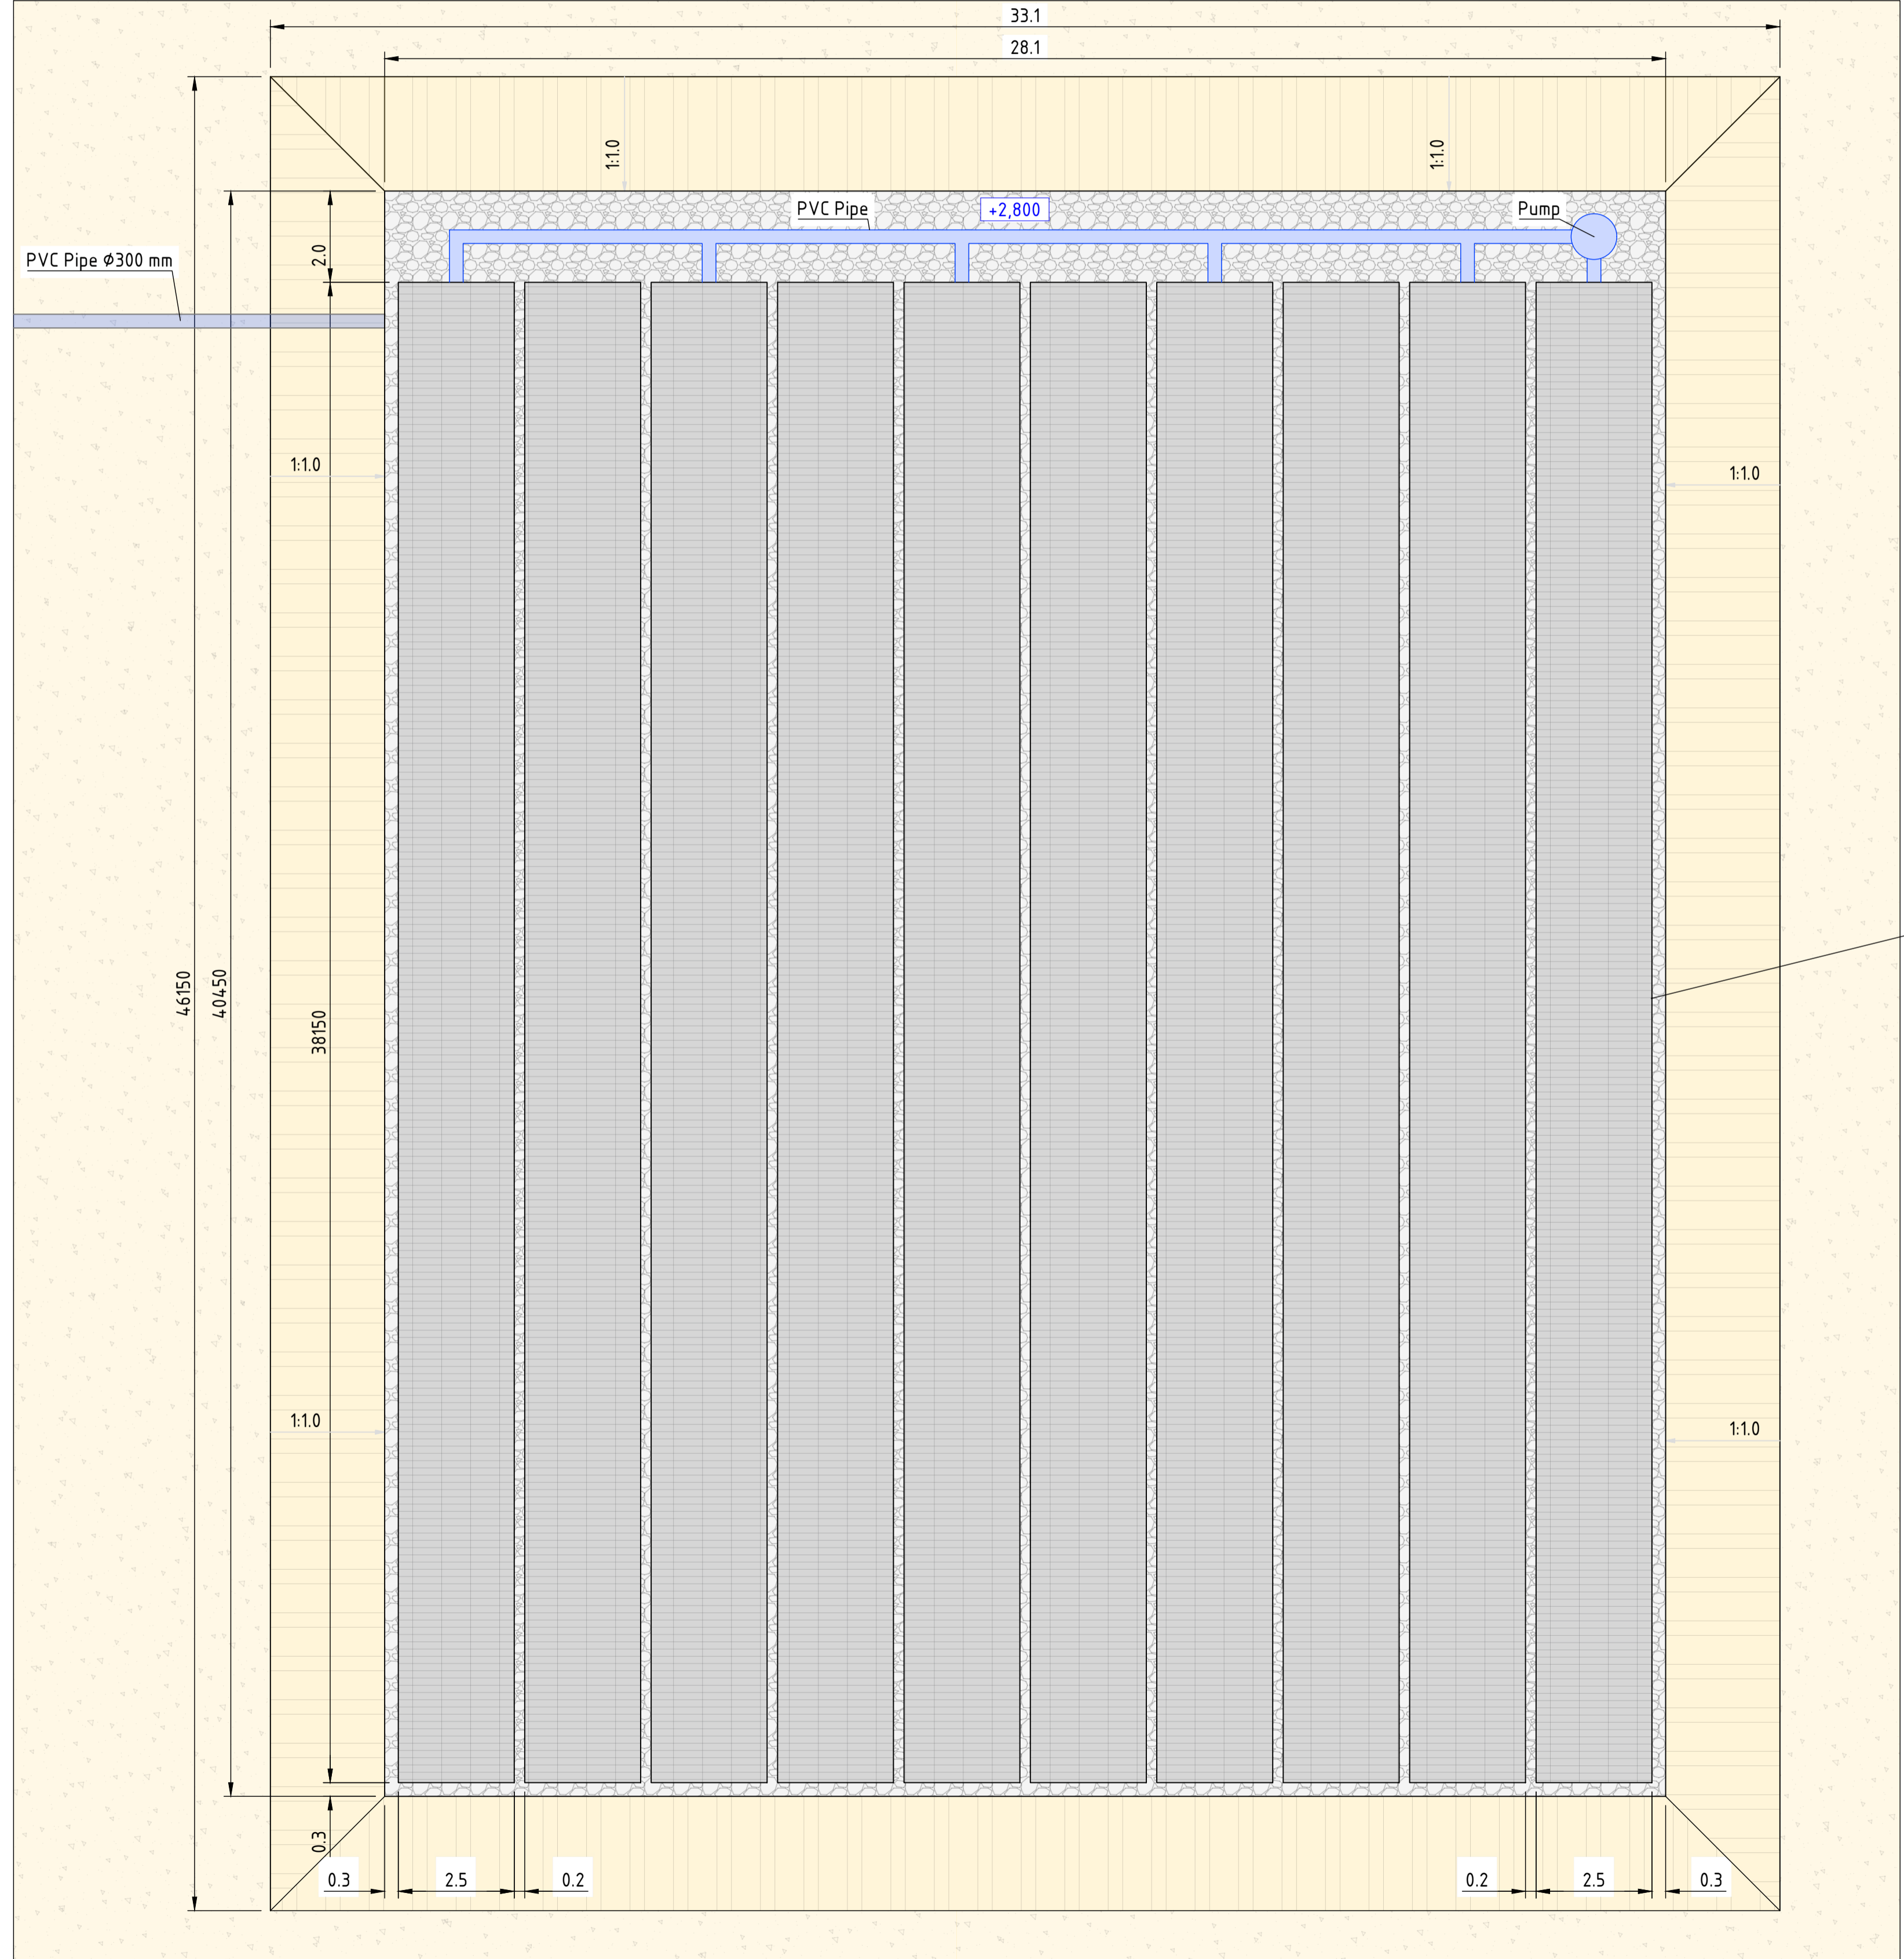

Plan (Shown without backfill)  
1:100

SITE KEY PLAN

LEGEND

REVISIONS

REV	DATE	DESCRIPTION	CHK	DRN

P01 21/08/23 ISSUED FOR PLANNING DC DG

REV DATE DESCRIPTION CHK DRN

STATUS

PLANNING

PROJECT

SEIUK - CL

PROJECT ADDRESS

-

DISCIPLINE

CIVIL

DWG TITLE

SITE SECTIONS - SHEET 10

-

DWG NO.

S-264-EUR-EXT-ZZ-DR-CS-63010

STATUS CODE

C4

PROJECT NO.

S-264

DATE

21/08/23

DRAWN / CHECKED

DG -

SCALE NO.

((@A1) 1:100






REVISION NUMBER

**P01**

**EUROPLAN GROUP**

Parkview House, Beechill Office Campus,  
Clonskeagh, Dublin 4, Eire.  
Tel: +353 1 2606578  
staprojectteam@euoplanservices.com

ALL DIMENSIONS TO BE CHECKED ON SITE. NO DIMENSIONS TO BE SCALED FROM THIS DRAWING. DRAWING IS TO BE READ IN CONJUNCTION WITH RELEVANT CONSULTANTS DRAWINGS.

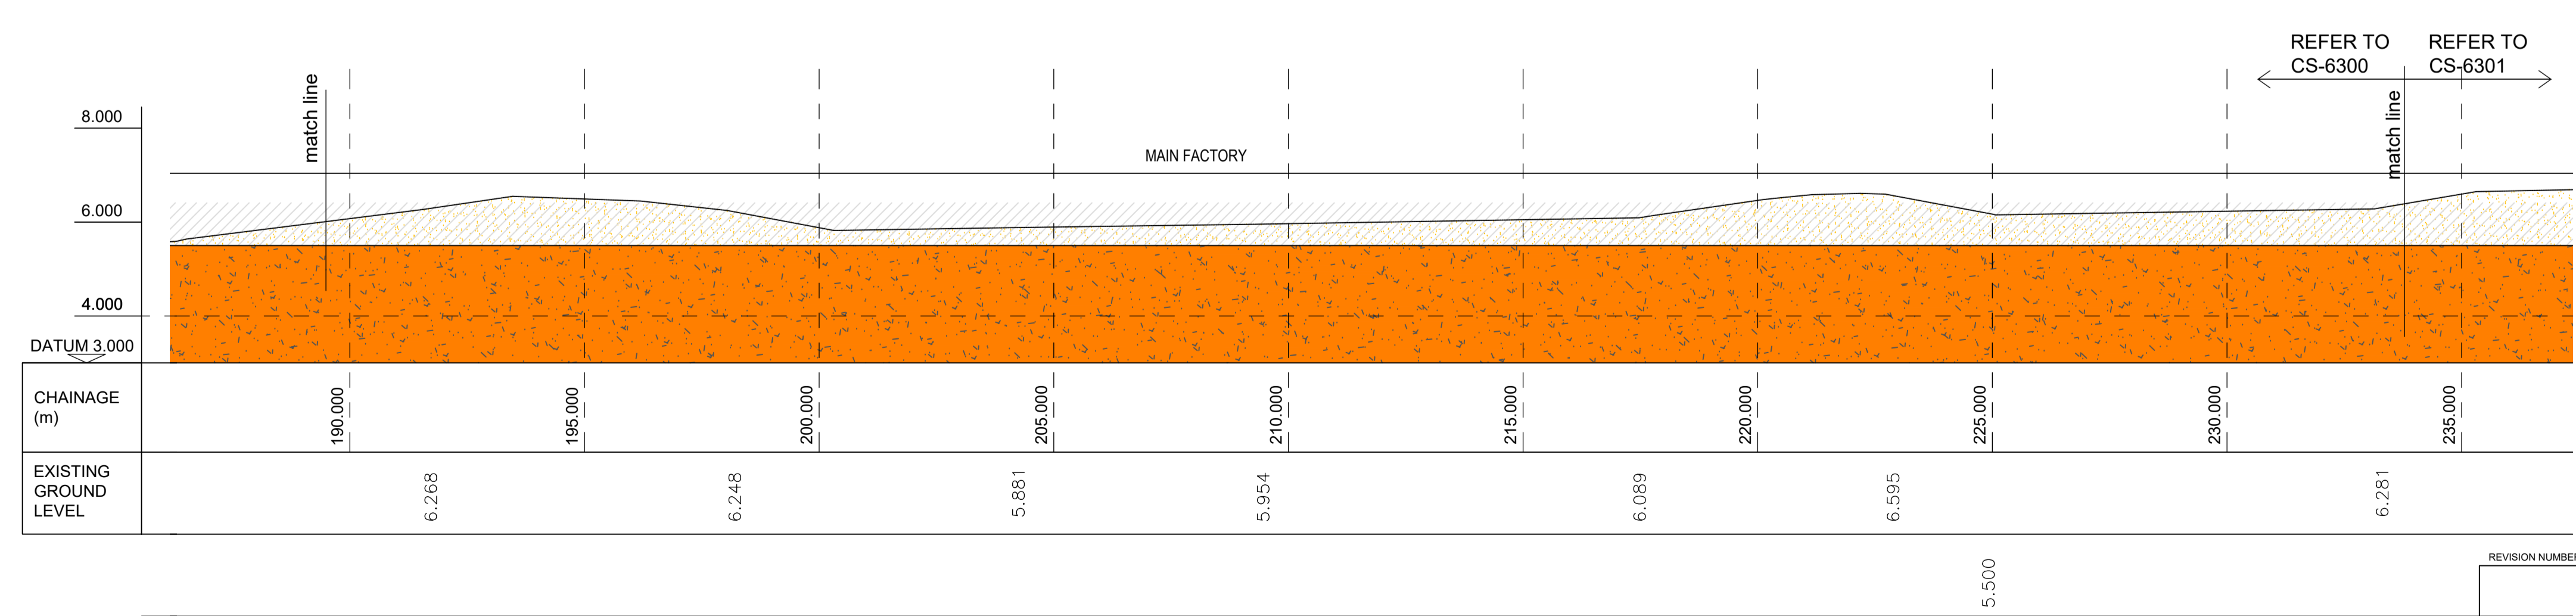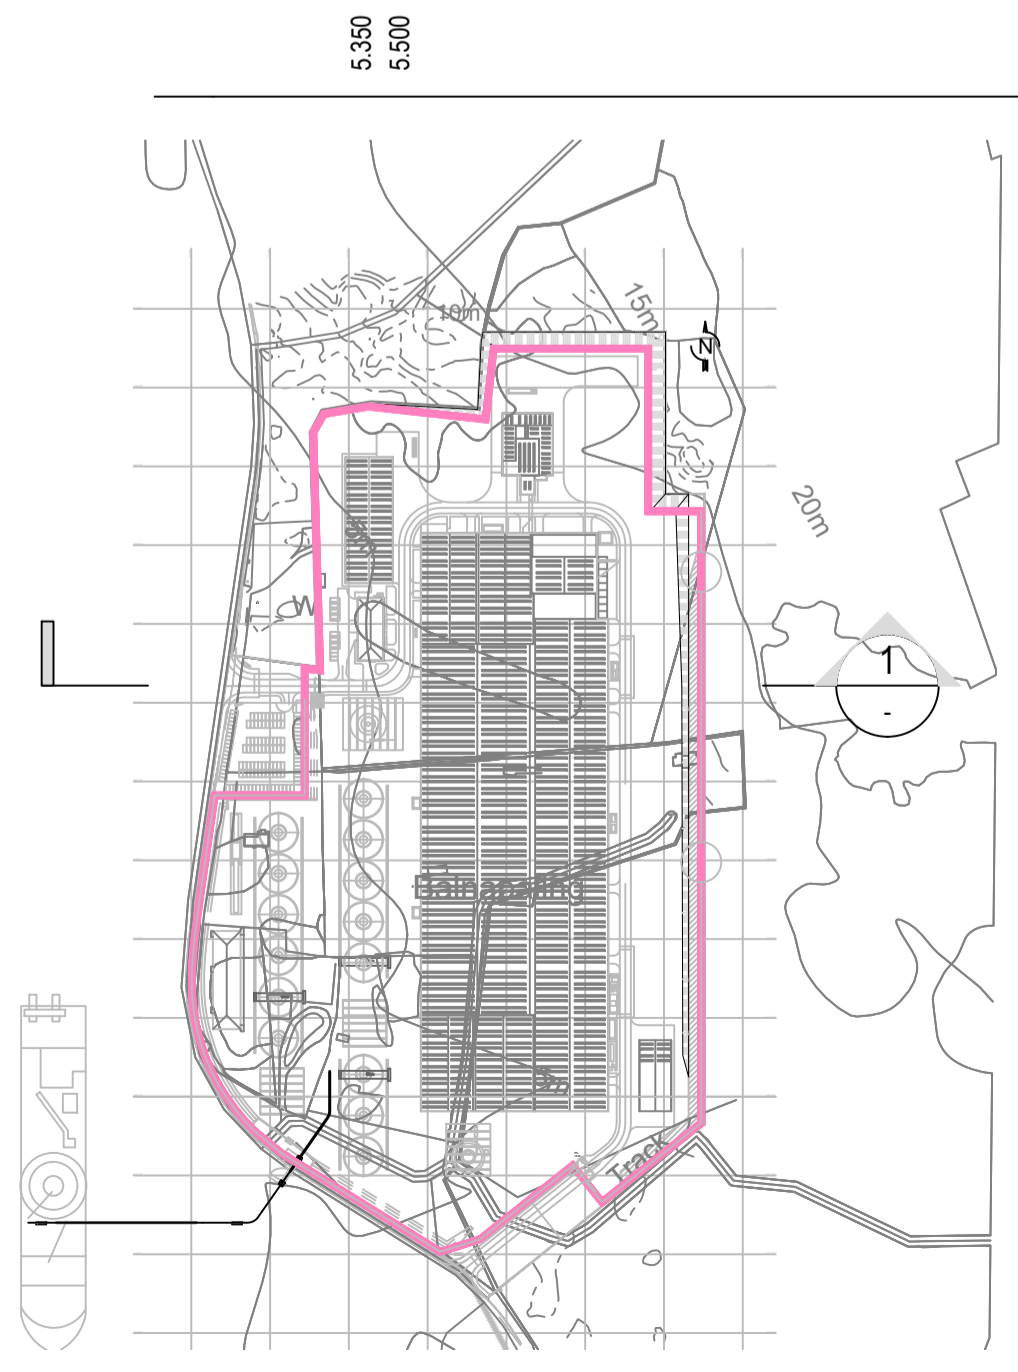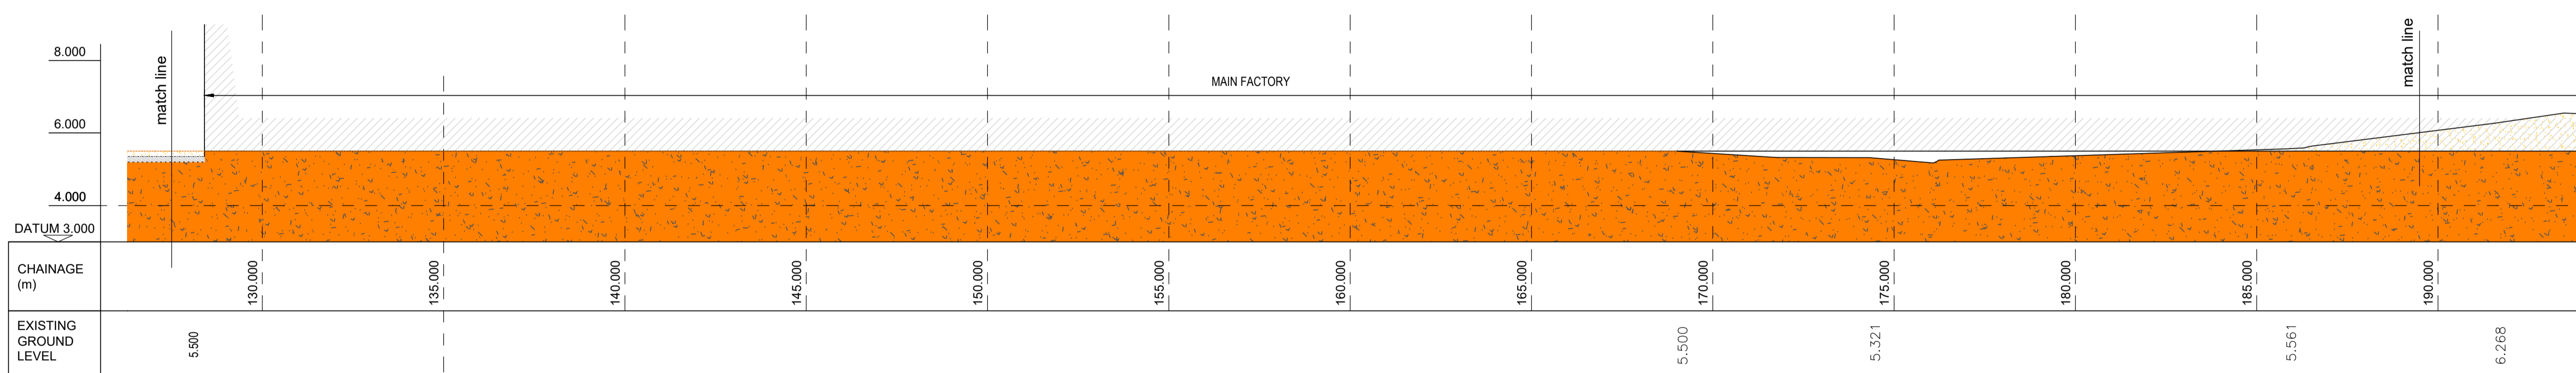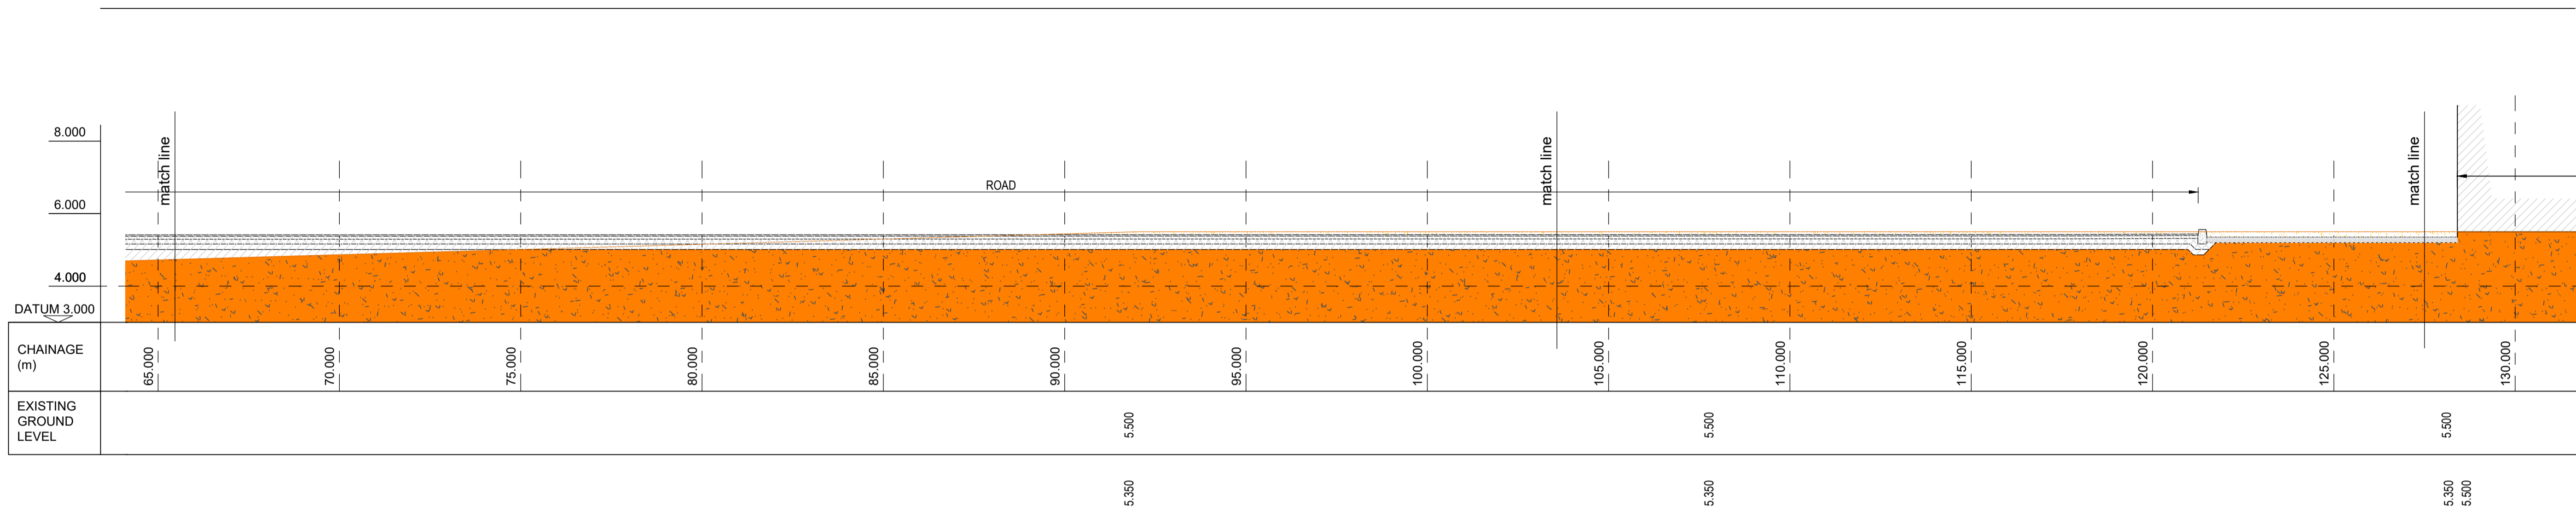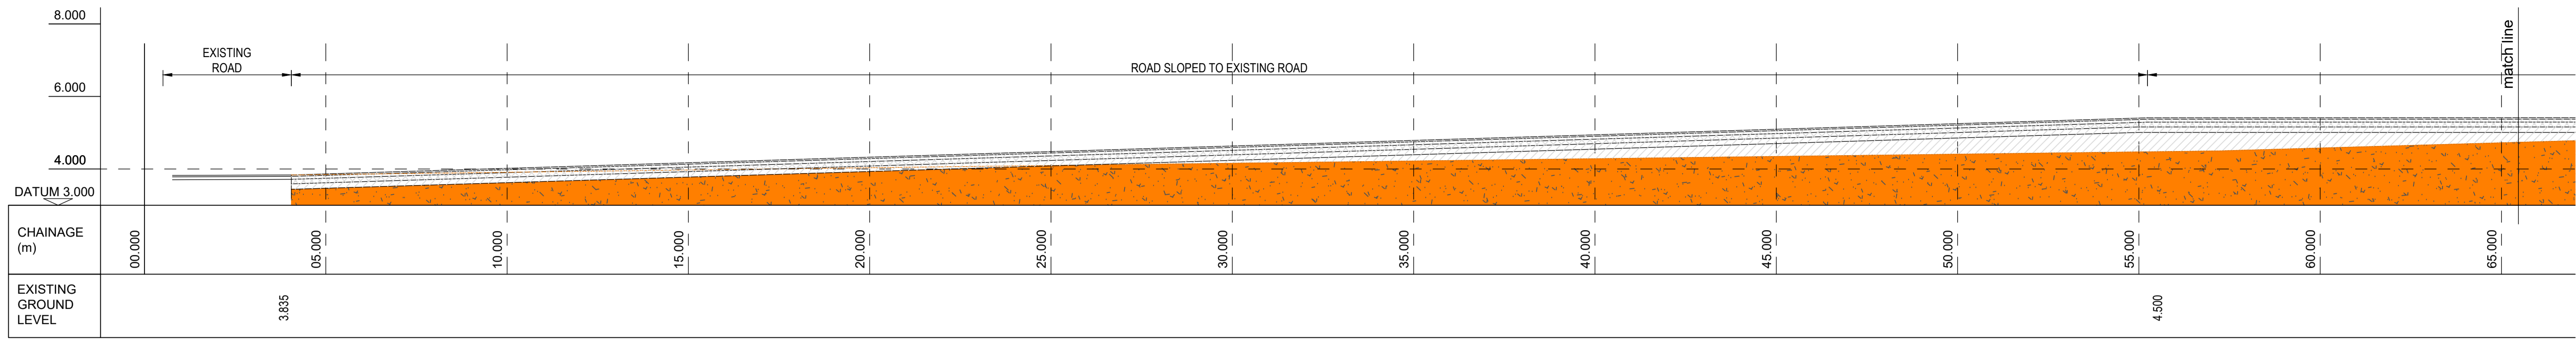

SITE KEY PLAN

LEGEND

**STA CABLE FACTORY**  
NIGG, TAIN IV19 1QU

eda ARCHITECTS  
EDA Architects Ltd  
Omagh Enterprise Centre,  
41 Gortrush Ind Est,  
Omagh BT78 5LJ  
eoghan@eda-architects.com

REVISIONS

REV NO	DATE	DESCRIPTION	CHK	DRN
P01	21/08/23	ISSUED FOR INFORMATION	DC	DG

STATUS  
**PLANNING**

PROJECT  
**SEIUK - CL**

PROJECT ADDRESS  
-

DISCIPLINE  
**CIVIL**

DWG TITLE  
**ROADS LONG SECTIONS - SHEET 1**

DWG NO.  
**S-264-EUR-EXT-ZZ-DR-C-6315**

STATUS CODE  
**PLANNING**

PROJECT NO.  
**S-264**

DATE  
**31/05/23**

DRAWN / CHECKED  
**DG -**




SCALE NO.  
**(@A1) 1:100**

REVISION NUMBER  
**P01**

**EUROPLAN GROUP**

Parkview House, Beechill Office Campus,  
Clonskeagh, Dublin 4, Eire.  
Tel: +353 1 2606578  
staprojectteam@euoplanservices.com

ALL DIMENSIONS TO BE CHECKED ON SITE  
NO DIMENSIONS TO BE SCALED FROM THIS  
DRAWING. DRAWING IS TO BE READ IN  
CONJUNCTION WITH RELEVANT  
CONSULTANT'S DRAWINGS

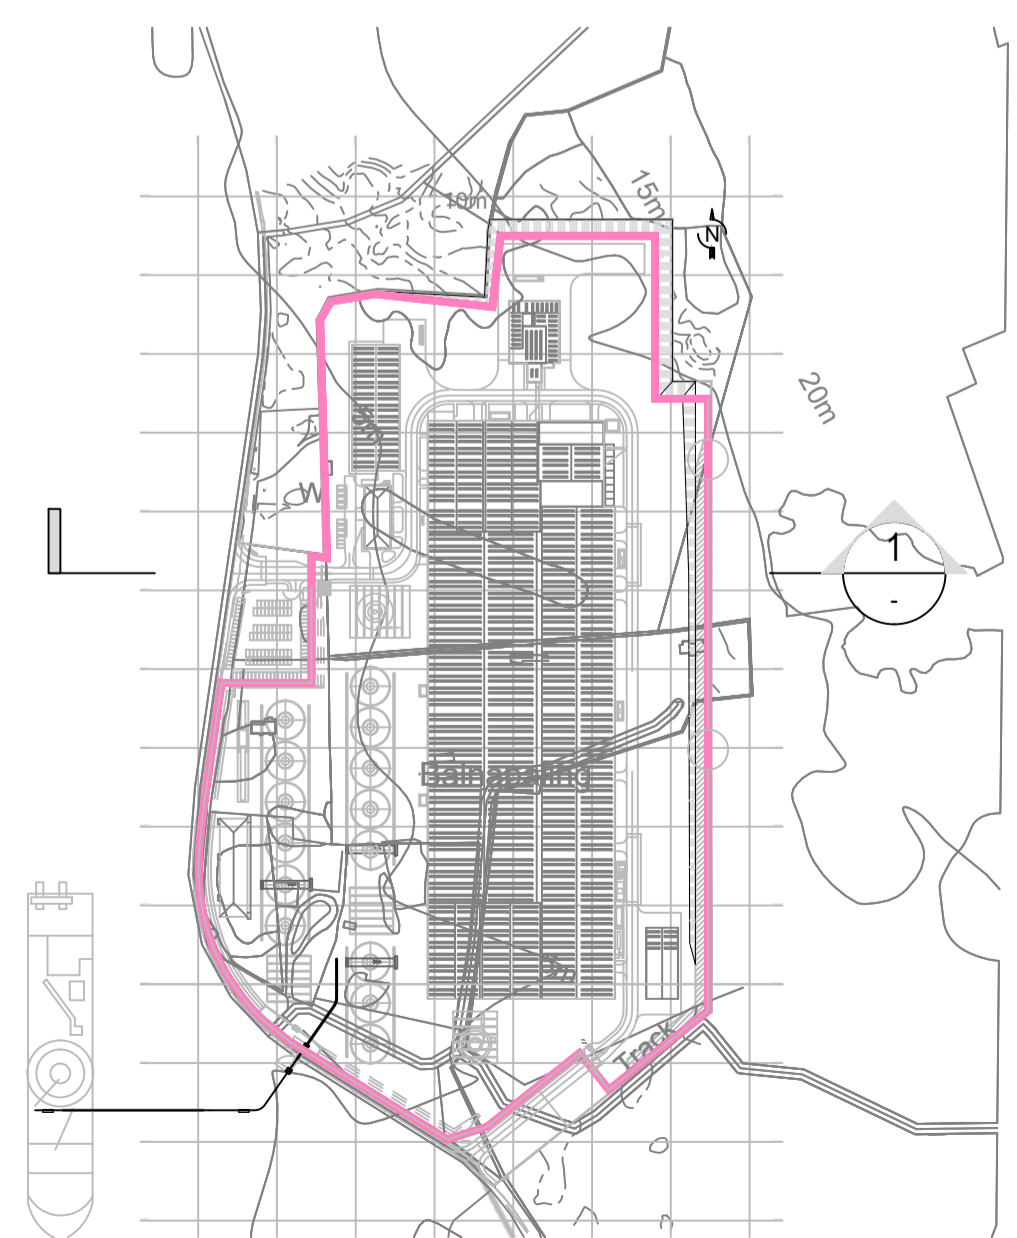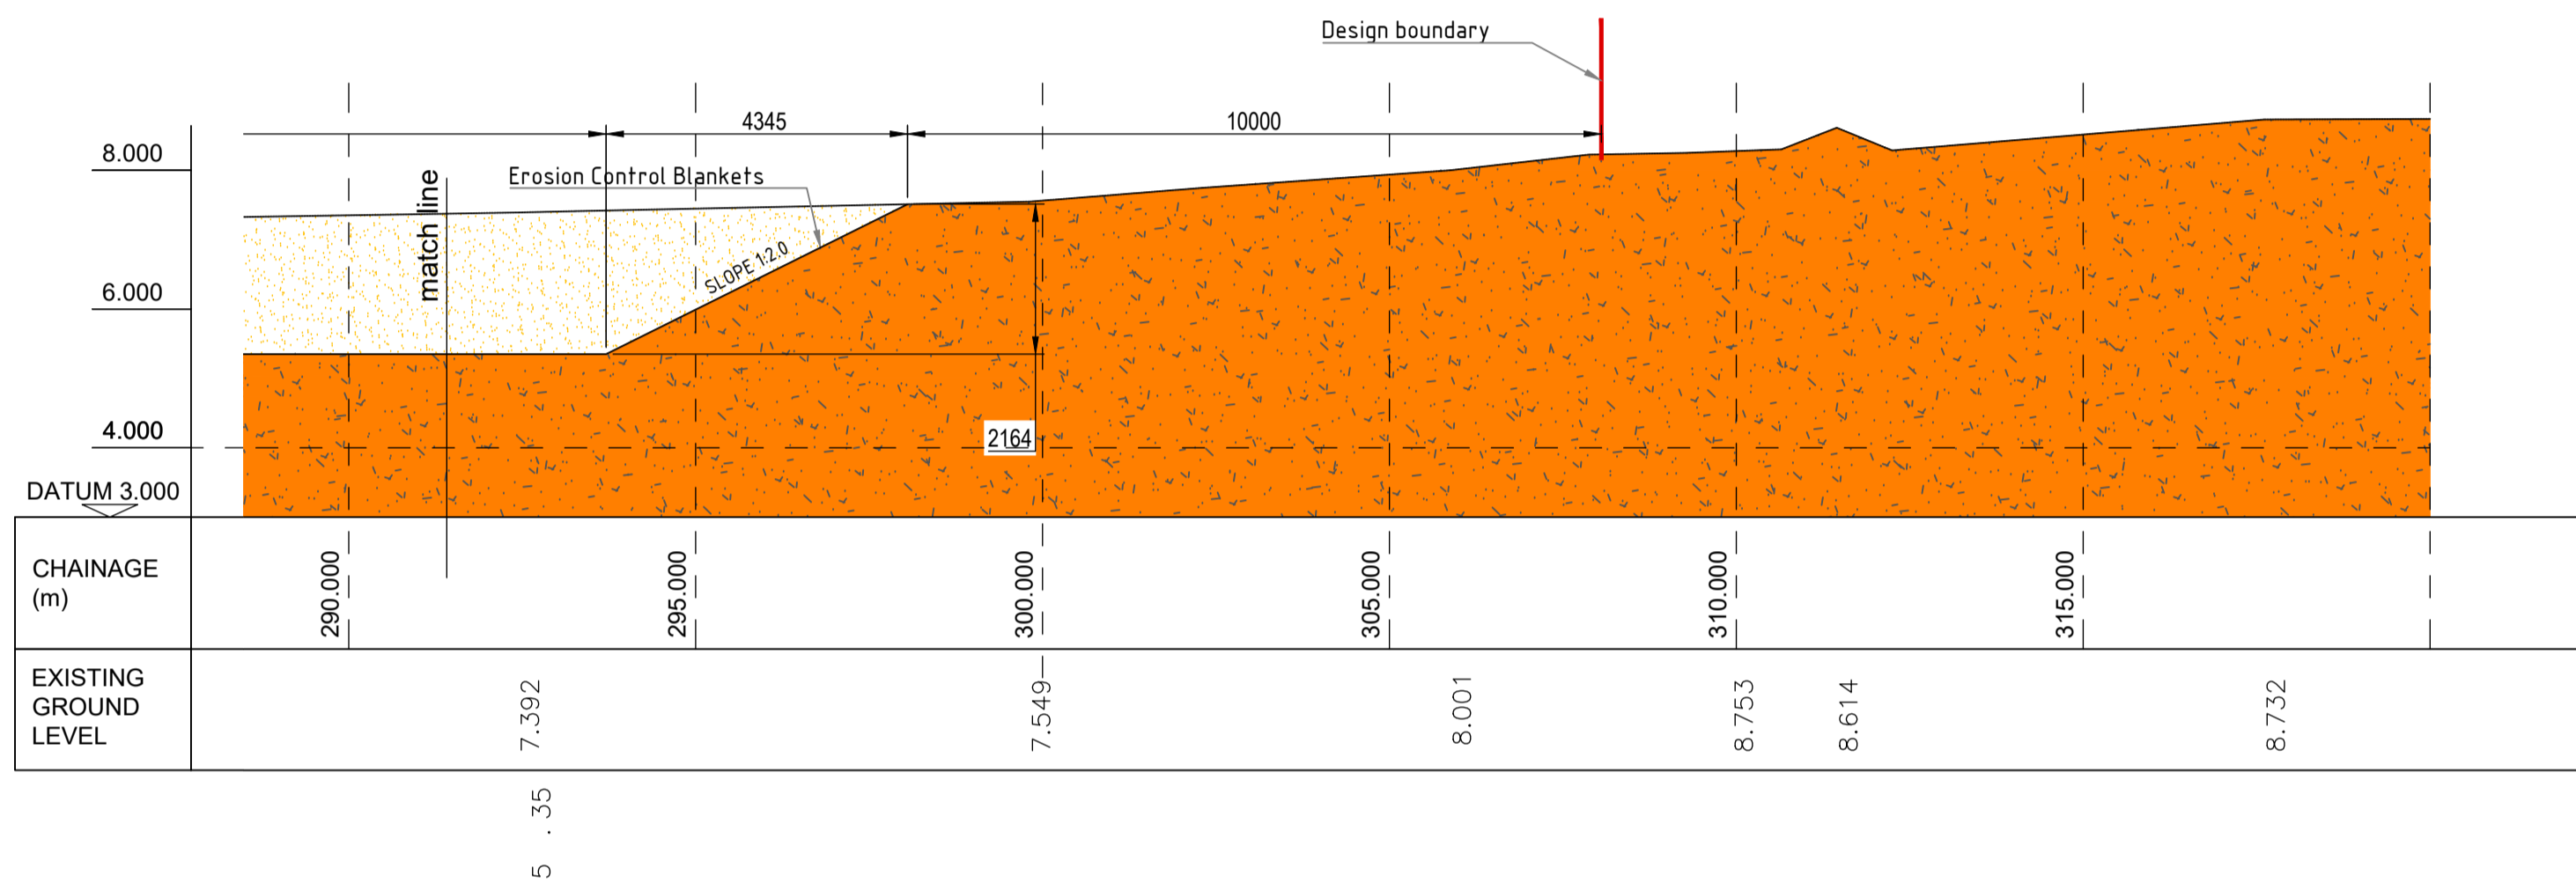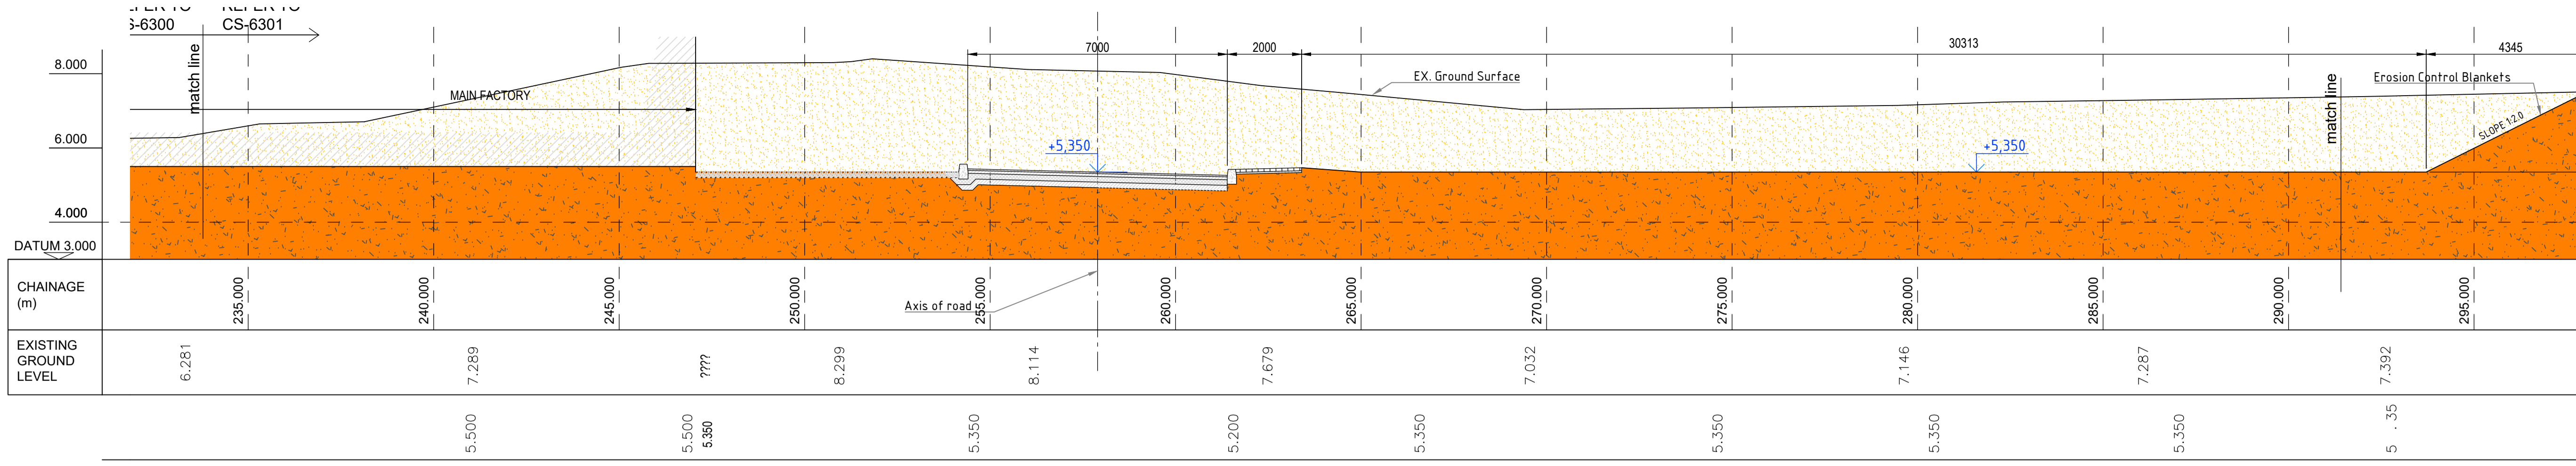

SITE KEY PLAN

LEGEND

**SUMITOMO ELECTRIC**  
STA CABLE FACTORY  
NIGG, TAIN IV19 1QU

**eda** ARCHITECTS  
EDA Architects Ltd  
Omagh Enterprise Centre,  
41 Gortrush Ind Est,  
Omagh BT78 5LJ  
eoghan@eda-architects.com

REVISIONS

NO.	DATE	DESCRIPTION	CHK	DRN

P01	21/08/23	ISSUED FOR INFORMATION	DC	DG
REV	DATE	DESCRIPTION	CHK	DRN

STATUS  
**PLANNING**

PROJECT  
**SEIUK - CL**

PROJECT ADDRESS  
-

DISCIPLINE  
**CIVIL**

DWG TITLE  
**ROADS LONG SECTIONS - SHEET 2**

DWG NO.  
**S-264-EUR-EXT-ZZ-DR-CS-6316**

STATUS CODE  
**PLANNING**

PROJECT NO. <b>S-264</b>	DATE <b>31/05/23</b>
DRAWN / CHECKED <b>DG -</b>	SCALE NO. <b>(@A1) 1:500</b>

REVISION NUMBER


**P01**

**EUROPLAN GROUP**  
Parkview House, Beechill Office Campus,  
Clonskeagh, Dublin 4, Eire.  
Tel: +353 1 2606578  
staprojectteam@euoplanservices.com



ALL DIMENSIONS TO BE CHECKED ON SITE.  
NO DIMENSIONS TO BE SCALED FROM THIS  
DRAWING. DRAWING IS TO BE READ IN  
CONJUNCTION WITH RELEVANT  
CONSULTANTS DRAWINGS.

A1

SITE KEY PLAN

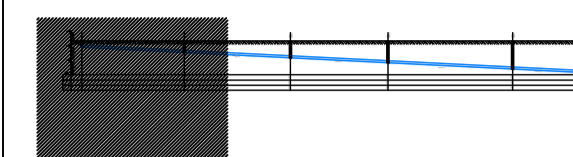

LEGEND

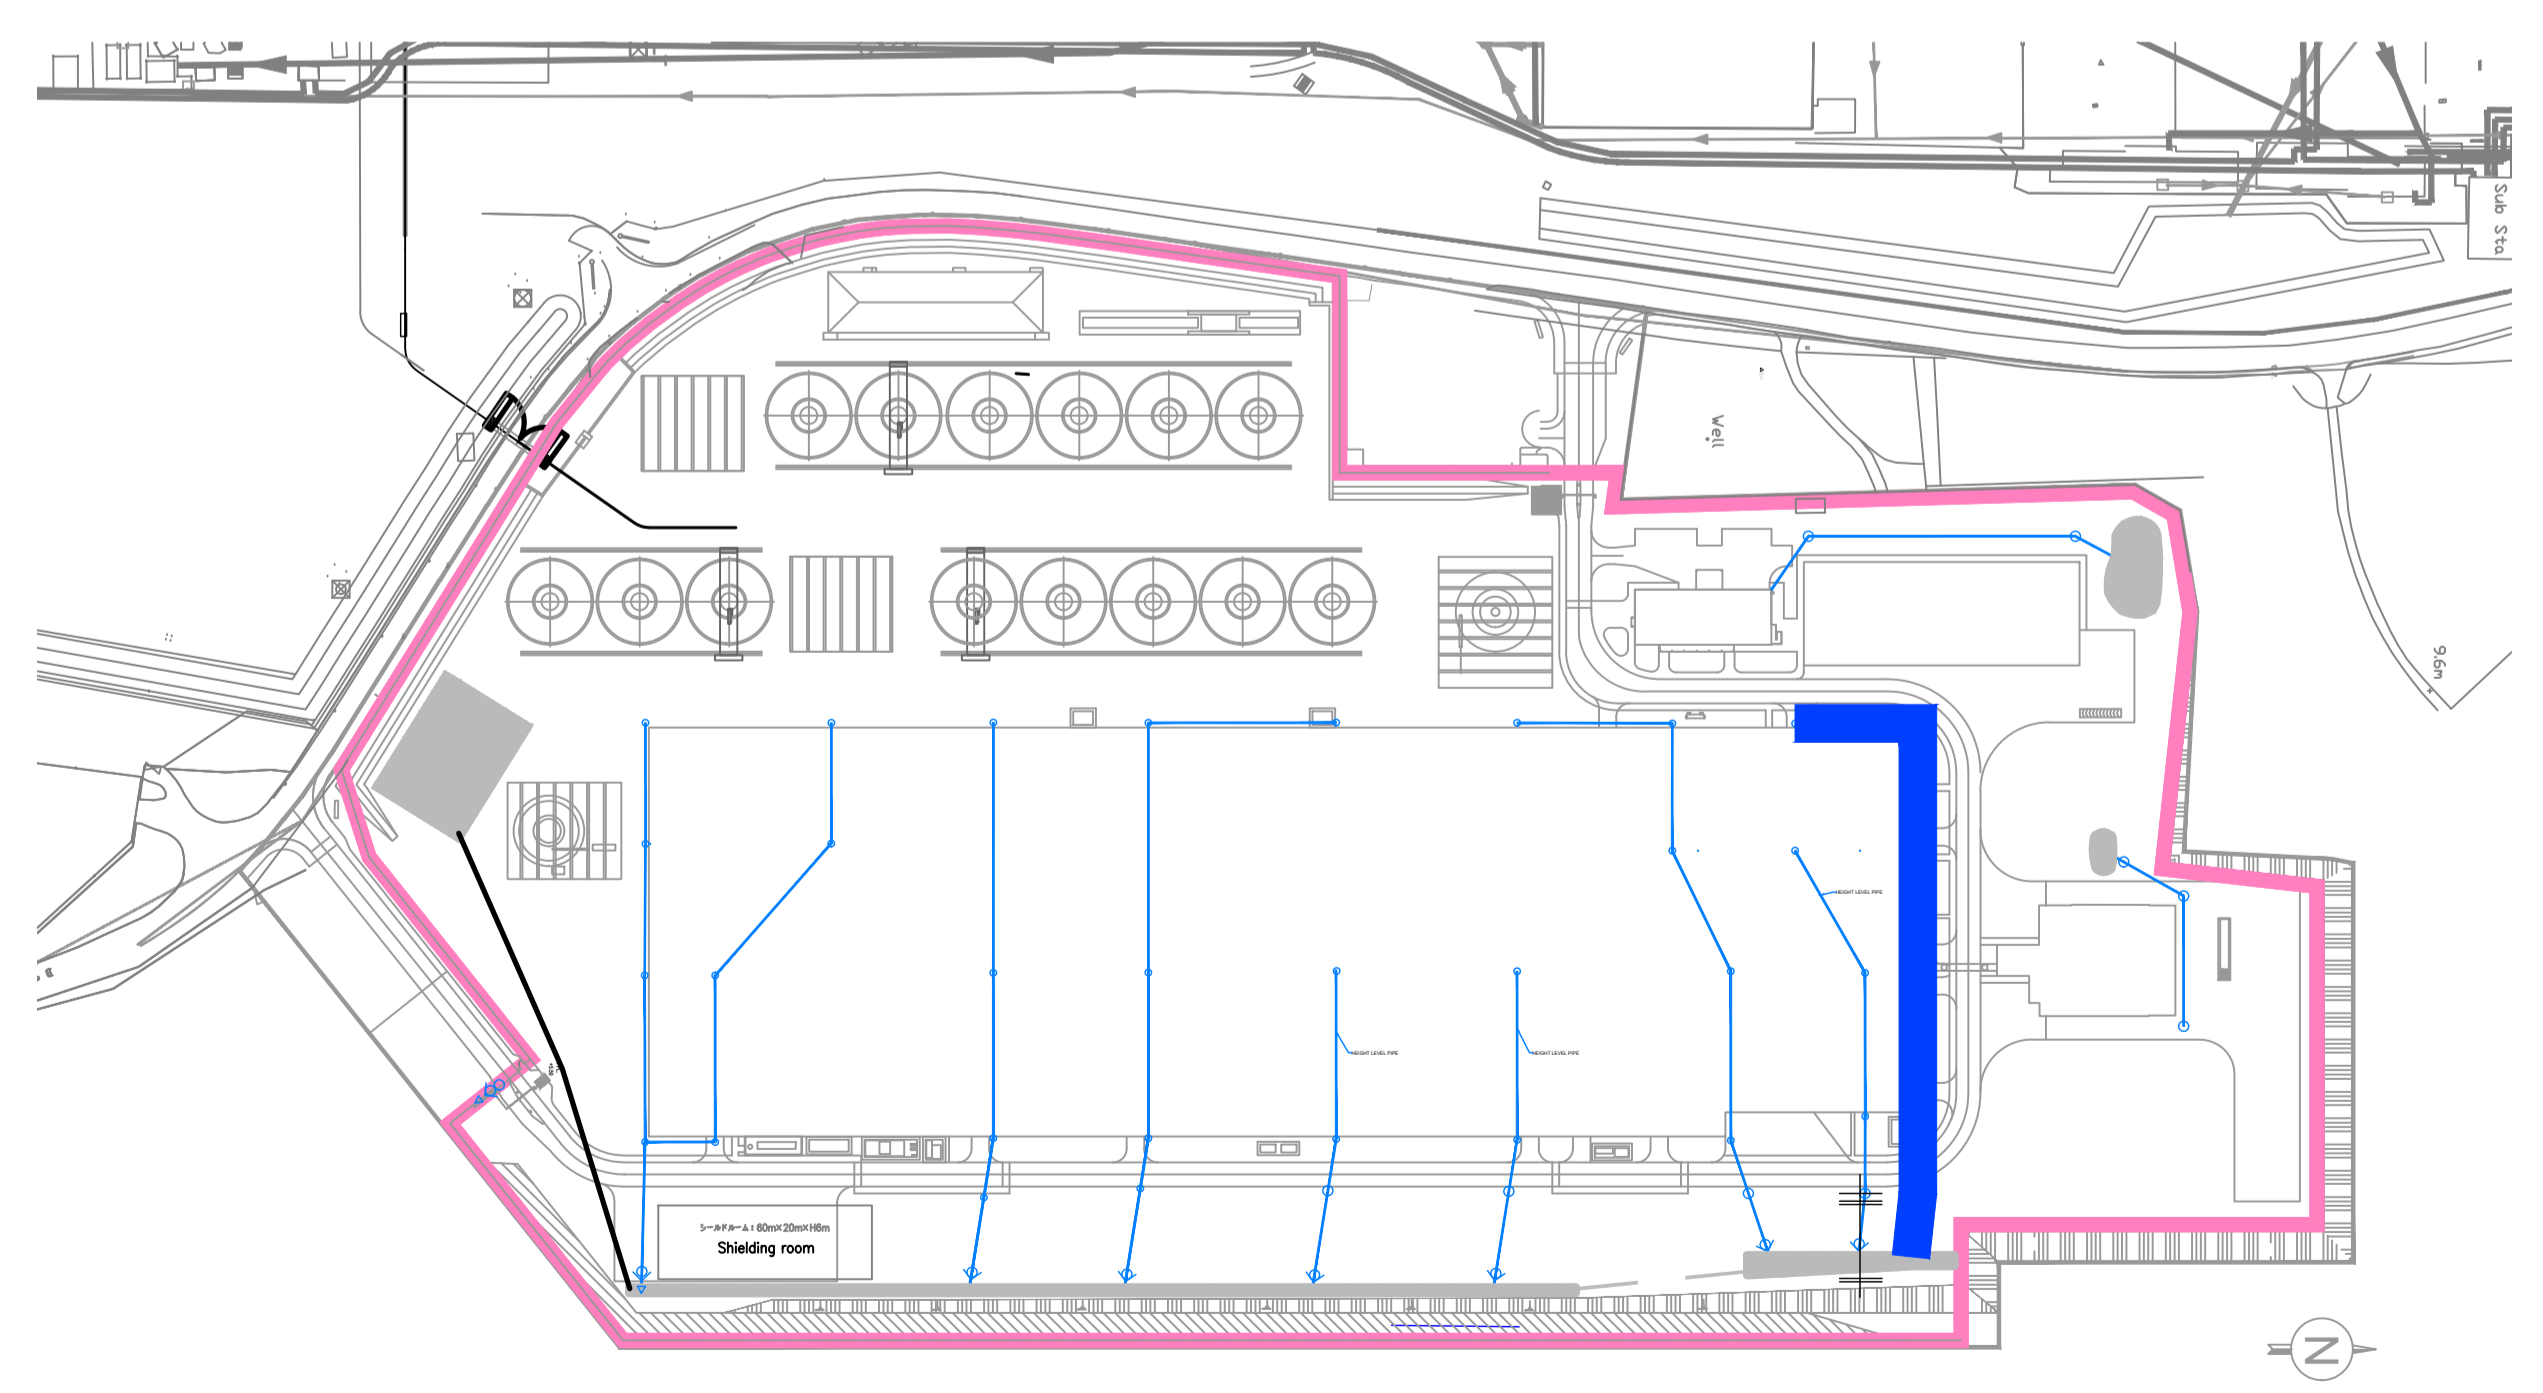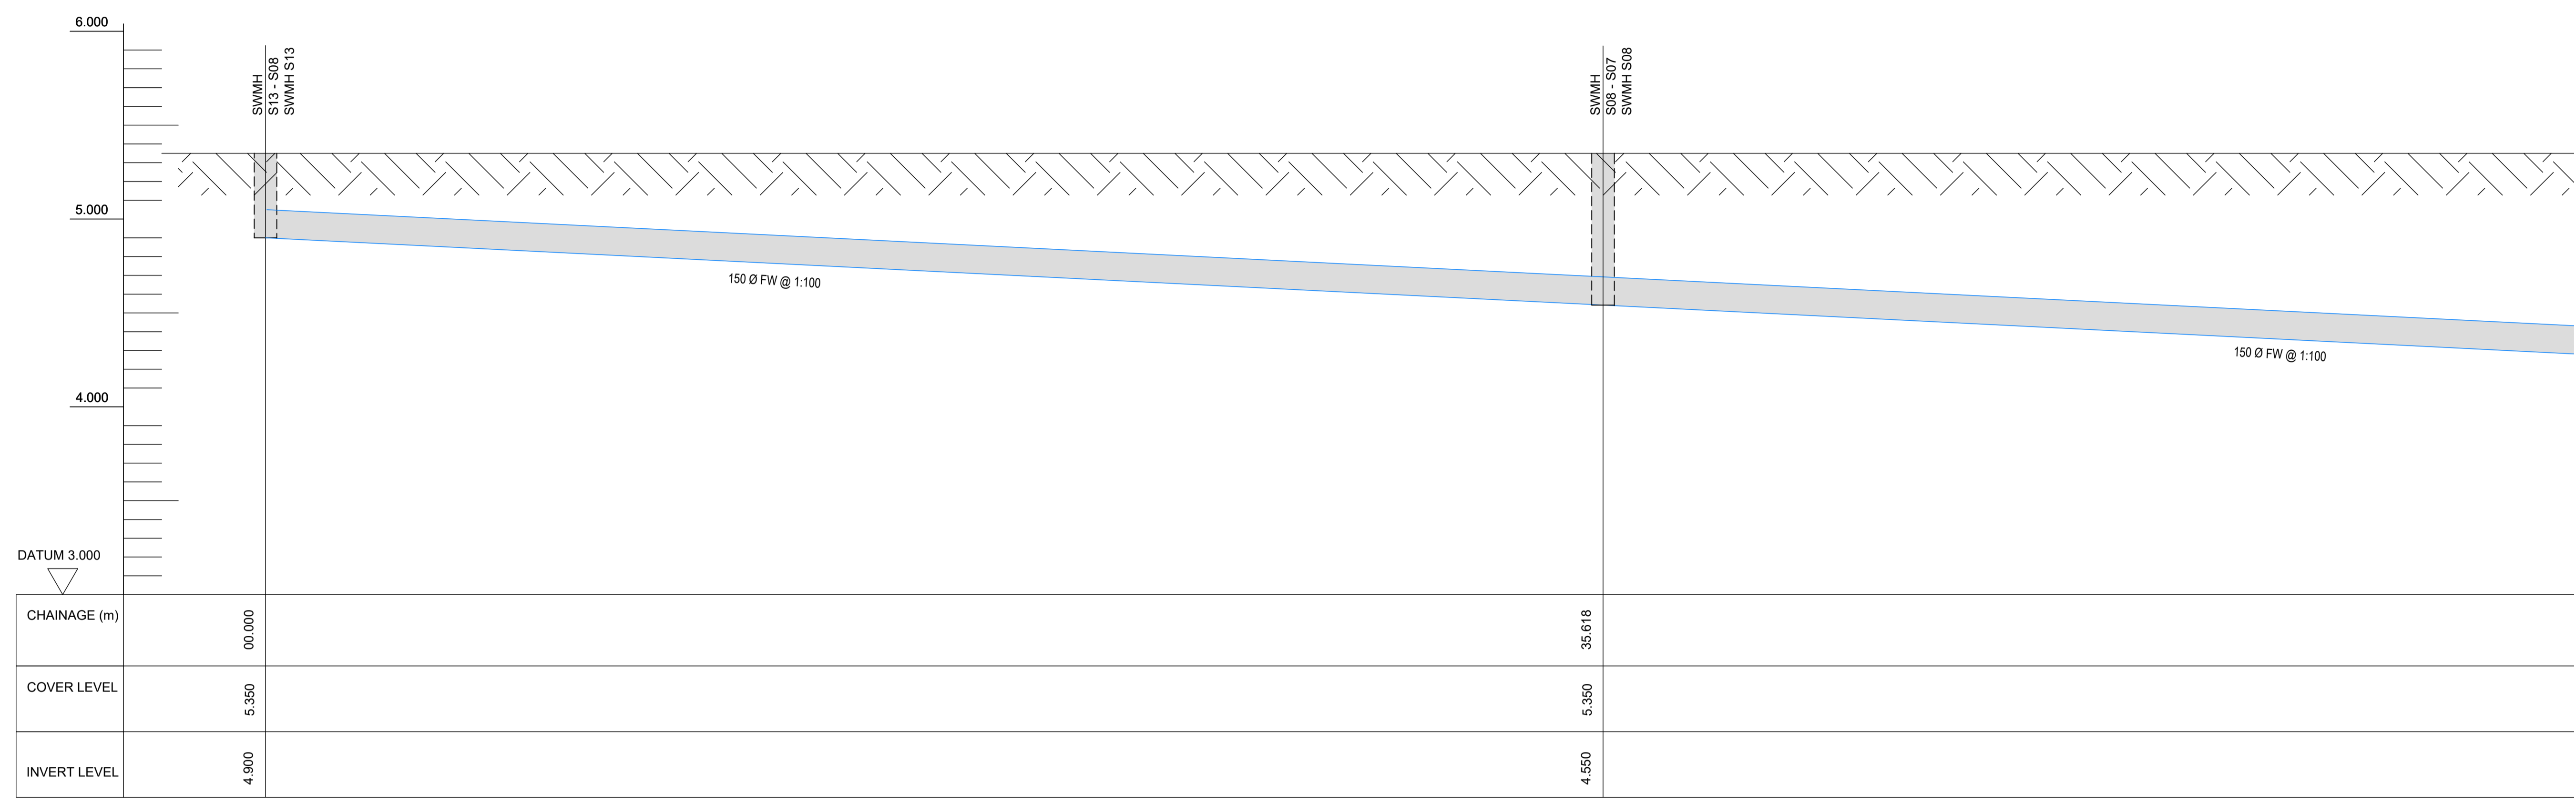

KEYPLAN

**STA CABLE FACTORY**  
SUMITOMO ELECTRIC NIGG, TAIN IV19 1QU

eda ARCHITECTS  
EDA Architects Ltd  
Omagh Enterprise Centre,  
41 Gortnah 1st East,  
Omagh BT78 5LU  
eoghan@eda-architects.com

REVISIONS

REV	DATE	DESCRIPTION	CHK	DRN
P01	21/08/23	ISSUED FOR PLANNING	DC	DG

STATUS  
**PLANNING**

PROJECT  
**SEIUK - CL**

PROJECT ADDRESS  
-

DISCIPLINE  
**CIVIL**

DWG TITLE  
**Storm Water - Longitudinal Section - S13-S04 - 01/03**

DWG NO.  
**S-264-EUR-EXT-ZZ-DR-CS-6326**

STATUS CODE  
**C4**

PROJECT NO.  
**S-264**

DATE  
**08/01/23**

DRAWN / CHECKED  
**SVM/DC**

SCALE NO.  
**1 : 100**

REVISION NUMBER


**P01**

**EUROPLAN GROUP**



Parkview House, Beechill Office Campus,  
Clonskeagh, Dublin 4, Eire.  
Tel: +353 1 2606578  
staprojectteam@europlanservices.com

ALL DIMENSIONS TO BE CHECKED ON SITE.  
NO DIMENSIONS TO BE SCALED FROM THIS  
DRAWING. DRAWINGS TO BE READ IN  
CONJUNCTION WITH RELEVANT  
CONSULTANTS DRAWINGS.

SITE KEY PLAN

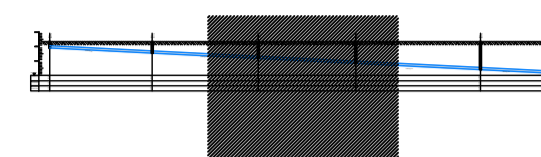

LEGEND

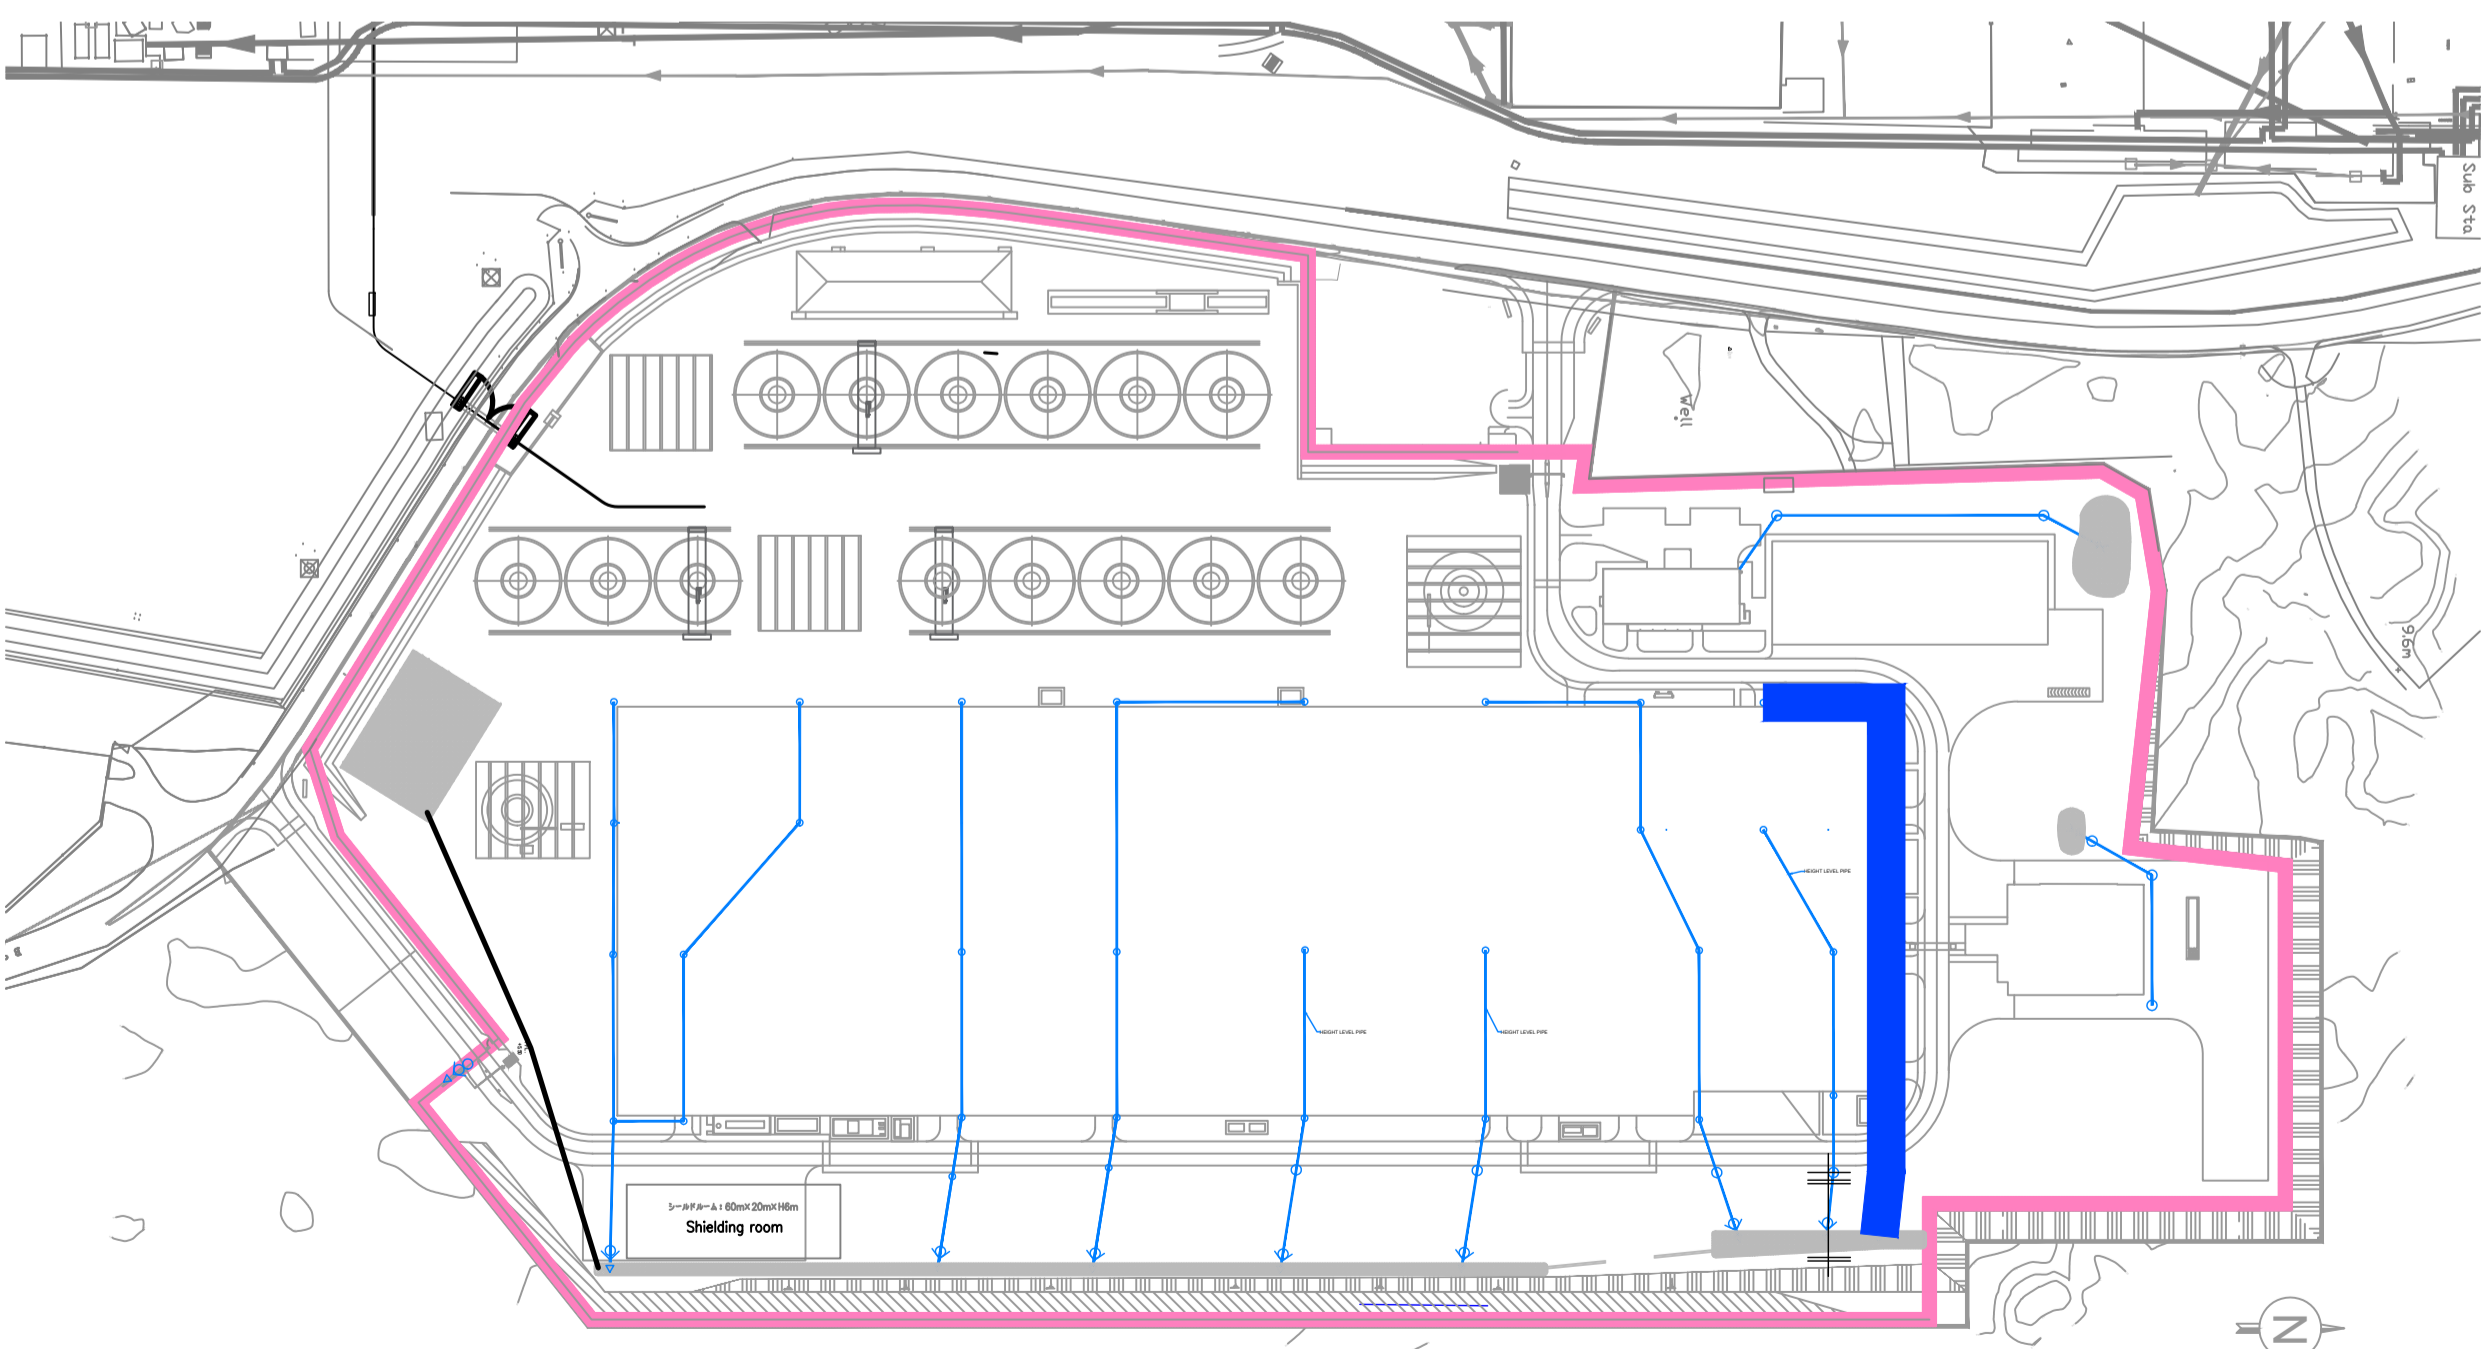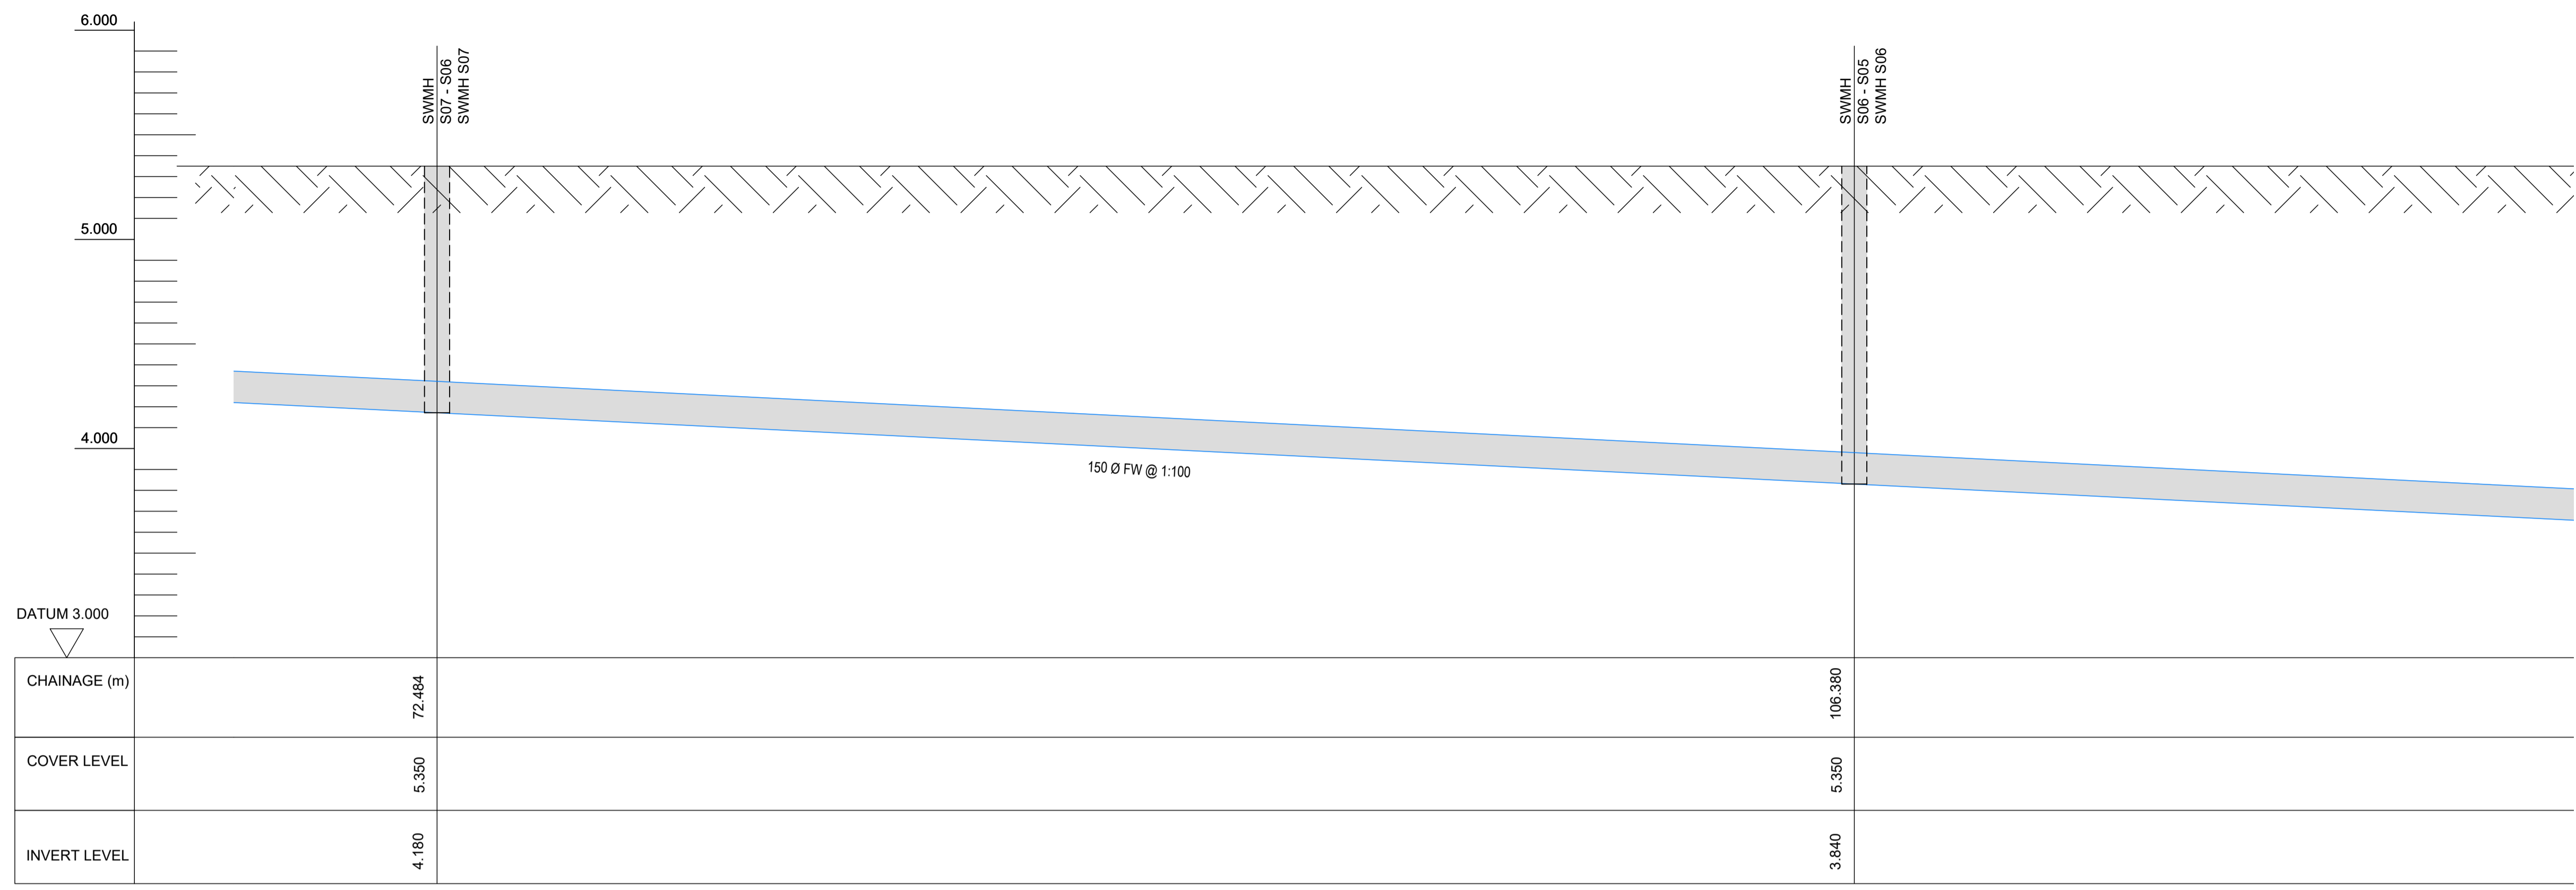

KEYPLAN

**SUMITOMO ELECTRIC** STA CABLE FACTORY  
NIGG, TAIN IV19 1QU

**eda** ARCHITECTS  
EDA Architects Ltd  
Omagh Enterprise Centre,  
41 Gortnah 1st East,  
Omagh BT78 5LU  
eoghan@eda-architects.com

REVISIONS

NO.	DATE	DESCRIPTION	CHK	DRN

P01	21/08/23	ISSUED FOR PLANNING	DC	DG
REV	DATE	DESCRIPTION	CHK	DRN
STATUS				
PLANNING				
PROJECT				
SEIUK - CL				
PROJECT ADDRESS				
-				
DISCIPLINE				
CIVIL				
DWG TITLE				
Storm Water - Longitudinal Section - S13-S04 - 02/03				
DWG NO.				
S-264-EUR-EXT-ZZ-DR-CS-6327				
STATUS CODE				
C4				
PROJECT NO.		DATE		
S-264		08/01/23		
DRAWN / CHECKED		SCALE NO.		
SVM/DC		1 : 100		

REVISION NUMBER


**P01**

**EUROPLAN GROUP**  
Parkview House, Beechill Office Campus,  
Clonskeagh, Dublin 4, Eire.  
Tel: +353 1 2606578  
staprojectteam@europlanservices.com





ALL DIMENSIONS TO BE CHECKED ON SITE.  
NO DIMENSIONS TO BE SCALED FROM THIS  
DRAWING. DRAWING IS TO BE READ IN  
CONJUNCTION WITH RELEVANT  
CONSULTANTS DRAWINGS.

SITE KEY PLAN

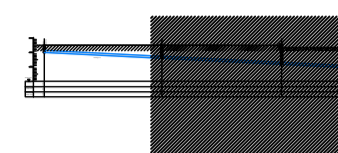

LEGEND

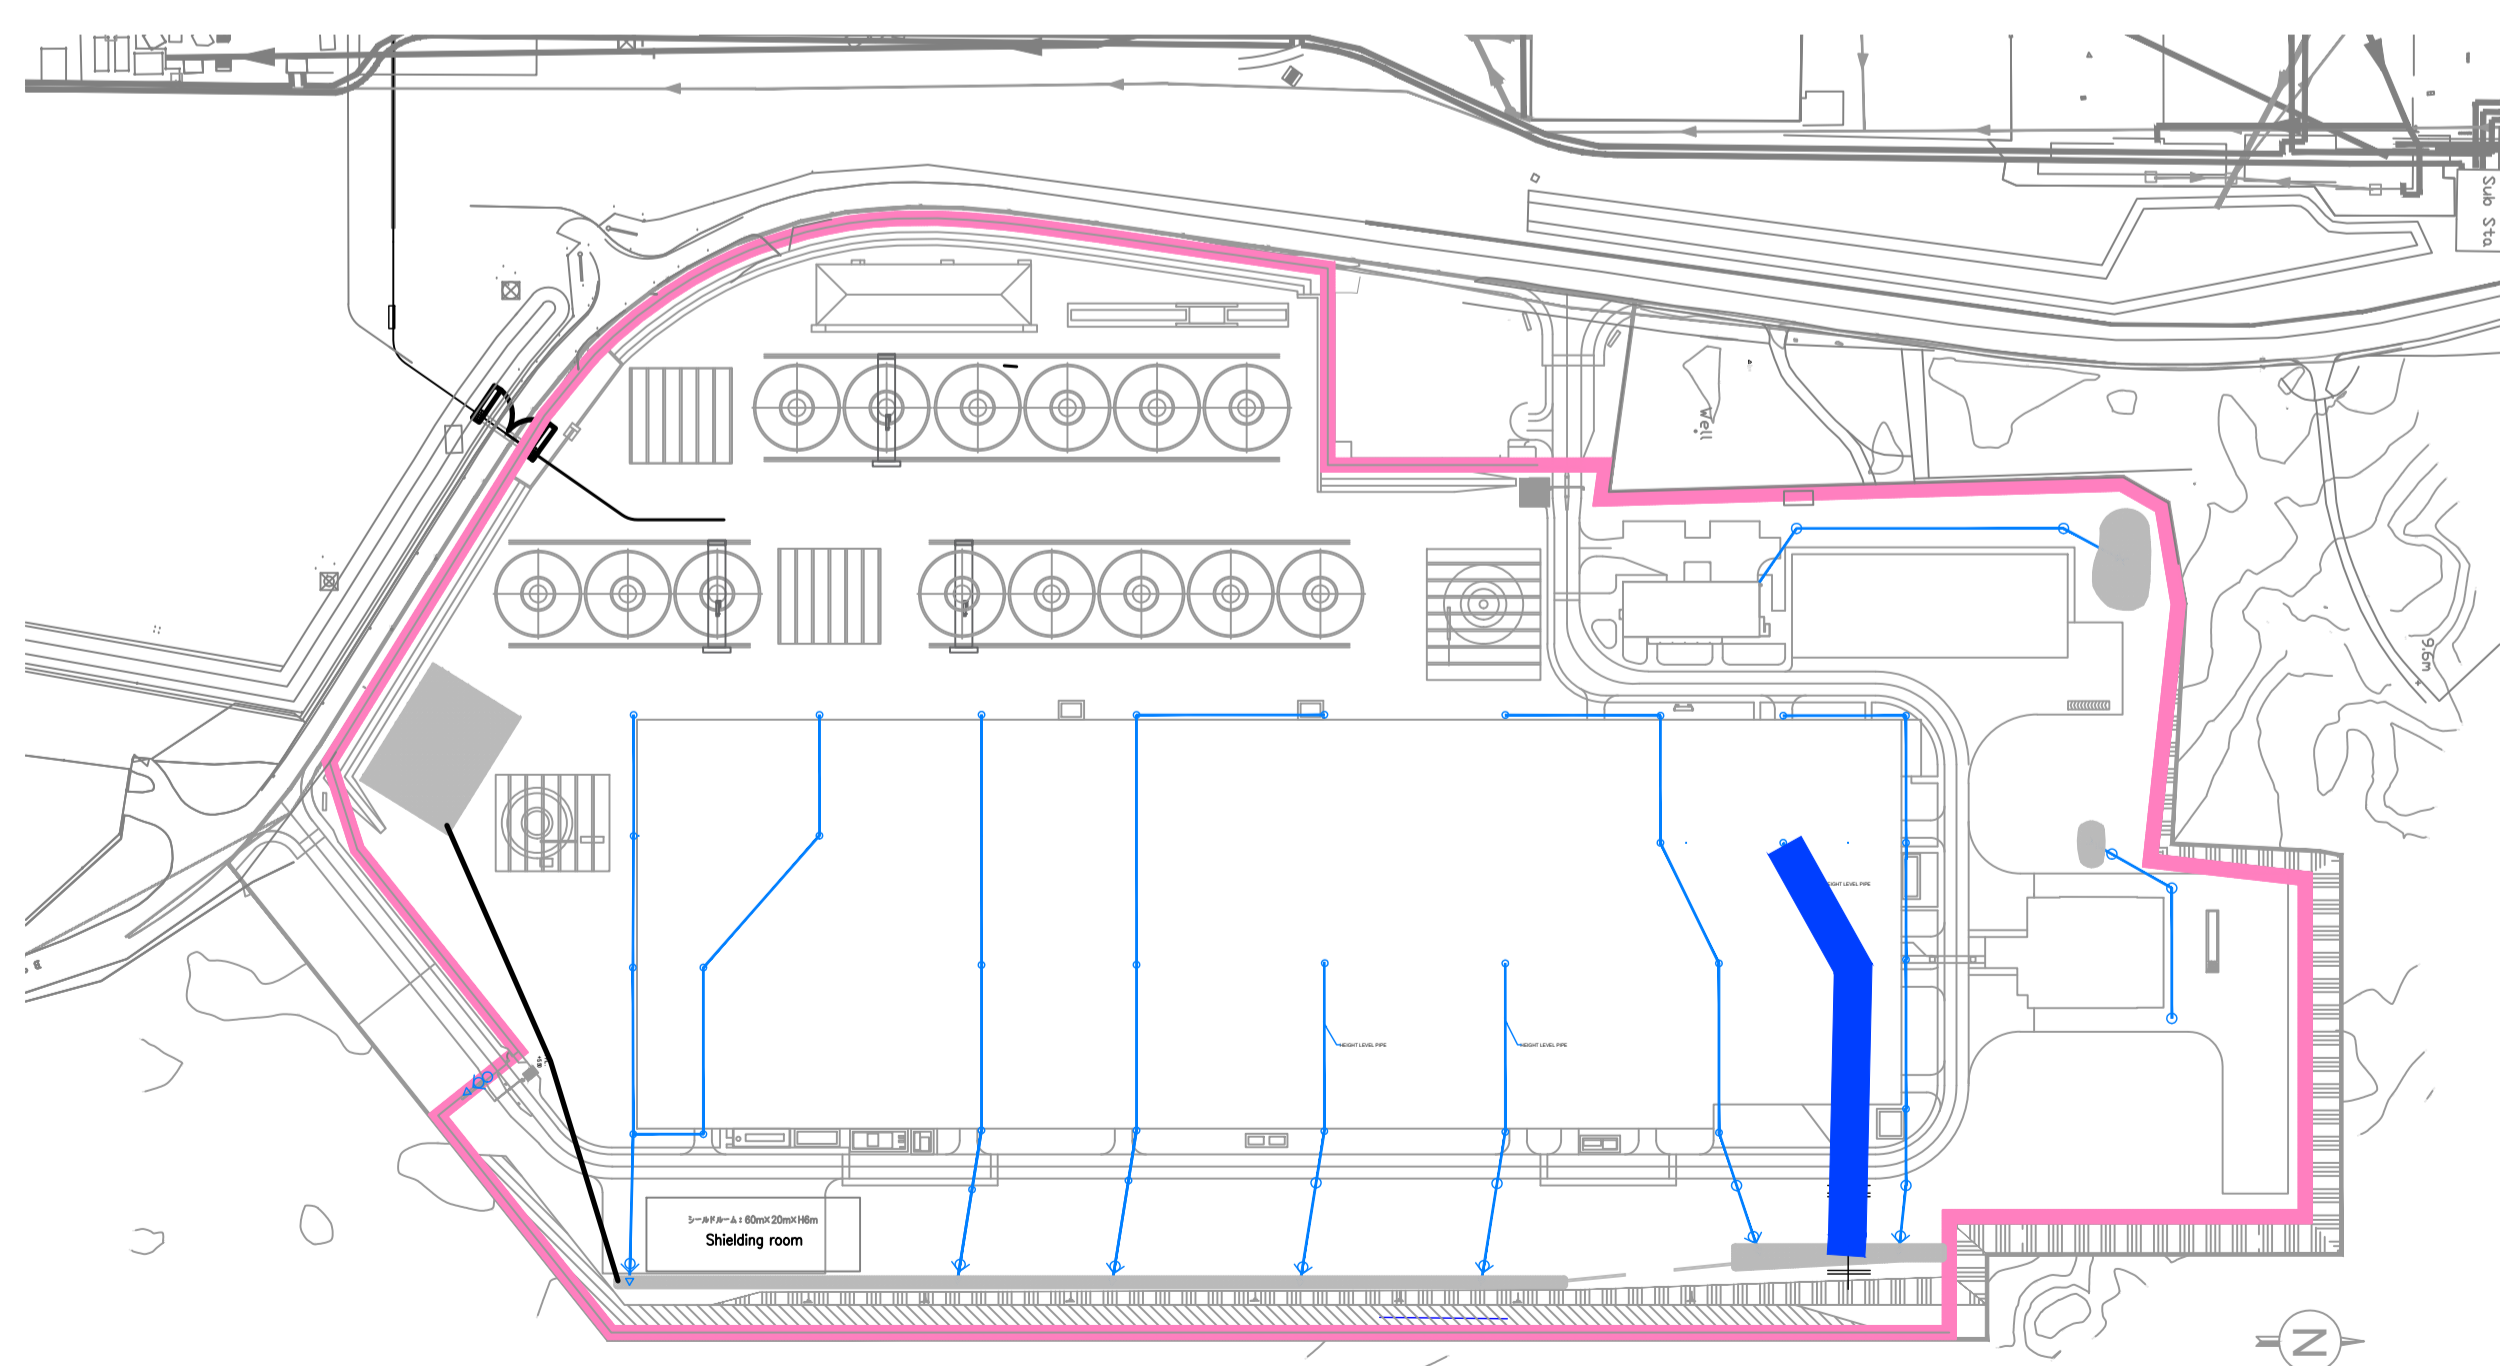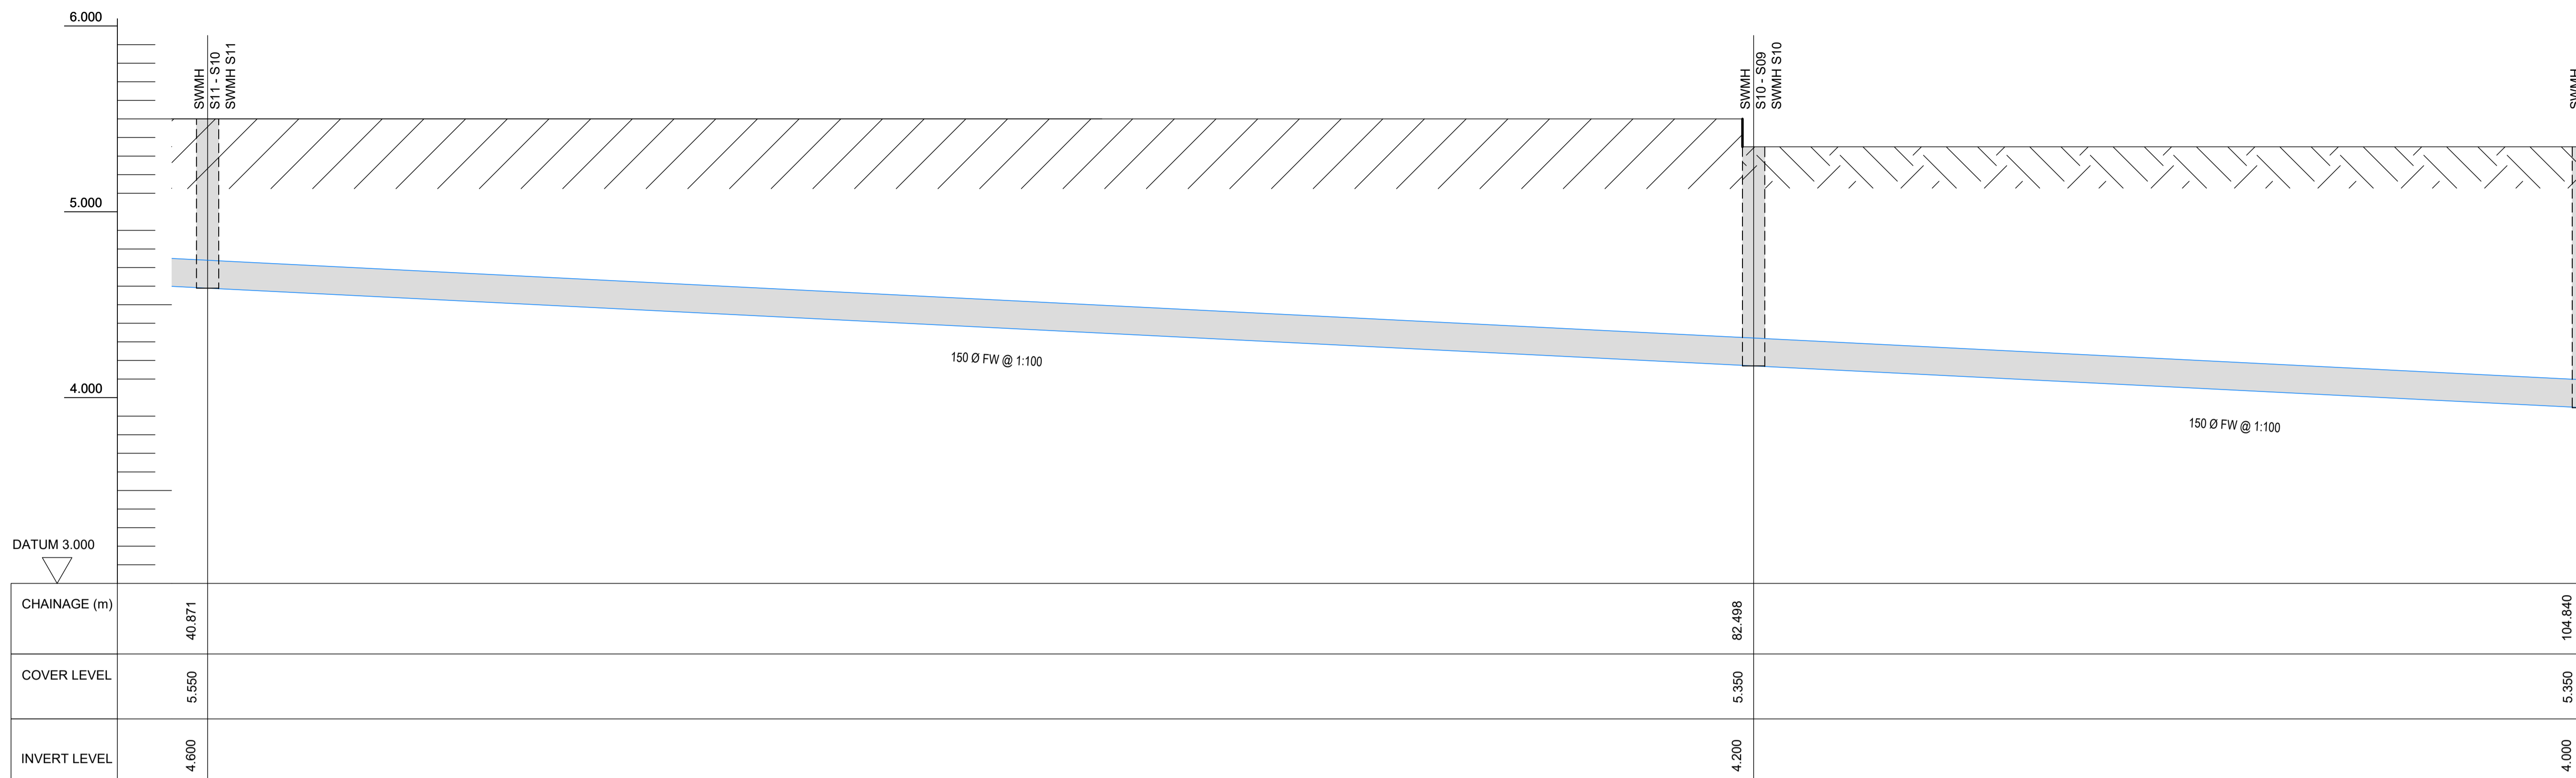

KEYPLAN

REVISIONS

REV	DATE	DESCRIPTION	CKH	DRN
P01	21/08/23	ISSUED FOR PLANNING	DC	DG

STATUS: PLANNING

PROJECT: SEIUK - CL

PROJECT ADDRESS: -

DISCIPLINE: CIVIL

DWG TITLE: Storm Water - Longitudinal Section - S12-S09 - 02/02

DWG NO.: S-264-EUR-EXT-ZZ-DR-CS-6330

STATUS CODE: C4

PROJECT NO.: S-264 DATE: 08/01/23

DRAWN / CHECKED: SVM/DC SCALE NO.: 1:100

REVISION NUMBER

P01

**EUROPLAN GROUP**  
 Parkview House, Beechill Office Campus,  
 Clonskeagh, Dublin 4, Eire.  
 Tel: +353 1 2606578  
 staprojectteam@europlanservices.com


**STA CABLE FACTORY**  
 NIGG, TAIN IV19 1QU

**eda ARCHITECTS**  
 EDA Architects Ltd  
 Omagh Enterprise Centre,  
 41 Gortnah 3rd Est,  
 Omagh BT78 5LU  
 eoghan@eda-architects.com



**SUMITOMO ELECTRIC**

ALL DIMENSIONS TO BE CHECKED ON SITE.  
NO DIMENSIONS TO BE SCALED FROM THIS  
DRAWING. DRAWING IS TO BE READ IN  
CONJUNCTION WITH RELEVANT  
CONSULTANTS DRAWINGS.

SITE KEY PLAN

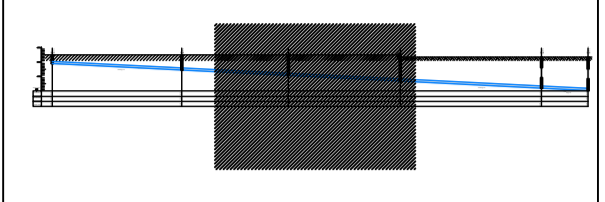

LEGEND

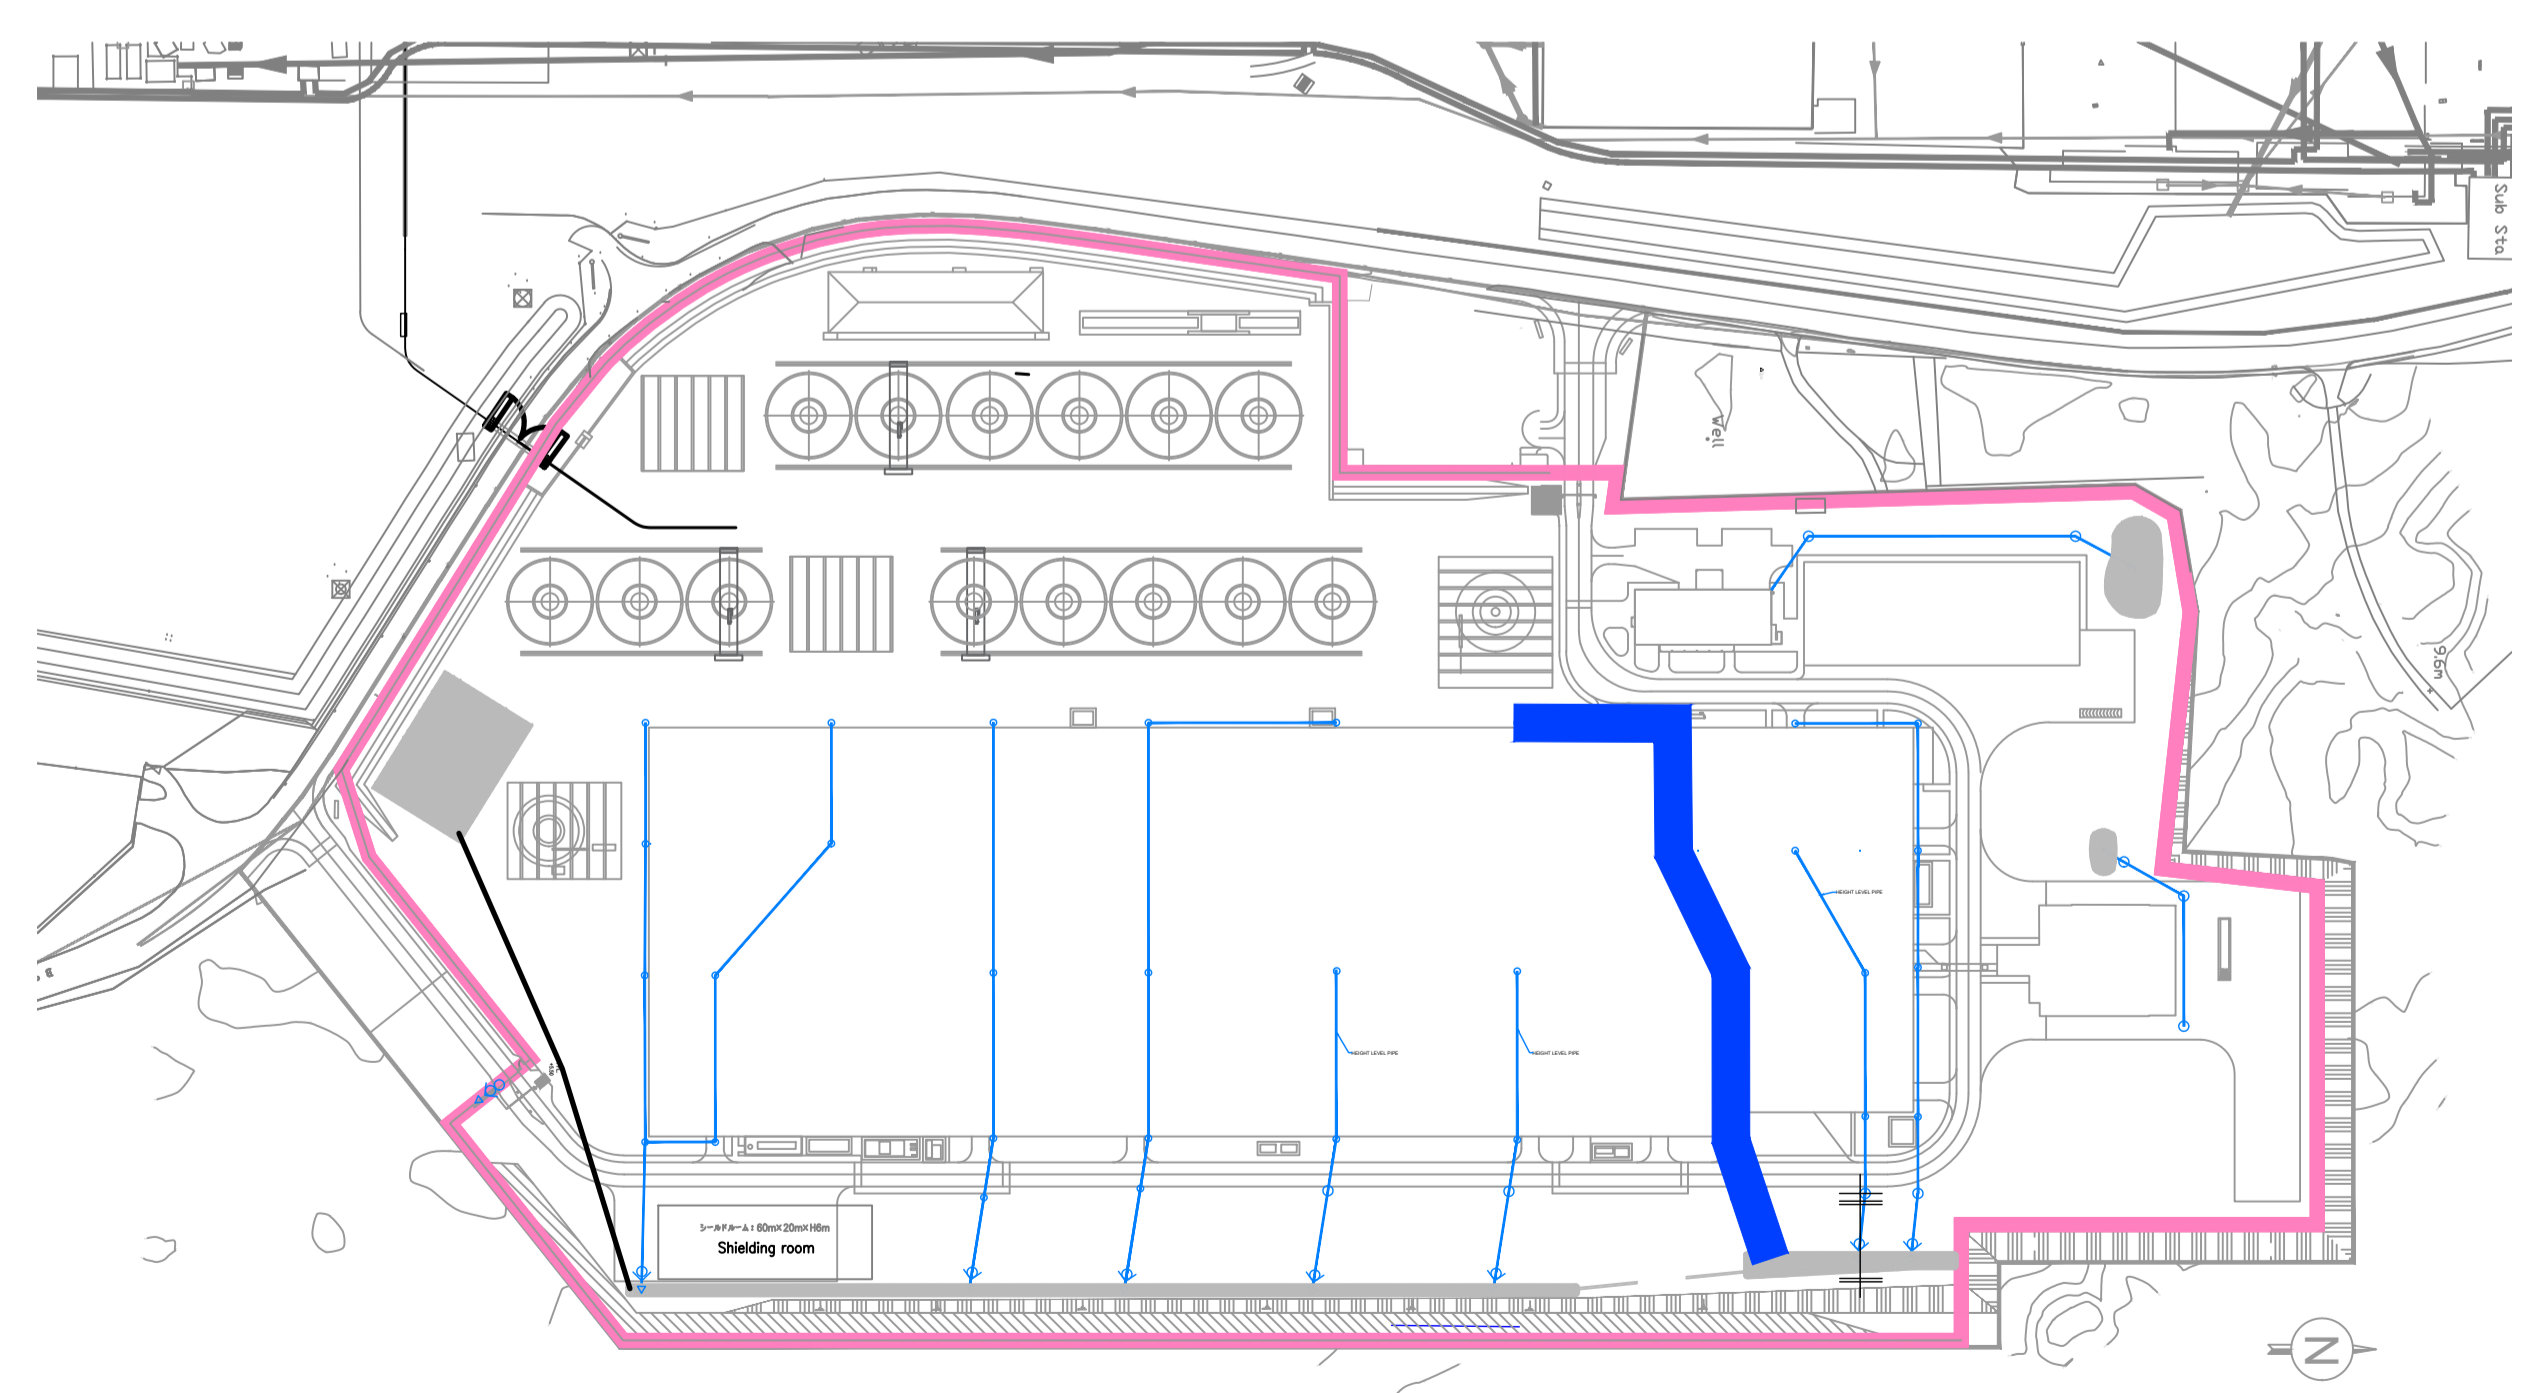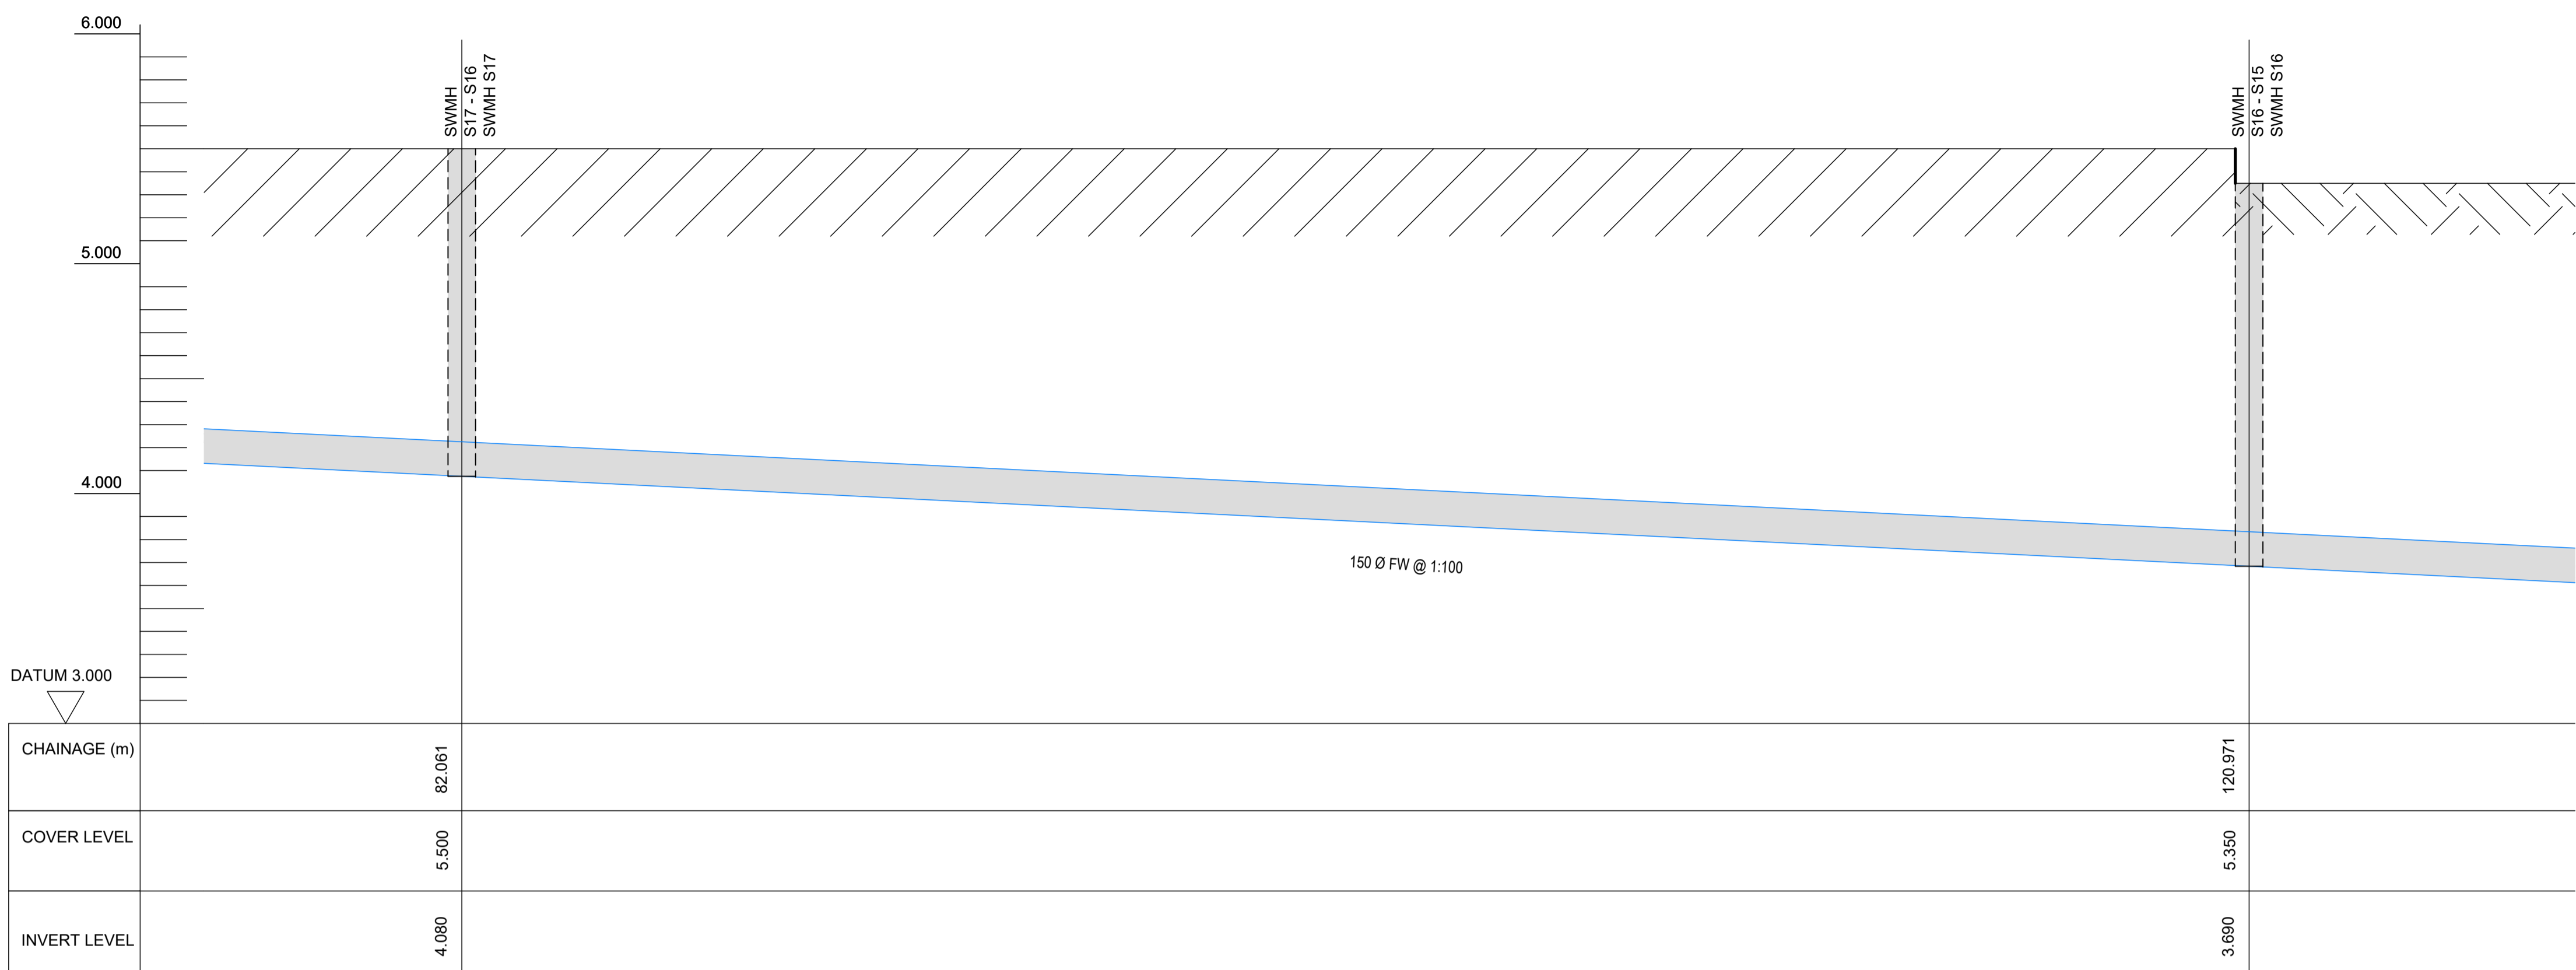

KEYPLAN

**SUMITOMO ELECTRIC** STA CABLE FACTORY  
NIGG, TAIN IV19 1QU

**eda** ARCHITECTS  
EDA Architects Ltd  
Omagh Enterprise Centre,  
41 Gortnah 1st East,  
Omagh BT78 5LU  
eoghan@eda-architects.com

REVISIONS

REV	DATE	DESCRIPTION	CHK	DRN
P01	21/08/23	ISSUED FOR PLANNING	DC	DG

STATUS

PLANNING
----------

PROJECT  
**SEIUK - CL**

PROJECT ADDRESS  
-

DISCIPLINE  
**CIVIL**

DWG TITLE  
**Storm Water - Longitudinal Section - S22-S14 - 02/03**

DWG NO.  
**S-264-EUR-EXT-ZZ-DR-CS-6332**

STATUS CODE  
**C4**

PROJECT NO. <b>S-264</b>	DATE <b>08/01/23</b>
DRAWN / CHECKED <b>SVM/DC</b>	SCALE NO. <b>1 : 100</b>

REVISION NUMBER  
**P01**

**EUROPLAN GROUP**  
Parkview House, Beechill Office Campus,  
Clonskeagh, Dublin 4, Eire.  
Tel: +353 1 2606578  
staprojectteam@europlanservices.com

ALL DIMENSIONS TO BE CHECKED ON SITE.  
NO DIMENSIONS TO BE SCALED FROM THIS  
DRAWING. DRAWING IS TO BE READ IN  
CONJUNCTION WITH RELEVANT  
CONSULTANTS DRAWINGS.

SITE KEY PLAN

LEGEND

**SUMITOMO ELECTRIC** STA CABLE FACTORY  
NIGG, TAIN IV19 1QU

**eda** ARCHITECTS  
EDA Architects Ltd  
Omagh Enterprise Centre,  
41 Gortnah 1st East,  
Omagh BT78 5LU  
eoghan@eda-architects.com

REVISIONS

NO.	DATE	DESCRIPTION	CHK	DRN

P01	21/08/23	ISSUED FOR PLANNING	DC	DG
REV	DATE	DESCRIPTION	CHK	DRN

STATUS: **PLANNING**

PROJECT: **SEIUK - CL**

PROJECT ADDRESS: -

DISCIPLINE: **CIVIL**

DWG TITLE: **Storm Water - Longitudinal Section - S22-S14 - 03/03**


DWG NO.: **S-264-EUR-EXT-ZZ-DR-CS-6333**

STATUS CODE: **C4**

PROJECT NO.: **S-264** DATE: **08/01/23**

DRAWN / CHECKED: **SVM/DC** SCALE NO.: **1:100**


**P01** **EUROPLAN GROUP**  
Parkview House, Beechill Office Campus,  
Clonskeagh, Dublin 4, Eire.  
Tel: +353 1 2606578  
staprojectteam@europlanservices.com

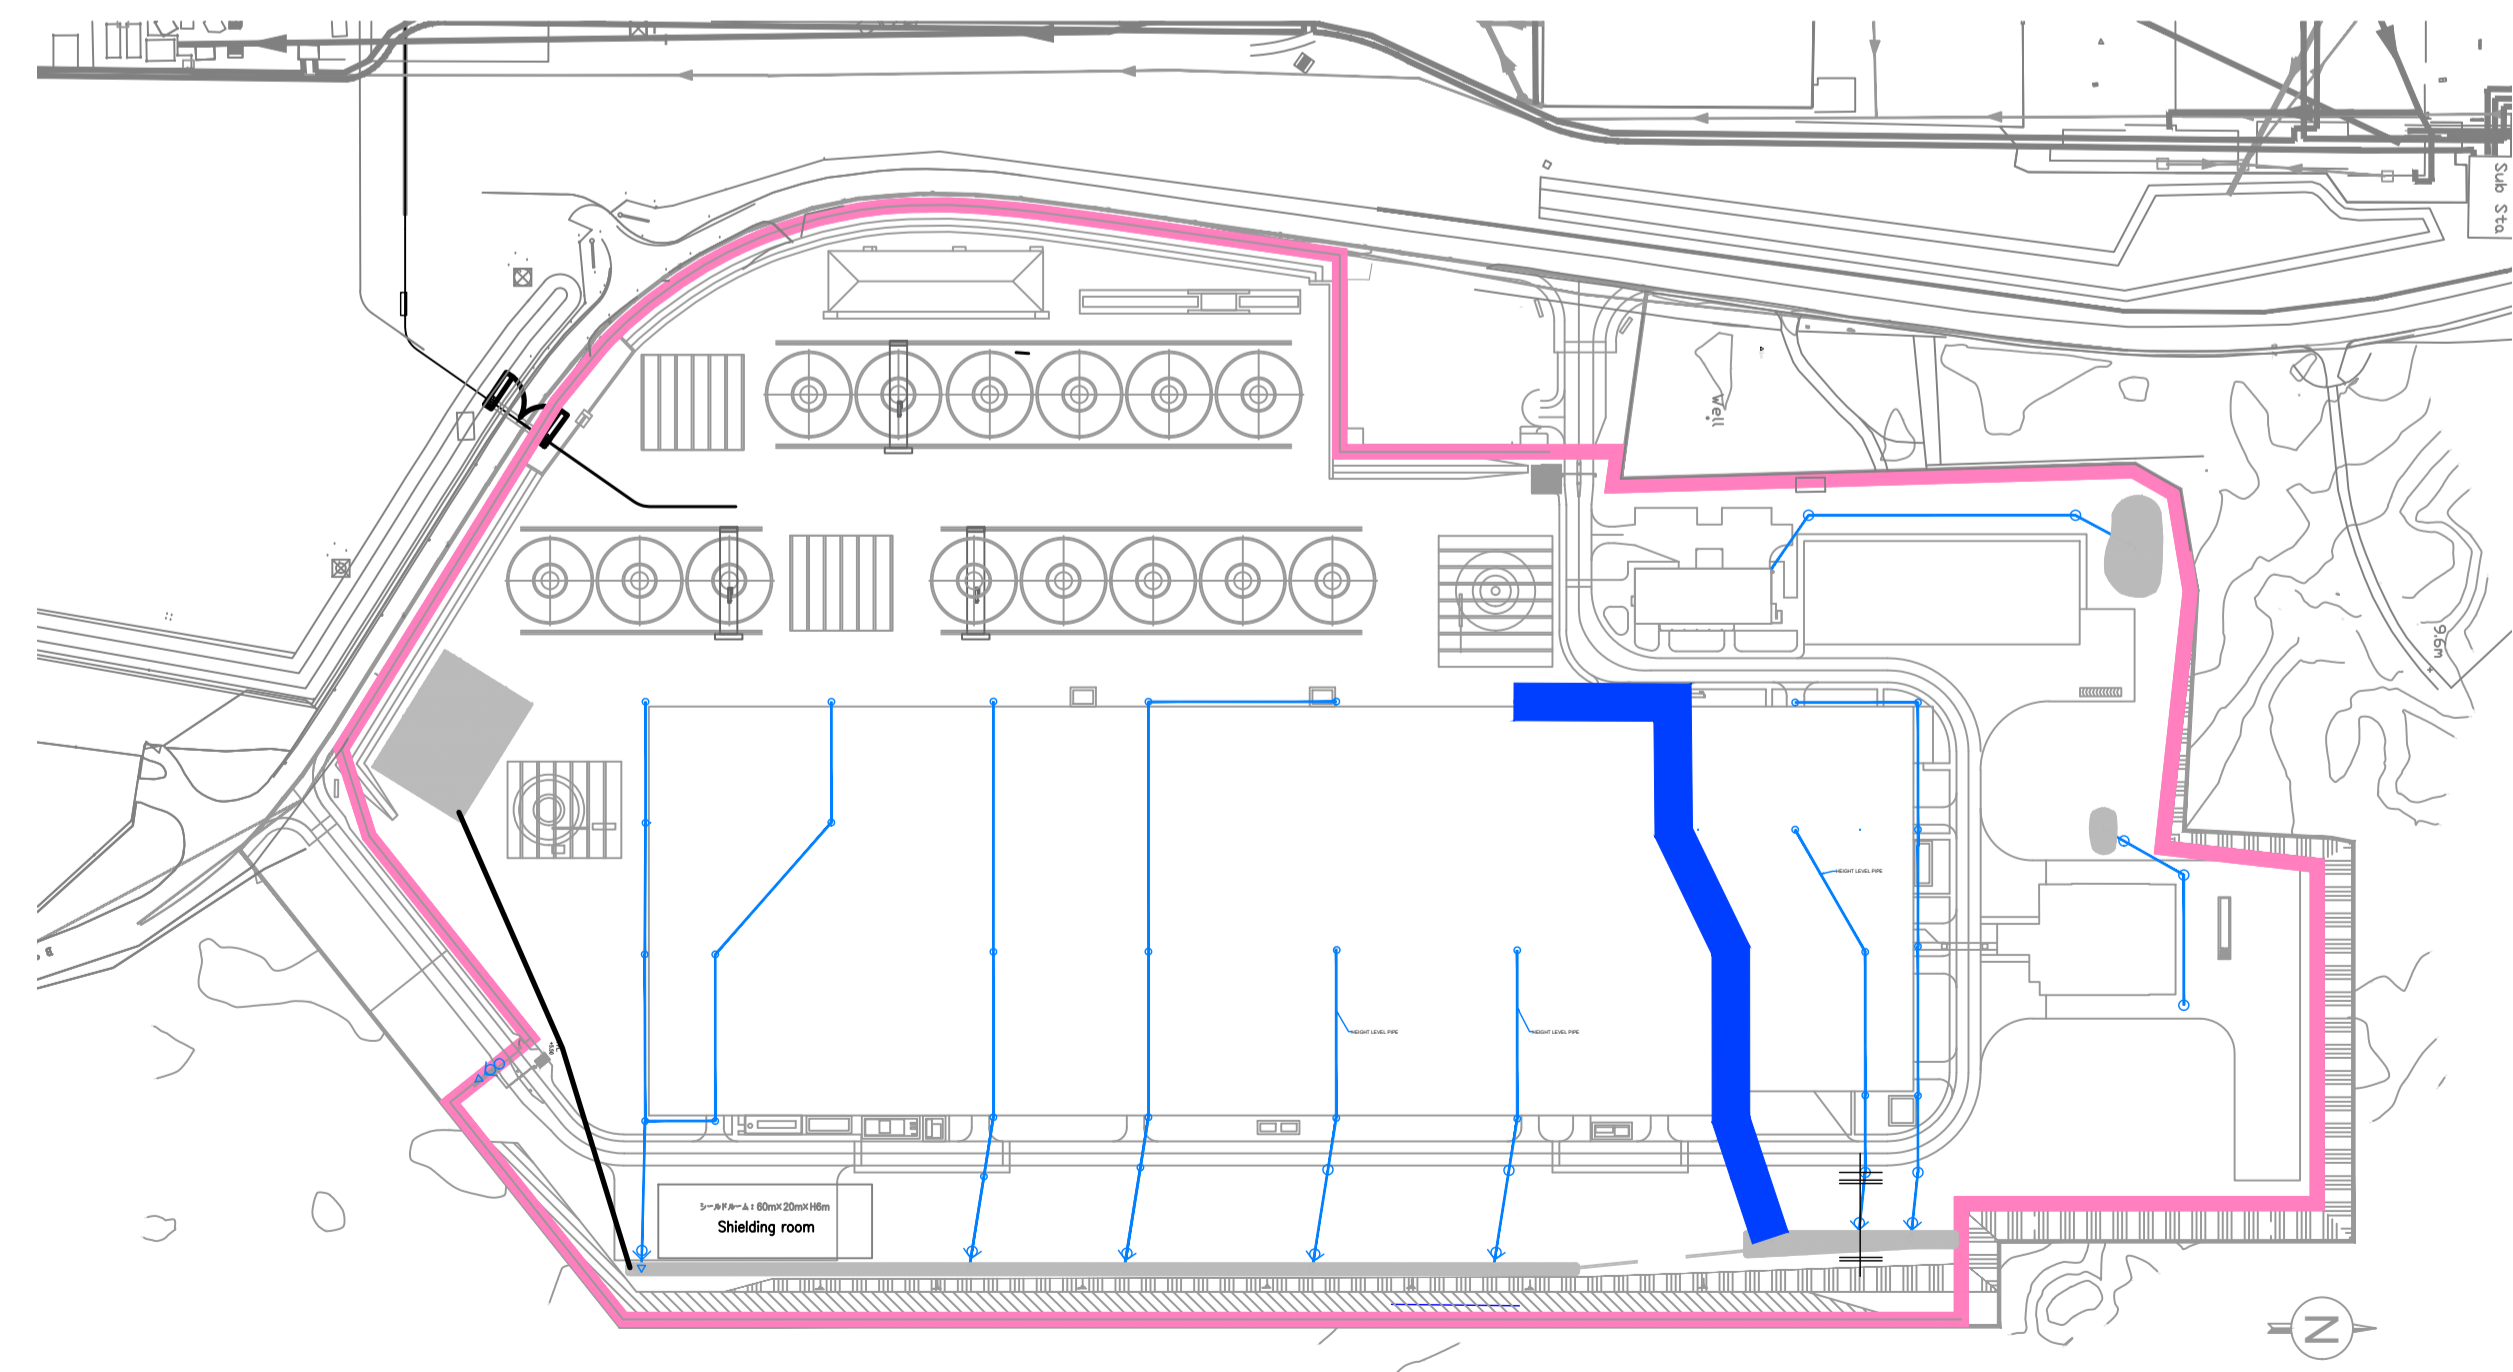



KEYPLAN

ALL DIMENSIONS TO BE CHECKED ON SITE.  
NO DIMENSIONS TO BE SCALED FROM THIS  
DRAWING. DRAWING IS TO BE READ IN  
CONJUNCTION WITH RELEVANT  
CONSULTANTS DRAWINGS.

SITE KEY PLAN

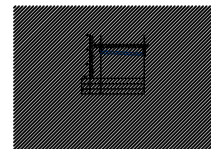

LEGEND

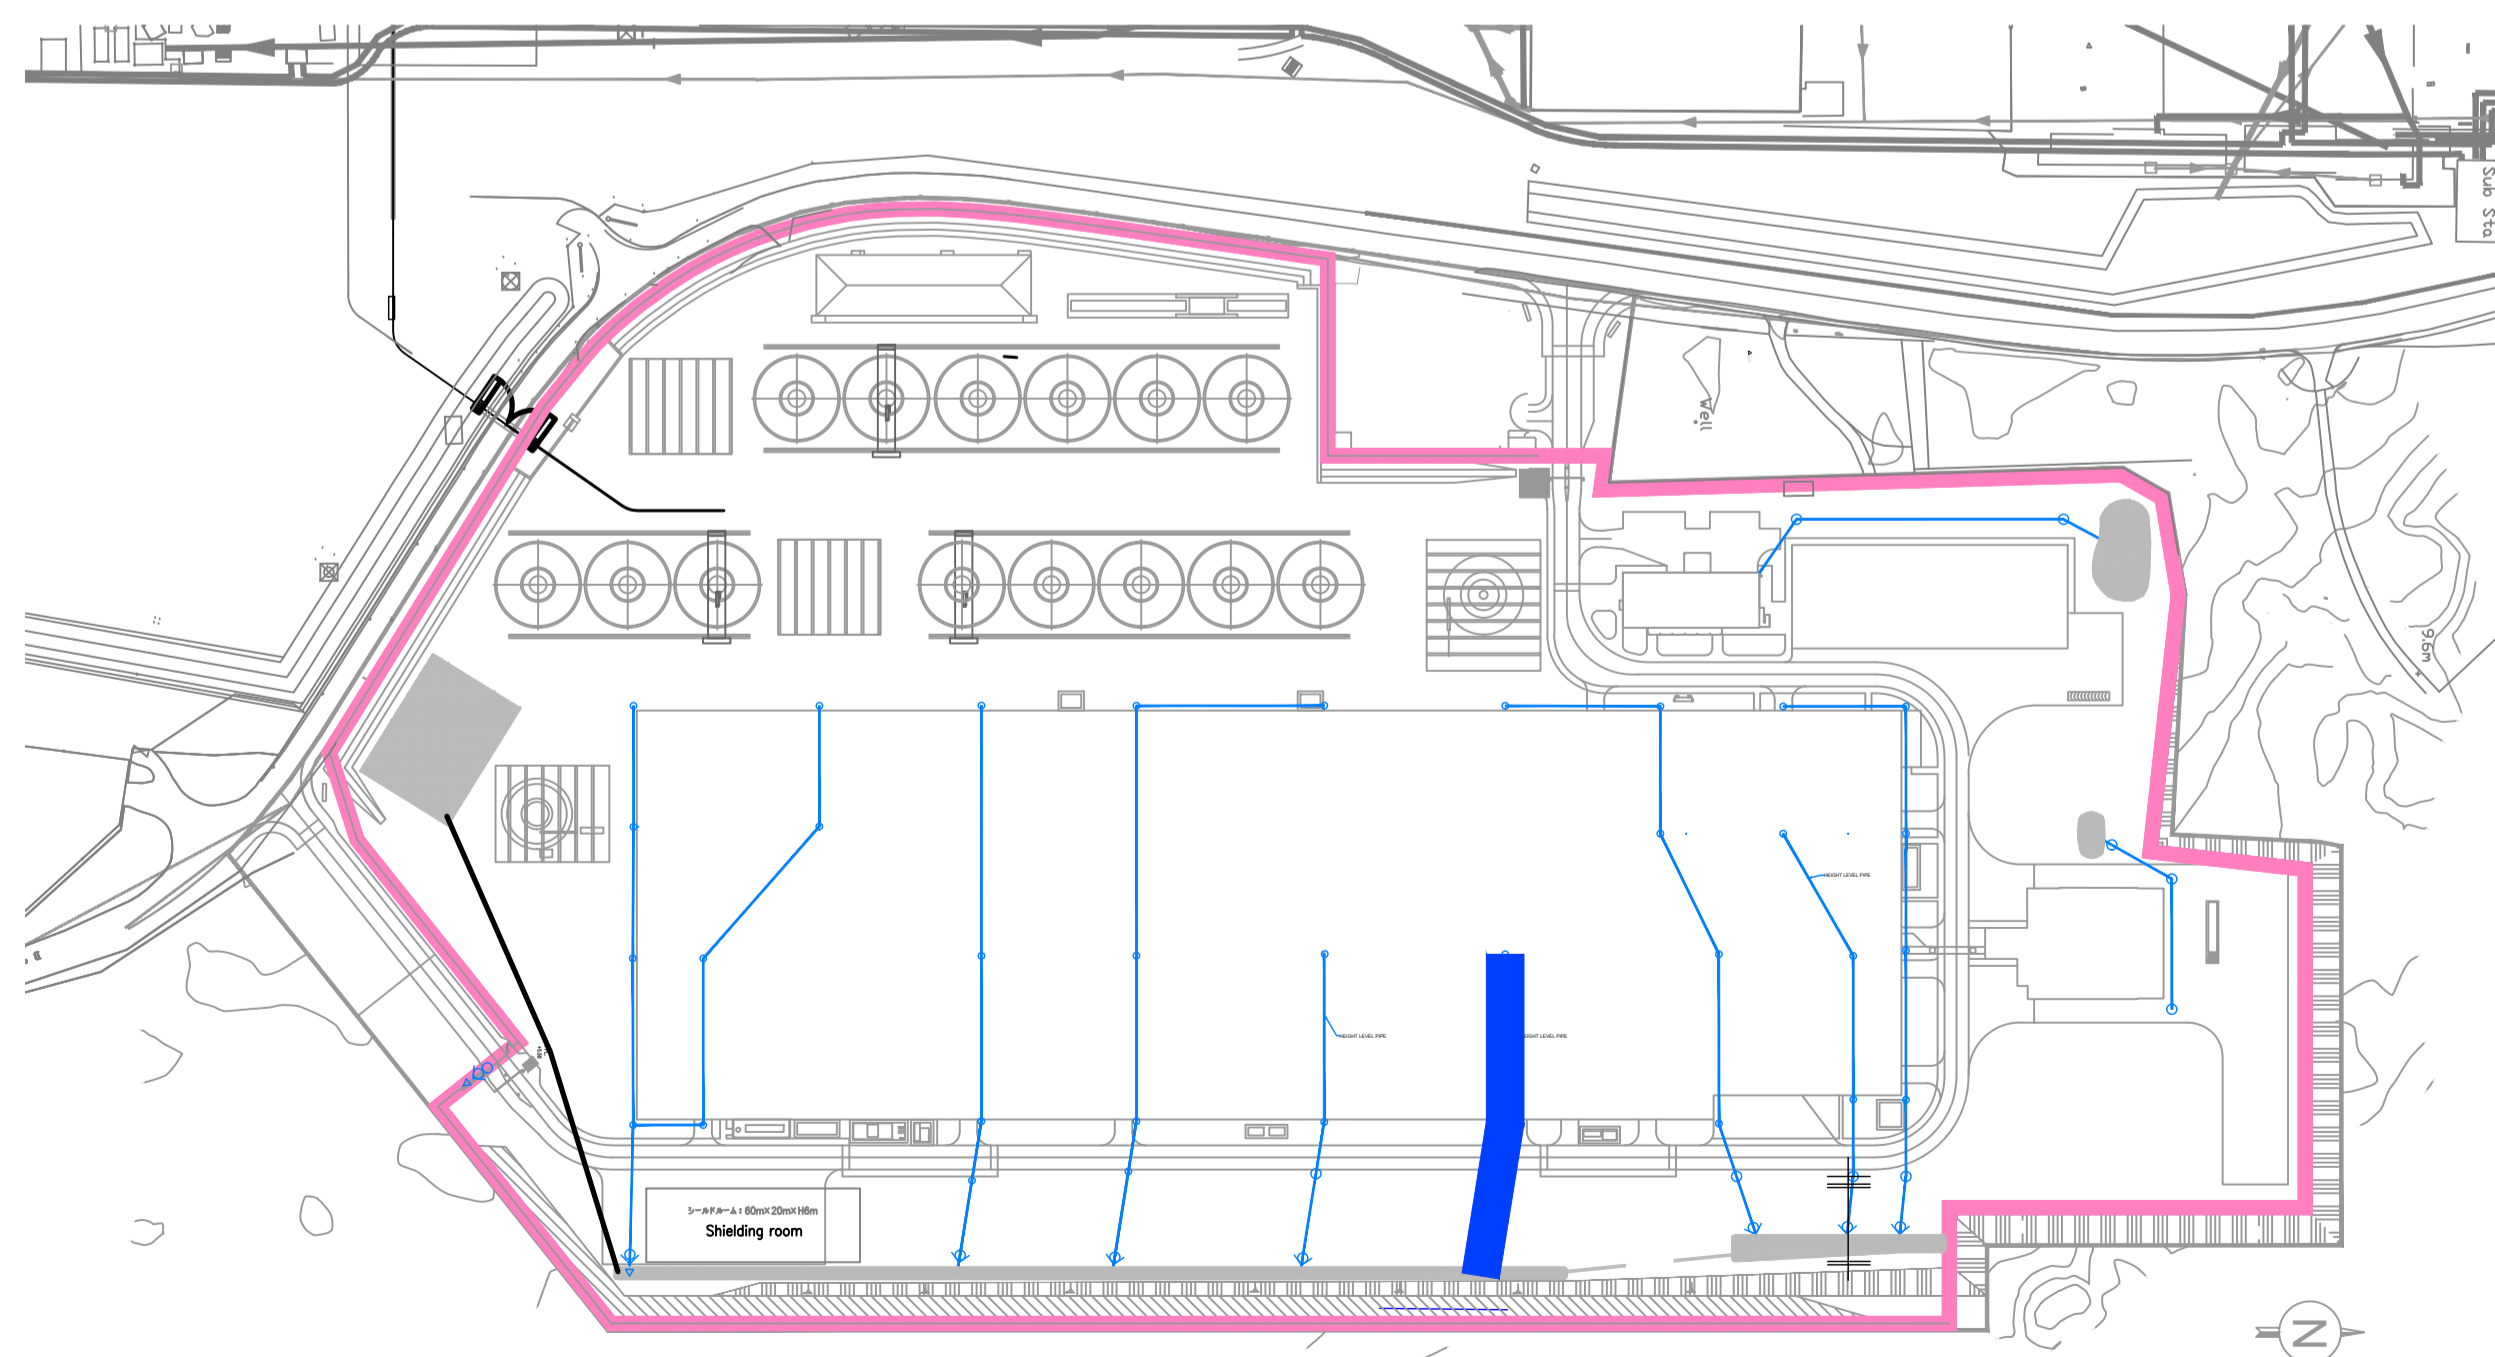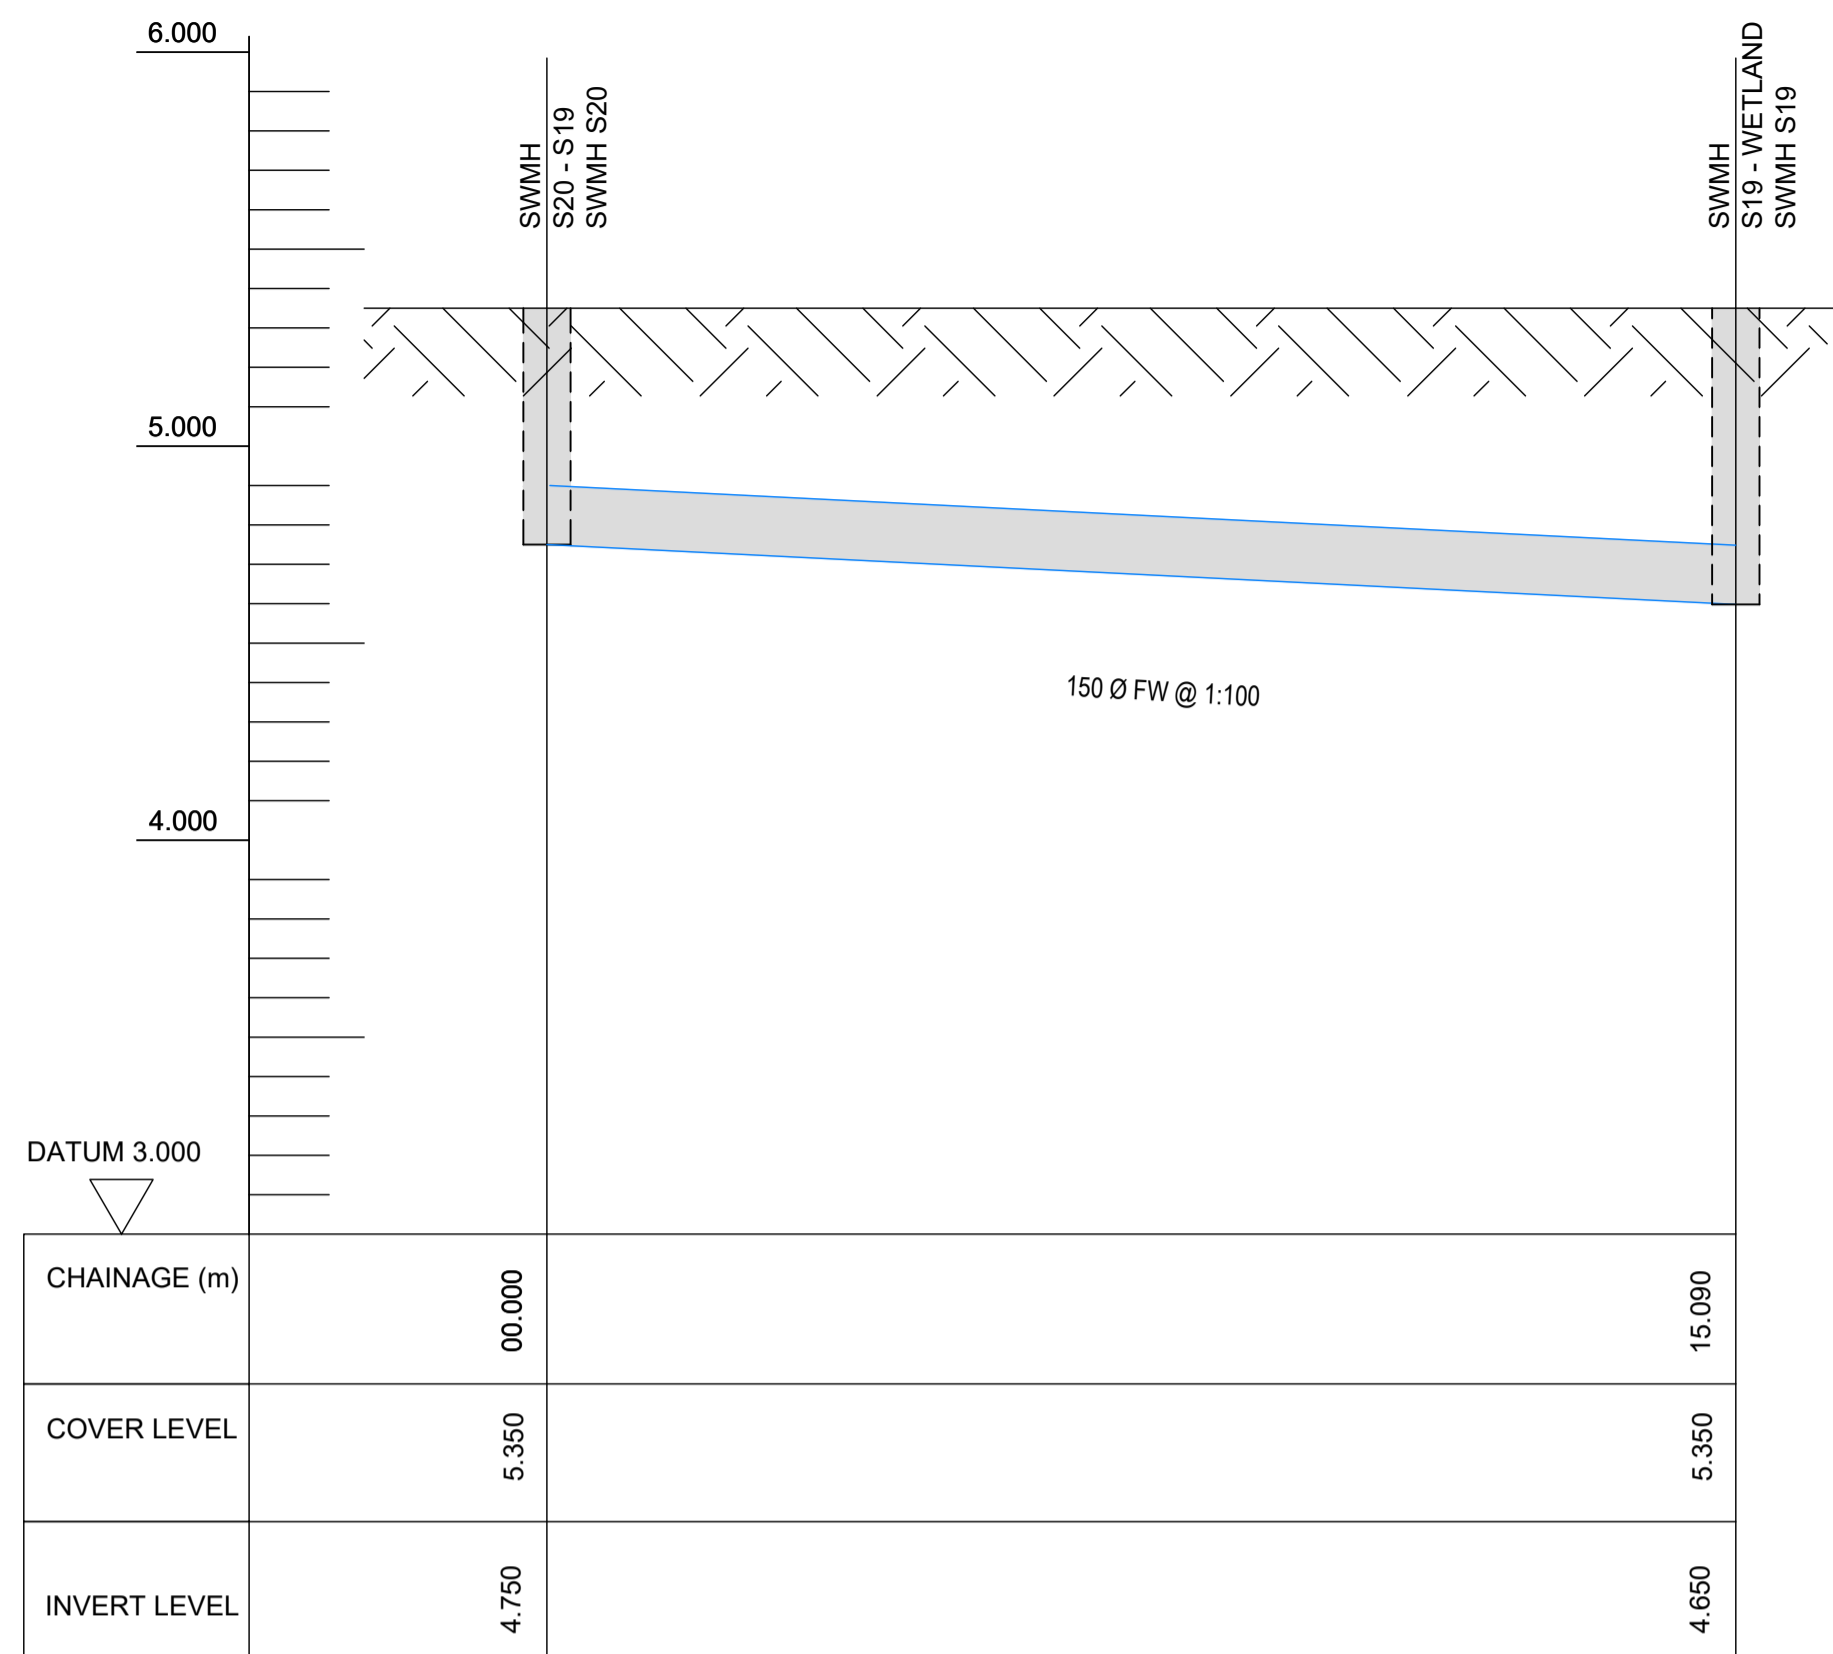

KEYPLAN

**SUMITOMO ELECTRIC** STA CABLE FACTORY  
NIGG, TAIN IV19 1QU

**eda** ARCHITECTS  
EDA Architects Ltd  
Omagh Enterprise Centre,  
41 Gortnah 1st East,  
Omagh BT78 5LU  
eoghan@eda-architects.com

REVISIONS

REV	DATE	DESCRIPTION	CHK	DRN
P01	21/08/23	ISSUED FOR PLANNING	DC	DG

STATUS: PLANNING

PROJECT: SEIUK - CL

PROJECT ADDRESS: -

DISCIPLINE: CIVIL

DWG TITLE: Storm Water - Longitudinal Section - S20-S19

DWG NO.: S-264-EUR-EXT-ZZ-DR-CS-6334

STATUS CODE: C4

PROJECT NO.: S-264 DATE: 08/01/23

DRAWN / CHECKED: SVM/DC SCALE NO.: 1:100

REVISION NUMBER


P01

**EUROPLAN GROUP**



Parkview House, Beechill Office Campus,  
Clonskeagh, Dublin 4, Eire.  
Tel: +353 1 2606578  
staprojectteam@europlanservices.com

ALL DIMENSIONS TO BE CHECKED ON SITE.  
NO DIMENSIONS TO BE SCALED FROM THIS  
DRAWING. DRAWING IS TO BE READ IN  
CONJUNCTION WITH RELEVANT  
CONSULTANTS DRAWINGS.


SITE KEY PLAN

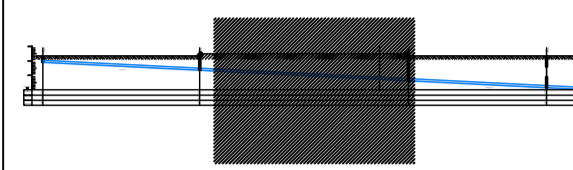

LEGEND

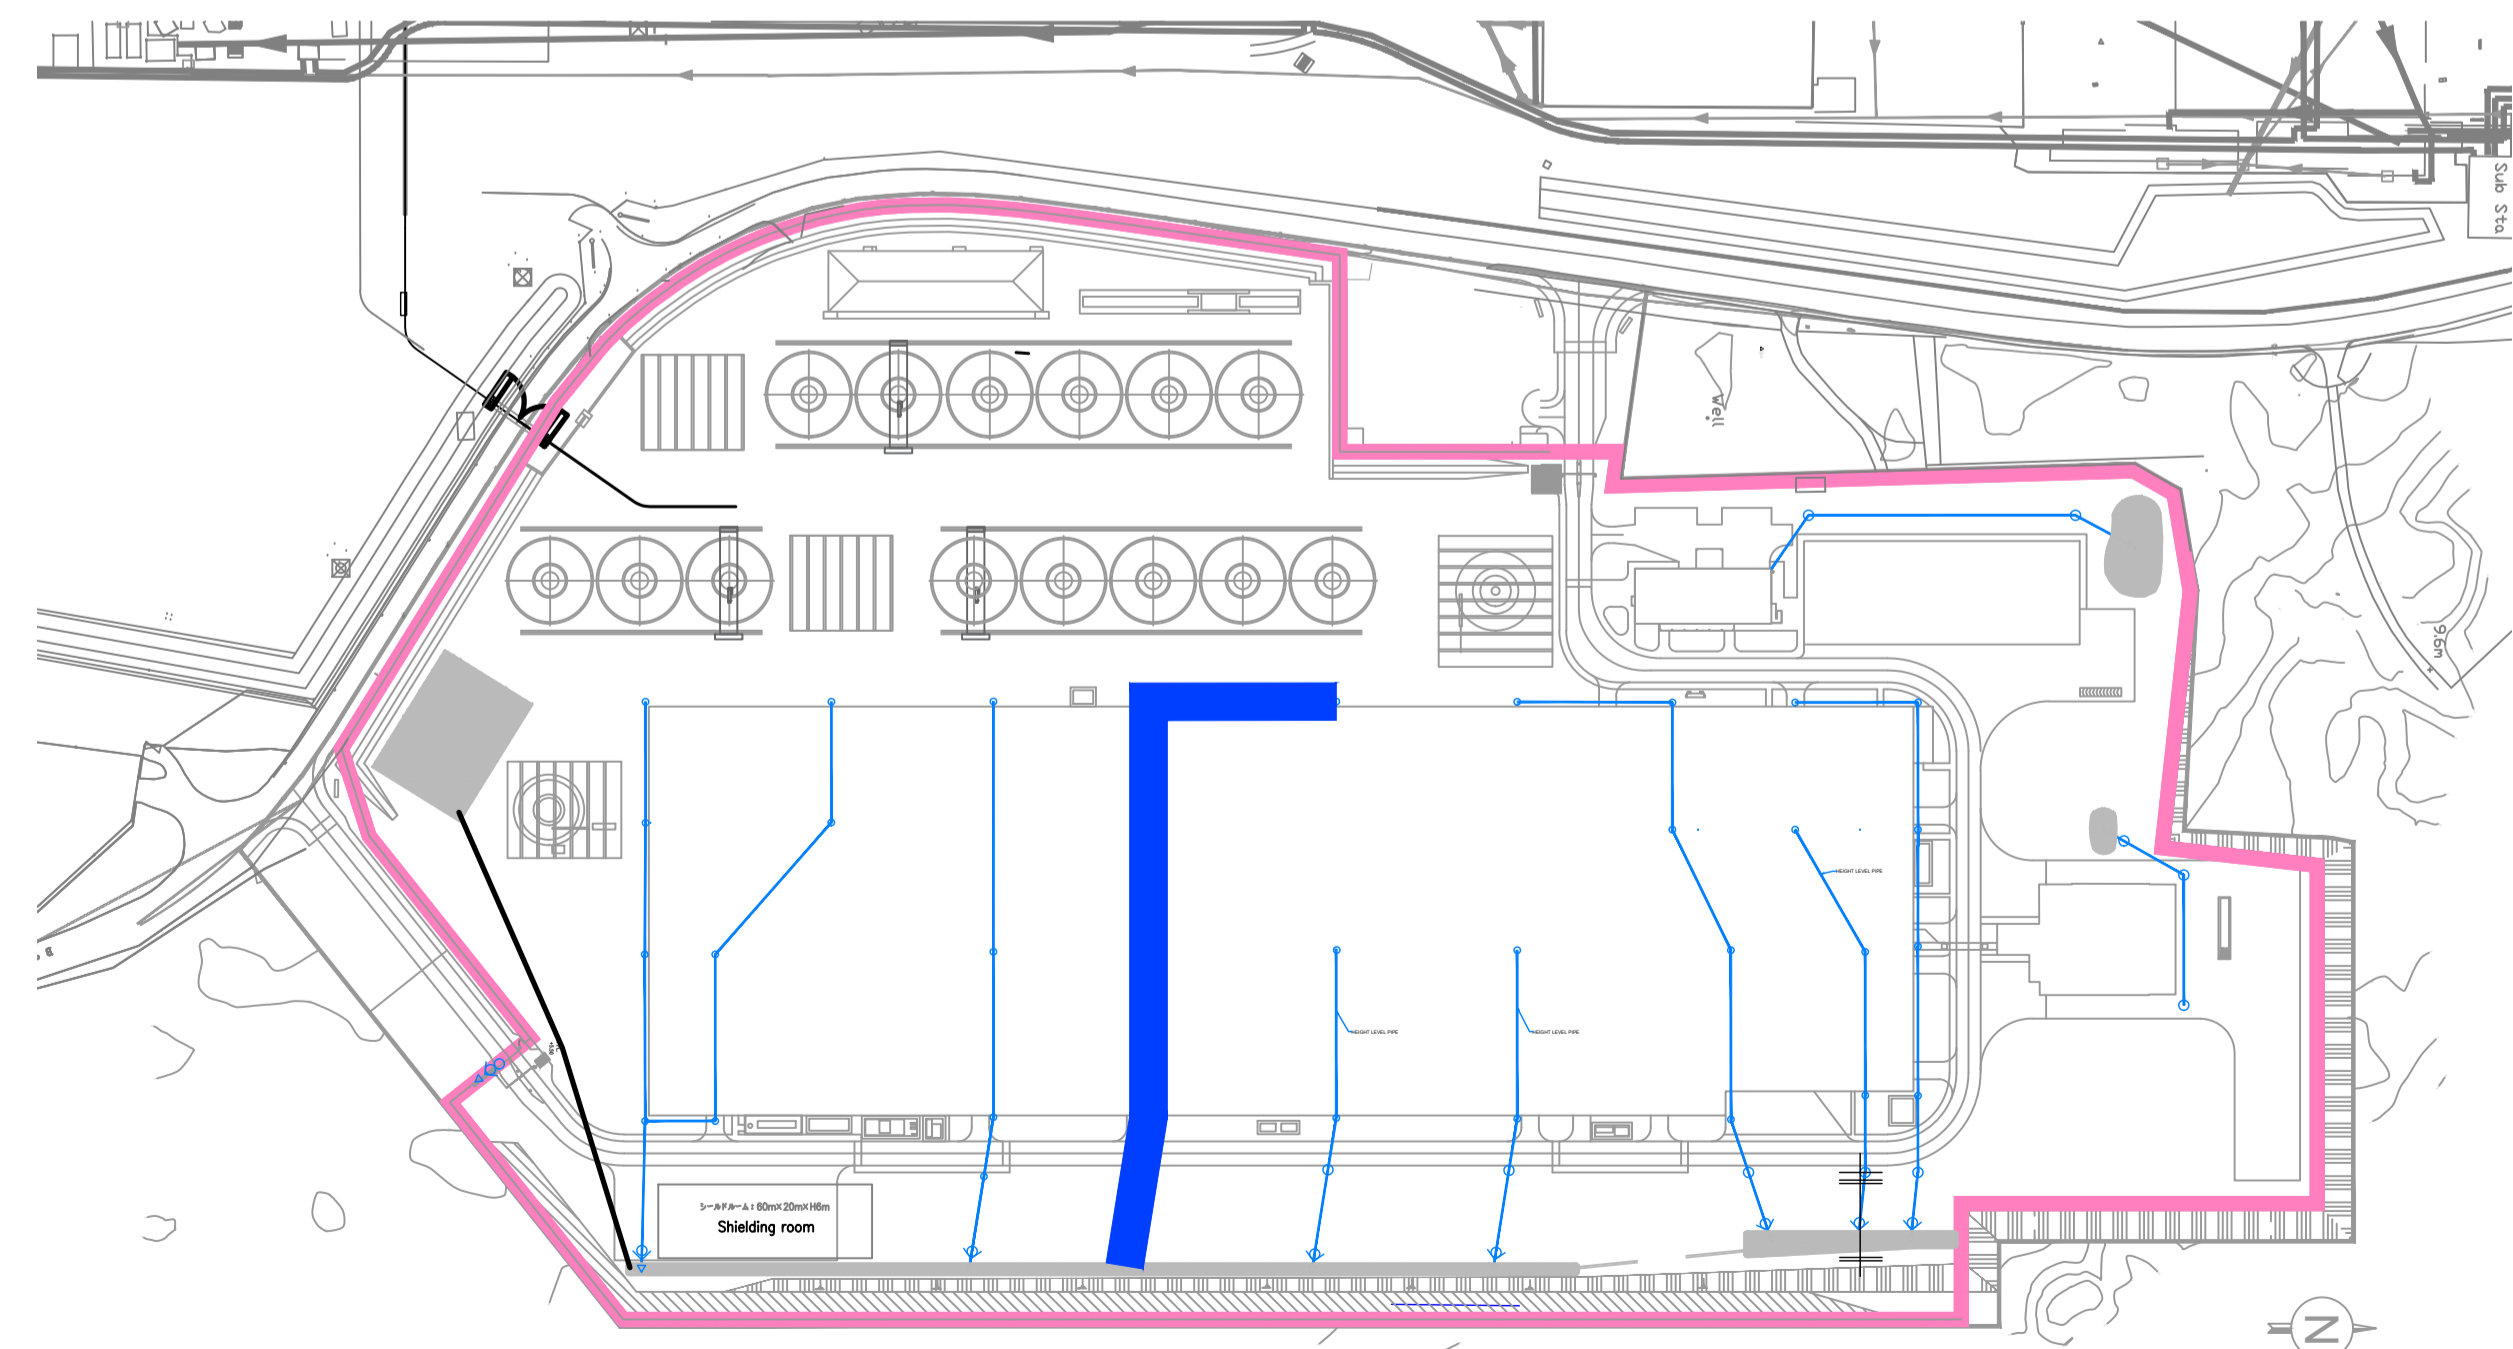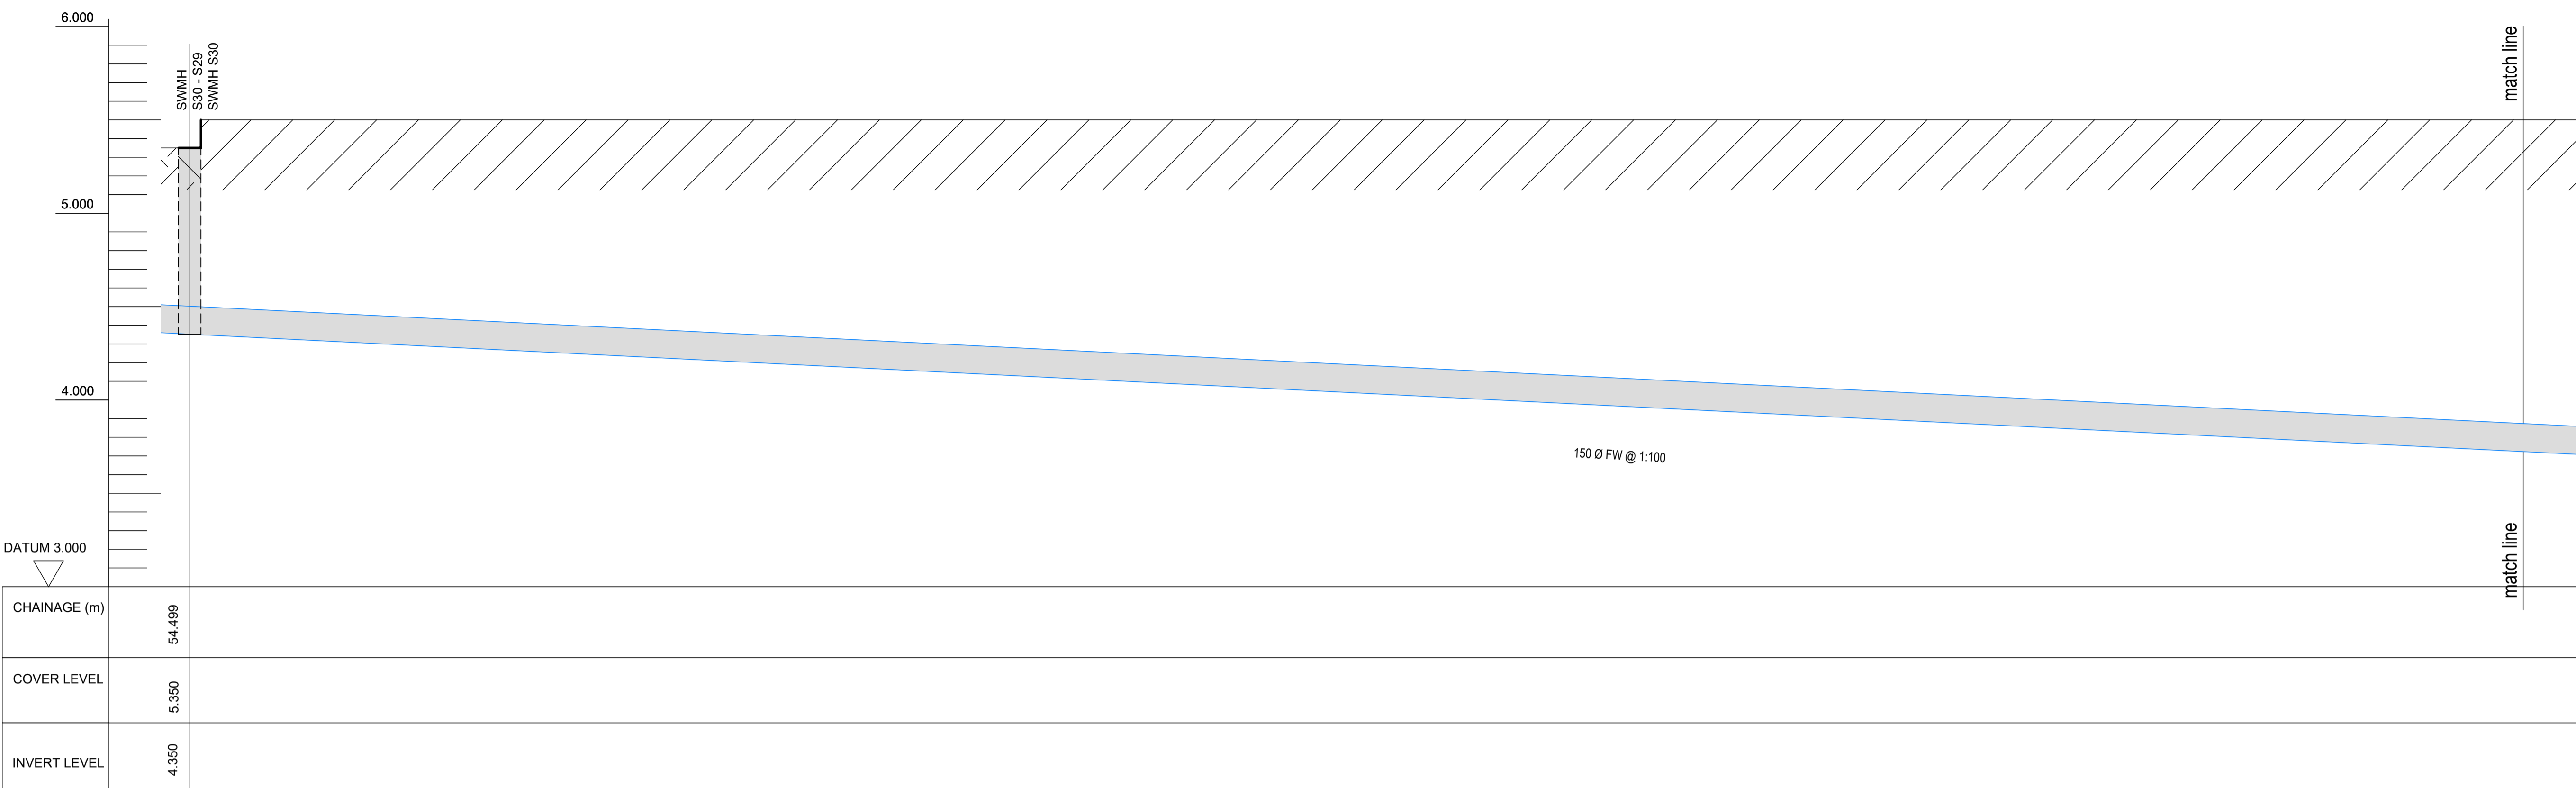

KEYPLAN

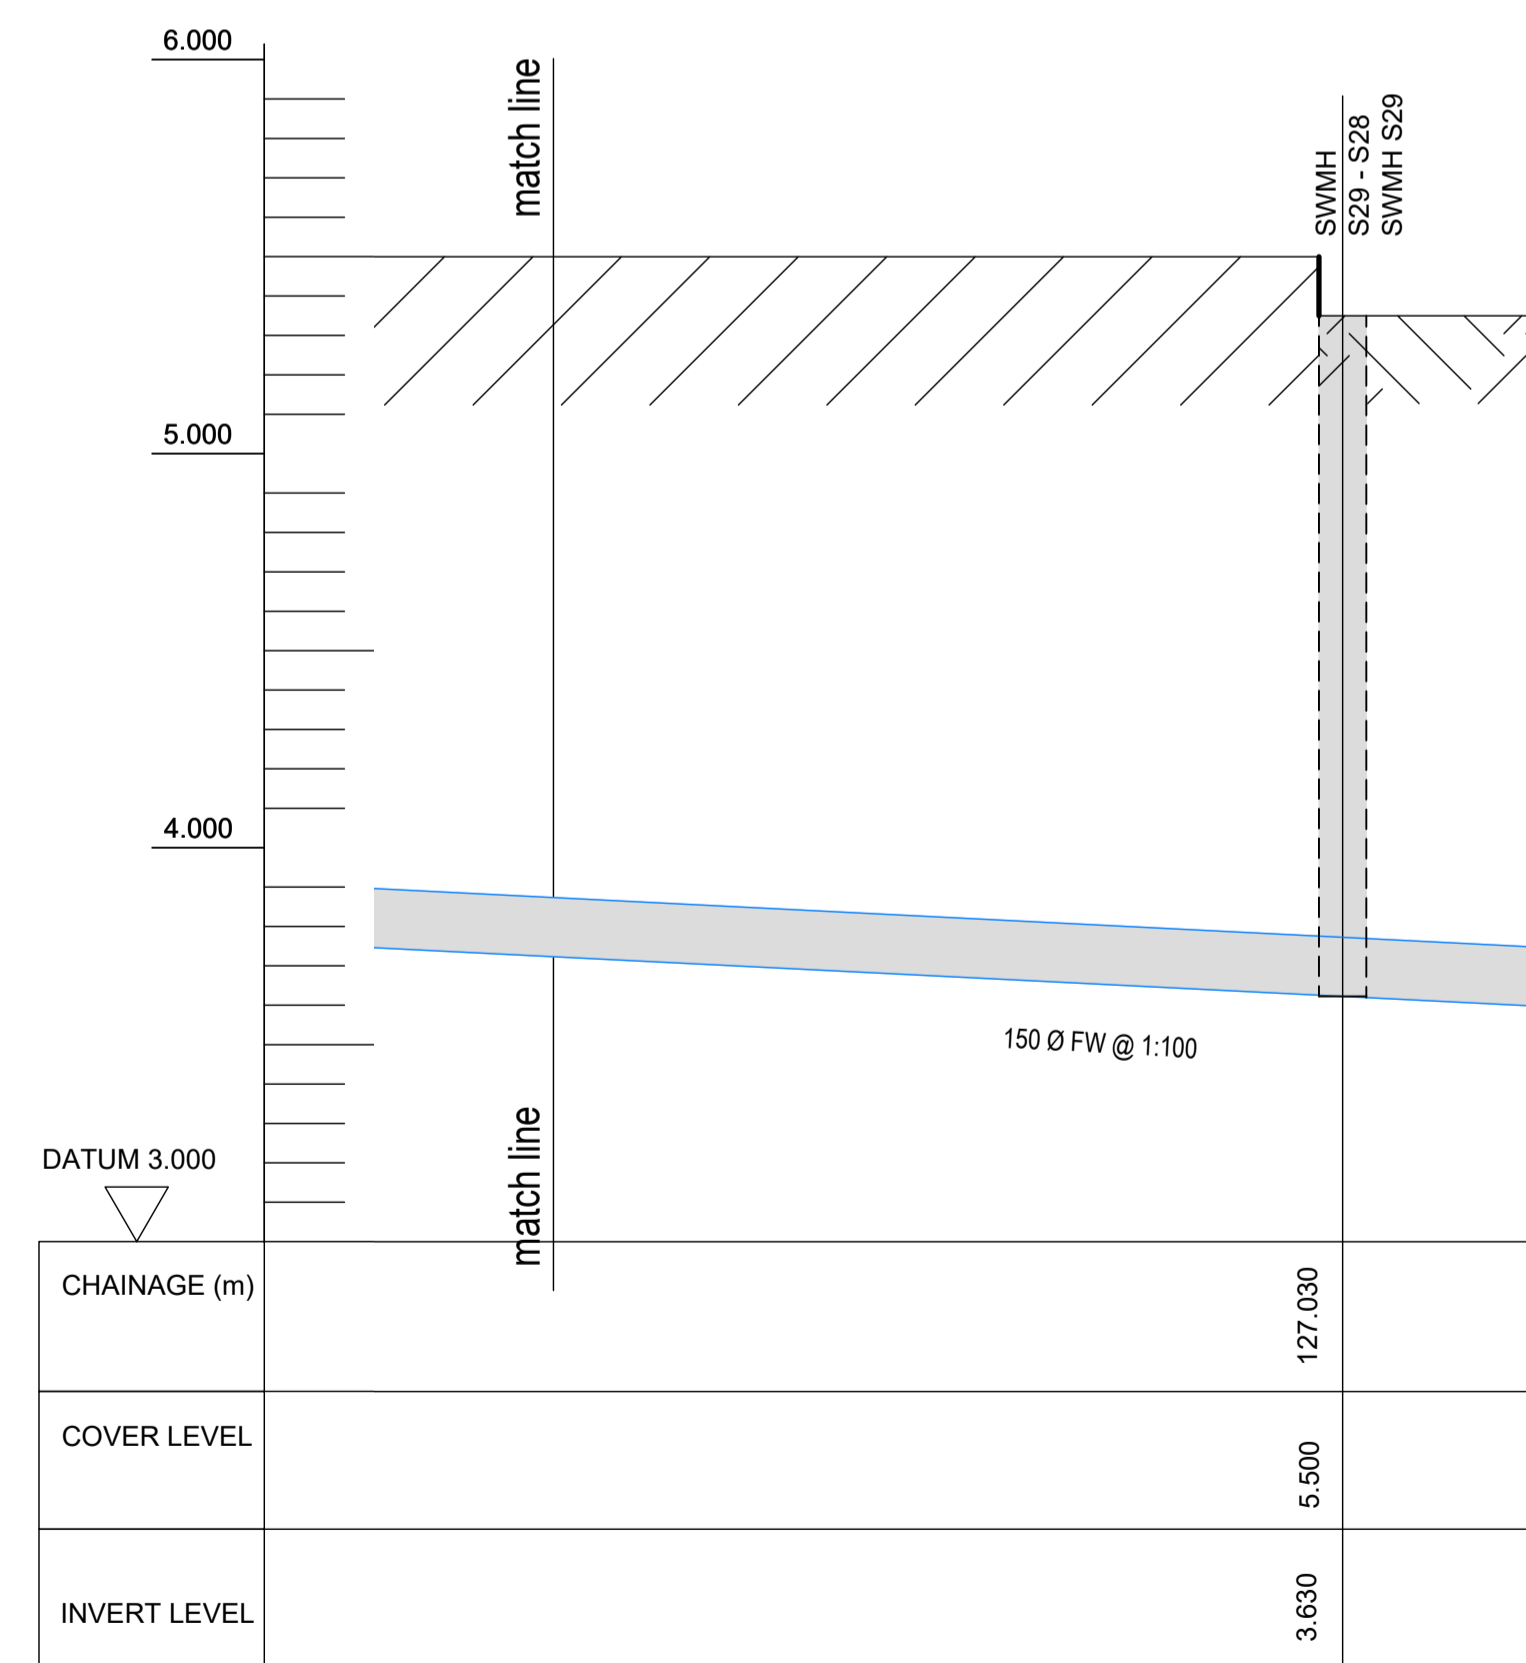

**SUMITOMO ELECTRIC** STA CABLE FACTORY  
NIGG, TAIN IV19 1QU

**eda** ARCHITECTS  
EDA Architects Ltd  
Omagh Enterprise Centre,  
41 Gortnah 1st Est.,  
Omagh BT78 5LU  
eoghan@eda-architects.com

REVISIONS

REV	DATE	DESCRIPTION	CHK	DRN
P01	21/08/23	ISSUED FOR PLANNING	DC	DG

STATUS  
**PLANNING**

PROJECT  
**SEIUK - CL**

PROJECT ADDRESS  
-

DISCIPLINE  
**CIVIL**

DWG TITLE  
**Storm Water - Longitudinal Section - S26-S27 - 02/03**

DWG NO.  
**S-264-EUR-EXT-ZZ-DR-CS-6337**

STATUS CODE  
**C4**


PROJECT NO. <b>S-264</b>	DATE <b>08/01/23</b>
DRAWN / CHECKED <b>SVM/DC</b>	SCALE NO. <b>1 : 100</b>

REVISION NUMBER  
**P01**



**EUROPLAN GROUP**  
Parkview House, Beechill Office Campus,  
Clonskeagh, Dublin 4, Eire.  
Tel: +353 1 2606578  
staprojectteam@europlanservices.com

ALL DIMENSIONS TO BE CHECKED ON SITE.  
NO DIMENSIONS TO BE SCALED FROM THIS  
DRAWING. DRAWING IS TO BE READ IN  
CONJUNCTION WITH RELEVANT  
CONSULTANTS DRAWINGS.

SITE KEY PLAN

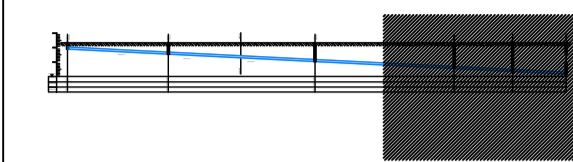

LEGEND

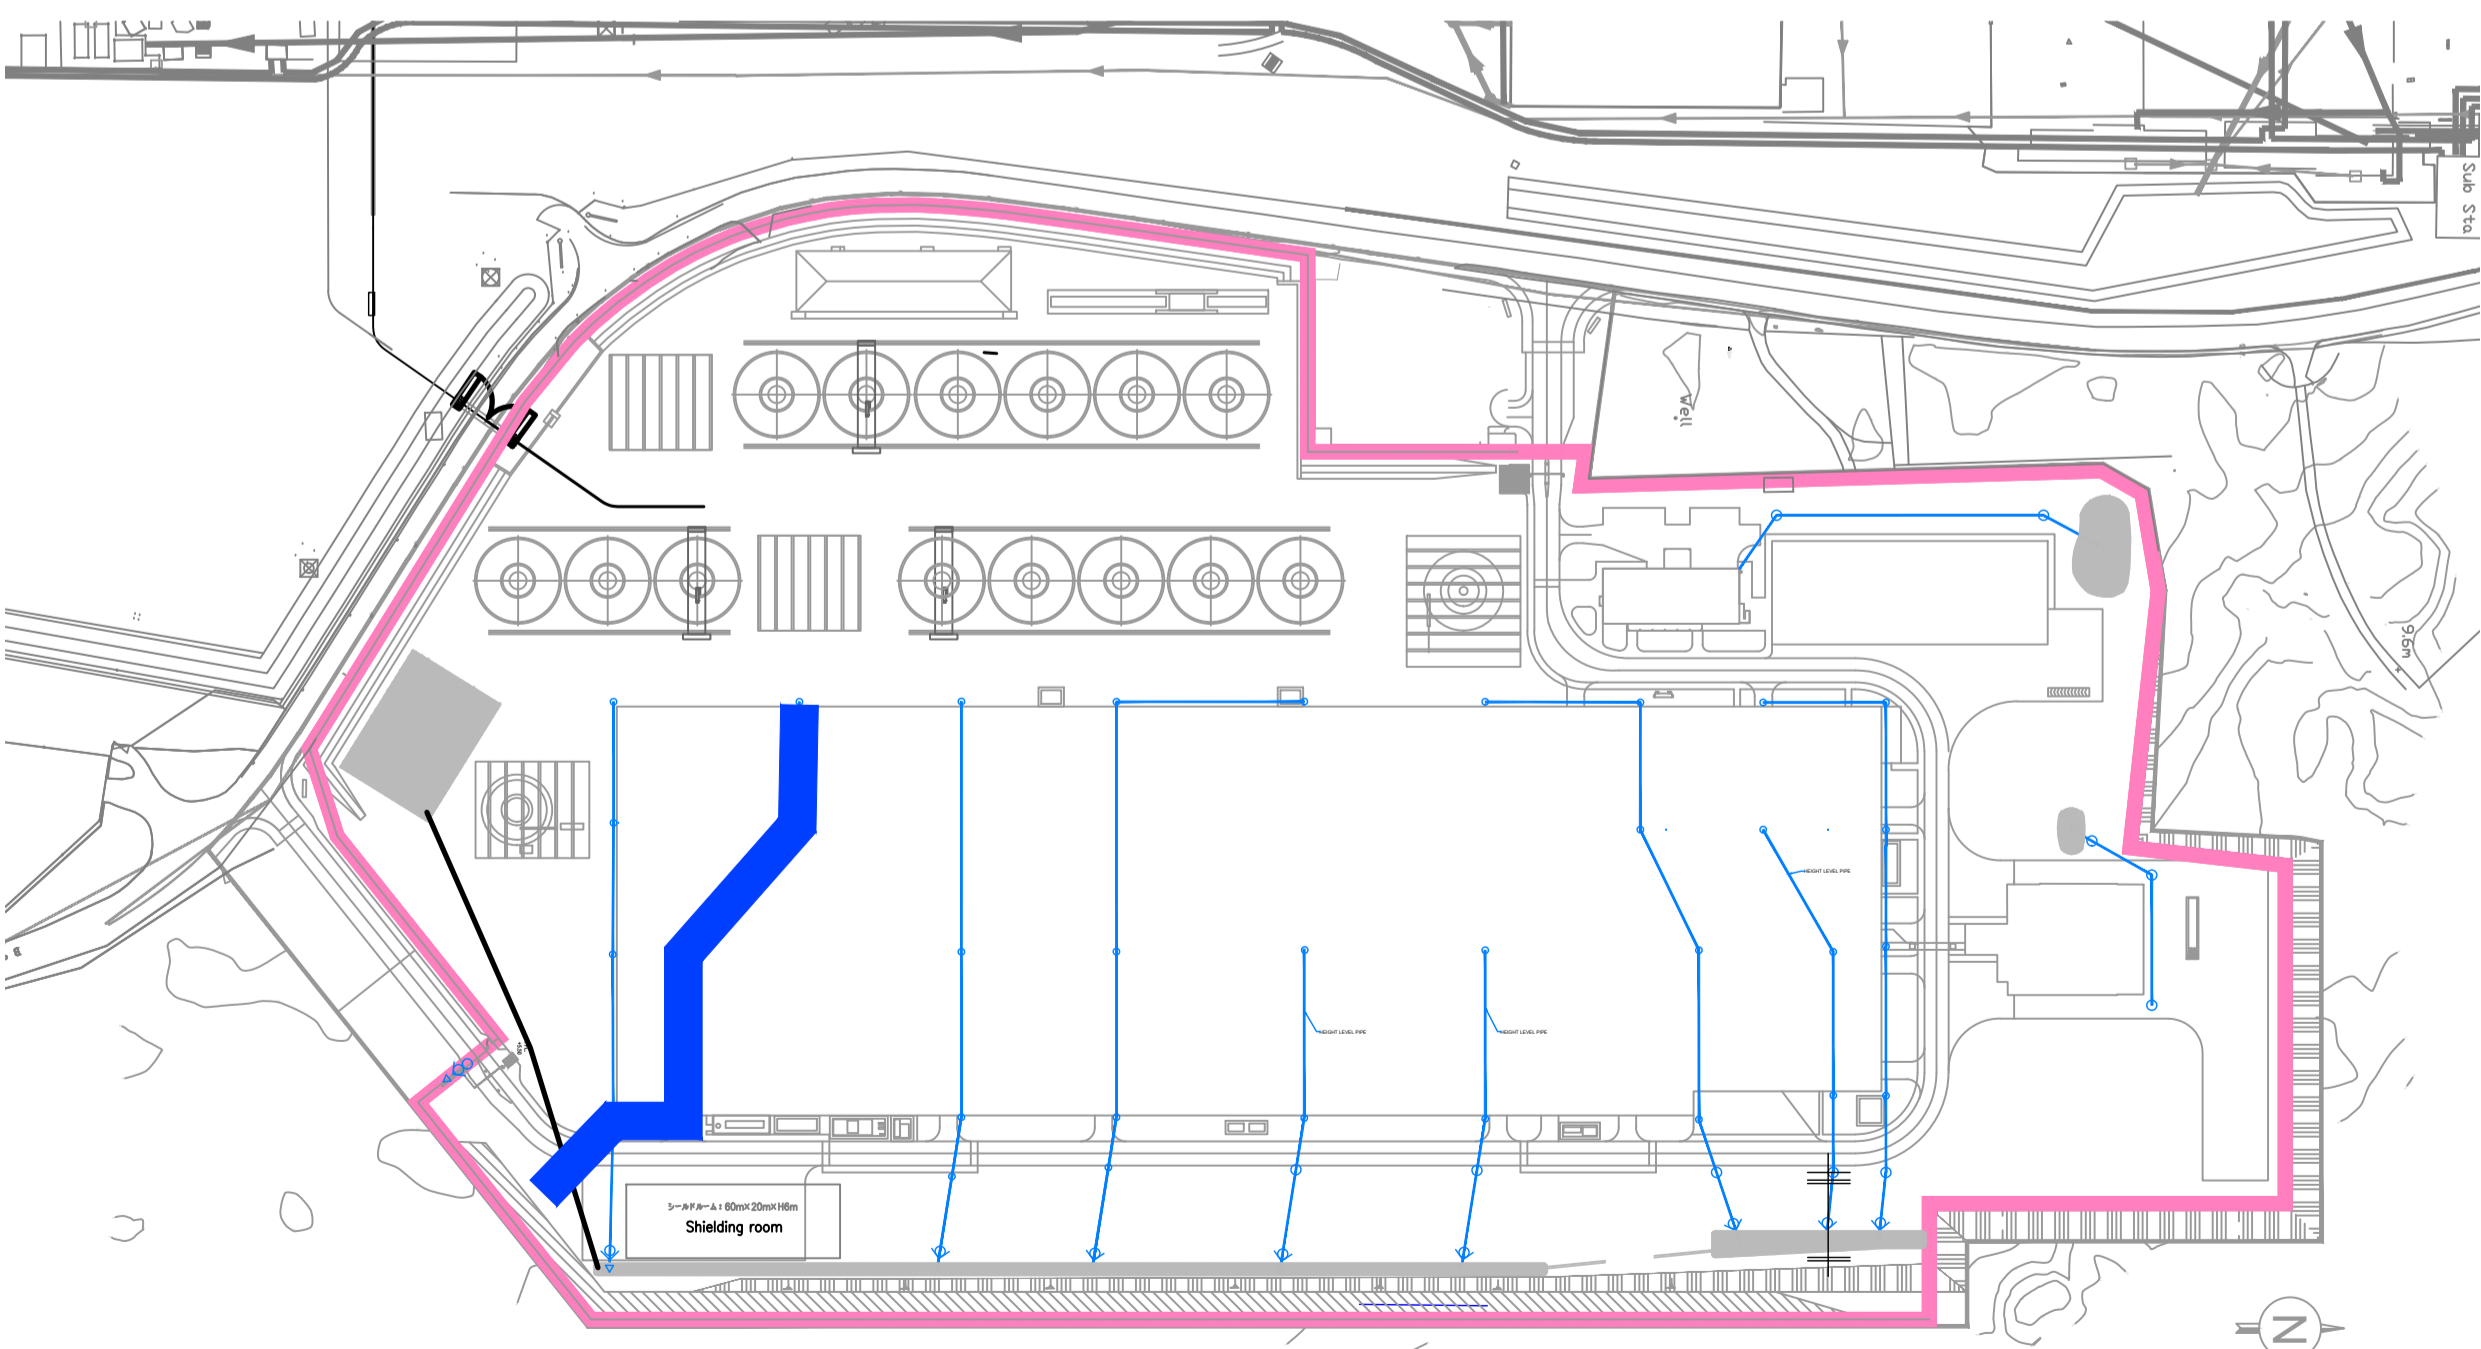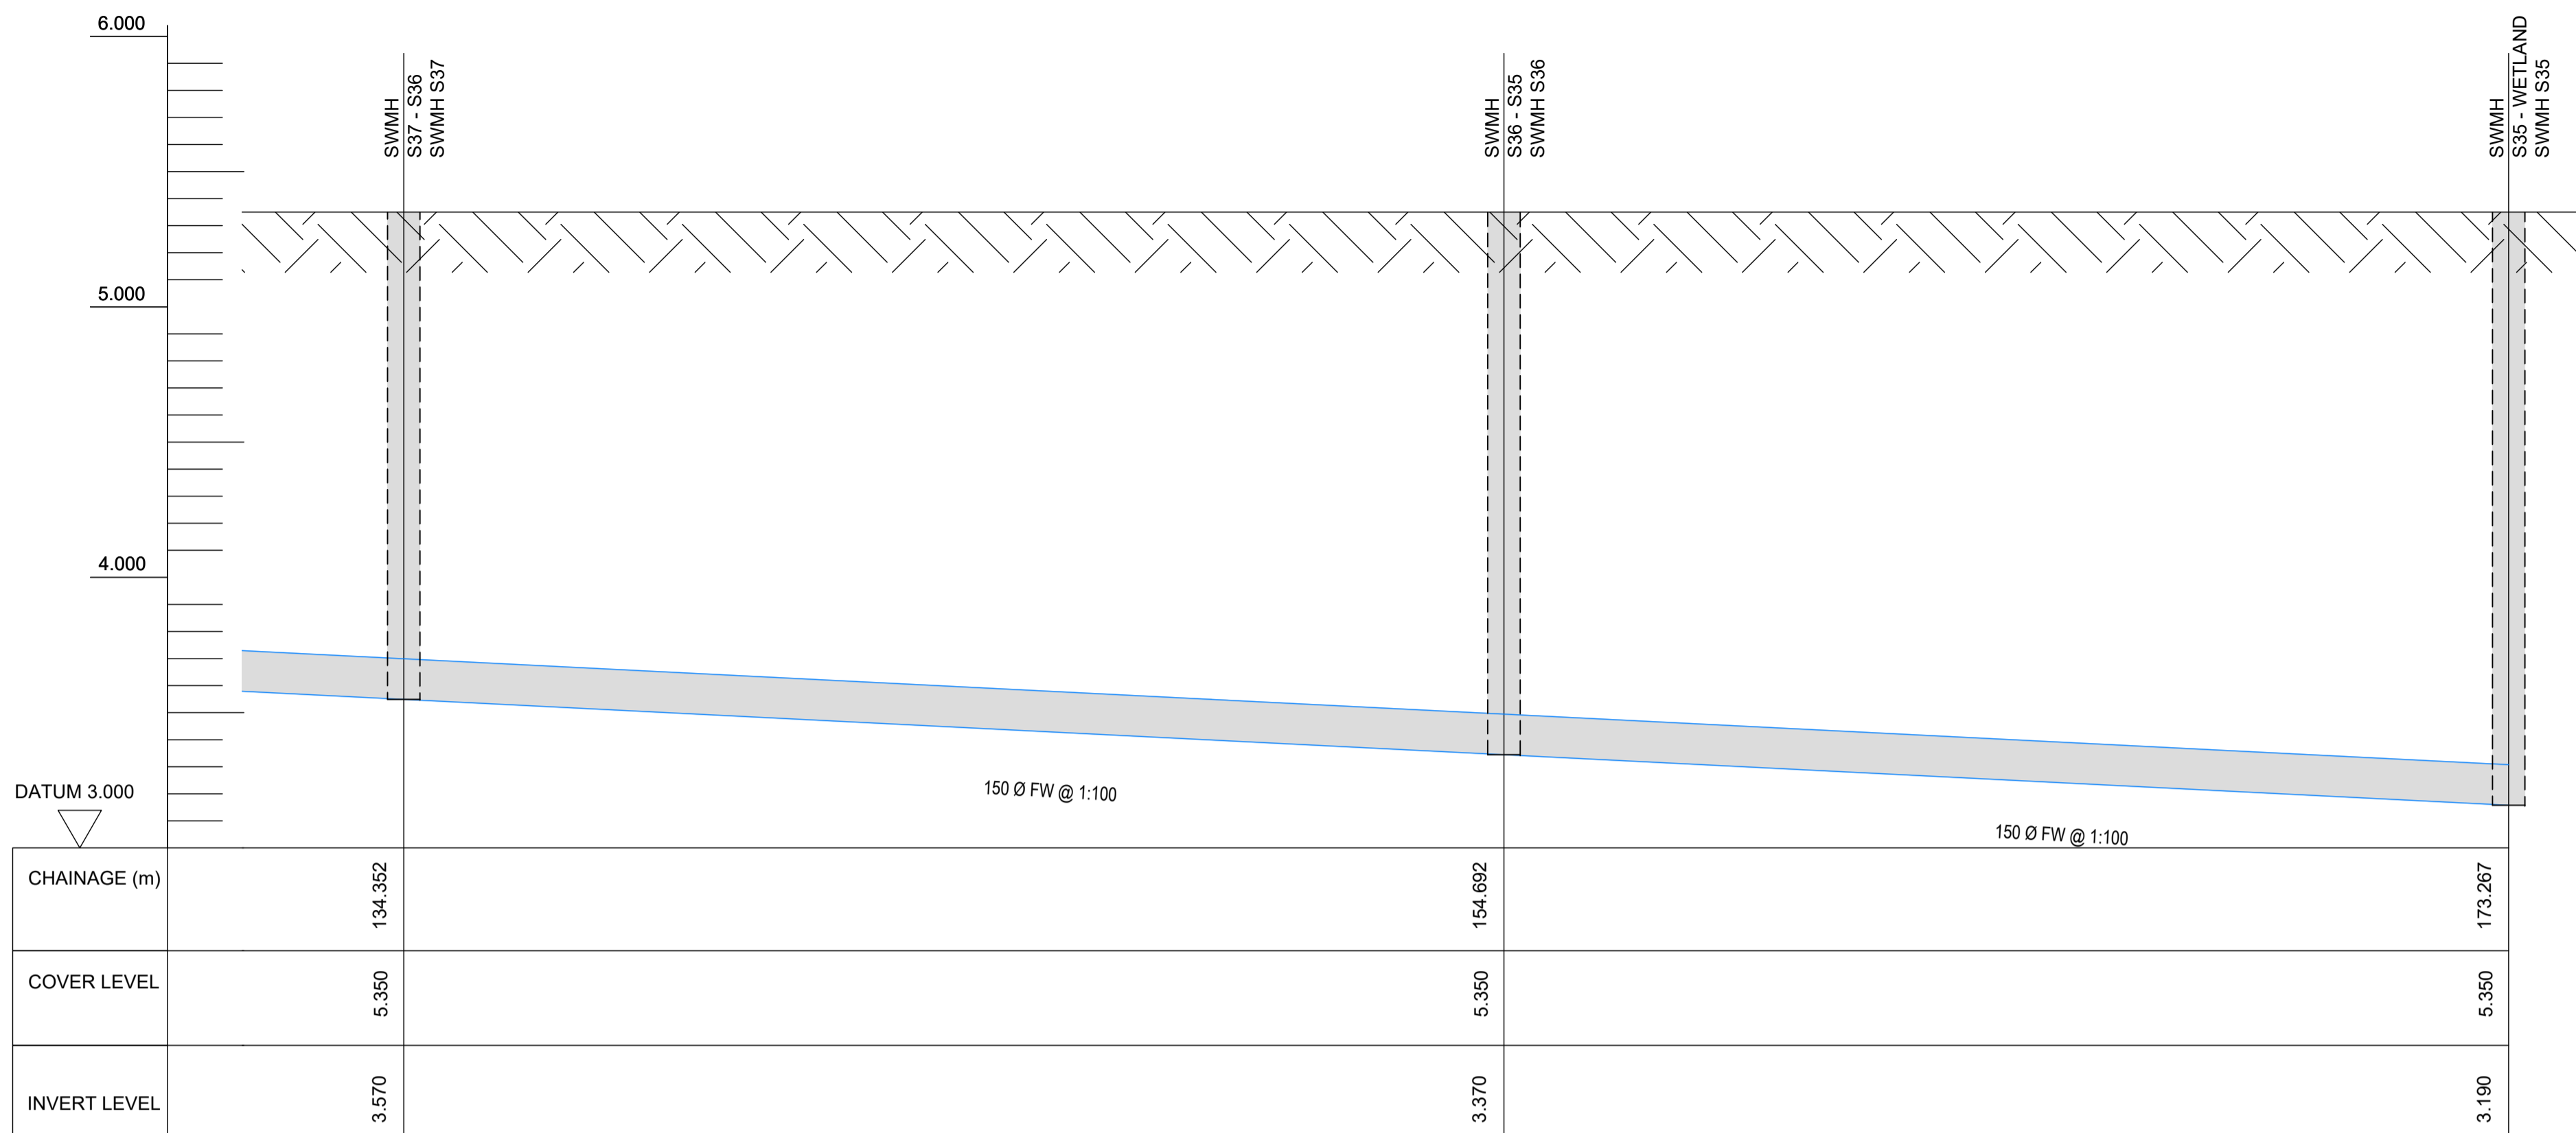

KEYPLAN

**SUMITOMO ELECTRIC** STA CABLE FACTORY  
NIGG, TAIN IV19 1QU

**eda** ARCHITECTS  
EDA Architects Ltd  
Omagh Enterprise Centre,  
41 Gortnah 1st East,  
Omagh BT78 5LU  
eoghan@eda-architects.com

REVISIONS

REV	DATE	DESCRIPTION	CKH	DRN
P01	21/08/23	ISSUED FOR PLANNING	DC	DG

STATUS	PLANNING		
PROJECT	SEIUK - CL		
PROJECT ADDRESS	-		
DISCIPLINE	CIVIL		
DWG TITLE	Storm Water - Longitudinal Section - S40-S35 - 03/03		
DWG NO.	S-264-EUR-EXT-ZZ-DR-CS-6343		
STATUS CODE	C4		
PROJECT NO.	S-264	DATE	08/01/23
DRAWN / CHECKED	SVM/DC	SCALE NO.	1 : 100


REVISION NUMBER

**P01**


**EUROPLAN GROUP**  
Parkview House, Beechill Office Campus,  
Clonskeagh, Dublin 4, Eire.  
Tel: +353 1 2606578  
staprojectteam@europlanservices.com

ALL DIMENSIONS TO BE CHECKED ON SITE.  
NO DIMENSIONS TO BE SCALED FROM THIS  
DRAWING. DRAWING IS TO BE READ IN  
CONJUNCTION WITH RELEVANT  
CONSULTANTS DRAWINGS.


SITE KEY PLAN

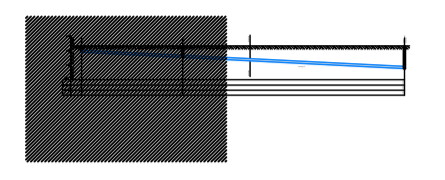

LEGEND

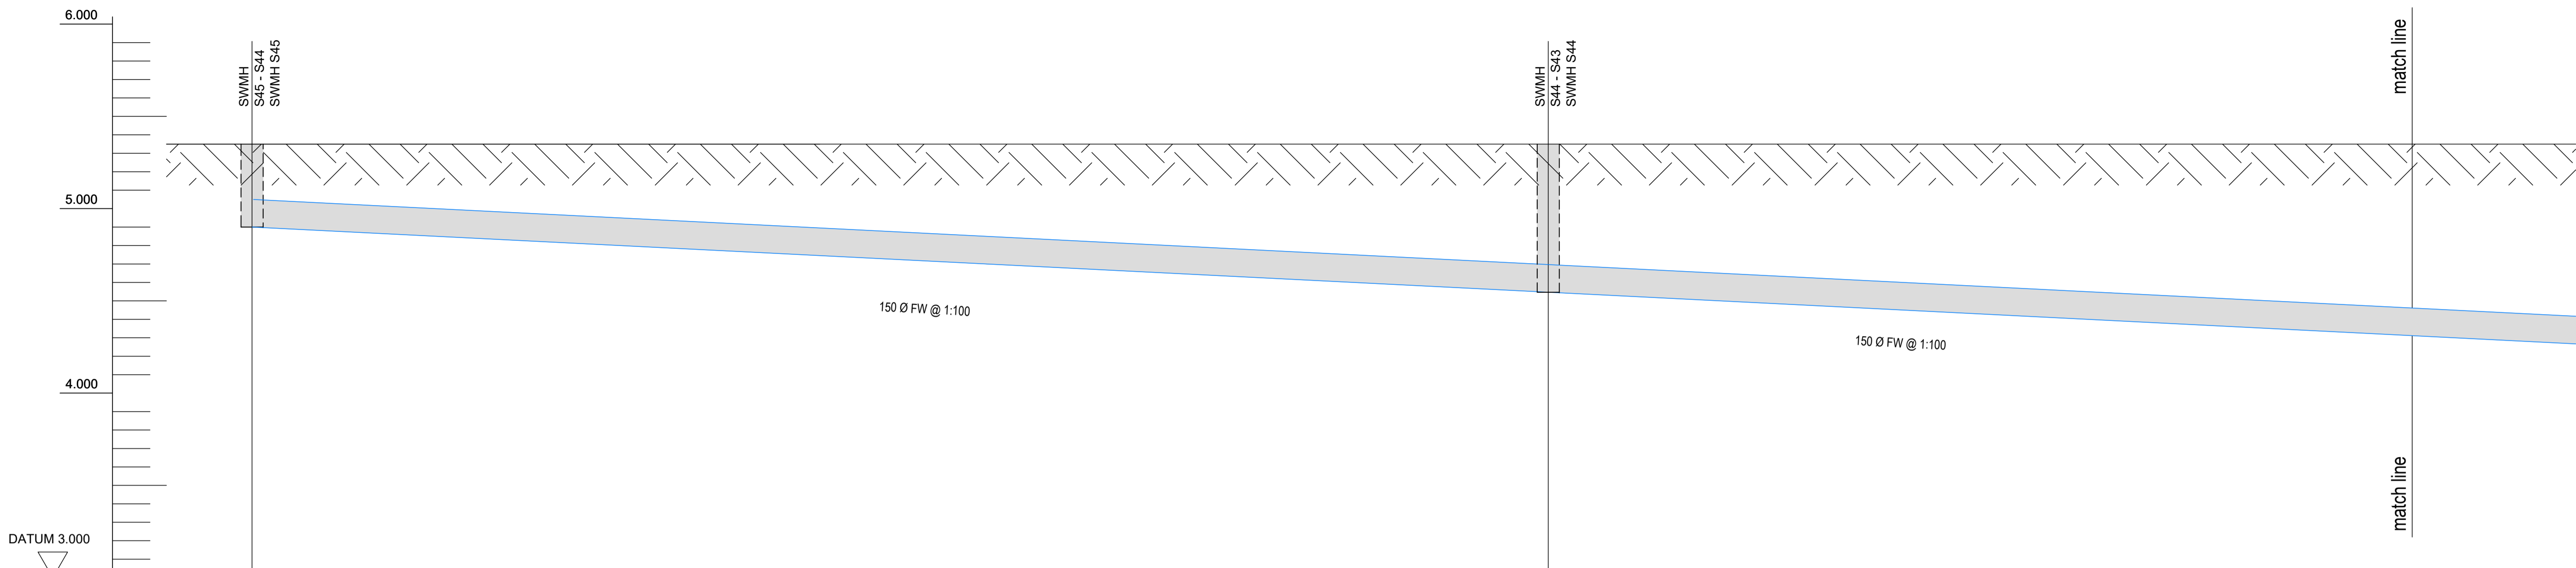

CHAINAGE (m)	00.000	39.129
COVER LEVEL	5.350	5.350
INVERT LEVEL	4.900	4.560

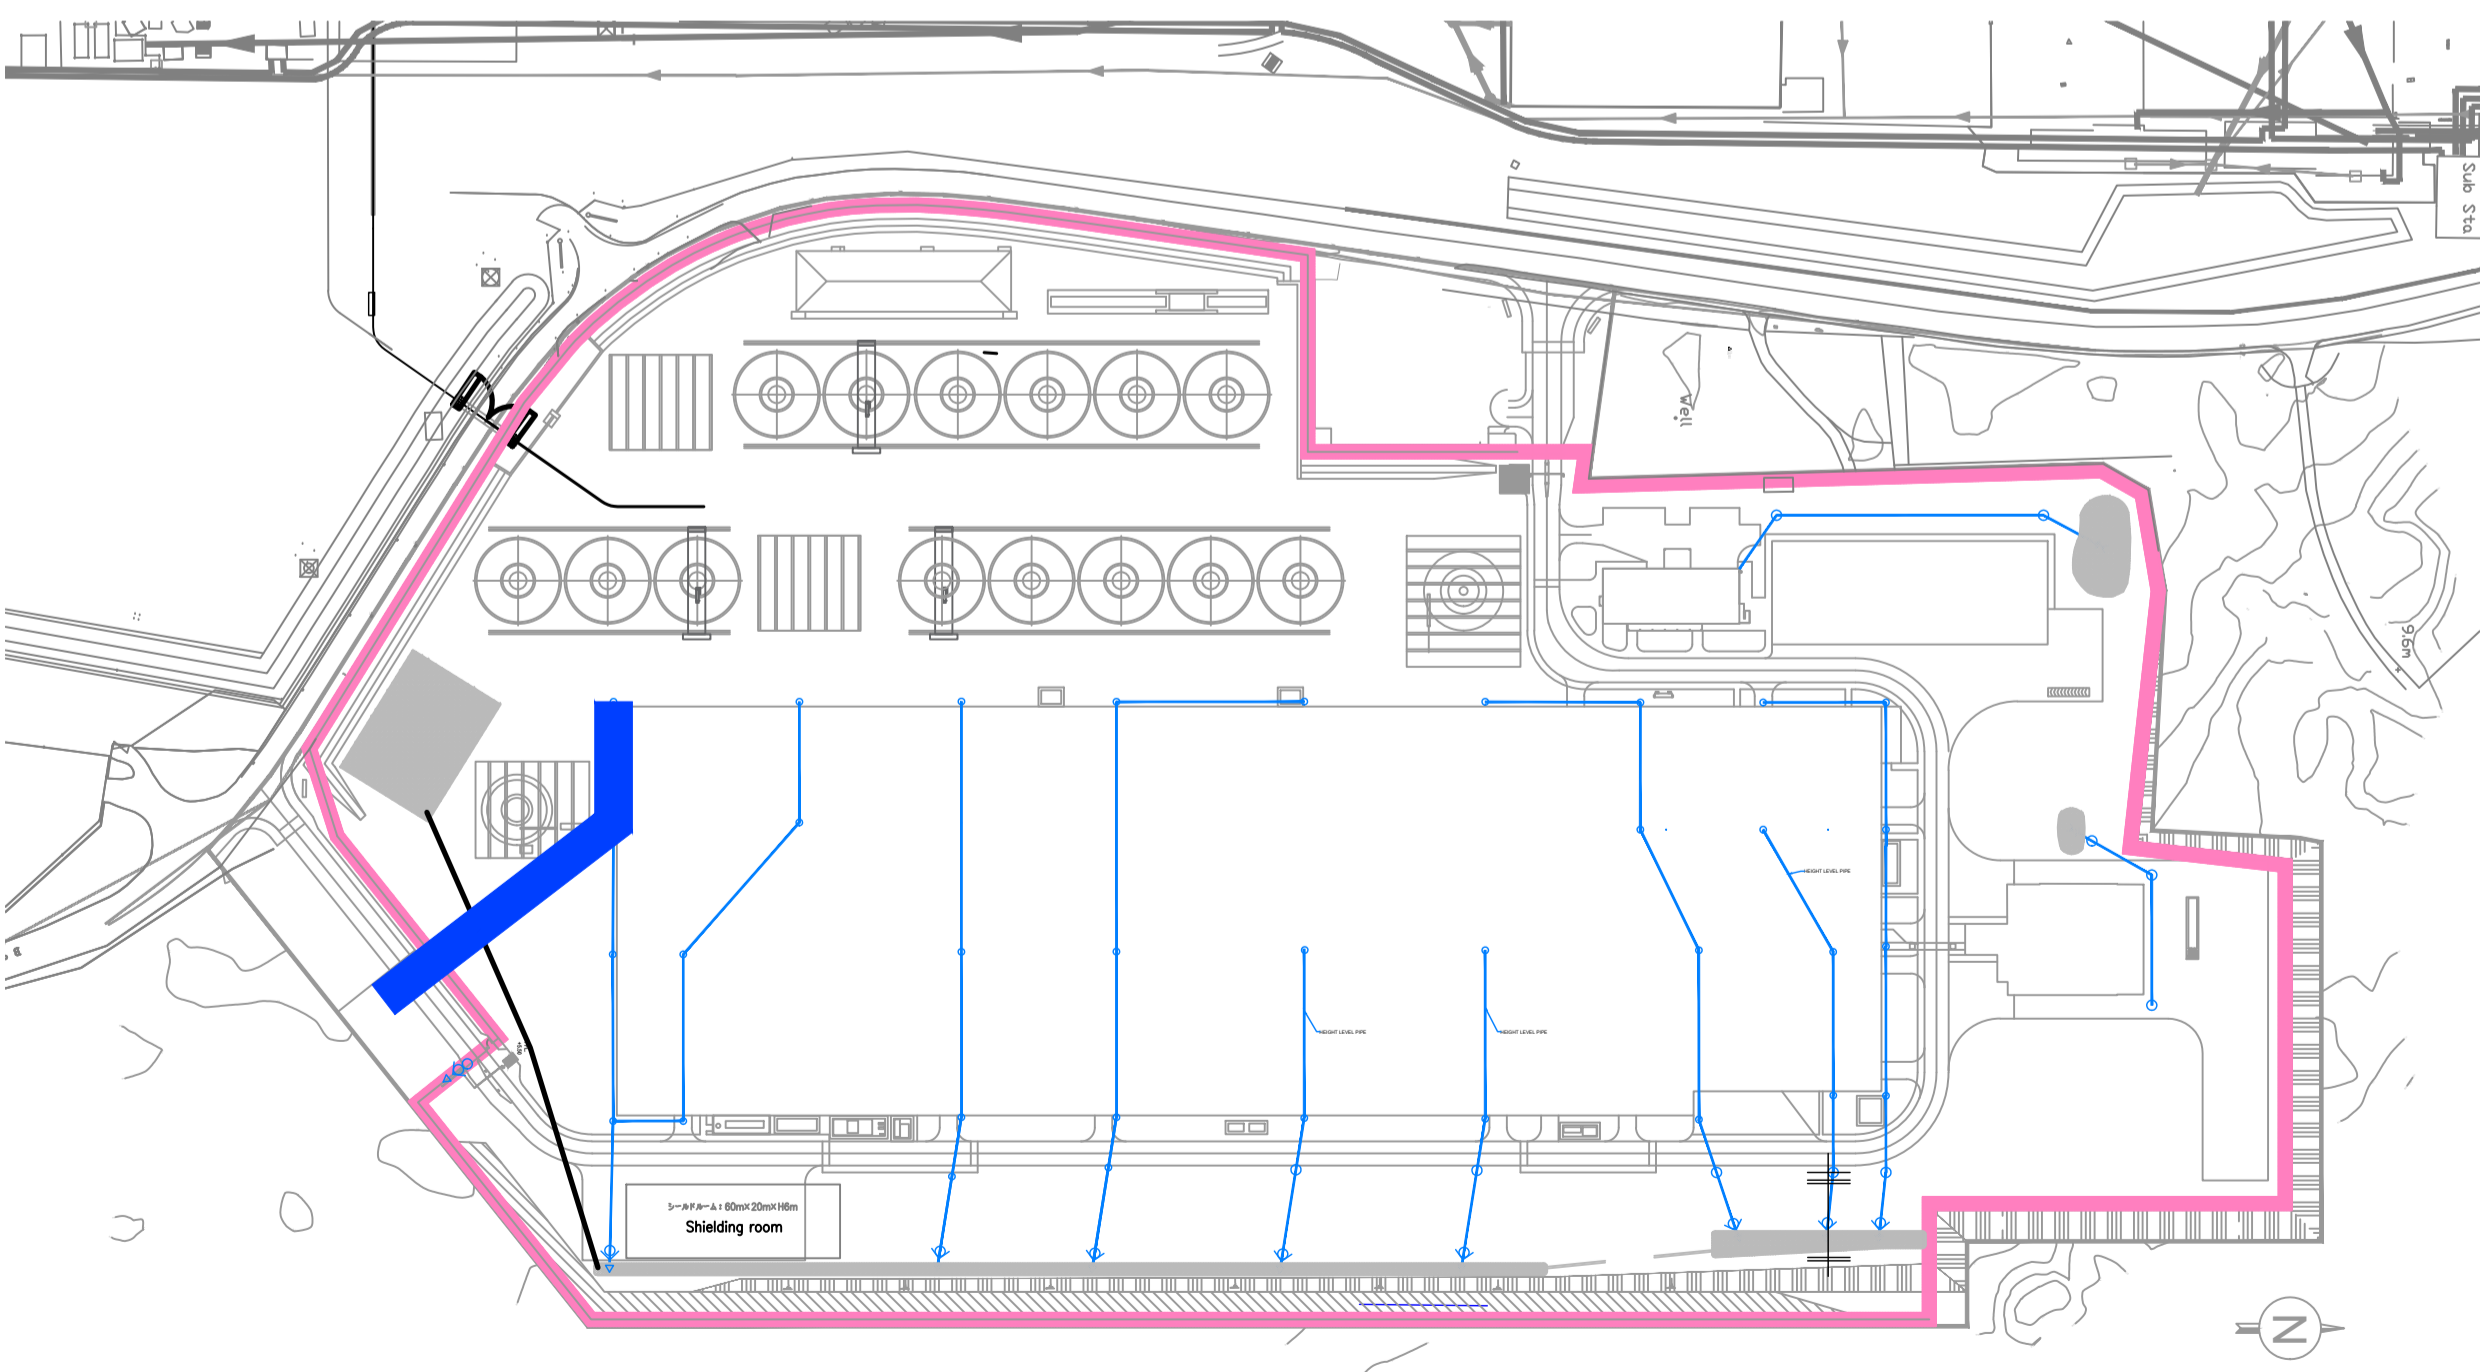

KEYPLAN

**SUMITOMO ELECTRIC** STA CABLE FACTORY  
NIGG, TAIN IV19 1QU

**eda** ARCHITECTS  
EDA Architects Ltd  
Omagh Enterprise Centre,  
41 Gortnah 1st East,  
Omagh BT78 5LU  
eoghan@eda-architects.com

REVISIONS

REV	DATE	DESCRIPTION	CHK	DRN
P01	21/08/23	ISSUED FOR PLANNING	DC	DG

STATUS  
**PLANNING**

PROJECT  
**SEIUK - CL**

PROJECT ADDRESS  
-

DISCIPLINE  
**CIVIL**

DWG TITLE  
**Storm Water - Longitudinal Section - S45-S43 - 01/02**

DWG NO.  
**S-264-EUR-EXT-ZZ-DR-CS-6345**

STATUS CODE  
**C4**

PROJECT NO.  
**S-264**

DATE  
**08/01/23**

DRAWN / CHECKED  
**SVM/DC**

SCALE NO.  
**1 : 100**

REVISION NUMBER


**P01**

**EUROPLAN GROUP**


Parkview House, Beechill Office Campus,  
Clonskeagh, Dublin 4, Eire.  
Tel: +353 1 2606578  
staprojectteam@europlanservices.com

ALL DIMENSIONS TO BE CHECKED ON SITE.  
NO DIMENSIONS TO BE SCALED FROM THIS  
DRAWING. DRAWING IS TO BE READ IN  
CONJUNCTION WITH RELEVANT  
CONSULTANTS DRAWINGS.


SITE KEY PLAN

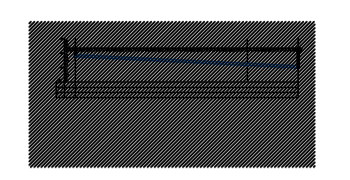


LEGEND

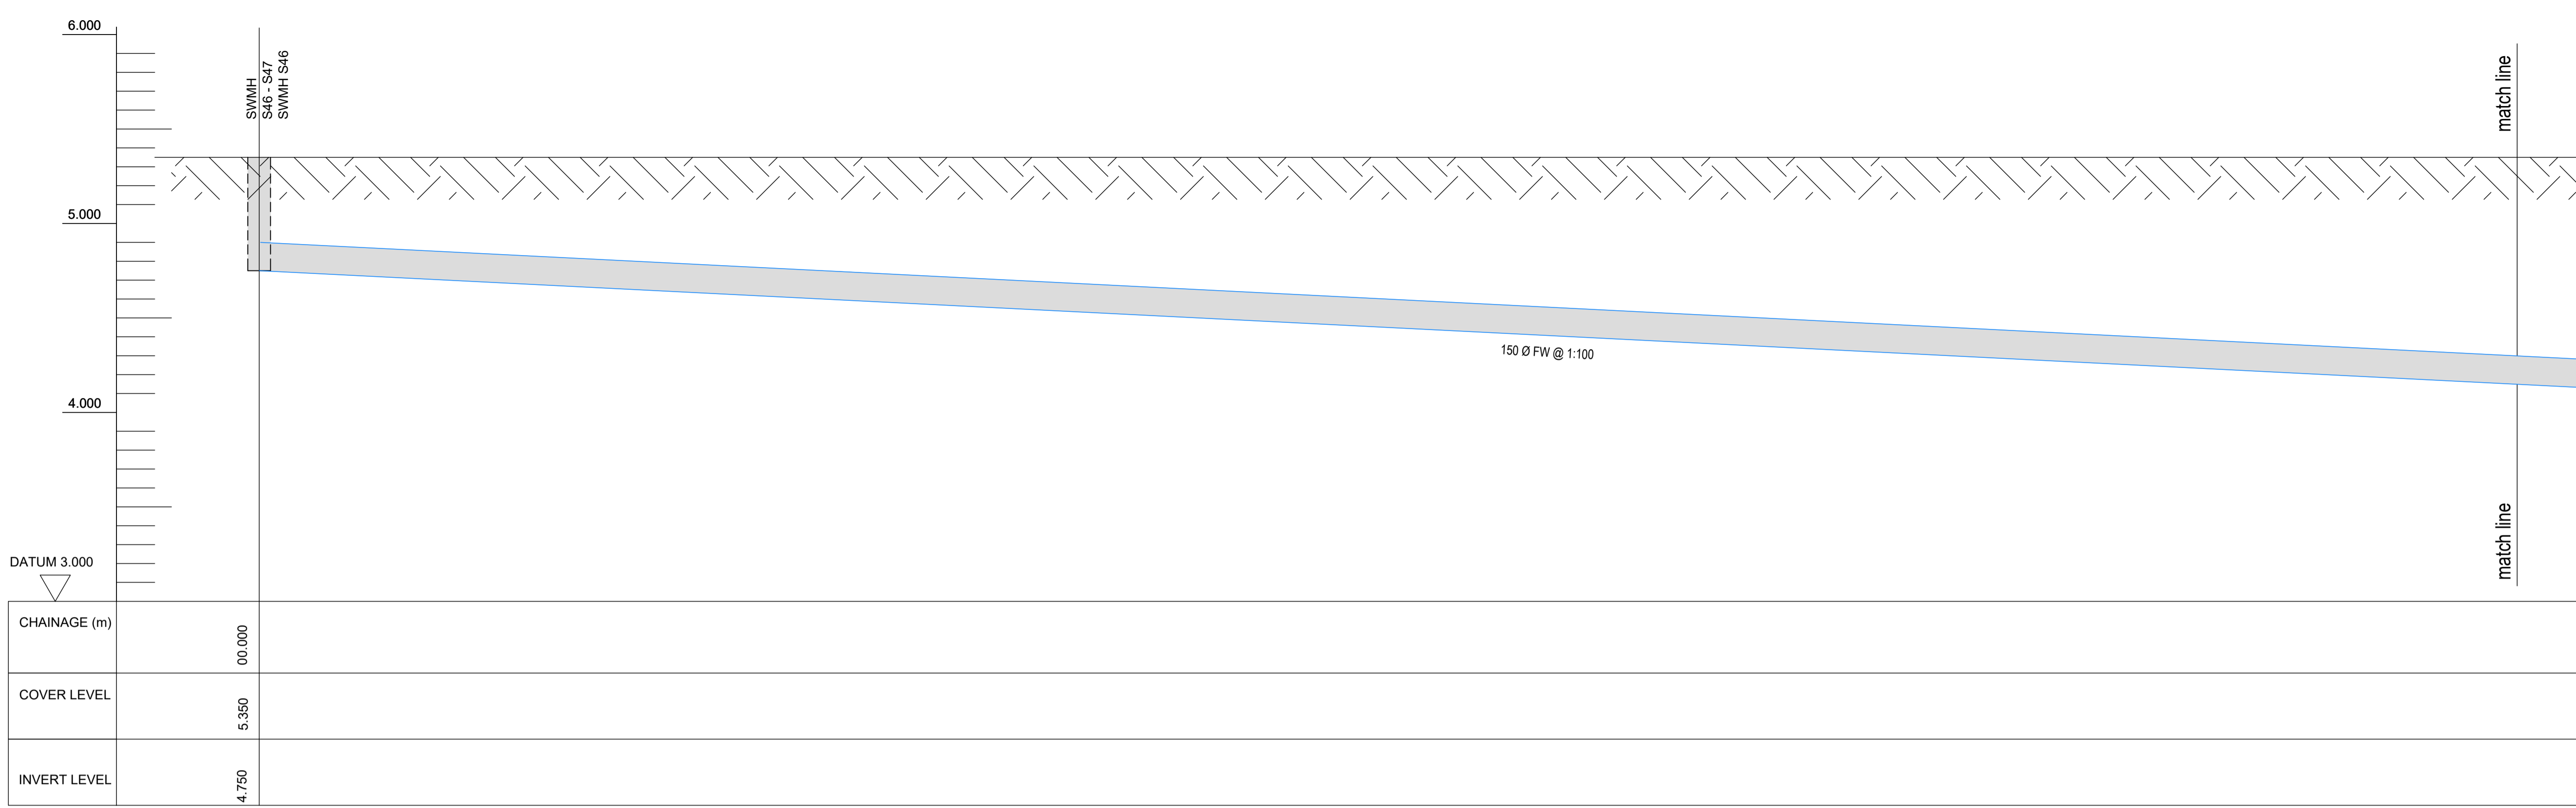

CHAINAGE (m)	00.000
COVER LEVEL	5.350
INVERT LEVEL	4.750

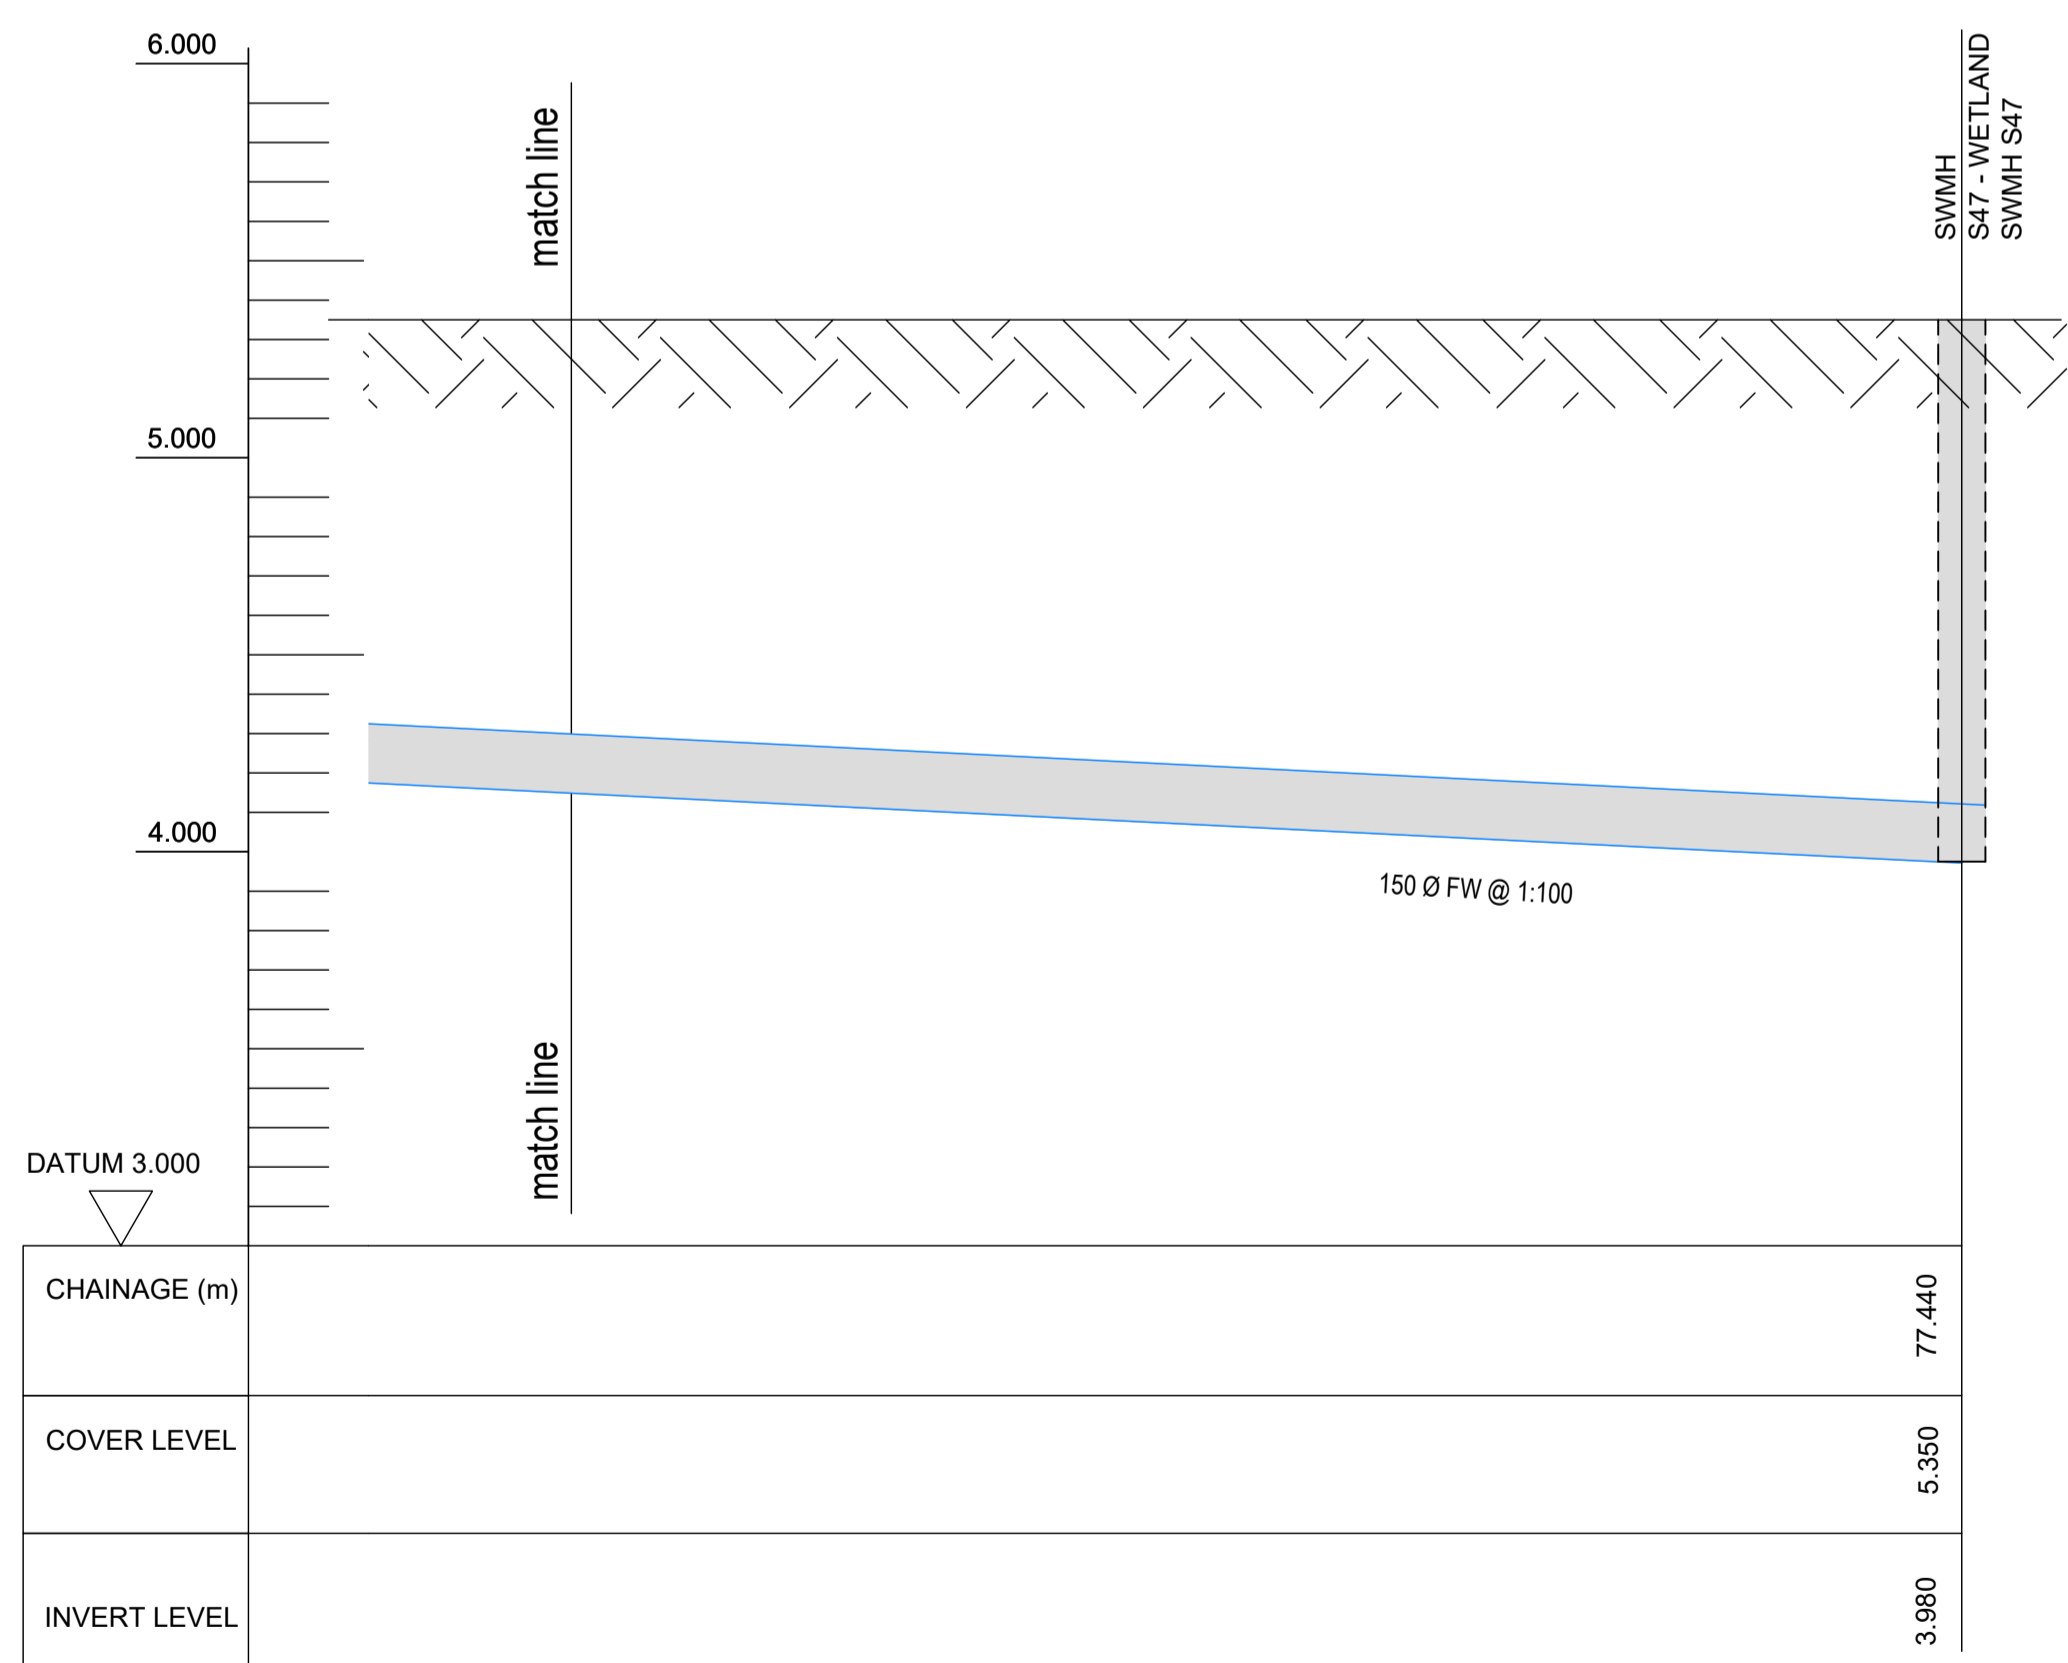

CHAINAGE (m)	77.440
COVER LEVEL	5.350
INVERT LEVEL	3.980

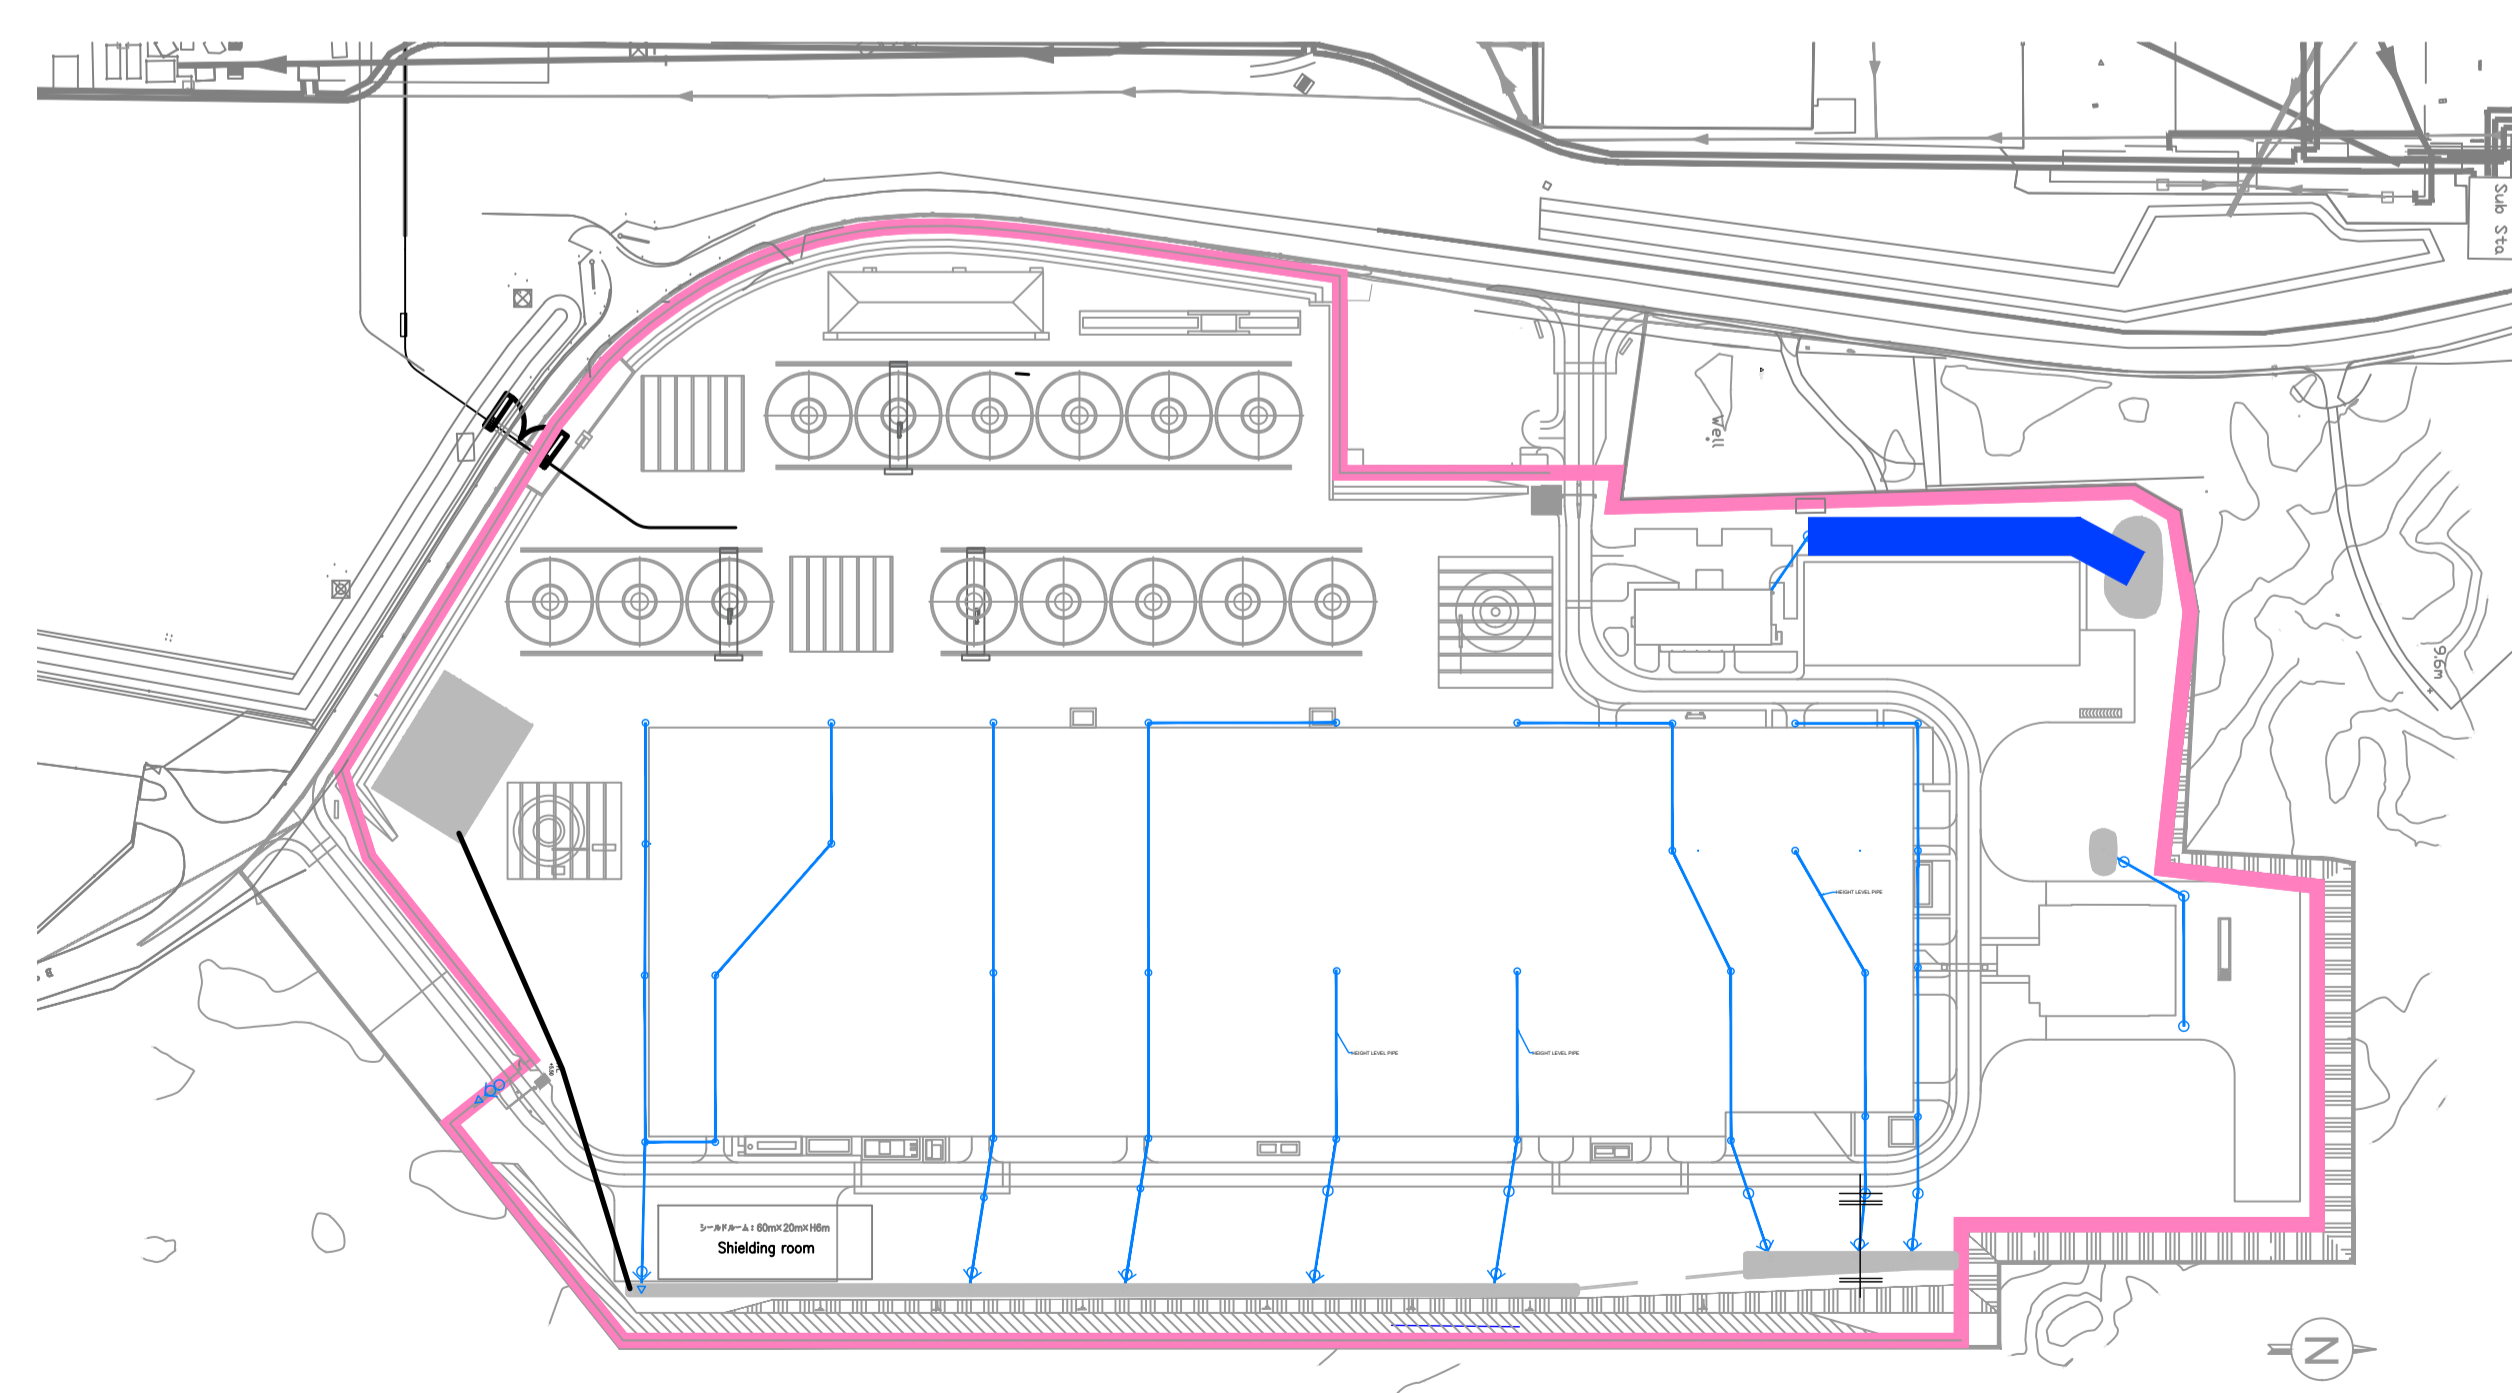

KEYPLAN

**SUMITOMO ELECTRIC** STA CABLE FACTORY  
NIGG, TAIN IV19 1QU

**eda** ARCHITECTS  
EDA Architects Ltd  
Omagh Enterprise Centre,  
41 Gortnah 1st Est.,  
Omagh BT78 5LU  
eoghan@eda-architects.com

REVISIONS

REV	DATE	DESCRIPTION	CHK	DRN

P01	21/08/23	ISSUED FOR PLANNING	DC	DG
-----	----------	---------------------	----	----

STATUS: **PLANNING**

PROJECT: **SEIUK - CL**  
PROJECT ADDRESS: -

DISCIPLINE: **CIVIL**  
DWG TITLE: **Storm Water - Longitudinal Section - S46-S47**

DWG NO.: **S-264-EUR-EXT-ZZ-DR-CS-6347**

STATUS CODE: **C4**

PROJECT NO.: **S-264** DATE: **08/01/23**

DRAWN / CHECKED: **SVM/DC** SCALE NO.: **1:100**


REVISION NUMBER: **P01**

**EUROPLAN GROUP**  
Parkview House, Beechill Office Campus,  
Clonskeagh, Dublin 4, Eire.  
Tel: +353 1 2606578  
staprojectteam@europlanservices.com



ALL DIMENSIONS TO BE CHECKED ON SITE.  
NO DIMENSIONS TO BE SCALED FROM THIS  
DRAWING. DRAWING IS TO BE READ IN  
CONJUNCTION WITH RELEVANT  
CONSULTANTS DRAWINGS.


SITE KEY PLAN

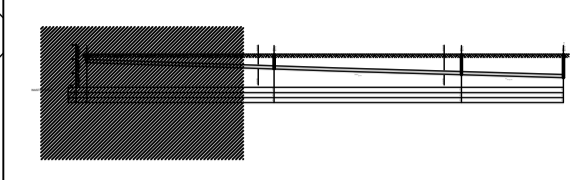


LEGEND



CHAINAGE (m)	0.000
COVER LEVEL	5.350
INVERT LEVEL	4.750

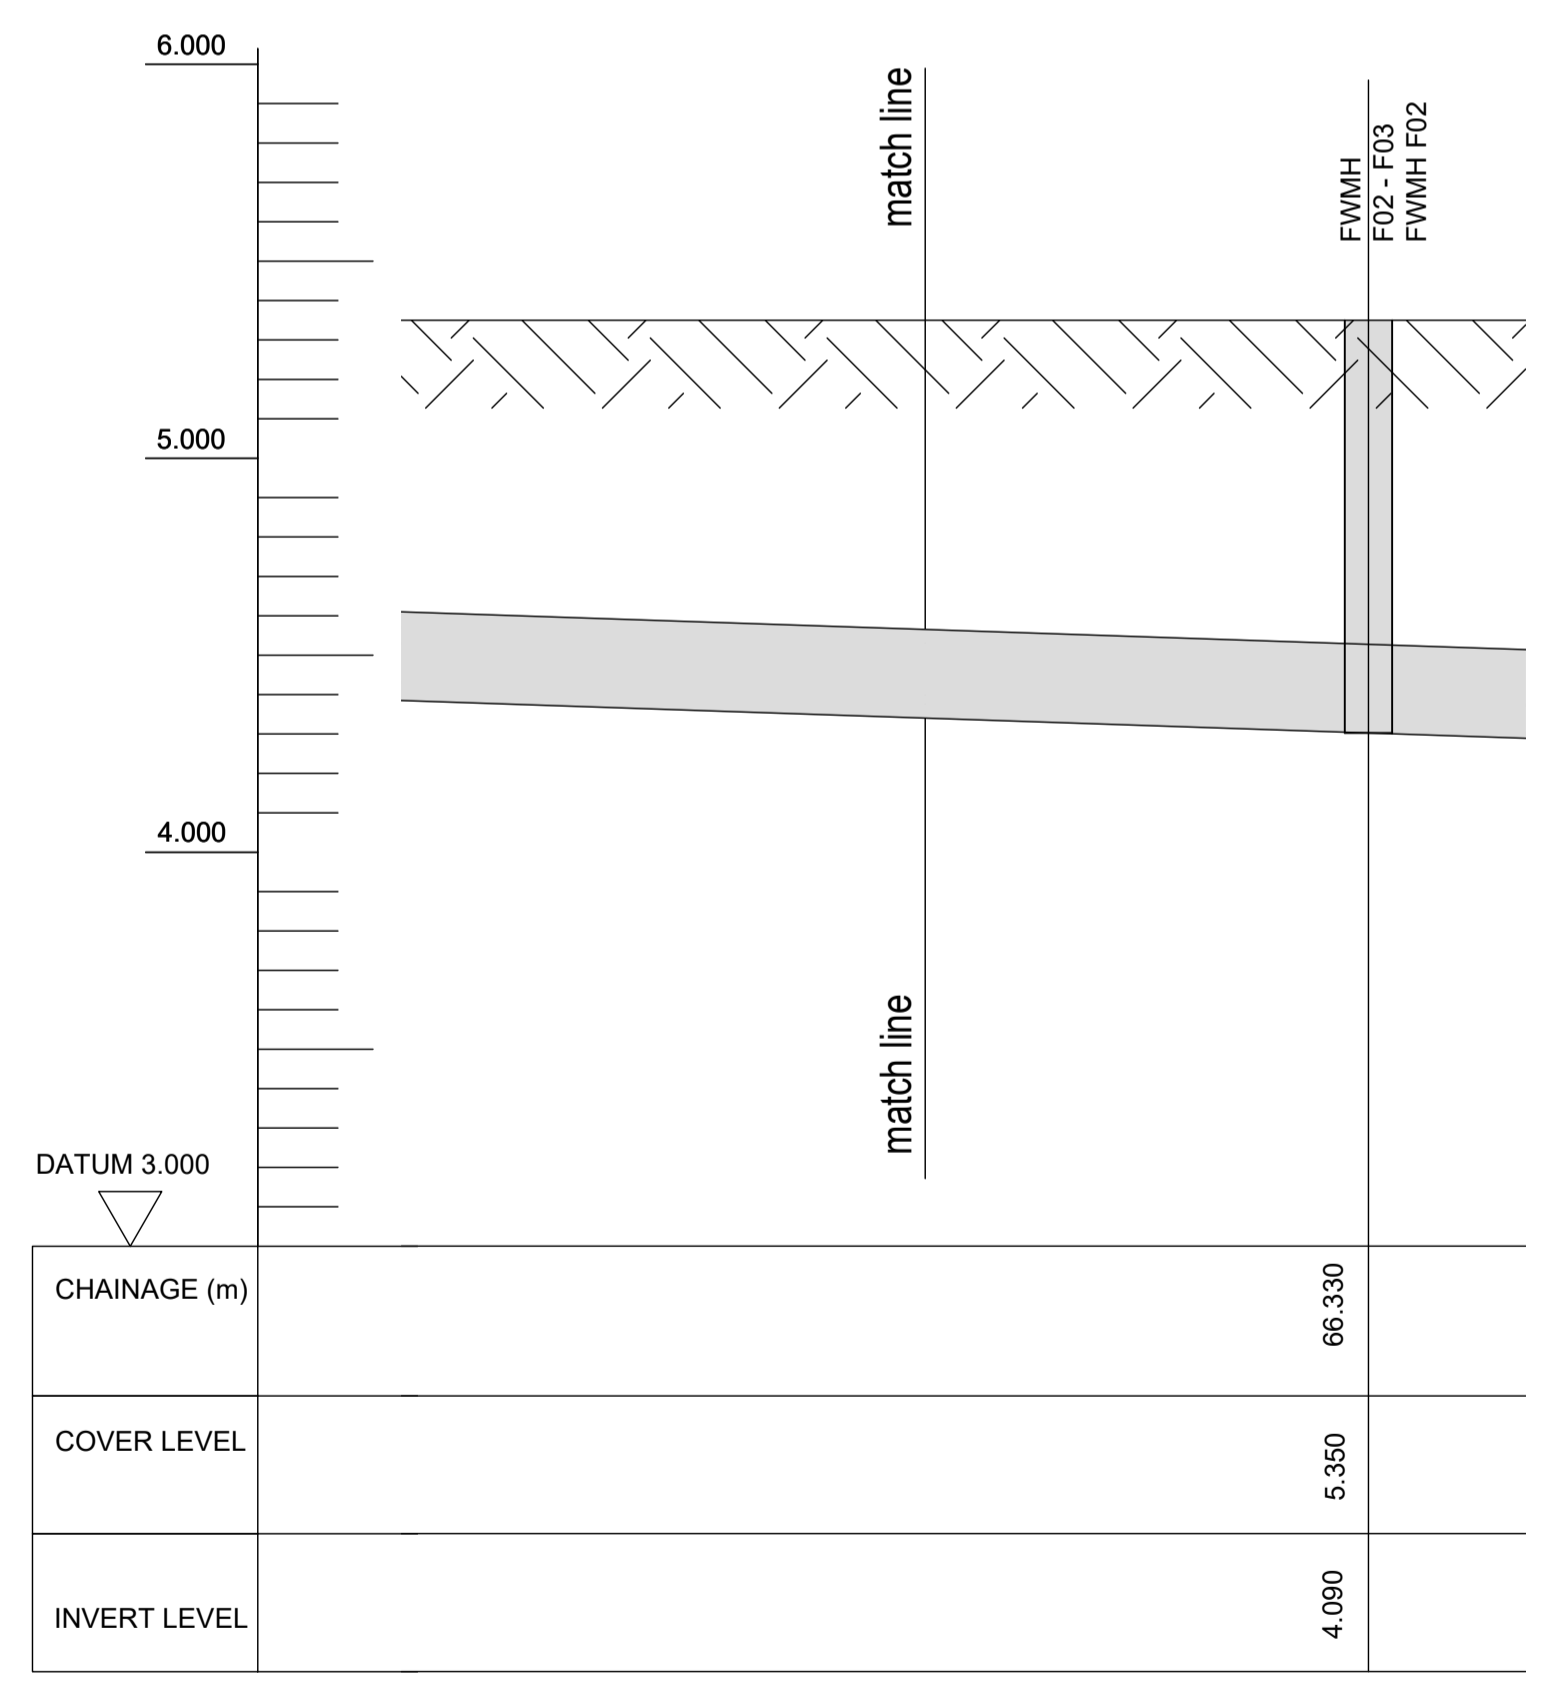

CHAINAGE (m)	66.330
COVER LEVEL	5.350
INVERT LEVEL	4.090

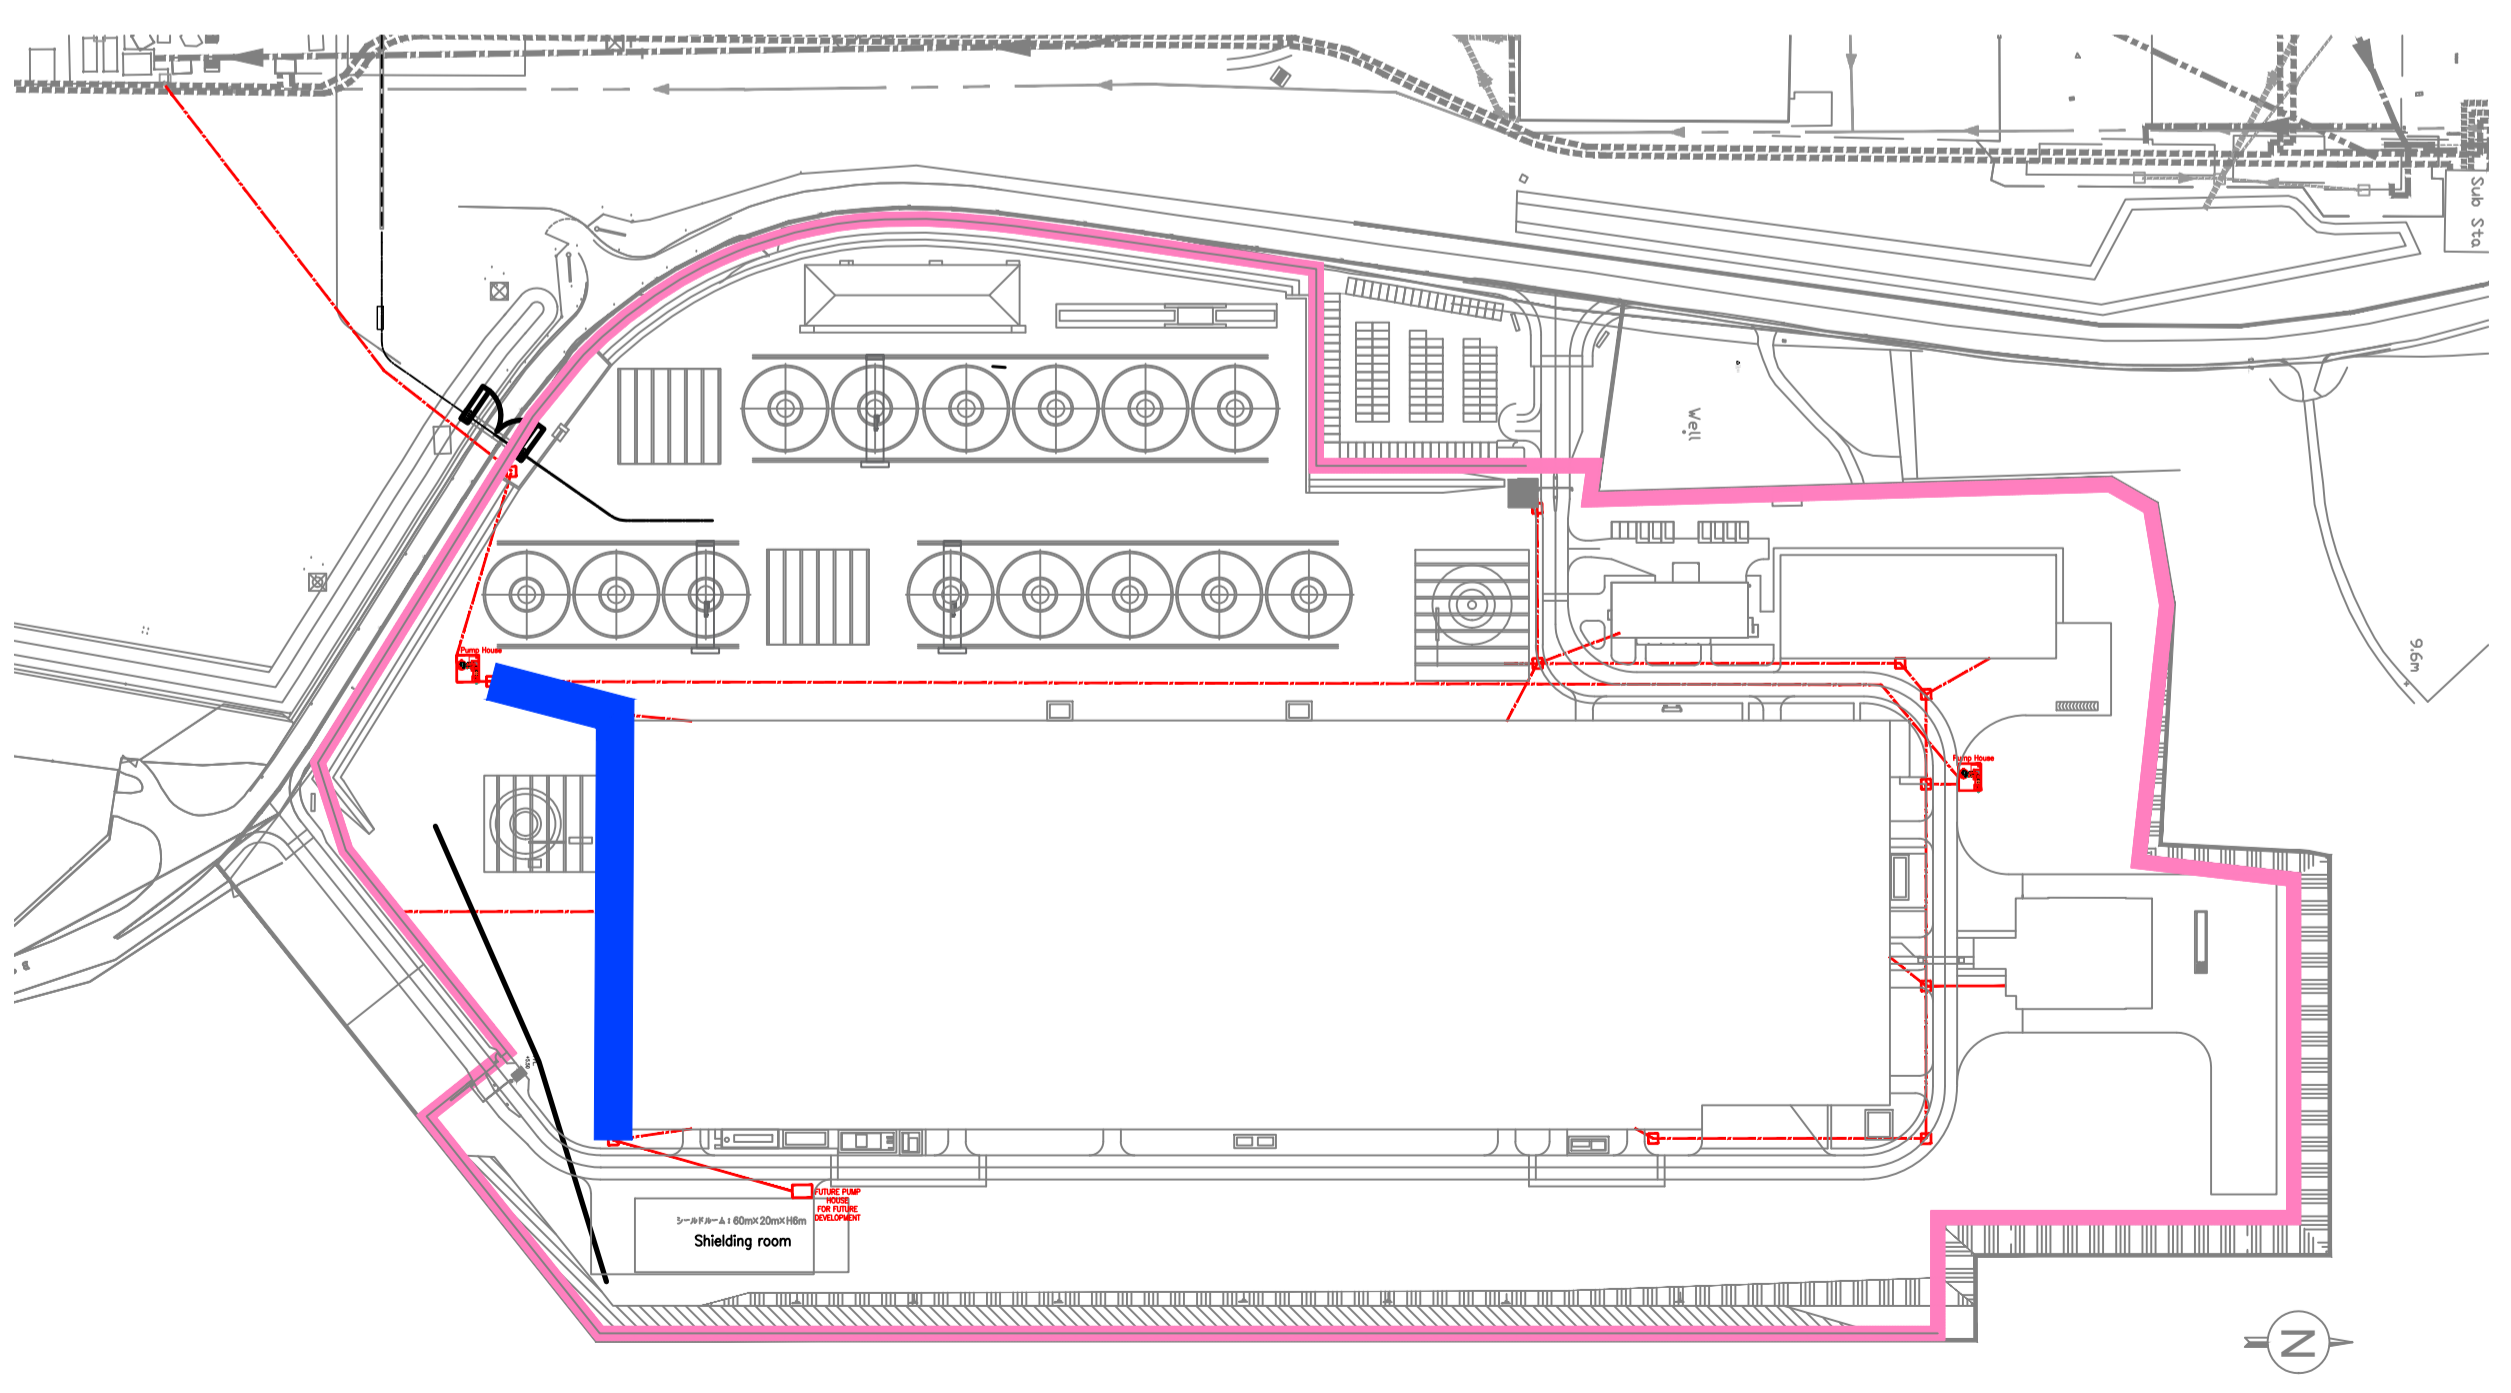

KEYPLAN

**SUMITOMO ELECTRIC** STA CABLE FACTORY  
NIGG, TAIN IV19 1QU

**eda** ARCHITECTS  
EDA Architects Ltd  
Omagh Enterprise Centre,  
41 Gortnah 3rd East,  
Omagh BT78 5LU  
eoghian@eda-architects.com

REVISIONS

REV	DATE	DESCRIPTION	CKH	DRN
P01	21/08/23	ISSUED FOR PLANNING	DC	DG

STATUS  
**PLANNING**

PROJECT  
**SEIUK - CL**

PROJECT ADDRESS

DISCIPLINE  
**CIVIL**

DWG TITLE  
**Foul Water - Longitudinal Section - F01-F04 - 01/03**

DWG NO.  
**S-263-EUR-EXT-ZZ-DR-CS-6350**

STATUS CODE  
**C4**

PROJECT NO.  
**S-263**

DATE  
**08/01/23**

DRAWN / CHECKED  
**SVM/DC**


SCALE NO.  
**1 : 100**

REVISION NUMBER  
**P01**


**EUROPLAN GROUP**  
Parkview House, Beechill Office Campus,  
Clonskeagh, Dublin 4, Eire.  
Tel: +353 1 2606578  
staprojectteam@euoplanservices.com

ALL DIMENSIONS TO BE CHECKED ON SITE.  
NO DIMENSIONS TO BE SCALED FROM THIS  
DRAWING. DRAWING IS TO BE READ IN  
CONJUNCTION WITH RELEVANT  
CONSULTANTS DRAWINGS.


SITE KEY PLAN

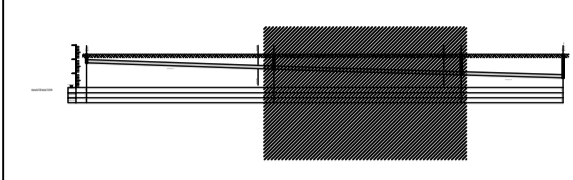


LEGEND

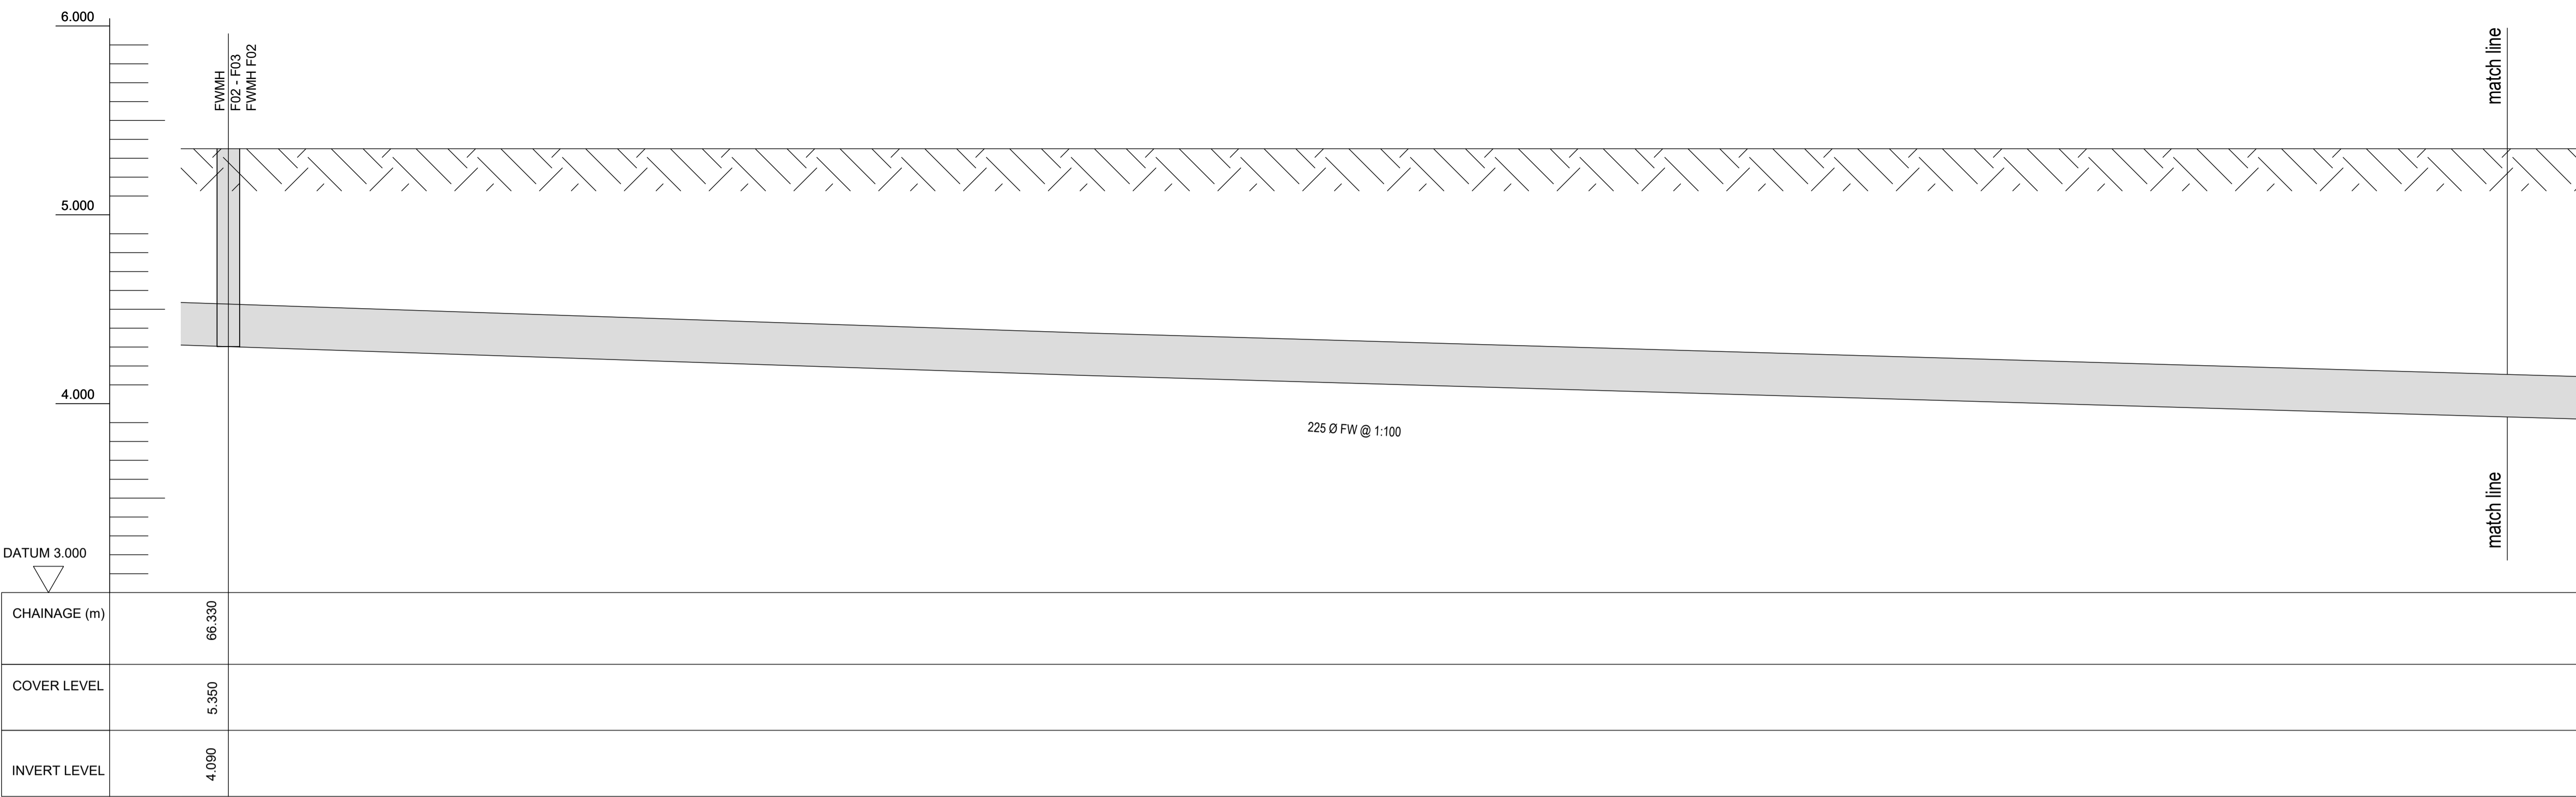

CHAINAGE (m)	66.330
COVER LEVEL	5.350
INVERT LEVEL	4.050

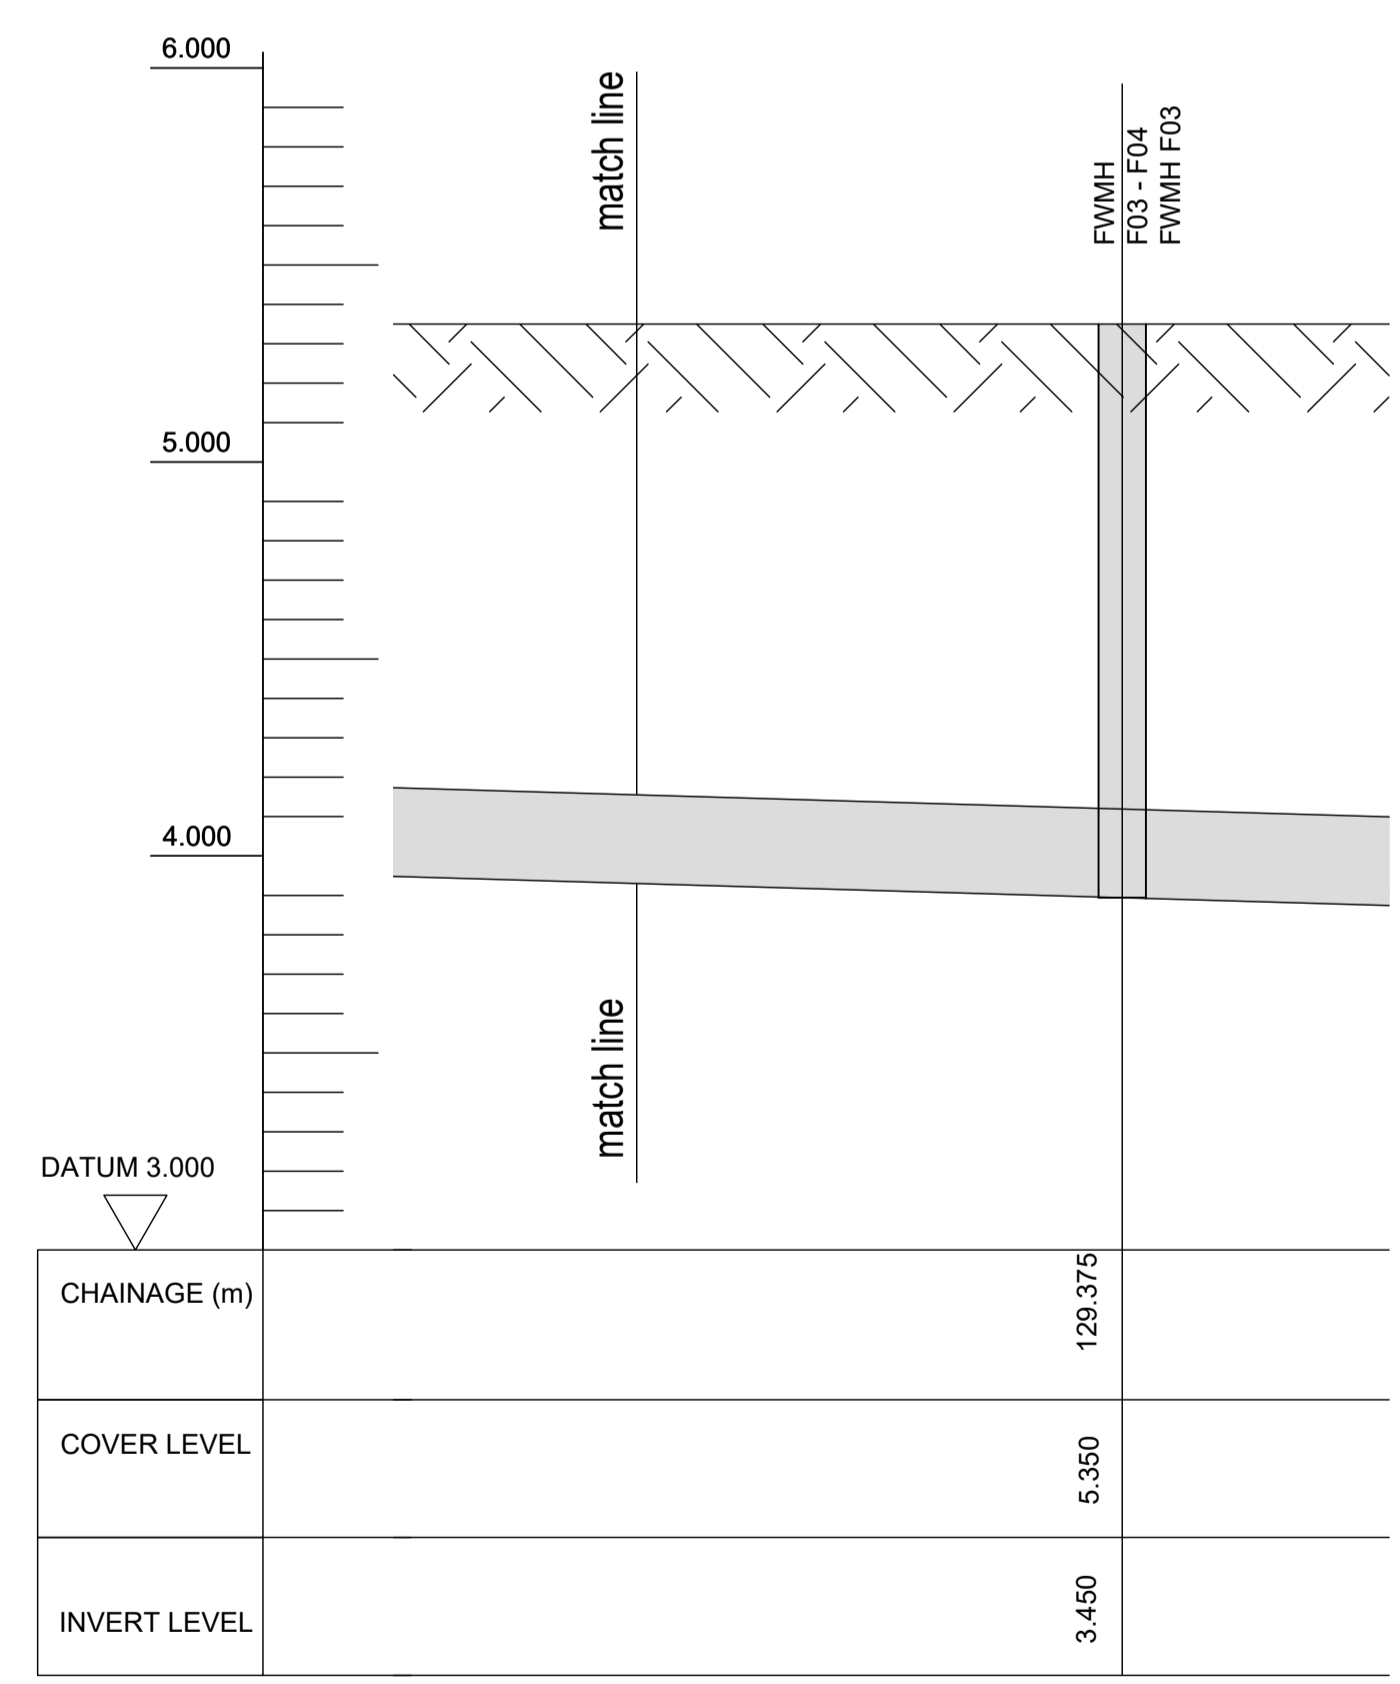

CHAINAGE (m)	129.375
COVER LEVEL	5.350
INVERT LEVEL	3.450

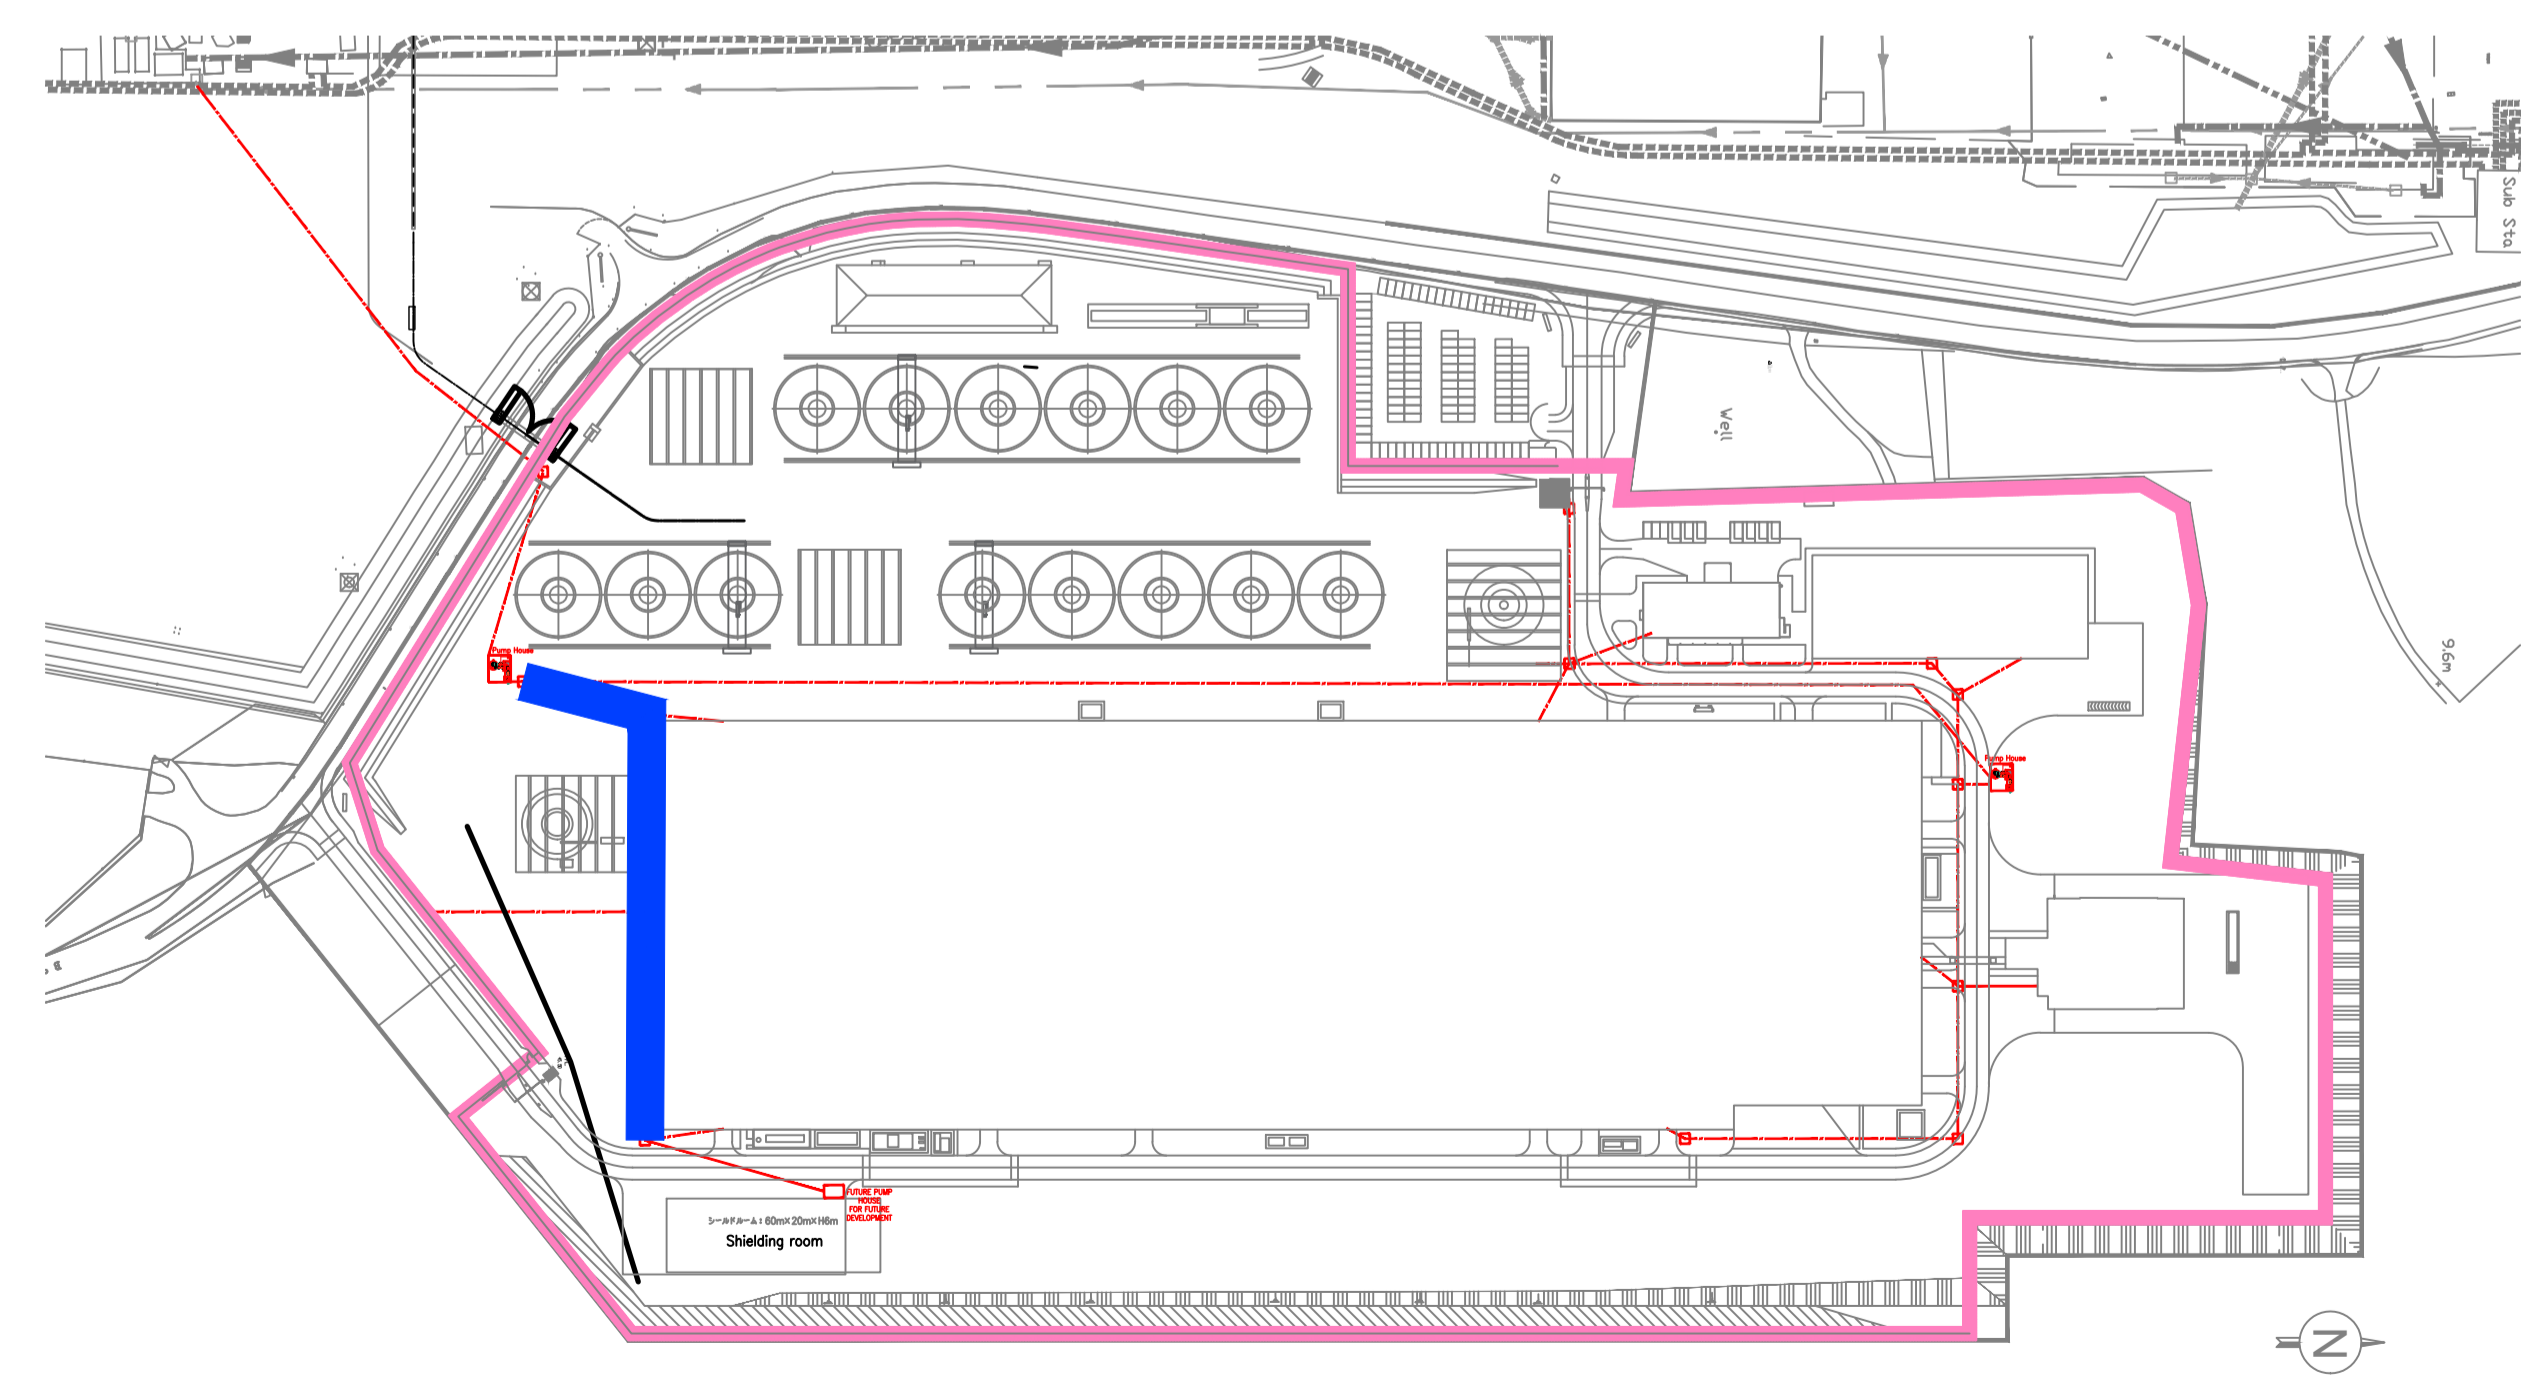

KEYPLAN

**SUMITOMO ELECTRIC** STA CABLE FACTORY  
NIGG, TAIN IV19 1QU

**eda** ARCHITECTS  
EDA Architects Ltd  
Omagh Enterprise Centre,  
41 Gortash Ind Est,  
Omagh BT78 5LU  
eoghan@eda-architects.com

REVISIONS

REV	DATE	DESCRIPTION	CKH	DRN
P01	21/08/23	ISSUED FOR PLANNING	DC	DG

STATUS  
**PLANNING**

PROJECT  
**SEIUK - CL**

PROJECT ADDRESS  
-

DISCIPLINE  
**CIVIL**

DWG TITLE  
**Foul Water - Longitudinal Section - F01-F04 - 02/03**

DWG NO.  
**S-263-EUR-EXT-ZZ-DR-CS-6351**

STATUS CODE  
**C4**

PROJECT NO.  
**S-263**

DATE  
**08/01/23**

DRAWN / CHECKED  
**SVM/DC**

SCALE NO.  
**1 : 100**

REVISION NUMBER


**P01**

**EUROPLAN GROUP**


Parkview House, Beechill Office Campus,  
Clonskeagh, Dublin 4, Eire.  
Tel: +353 1 2606578  
staprojectteam@europlanservices.com

ALL DIMENSIONS TO BE CHECKED ON SITE.  
NO DIMENSIONS TO BE SCALED FROM THIS  
DRAWING. DRAWING IS TO BE READ IN  
CONJUNCTION WITH RELEVANT  
CONSULTANTS DRAWINGS.

SITE KEY PLAN

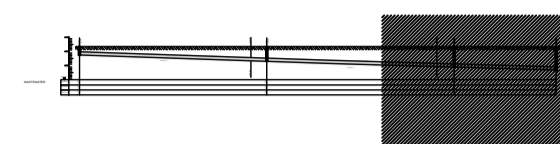

LEGEND

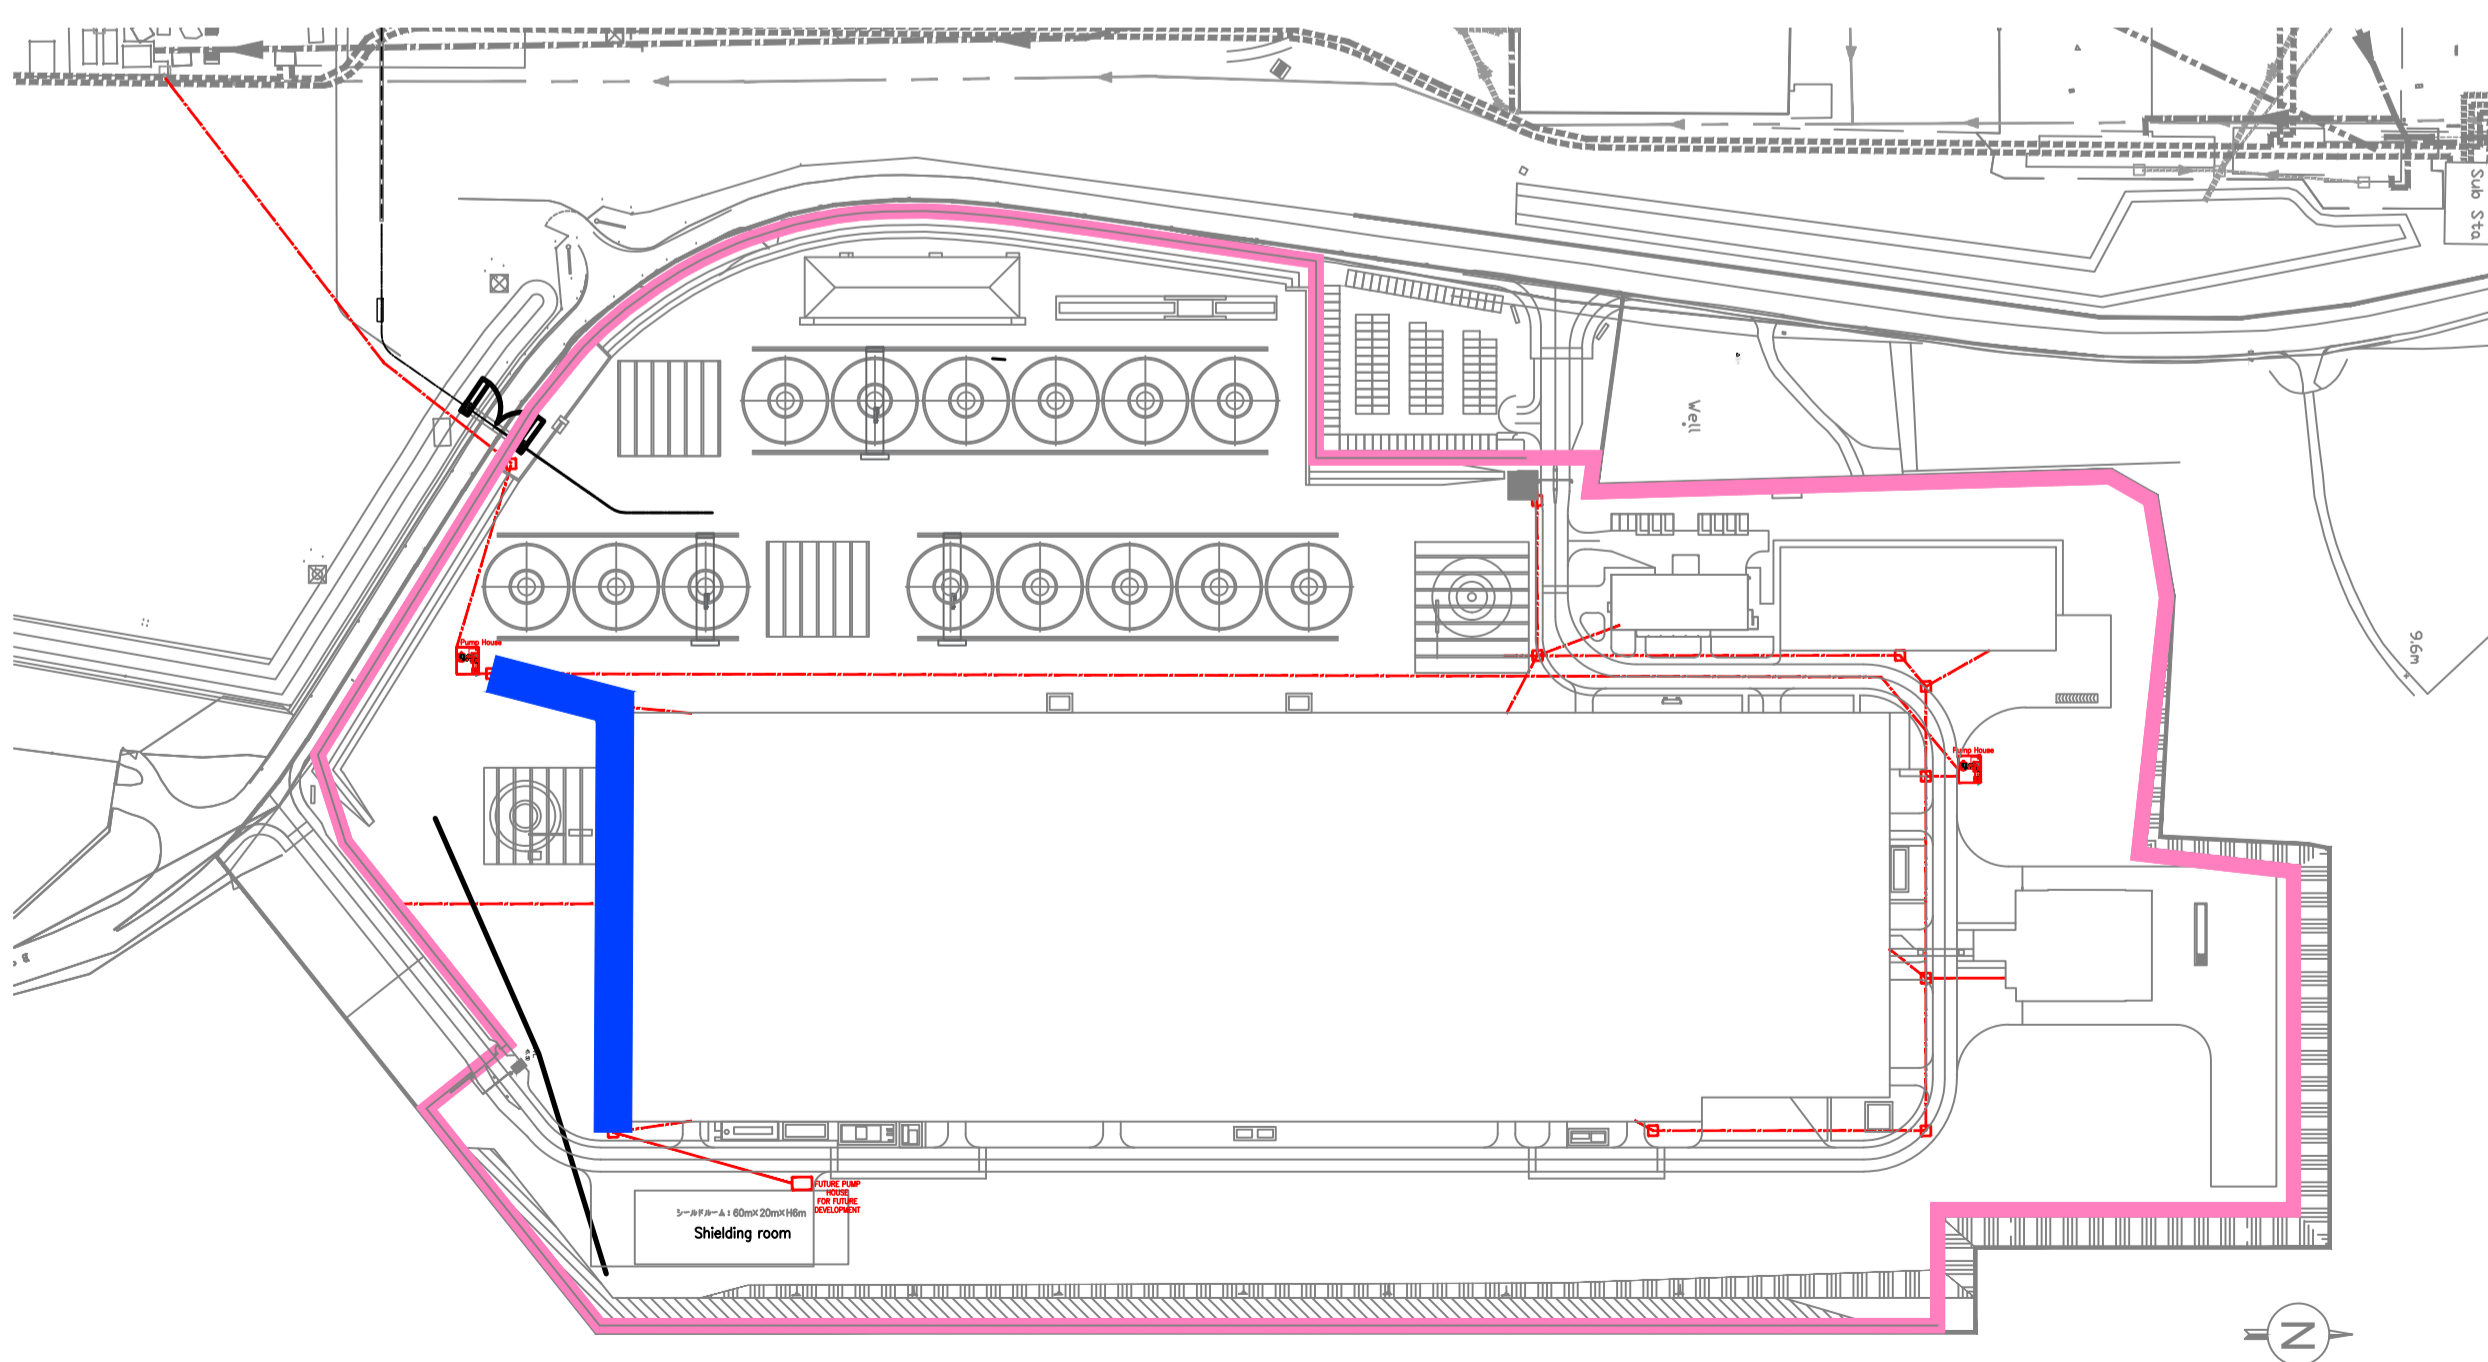

KEYPLAN

**SUMITOMO ELECTRIC** STA CABLE FACTORY  
NIGG, TAIN IV19 1QU

**eda** ARCHITECTS  
EDA Architects Ltd  
Omagh Enterprise Centre,  
41 Gortnah 1st East,  
Omagh BT78 5LU  
eoghan@eda-architects.com

REVISIONS

REV	DATE	DESCRIPTION	CHK	DRN

P01 21/08/23 ISSUED FOR PLANNING DC DG

STATUS: PLANNING

PROJECT: SEIUK - CL

PROJECT ADDRESS: -

DISCIPLINE: CIVIL

DWG TITLE: Foul Water - Longitudinal Section - F01-F04 - 03/03

DWG NO.: S-263-EUR-EXT-ZZ-DR-CS-6352

STATUS CODE: C4

PROJECT NO.: S-263 DATE: 08/01/23

DRAWN / CHECKED: SVM/DC SCALE NO.: 1:100


REVISION NUMBER

P01



**EUROPLAN GROUP**  
Parkview House, Beechill Office Campus,  
Clonskeagh, Dublin 4, Eire.  
Tel: +353 1 2606578  
staprojectteam@europlanservices.com

ALL DIMENSIONS TO BE CHECKED ON SITE.  
NO DIMENSIONS TO BE SCALED FROM THIS  
DRAWING. DRAWINGS IS TO BE READ IN  
CONJUNCTION WITH RELEVANT  
CONSULTANTS DRAWINGS.

SITE KEY PLAN

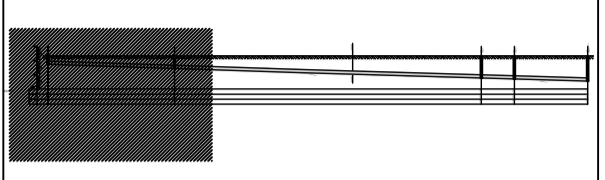

LEGEND

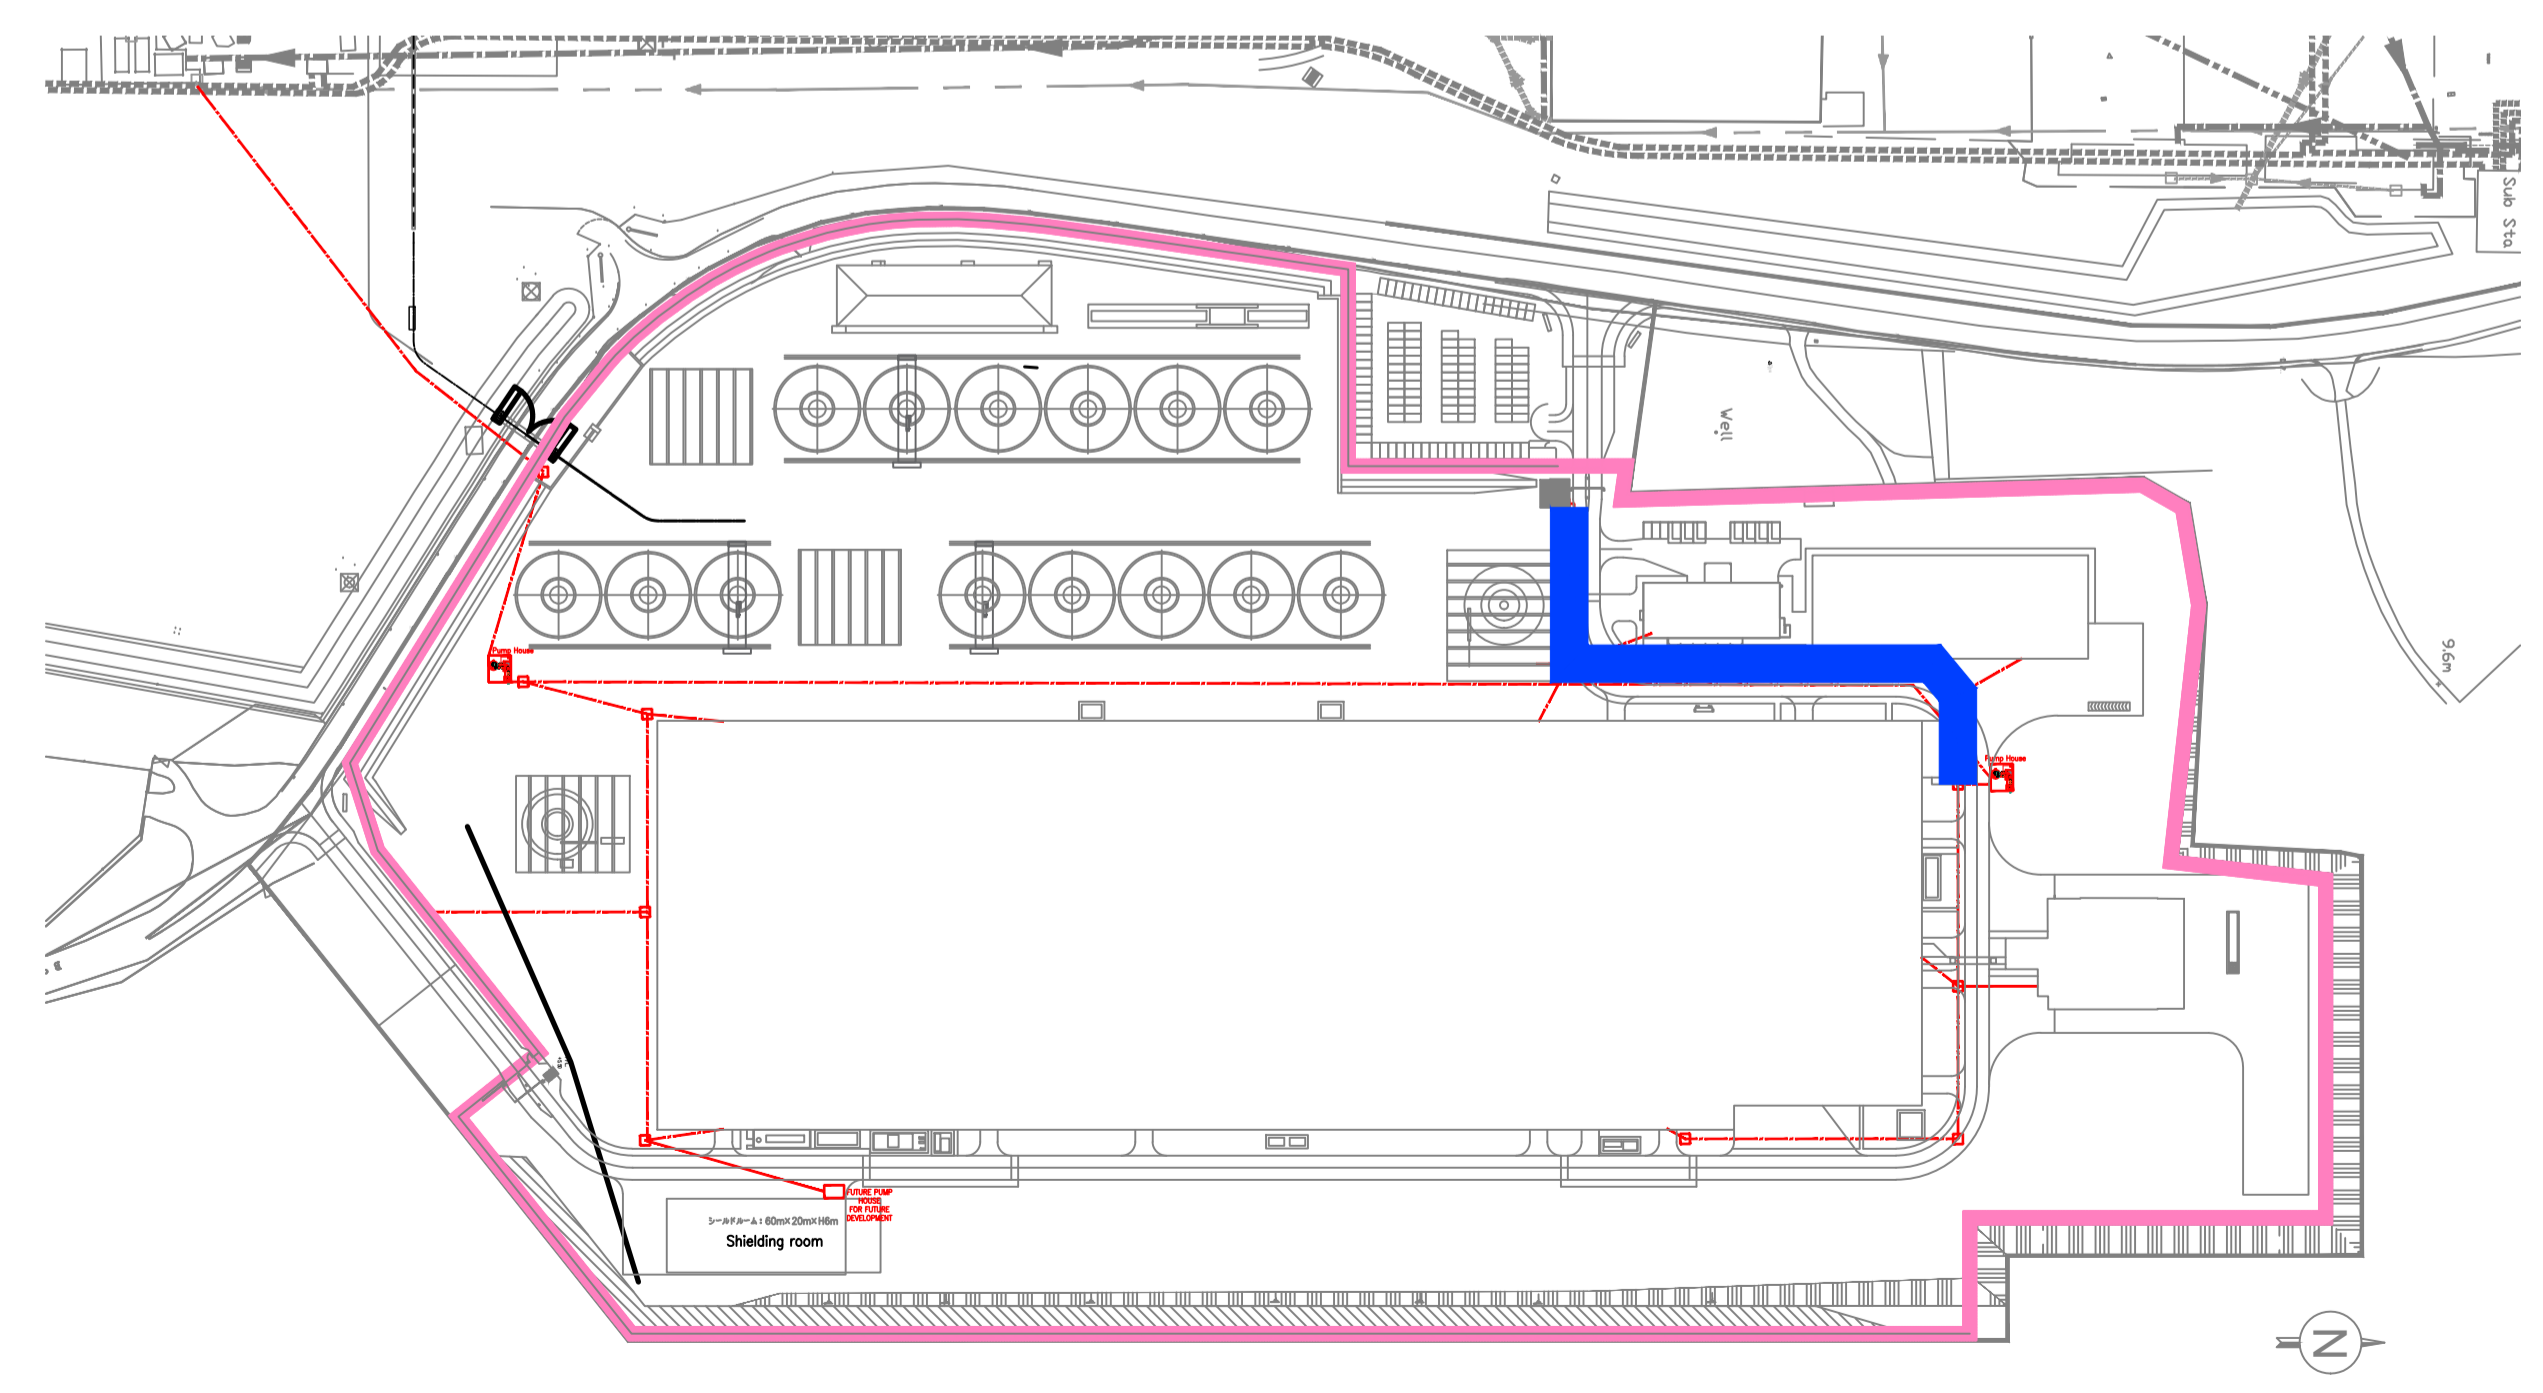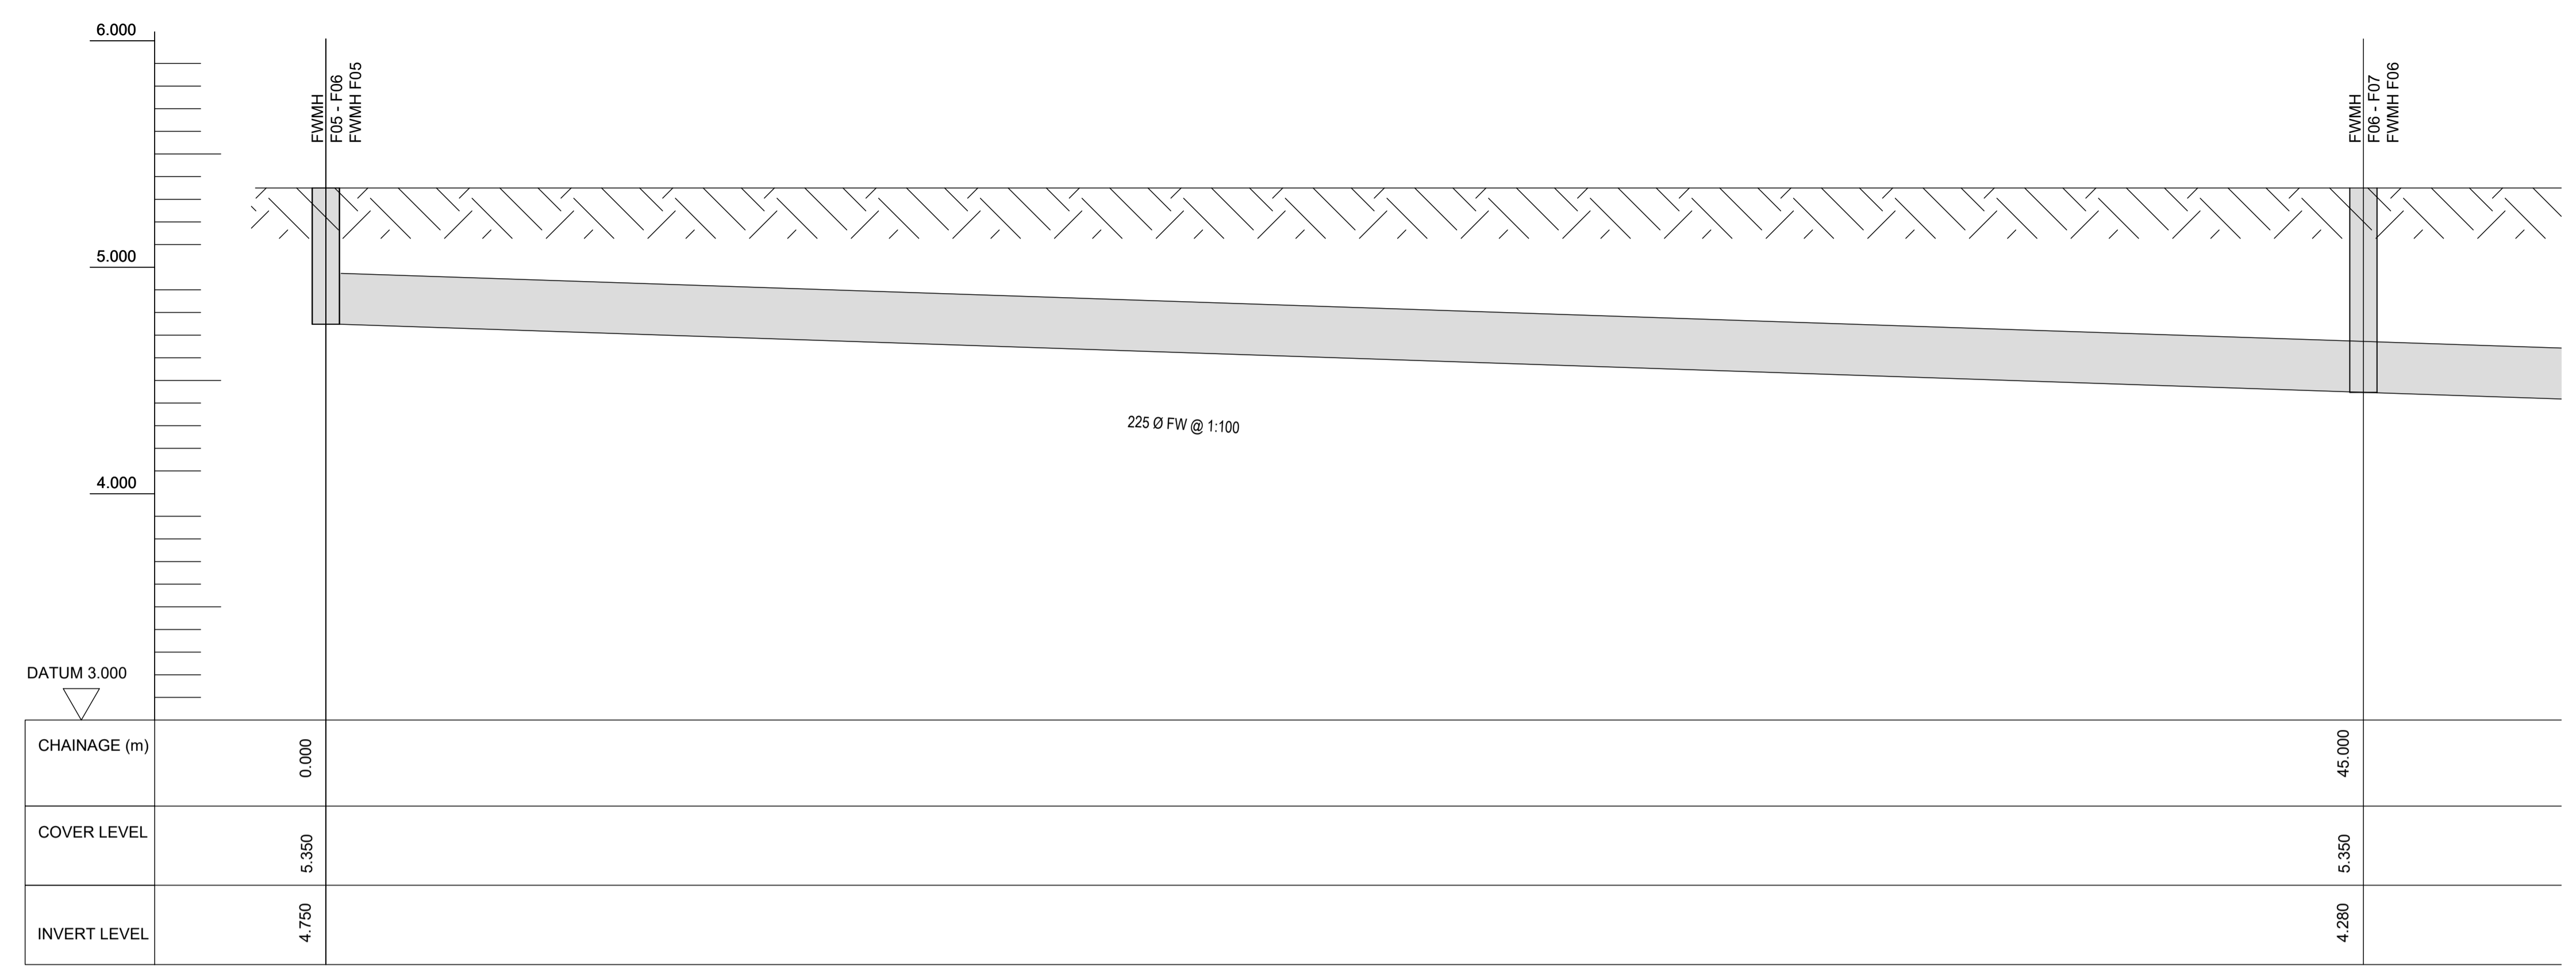

KEYPLAN

**SUMITOMO ELECTRIC** STA CABLE FACTORY  
NIGG, TAIN IV19 1QU

**eda** ARCHITECTS  
EDA Architects Ltd  
Omagh Enterprise Centre,  
41 Gortnah 1st East,  
Omagh BT18 5LU  
eoghan@eda-architects.com

REVISIONS

REV	DATE	DESCRIPTION	CHK	DRN

P01	21/08/23	ISSUED FOR PLANNING	DC	DG
-----	----------	---------------------	----	----

STATUS: **PLANNING**

PROJECT: **SEIUK - CL**

PROJECT ADDRESS: -

DISCIPLINE: **CIVIL**

DWG TITLE: **Foul Water - Longitudinal Section - F05-F09 - 01/03**

DWG NO.: **S-263-EUR-EXT-ZZ-DR-CS-6353**

STATUS CODE: **C4**

PROJECT NO.: **S-263** DATE: **08/01/23**


DRAWN / CHECKED: **SYM/DC** SCALE NO.: **1:100**

REVISION NUMBER


**P01** **EUROPLAN GROUP**  
Parkview House, Beechill Office Campus,  
Clonskeagh, Dublin 4, Eire.  
Tel: +353 1 2606578  
staprojectteam@euoplanservices.com

ALL DIMENSIONS TO BE CHECKED ON SITE.  
NO DIMENSIONS TO BE SCALED FROM THIS  
DRAWING. DRAWING IS TO BE READ IN  
CONJUNCTION WITH RELEVANT  
CONSULTANTS DRAWINGS.


SITE KEY PLAN

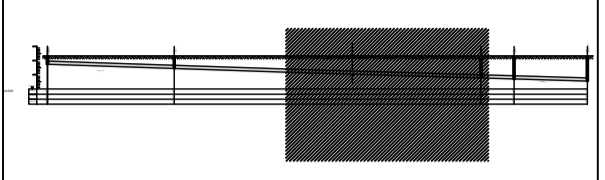


LEGEND

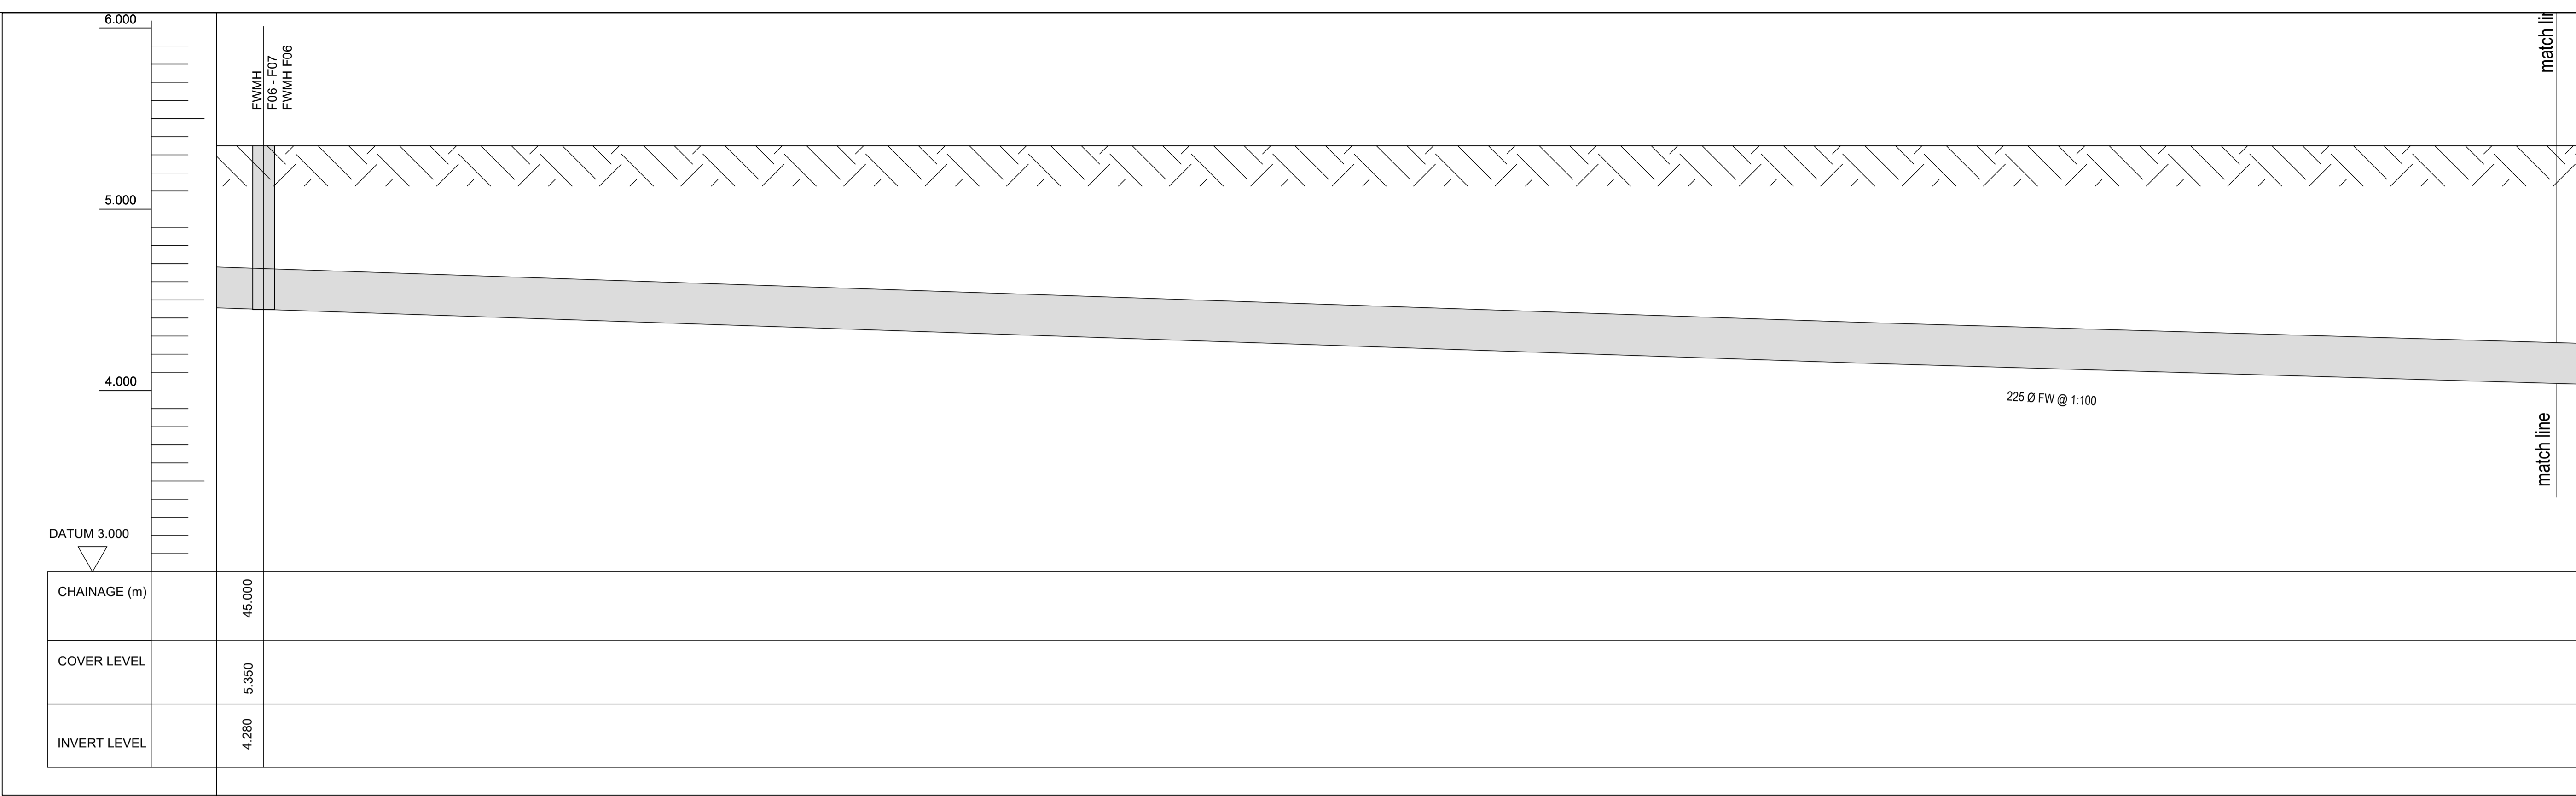

DATUM 3.000	
CHAINAGE (m)	45.000
COVER LEVEL	5.350
INVERT LEVEL	4.280

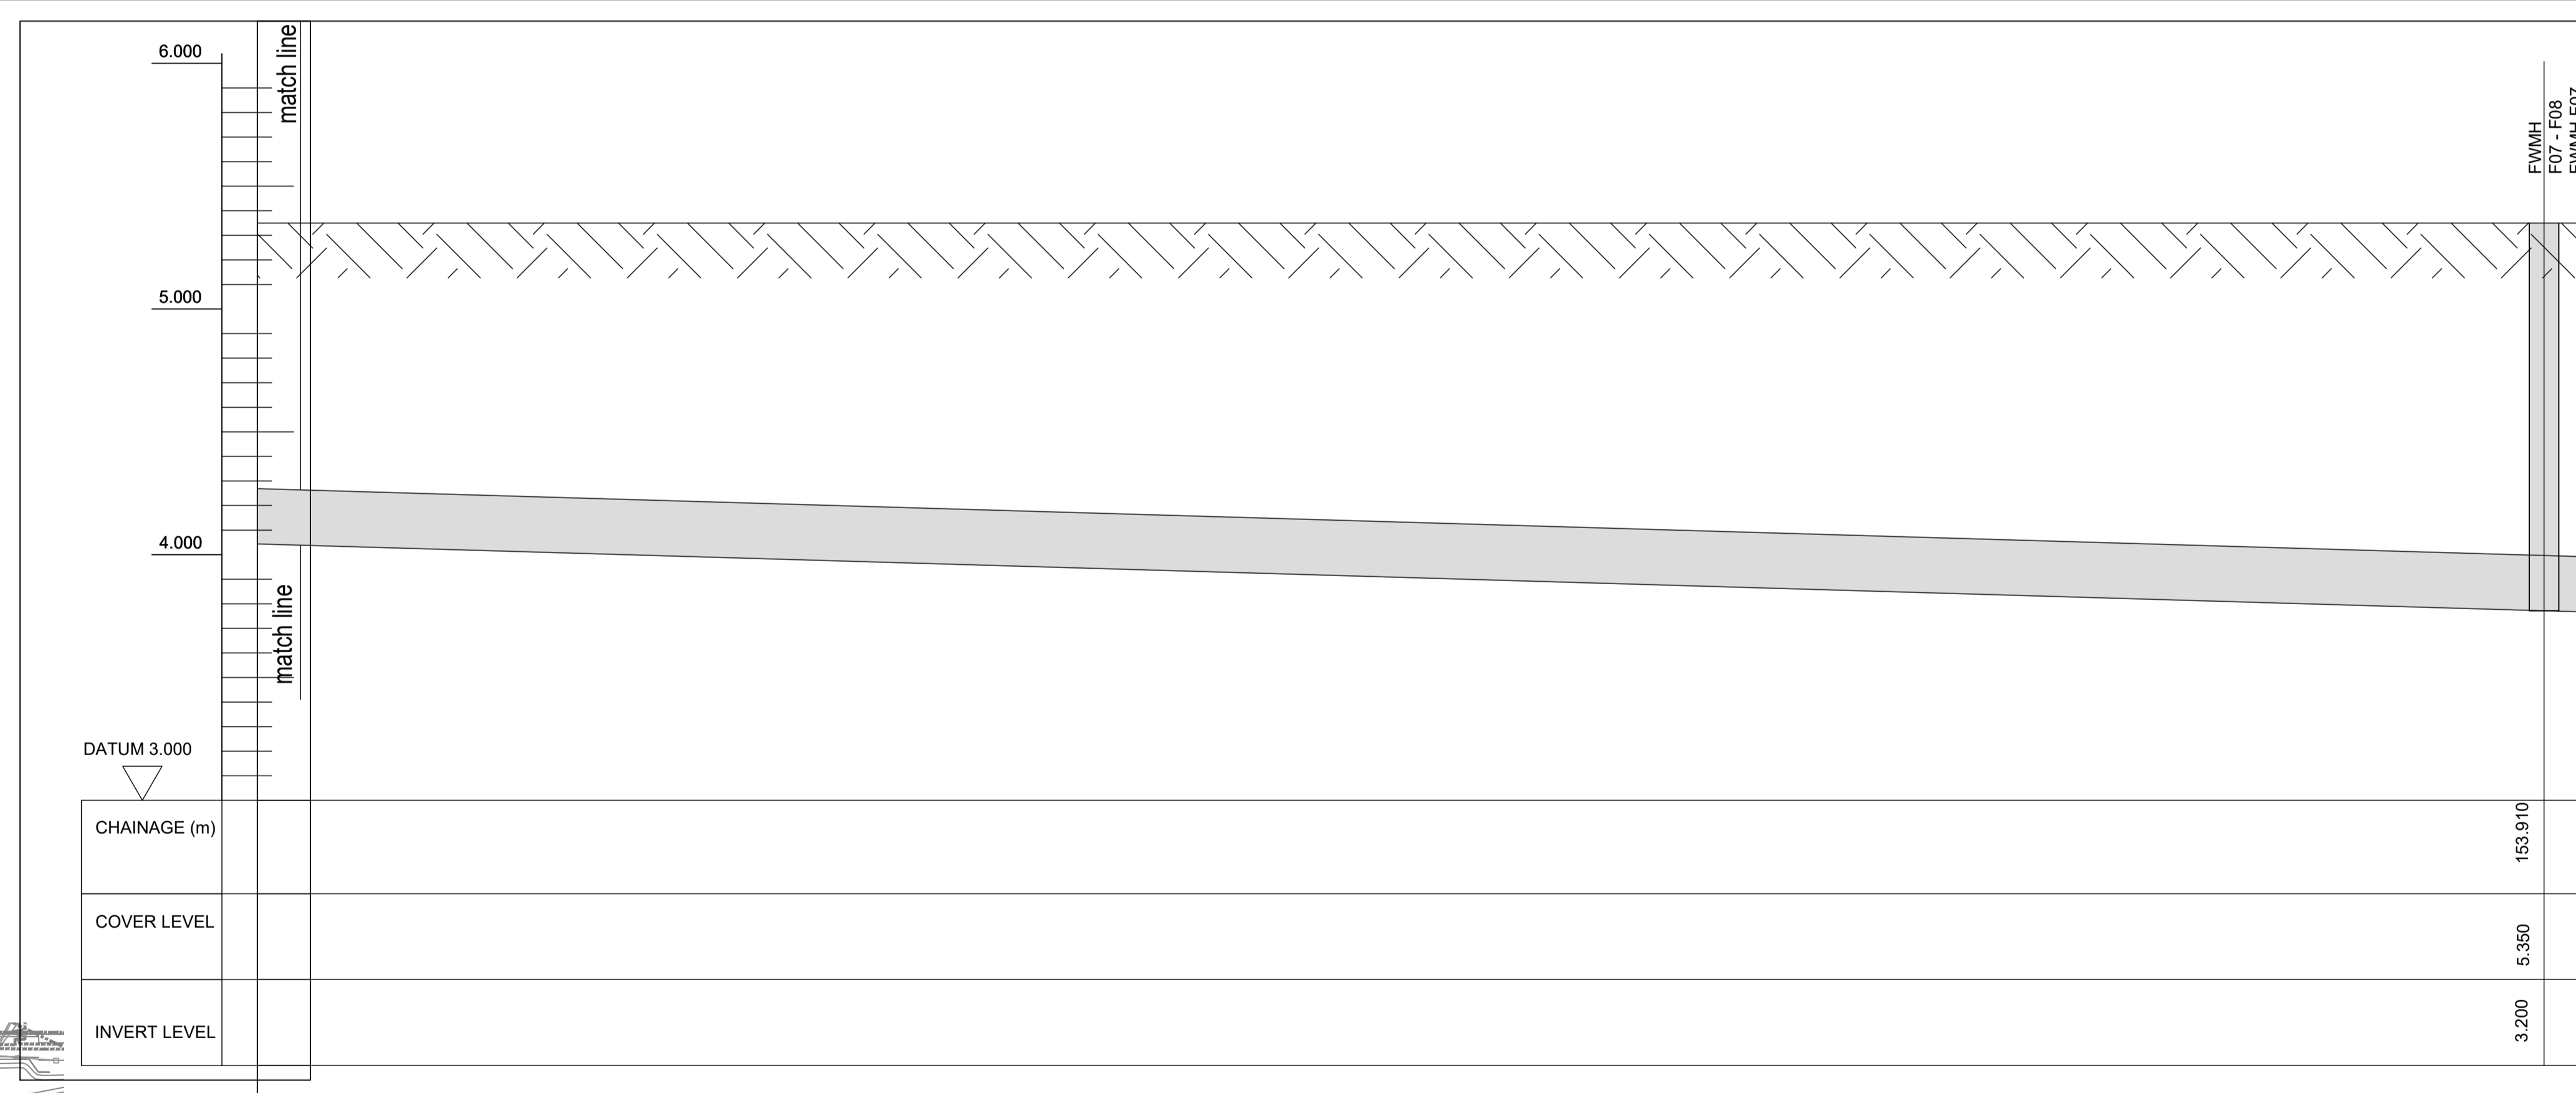

DATUM 3.000	
CHAINAGE (m)	153.910
COVER LEVEL	5.350
INVERT LEVEL	3.200

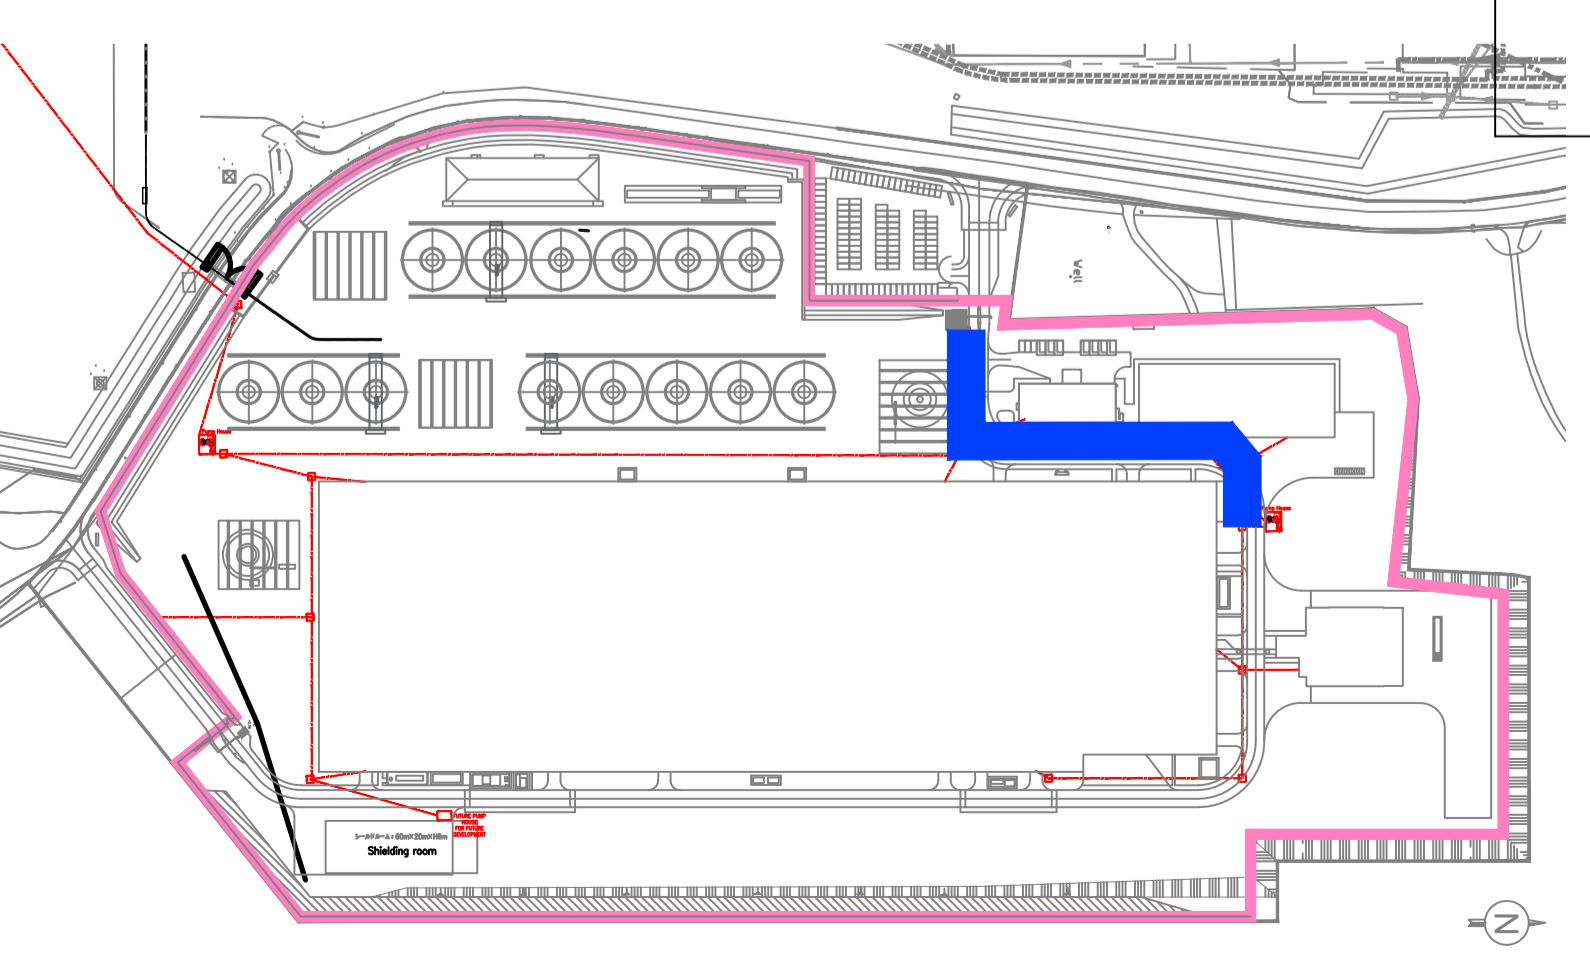

KEYPLAN

**STA CABLE FACTORY**  
SUMITOMO ELECTRIC NIGG, TAIN IV19 1QU

**eda** ARCHITECTS  
EDA Architects Ltd  
Omagh Enterprise Centre,  
41 Gortash Ind Est,  
Omagh BT78 5LU  
eoghan@eda-architects.com

REVISIONS

NO.	DATE	DESCRIPTION	CHK	DRN

P01	21/08/23	ISSUED FOR PLANNING	DC	DG
REV	DATE	DESCRIPTION	CHK	DRN

STATUS  
**PLANNING**

PROJECT  
**SEIUK - CL**

PROJECT ADDRESS  
-

DISCIPLINE  
**CIVIL**

DWG TITLE  
**Foul Water - Longitudinal Section - F05-F09 - 02/03**

DWG NO.  
**S-263-EUR-EXT-ZZ-DR-CS-6354**

STATUS CODE  
**C4**


PROJECT NO. **S-263** DATE **08/01/23**  
DRAWN / CHECKED **SVM/DC** SCALE NO. **1 : 100**

REVISION NUMBER  
**P01**



**EUROPLAN GROUP**  
Parkview House, Beechill Office Campus,  
Clonskeagh, Dublin 4, Eire.  
Tel: +353 1 2606578  
staprojectteam@europlanservices.com

ALL DIMENSIONS TO BE CHECKED ON SITE.  
NO DIMENSIONS TO BE SCALED FROM THIS  
DRAWING. DRAWINGS IS TO BE READ IN  
CONJUNCTION WITH RELEVANT  
CONSULTANTS DRAWINGS.

SITE KEY PLAN

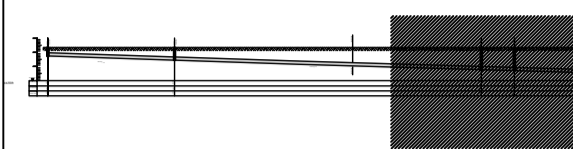

LEGEND

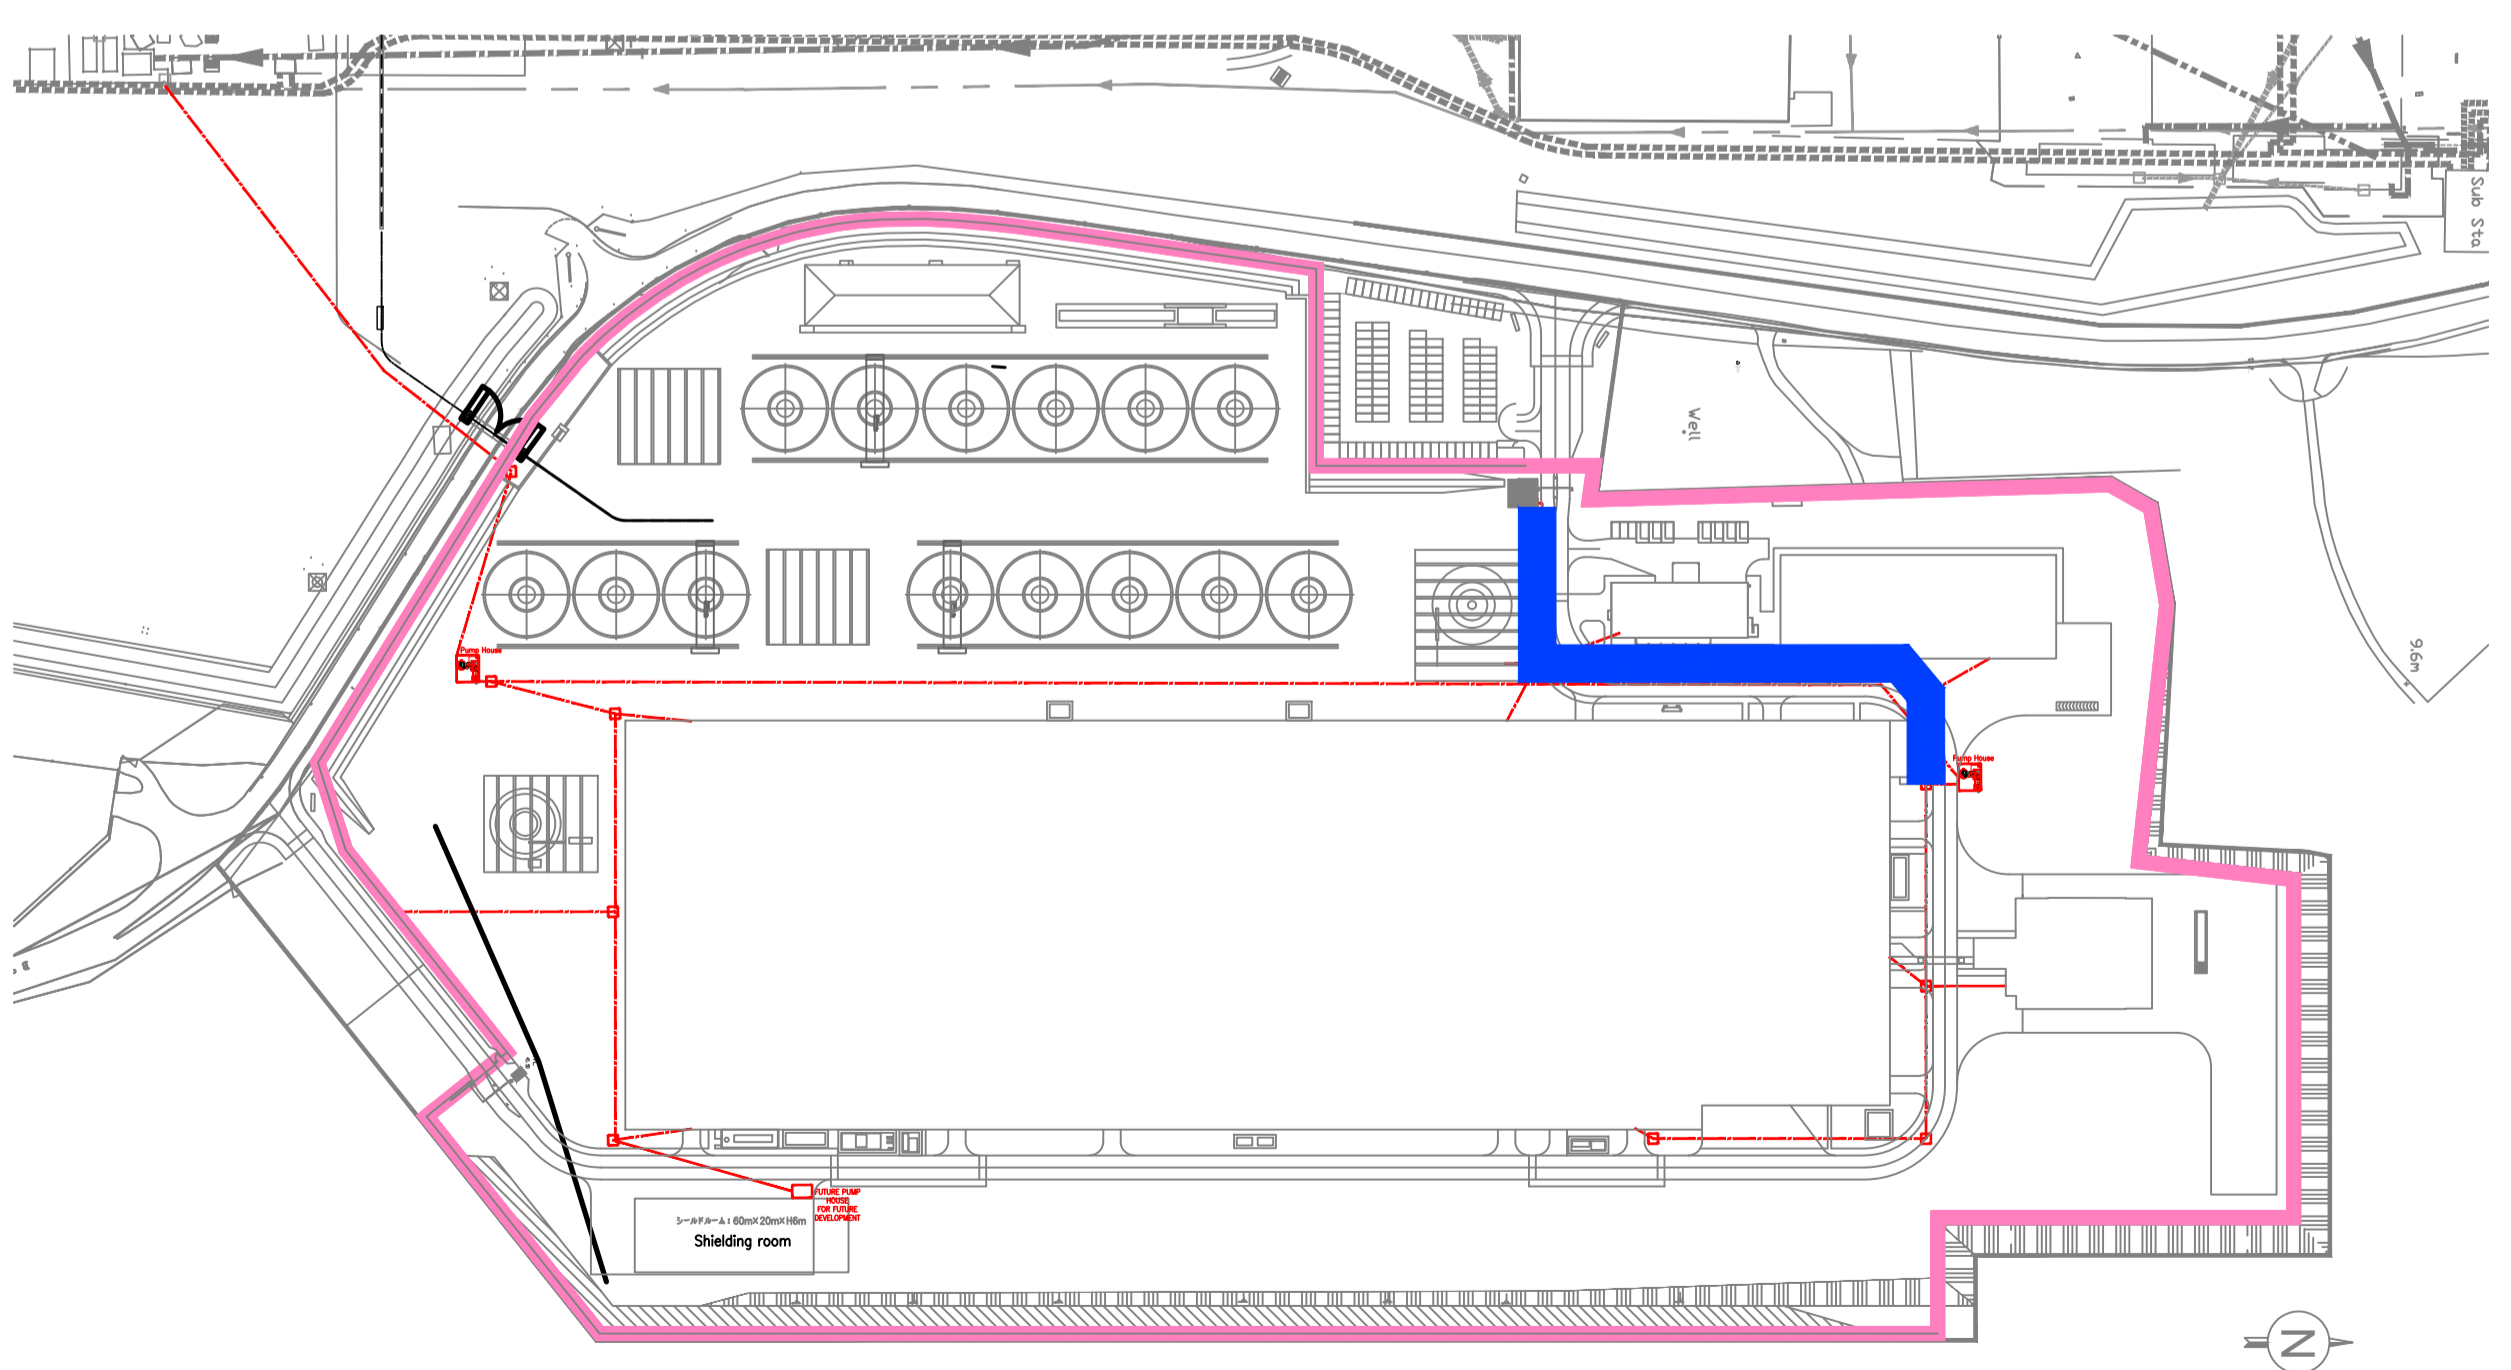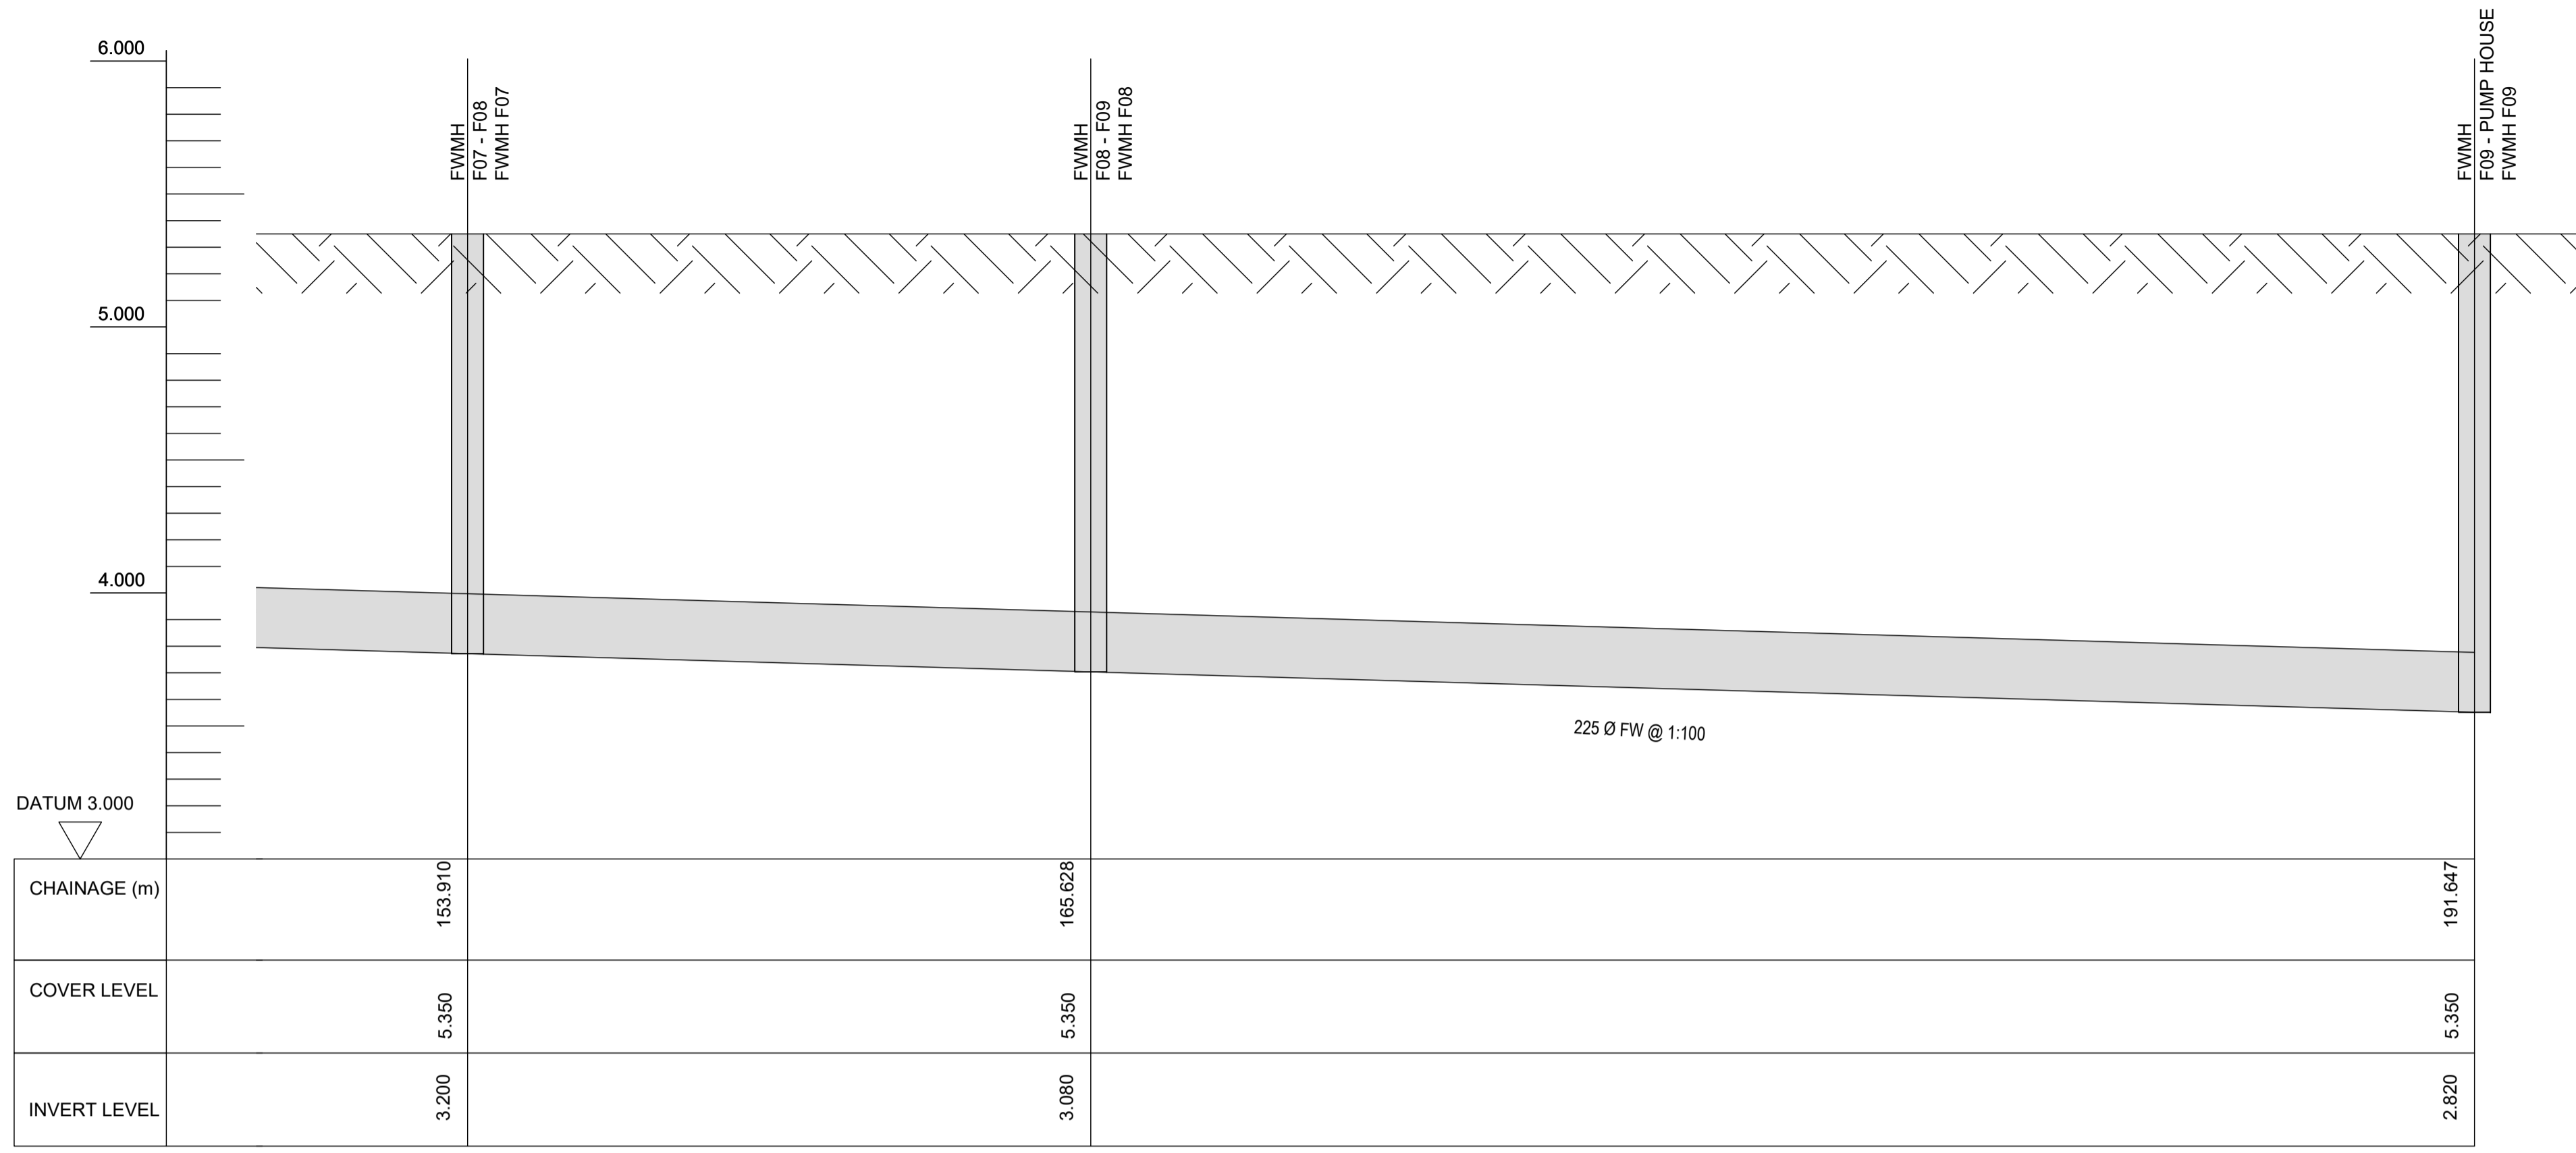

KEYPLAN

**SUMITOMO ELECTRIC** STA CABLE FACTORY  
NIGG, TAIN IV19 1QU

**eda** ARCHITECTS  
EDA Architects Ltd  
Omagh Enterprise Centre,  
41 Gortash Ind Est,  
Omagh BT78 5LU  
eoghan@eda-architects.com

REVISIONS

REV	DATE	DESCRIPTION	CHK	DRN

P01	21/08/23	ISSUED FOR PLANNING	DC	DG
REV	DATE	DESCRIPTION	CHK	DRN
STATUS				
PLANNING				
PROJECT				
SEIUK - CL				
PROJECT ADDRESS				
-				
DISCIPLINE				
CIVIL				
DWG TITLE				
Foul Water - Longitudinal Section - F05-F09 - 03/03				
DWG NO.				
S-263-EUR-EXT-ZZ-DR-CS-6355				
STATUS CODE				
C4				
PROJECT NO.		DATE		
S-263		08/01/23		
DRAWN / CHECKED		SCALE NO.		
SVM/DC		1 : 100		


REVISION NUMBER

**P01**


**EUROPLAN GROUP**  
Parkview House, Beechill Office Campus,  
Clonskeagh, Dublin 4, Eire.  
Tel: +353 1 2606578  
staprojectteam@euoplanservices.com

ALL DIMENSIONS TO BE CHECKED ON SITE. NO DIMENSIONS TO BE SCALED FROM THIS DRAWING. DRAWING IS TO BE READ IN CONJUNCTION WITH RELEVANT CONSULTANTS DRAWINGS.


SITE KEY PLAN

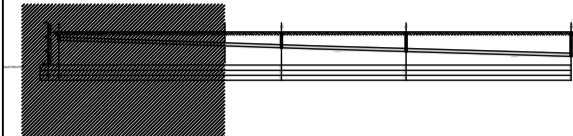


LEGEND

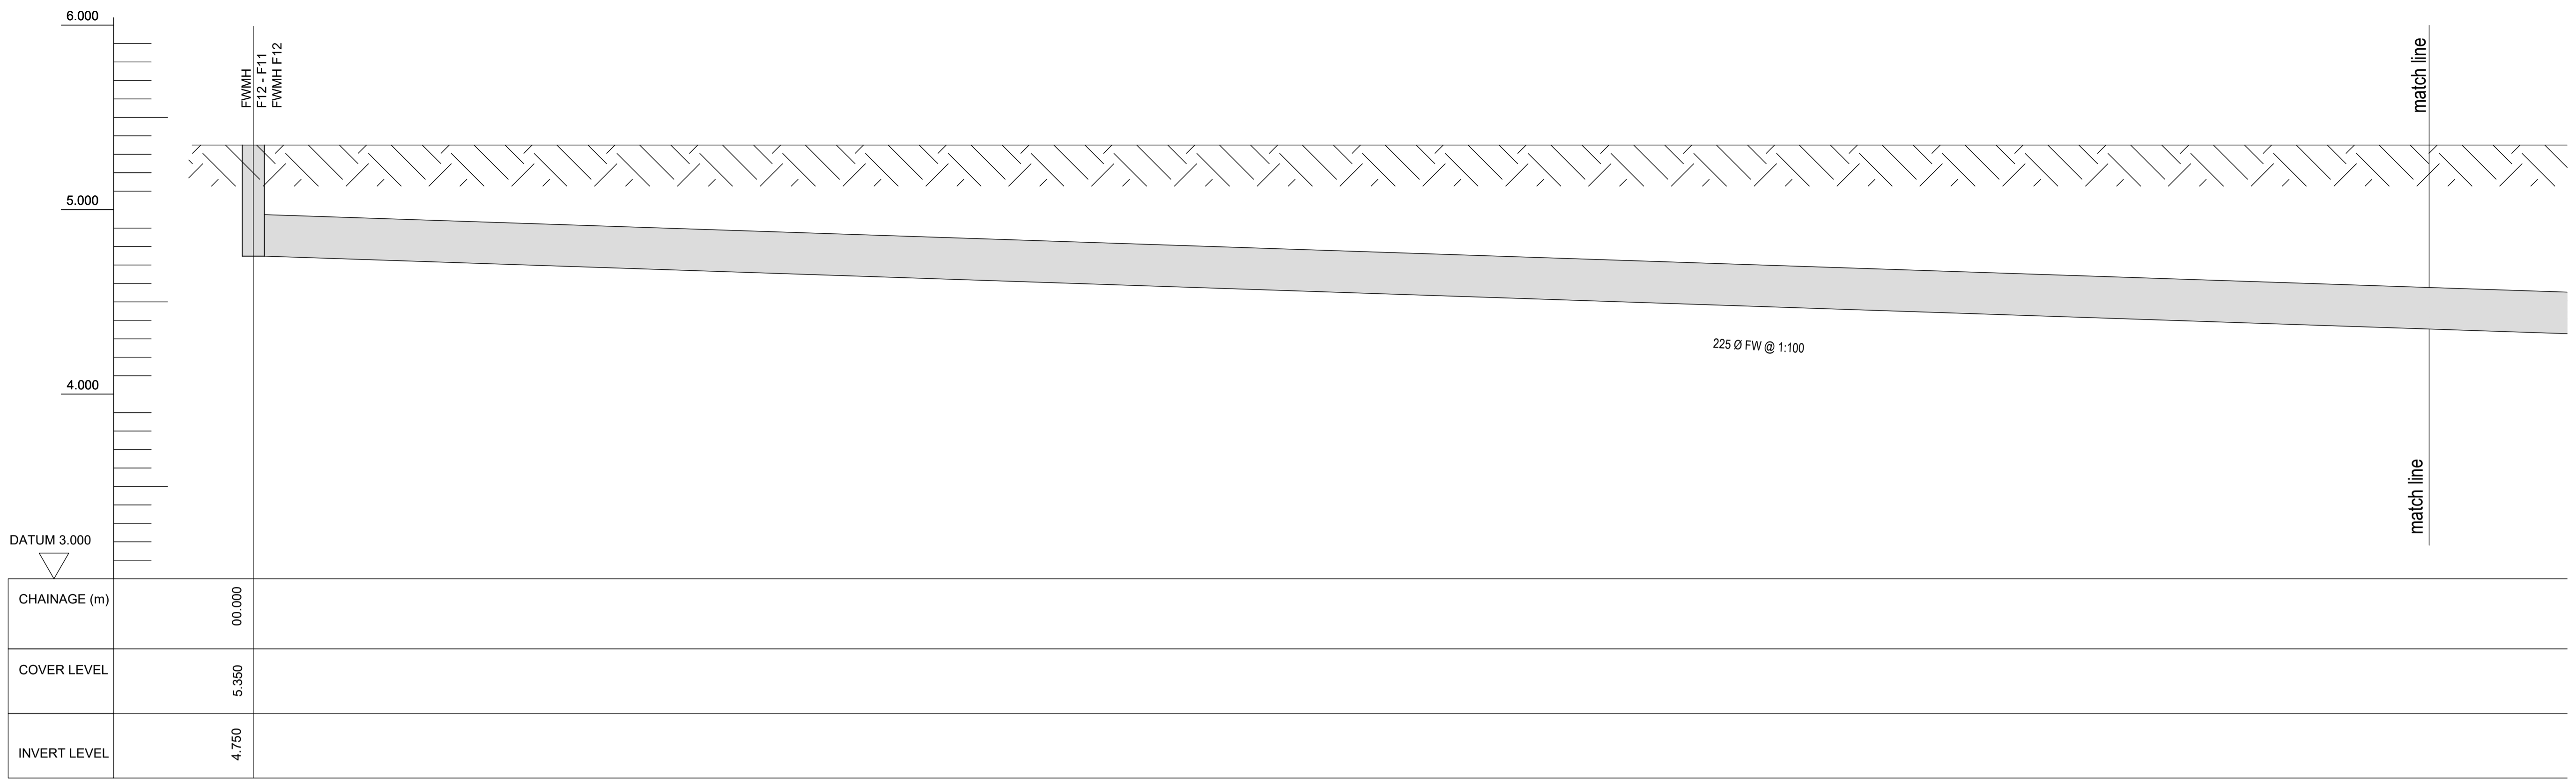

CHAINAGE (m)	00.000
COVER LEVEL	5.350
INVERT LEVEL	4.750

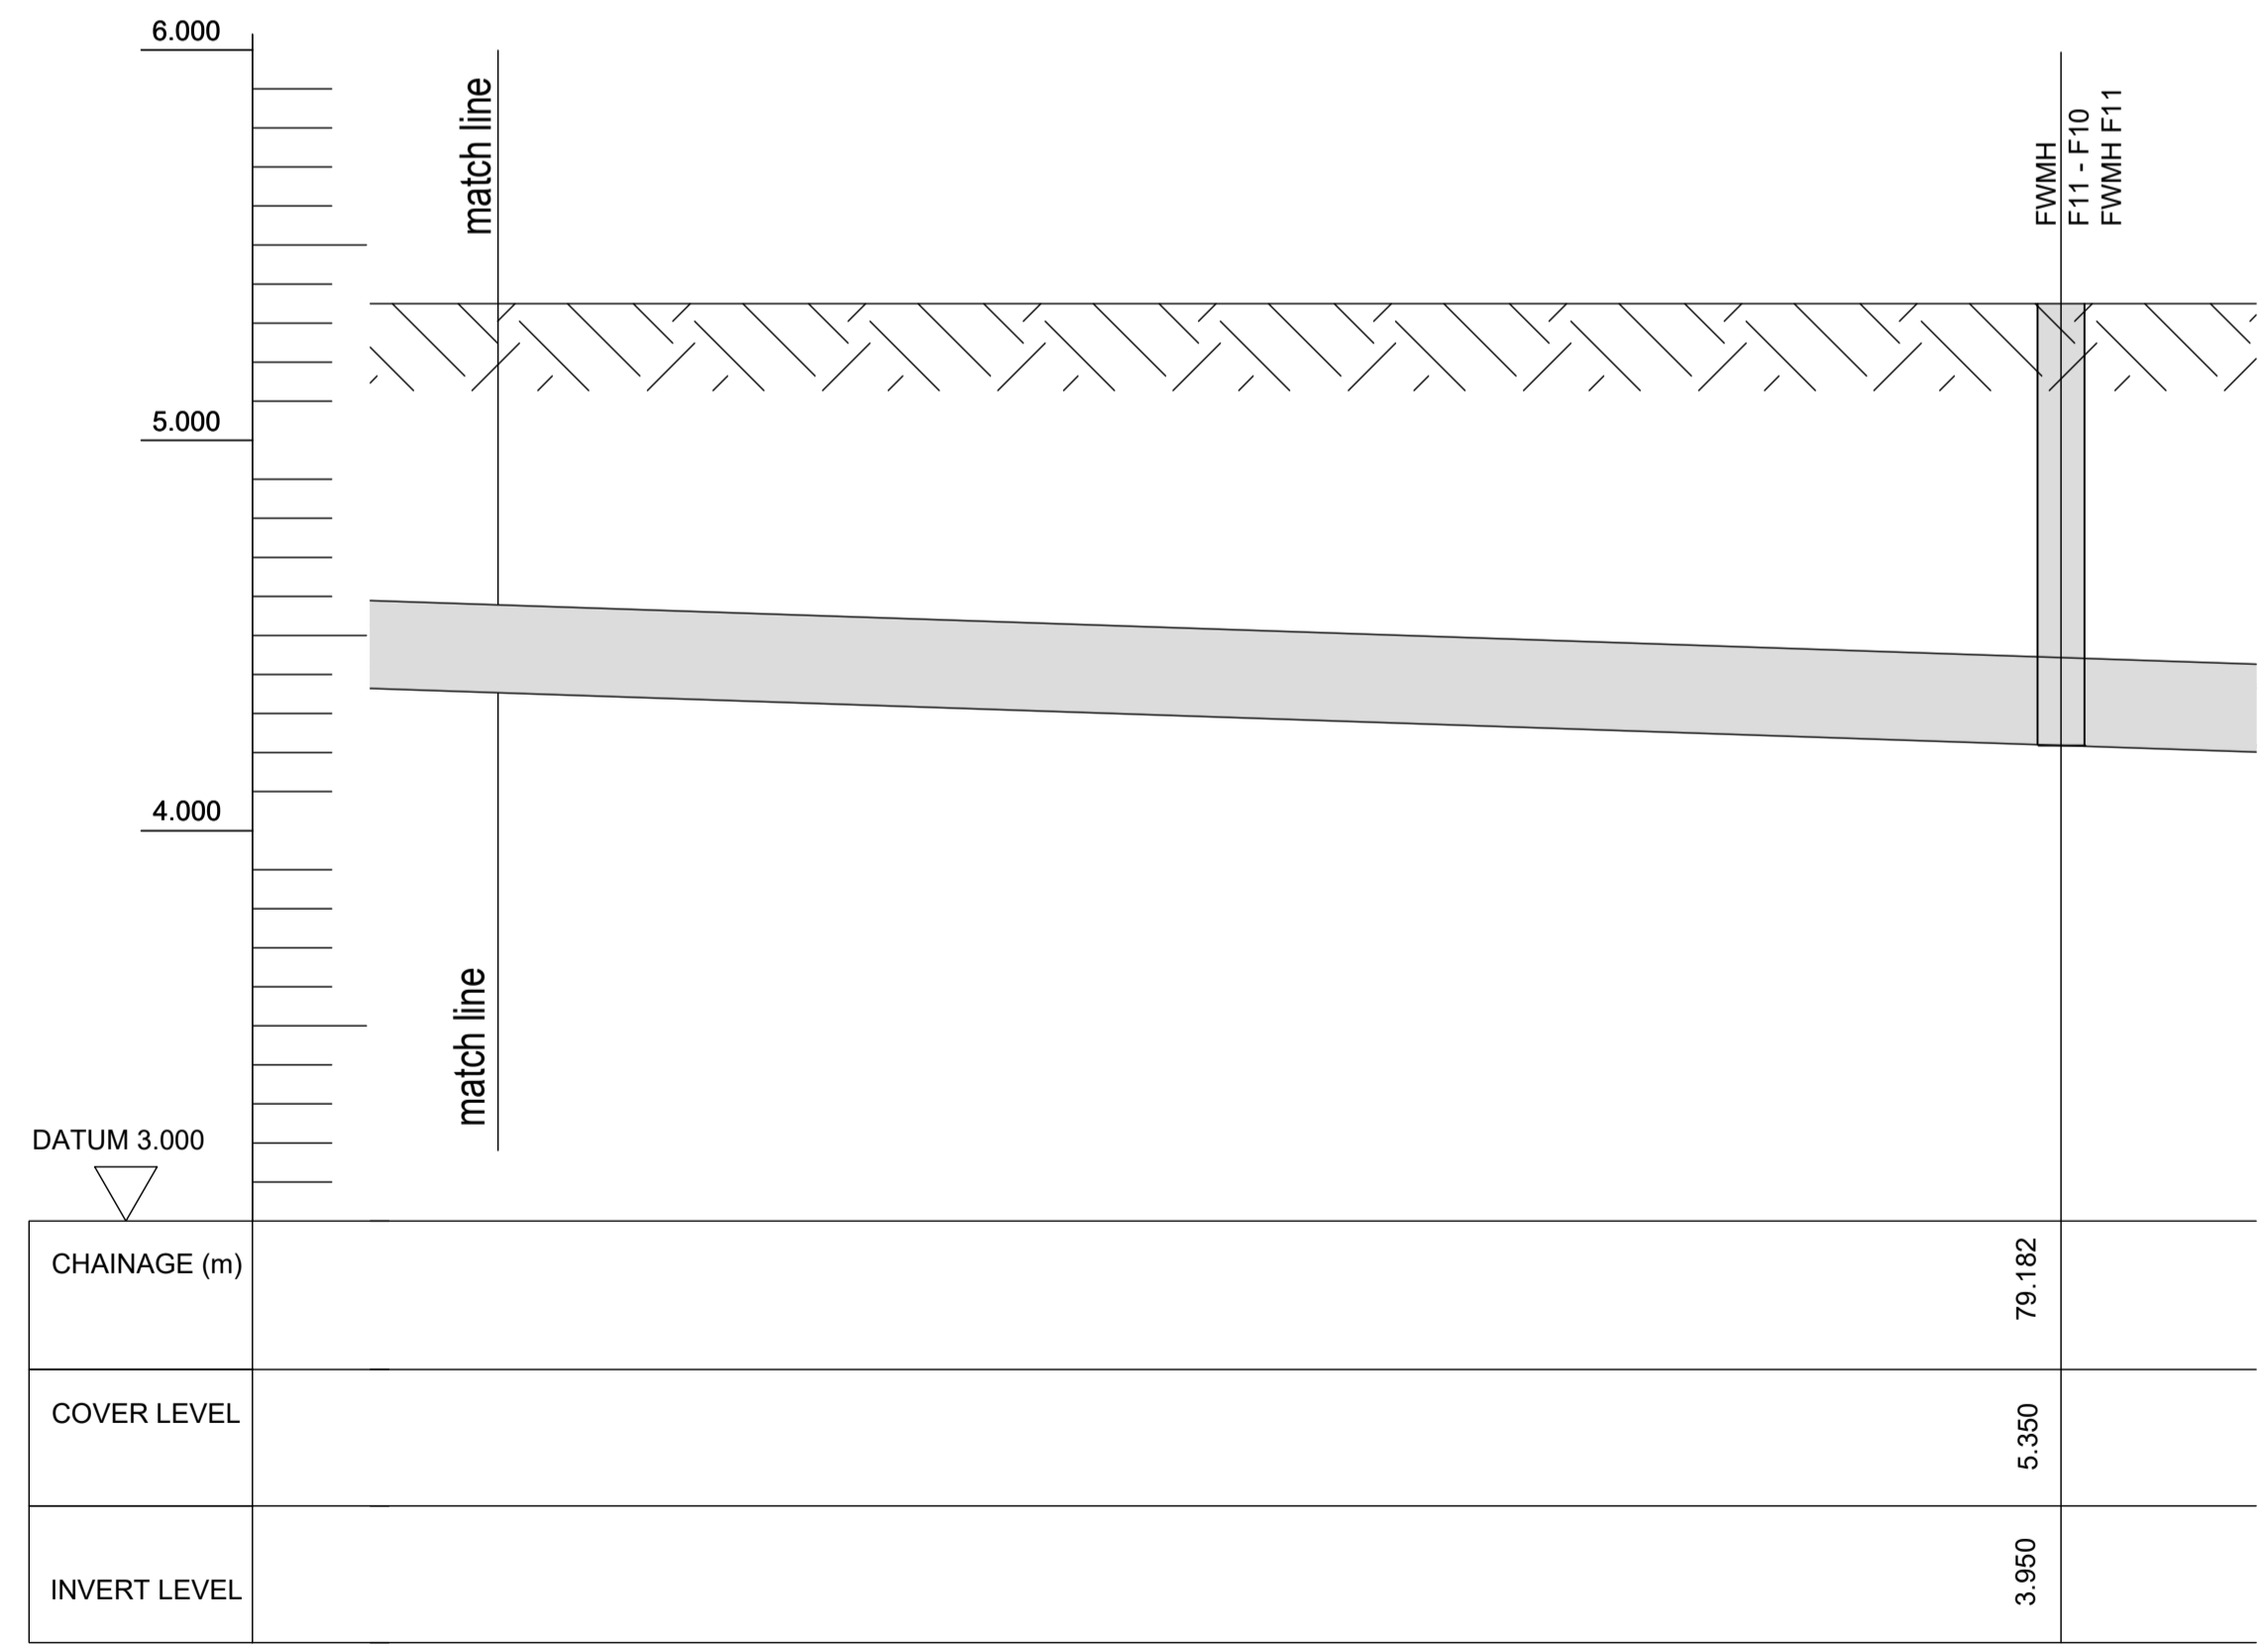

CHAINAGE (m)	79.182
COVER LEVEL	5.350
INVERT LEVEL	3.950

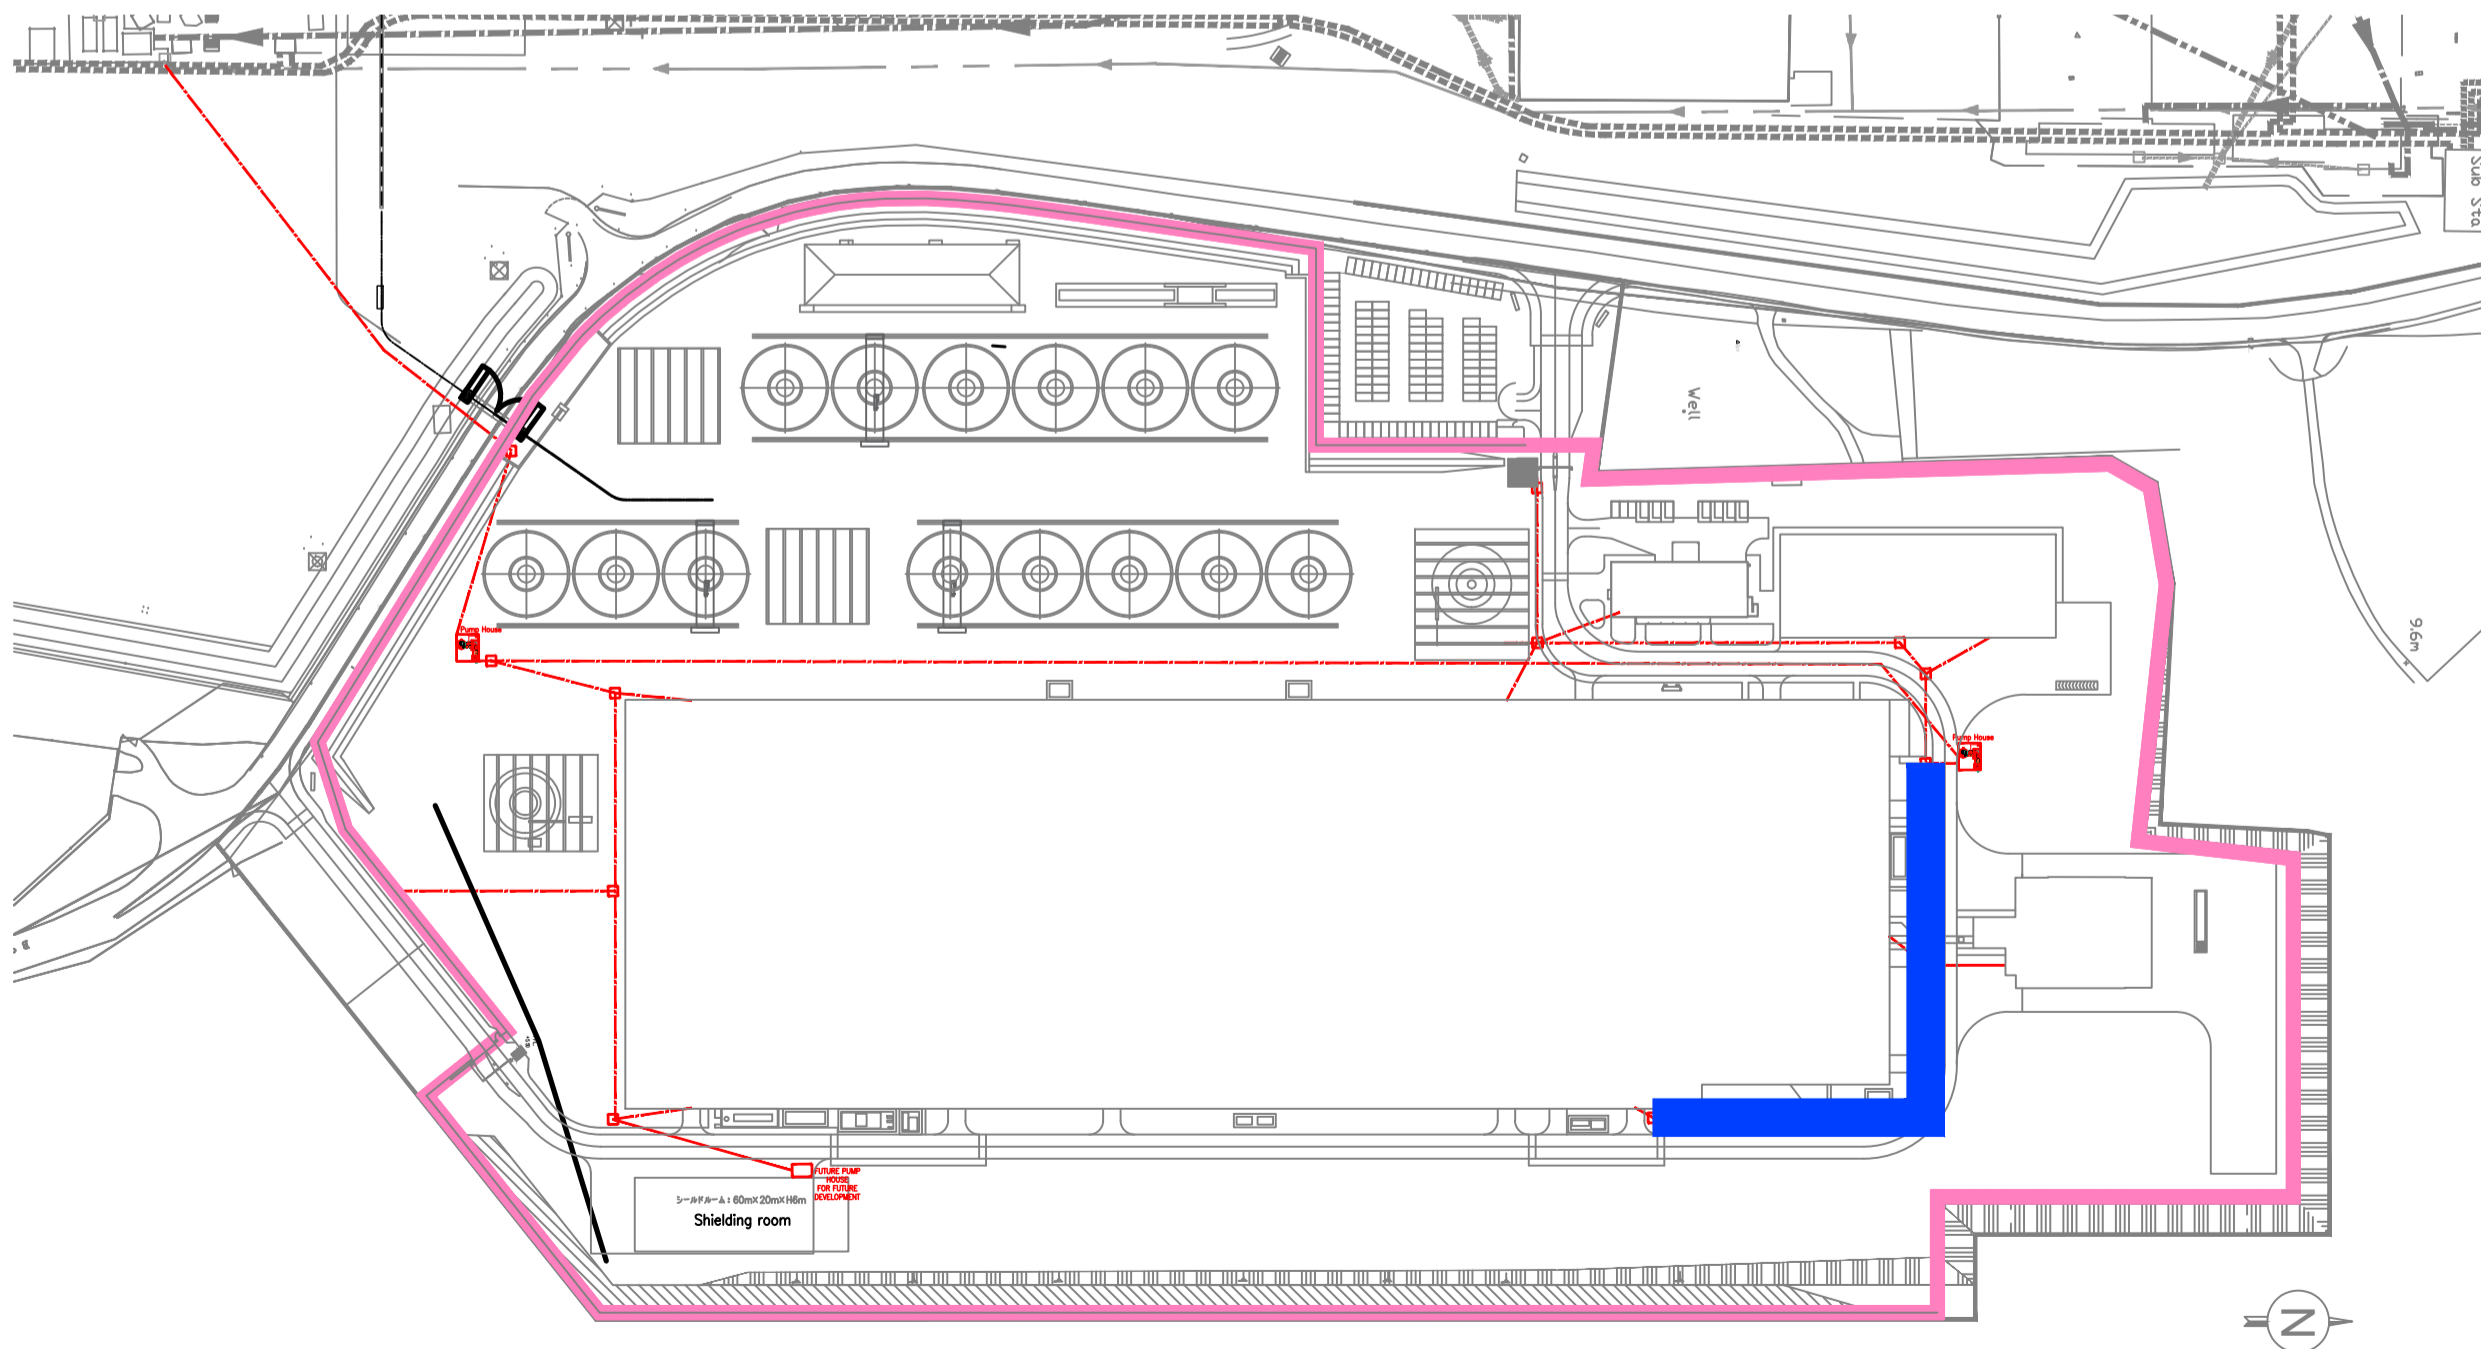

KEYPLAN

**SUMITOMO ELECTRIC** STA CABLE FACTORY  
NIGG, TAIN IV19 1QU

**eda** ARCHITECTS  
EDA Architects Ltd  
Omagh Enterprise Centre,  
41 Gortnah 1st Est,  
Omagh BT78 5LU  
eoghan@eda-architects.com

REVISIONS

NO.	DATE	DESCRIPTION	CHK	DRN


P01	21/08/23	ISSUED FOR PLANNING	DC	DG
REV	DATE	DESCRIPTION	CHK	DRN
STATUS				
PLANNING				
PROJECT				
SEIUK - CL				
PROJECT ADDRESS				
-				
DISCIPLINE				
CIVIL				
DWG TITLE				
Foul Water - Longitudinal Section - F12-F09 - 01/03				

DWG NO.		S-263-EUR-EXT-ZZ-DR-CS-6356	
STATUS CODE		C4	
PROJECT NO.	S-263	DATE	08/01/23
DRAWN / CHECKED	SVM/DC	SCALE NO.	1 : 100


REVISION NUMBER **P01**

**EUROPLAN GROUP**  
Parkview House, Beechill Office Campus,  
Clonskeagh, Dublin 4, Eire.  
Tel: +353 1 2606578  
staprojectteam@europlanservices.com

ALL DIMENSIONS TO BE CHECKED ON SITE.  
NO DIMENSIONS TO BE SCALED FROM THIS  
DRAWING. DRAWING IS TO BE READ IN  
CONJUNCTION WITH RELEVANT  
CONSULTANTS DRAWINGS.

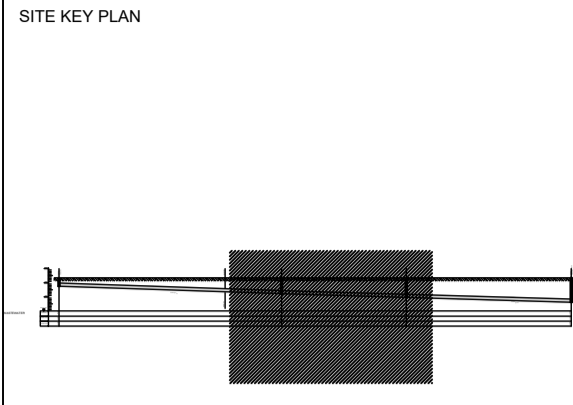

LEGEND

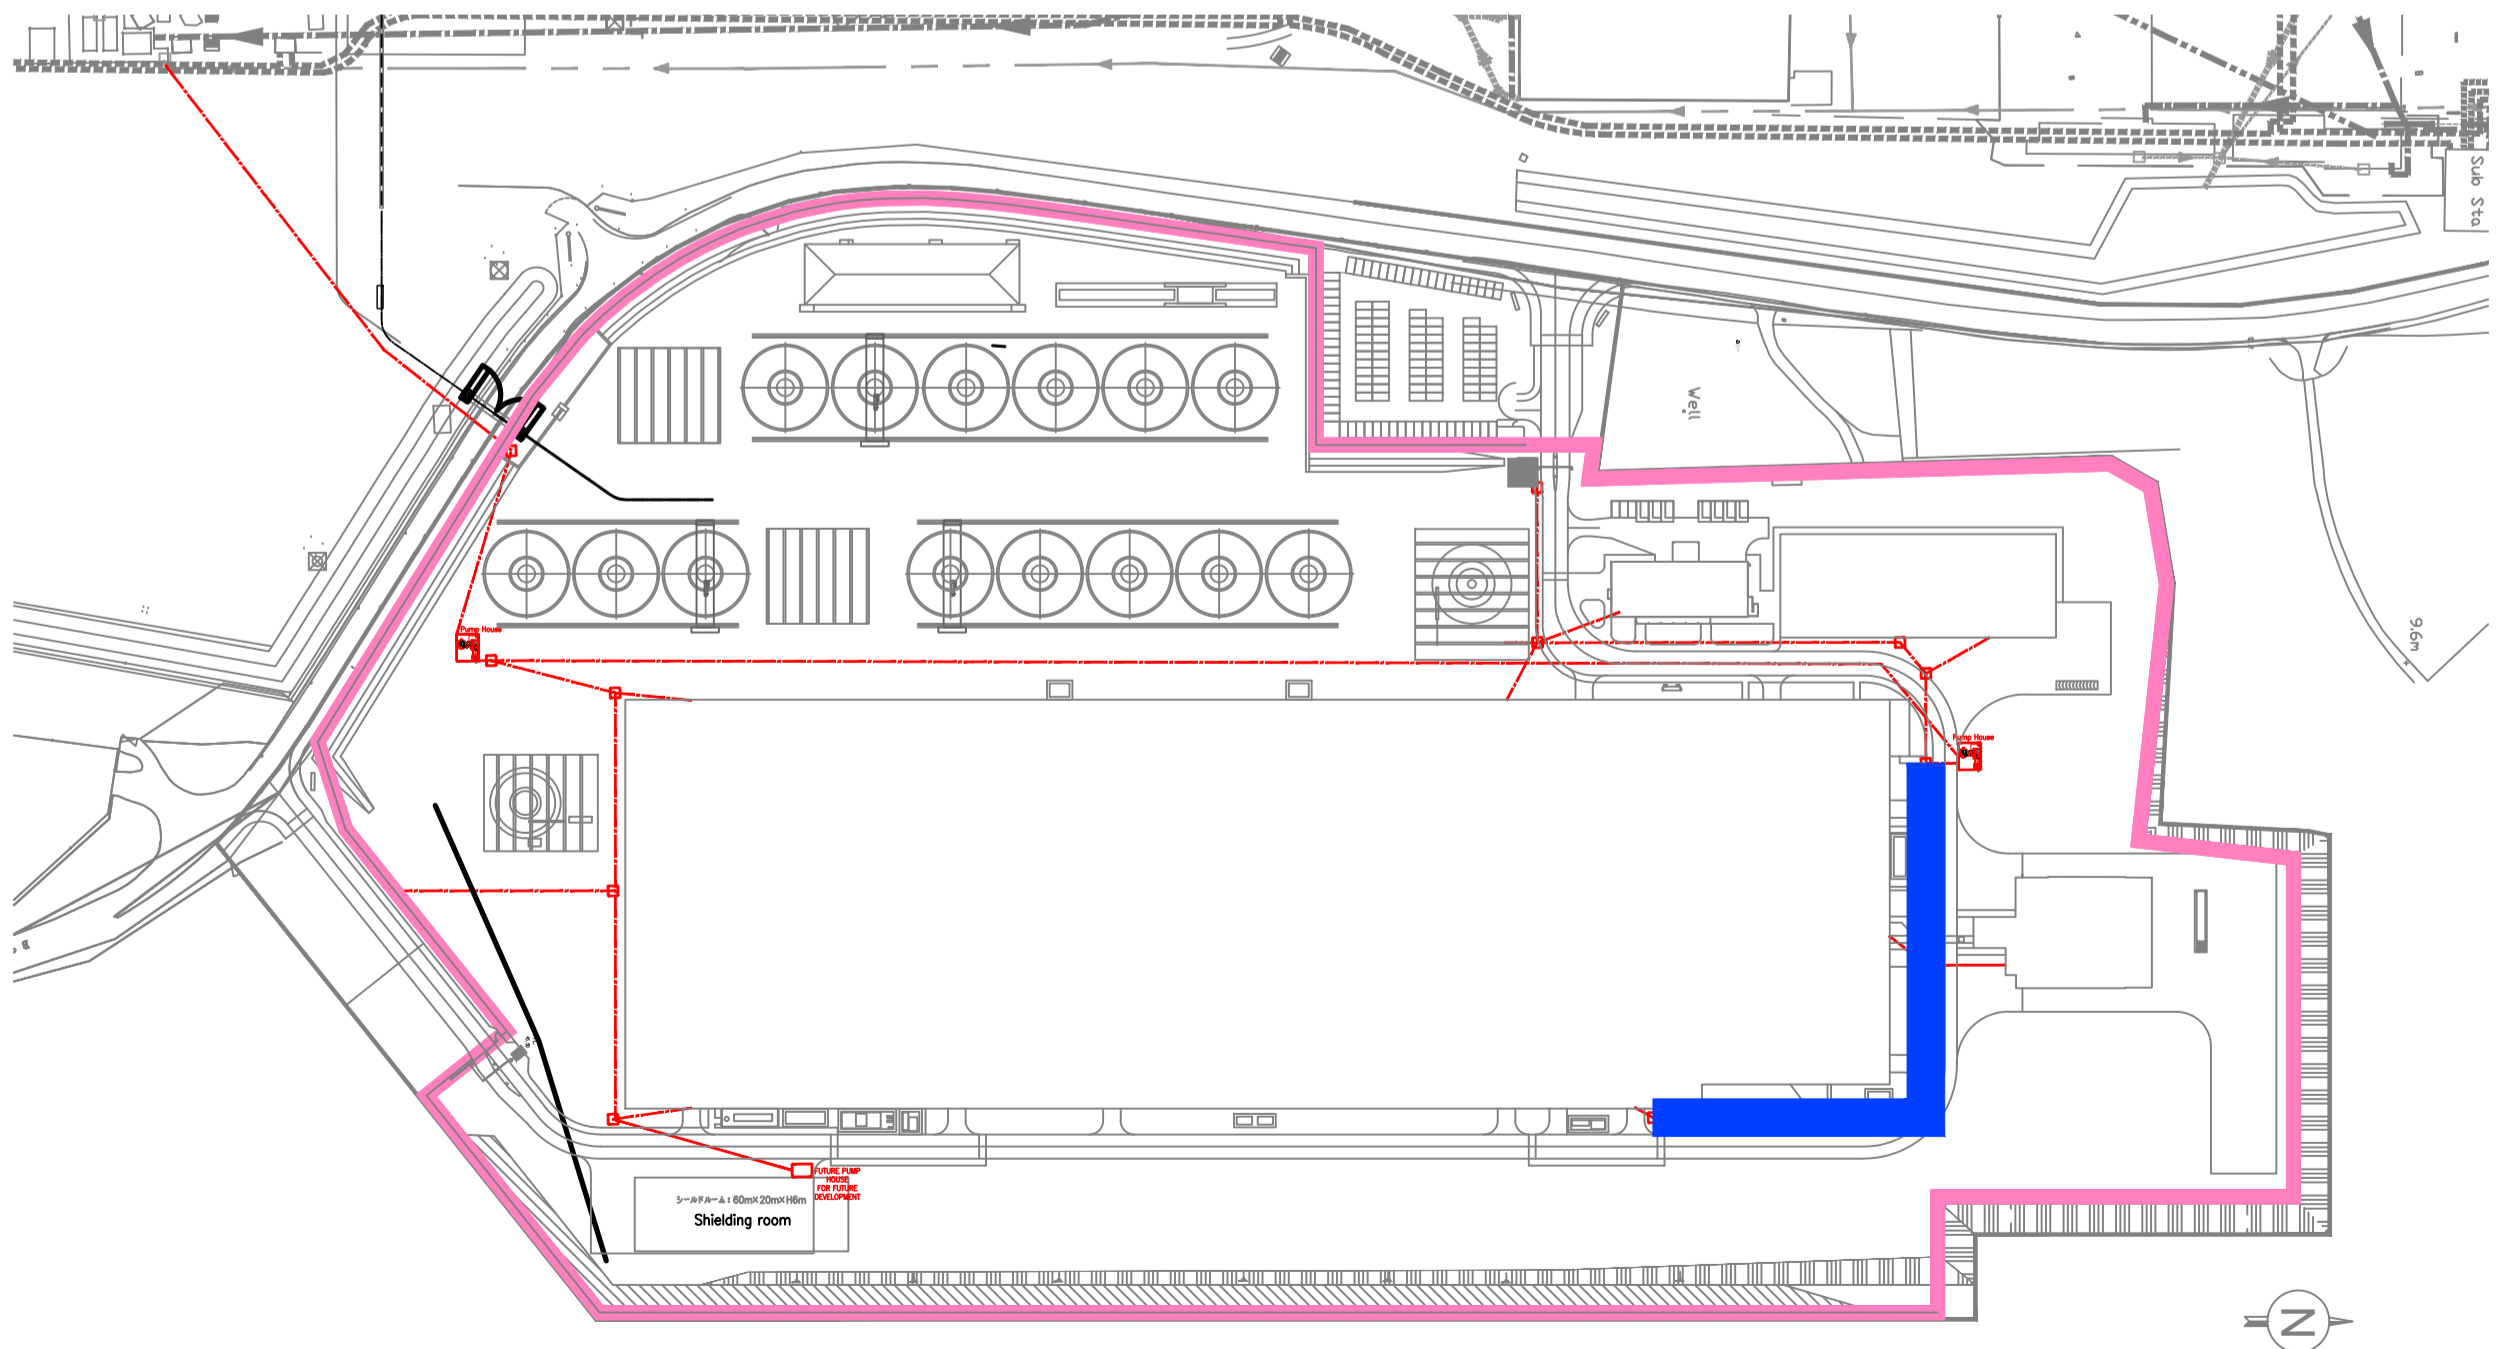

KEYPLAN

**SUMITOMO ELECTRIC** STA CABLE FACTORY  
NIGG, TAIN IV19 1QU

**eda** ARCHITECTS  
EDA Architects Ltd  
Omagh Enterprise Centre,  
41 Gortnah 1st Est,  
Omagh BT78 5LU  
eoghan@eda-architects.com

REVISIONS

REV	DATE	DESCRIPTION	CHK	DRN

P01	21/08/23	ISSUED FOR PLANNING	DC	DG
-----	----------	---------------------	----	----

STATUS: **PLANNING**

PROJECT: **SEIUK - CL**

PROJECT ADDRESS: -

DISCIPLINE: **CIVIL**

DWG TITLE: **Foul Water - Longitudinal Section - F12-F09 - 02/03**

DWG NO.: **S-263-EUR-EXT-ZZ-DR-CS-6357**

STATUS CODE: **C4**

PROJECT NO.	DATE
S-263	08/01/23

DRAWN / CHECKED	SCALE NO.
SVM/DC	1 : 100

REVISION NUMBER

**P01**


**EUROPLAN GROUP**

Parkview House, Beechill Office Campus,  
Clonskeagh, Dublin 4, Eire.  
Tel: +353 1 2606578  
staprojectteam@europlanservices.com





ALL DIMENSIONS TO BE CHECKED ON SITE.  
NO DIMENSIONS TO BE SCALED FROM THIS  
DRAWING. DRAWING IS TO BE READ IN  
CONJUNCTION WITH RELEVANT  
CONSULTANTS DRAWINGS.

SITE KEY PLAN

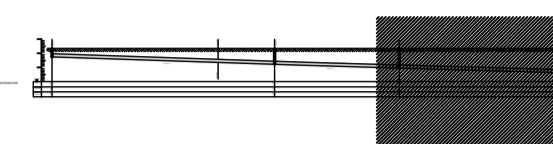

LEGEND

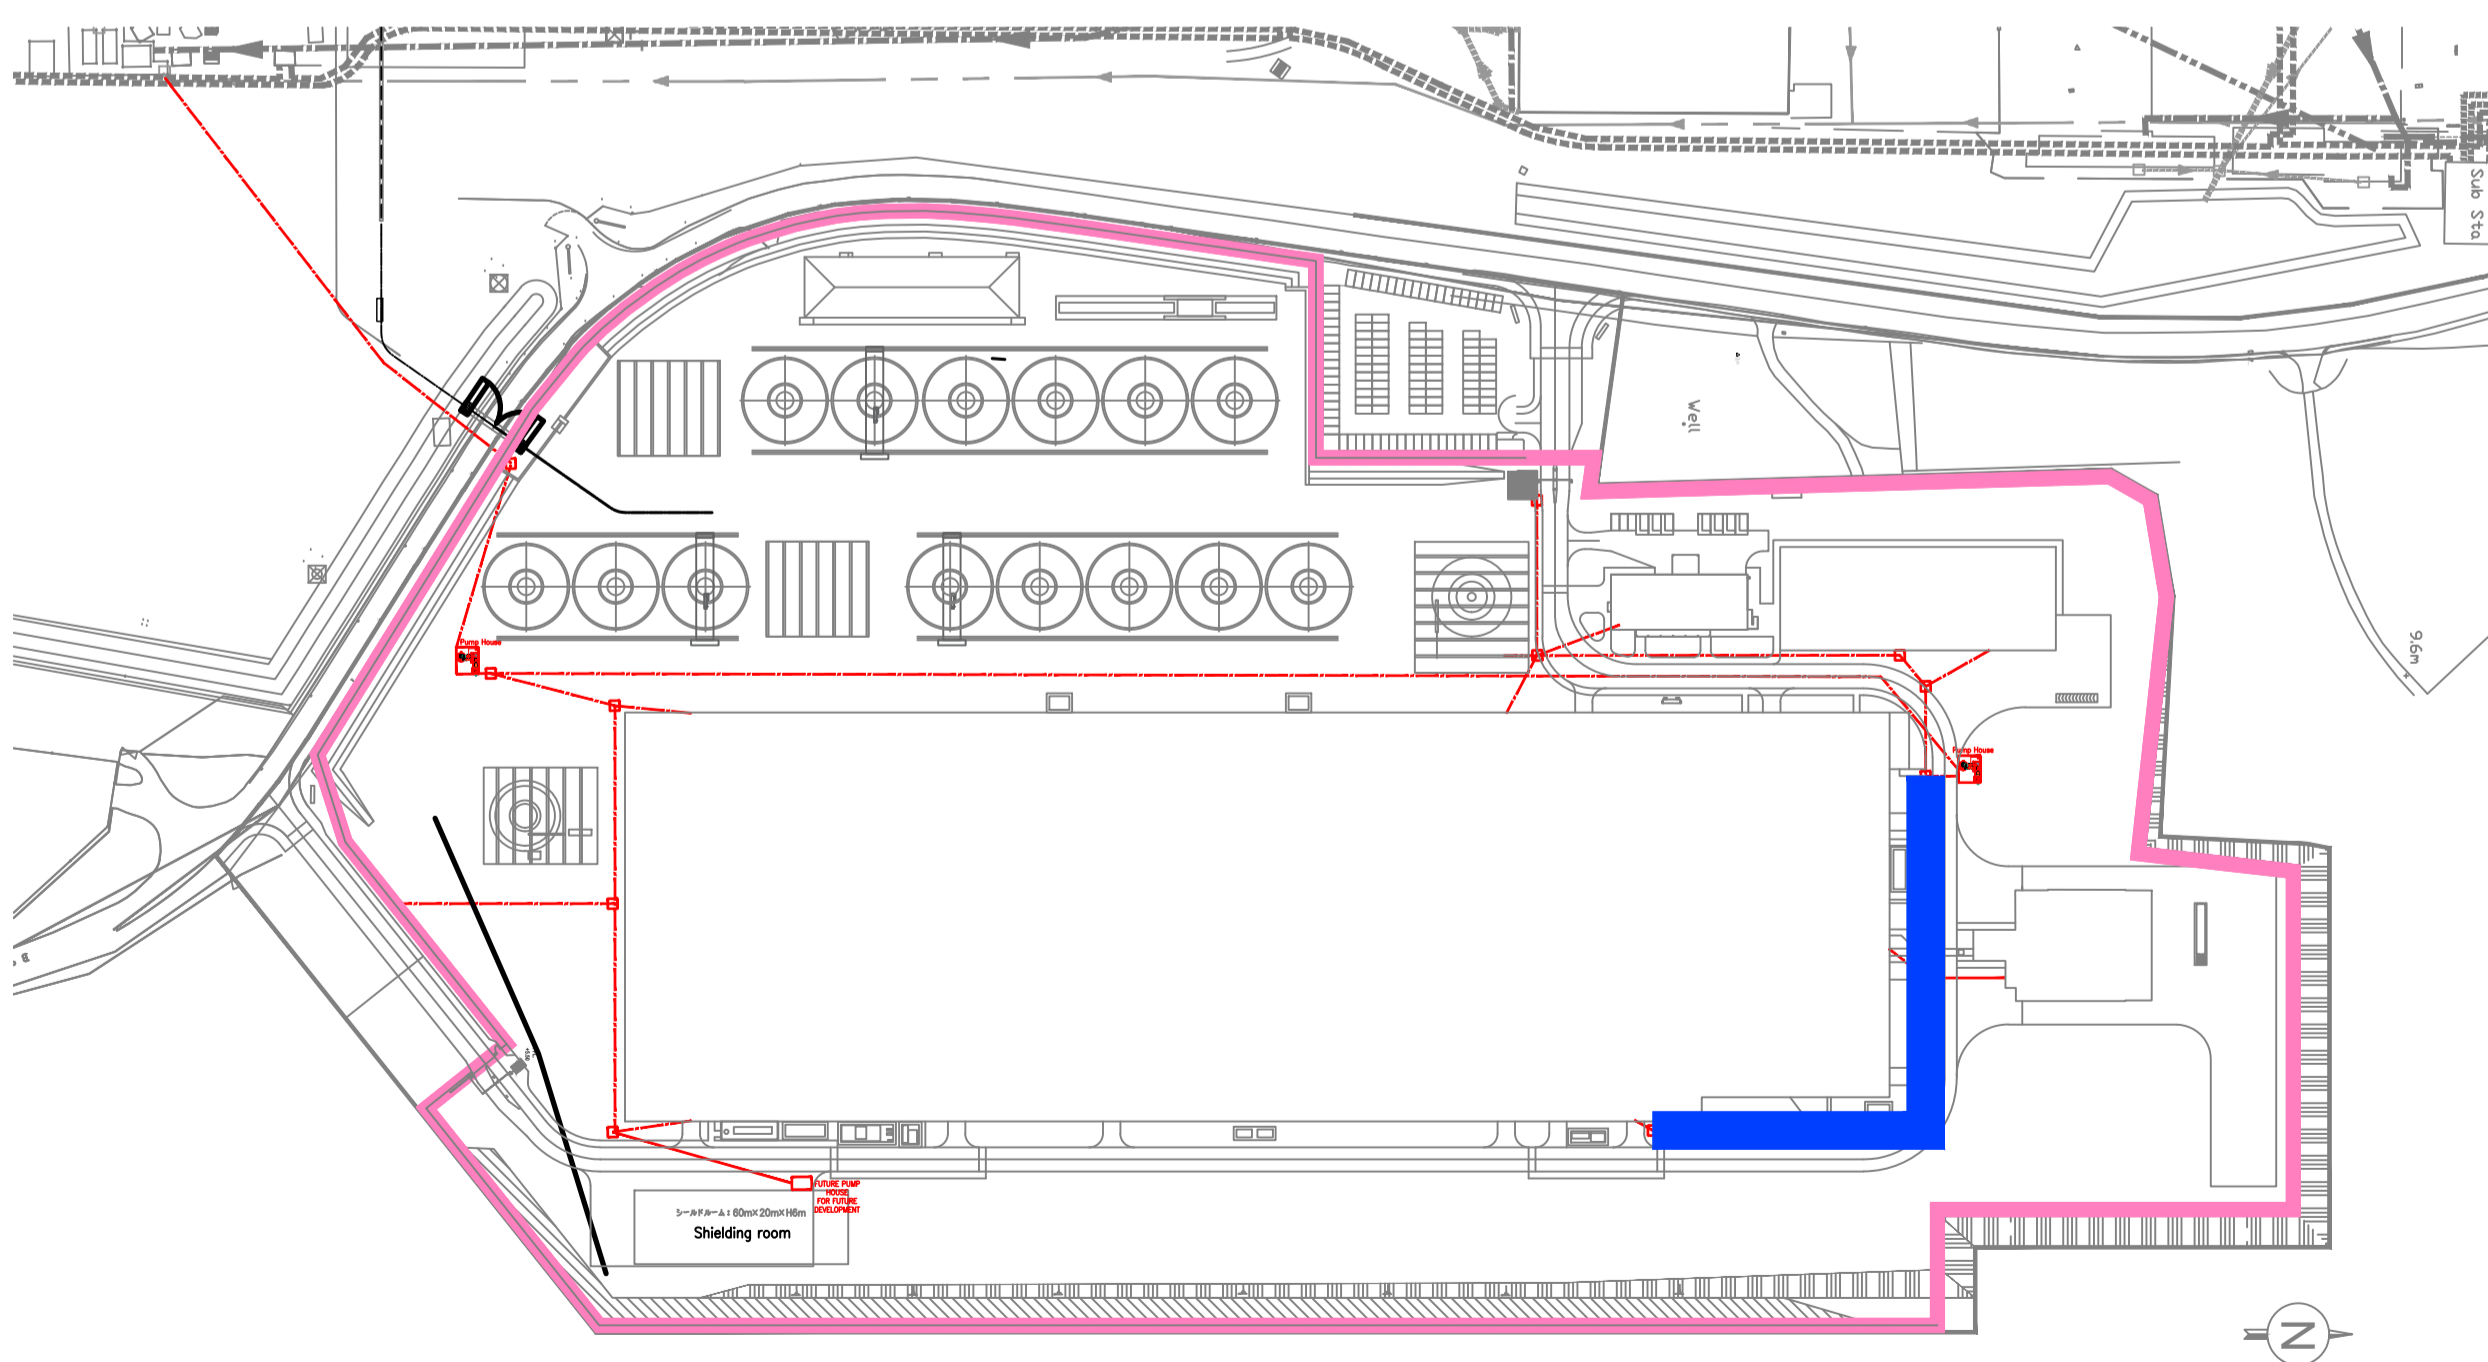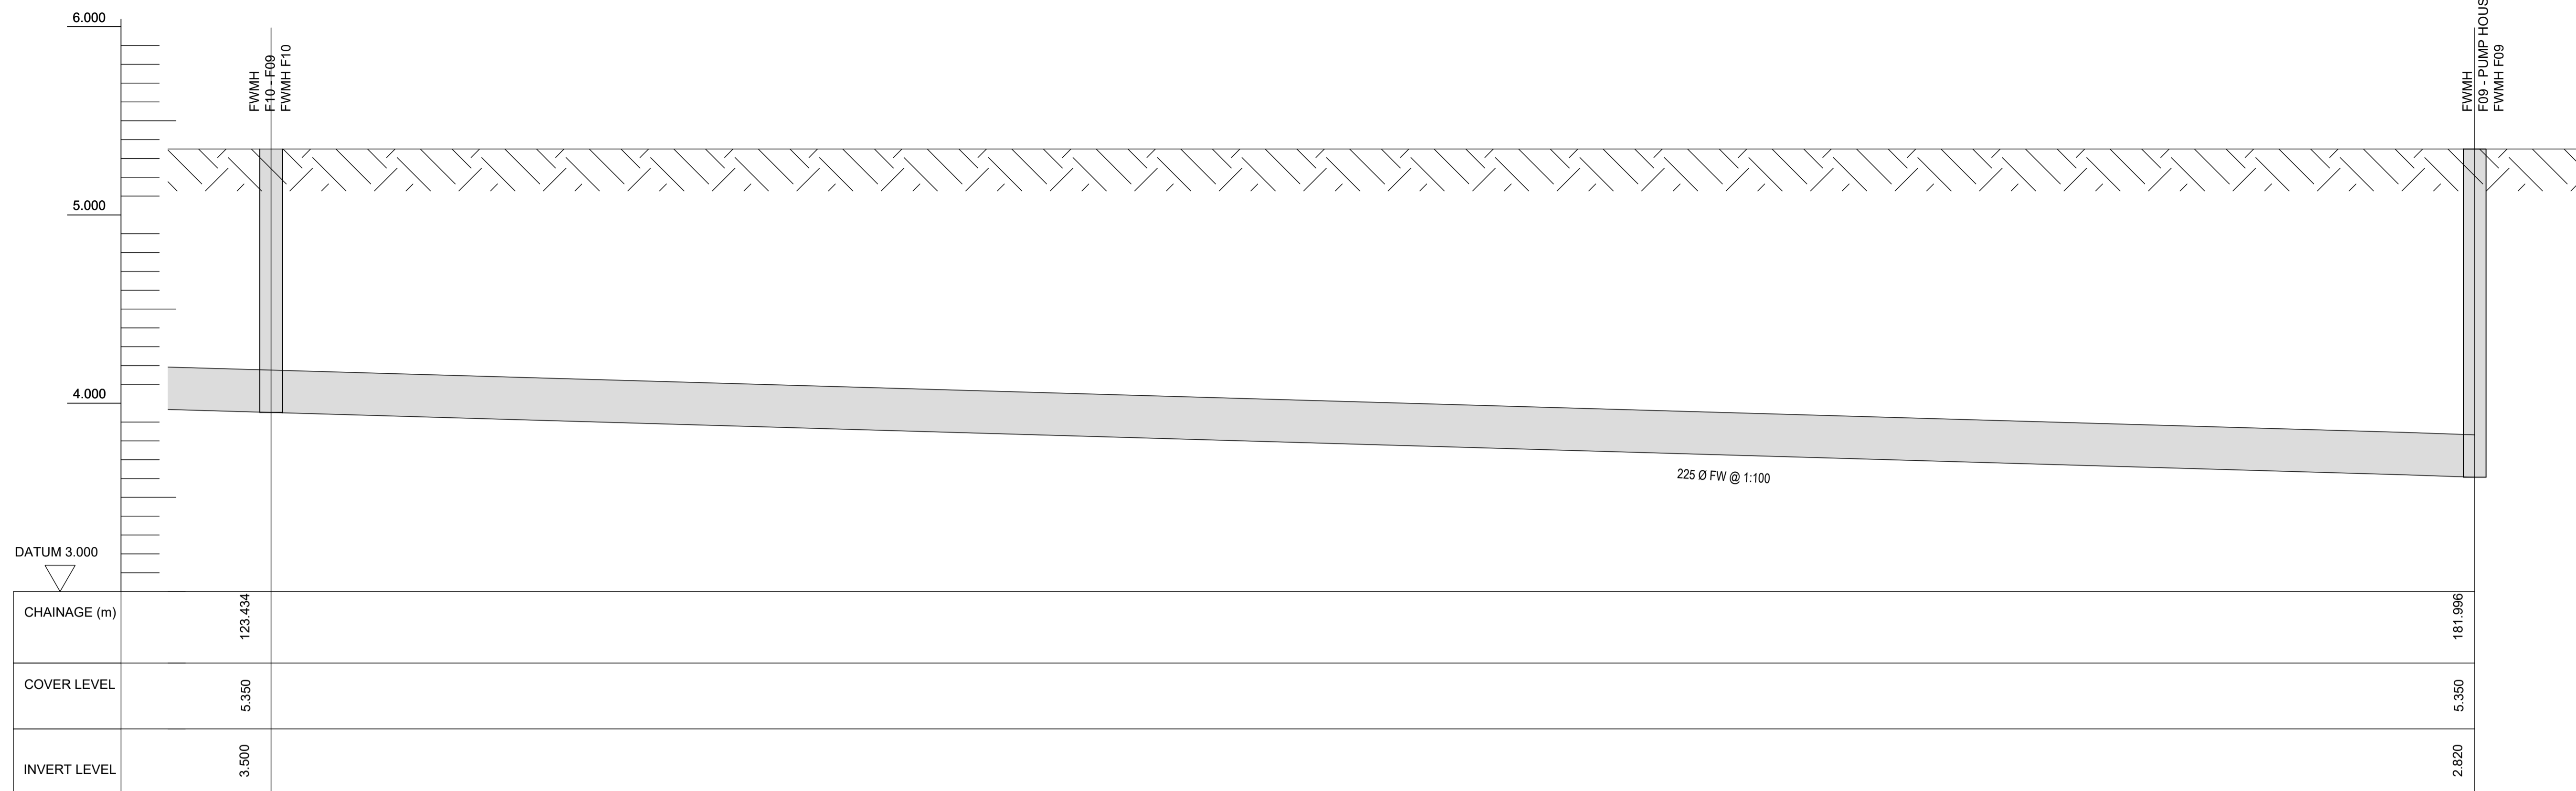

KEYPLAN

**SUMITOMO ELECTRIC** STA CABLE FACTORY  
NIGG, TAIN IV19 1QU

**eda** ARCHITECTS  
EDA Architects Ltd  
Omagh Enterprise Centre,  
41 Gortashind East,  
Omagh BT78 5LU  
eoghan@eda-architects.com

REVISIONS

REV	DATE	DESCRIPTION	CHK	DRN
P01	21/08/23	ISSUED FOR PLANNING	DC	DG

STATUS  
**PLANNING**

PROJECT  
**SEIUK - CL**

PROJECT ADDRESS  
-

DISCIPLINE  
**CIVIL**

DWG TITLE  
**Foul Water - Longitudinal Section - F12-F09 - 03/03**

DWG NO.  
**S-263-EUR-EXT-ZZ-DR-C-2558**


STATUS CODE  
**C4**

PROJECT NO. <b>S-263</b>	DATE <b>08/01/23</b>
DRAWN / CHECKED <b>SYM/DC</b>	SCALE NO. <b>1 : 100</b>

REVISION NUMBER




**P01**

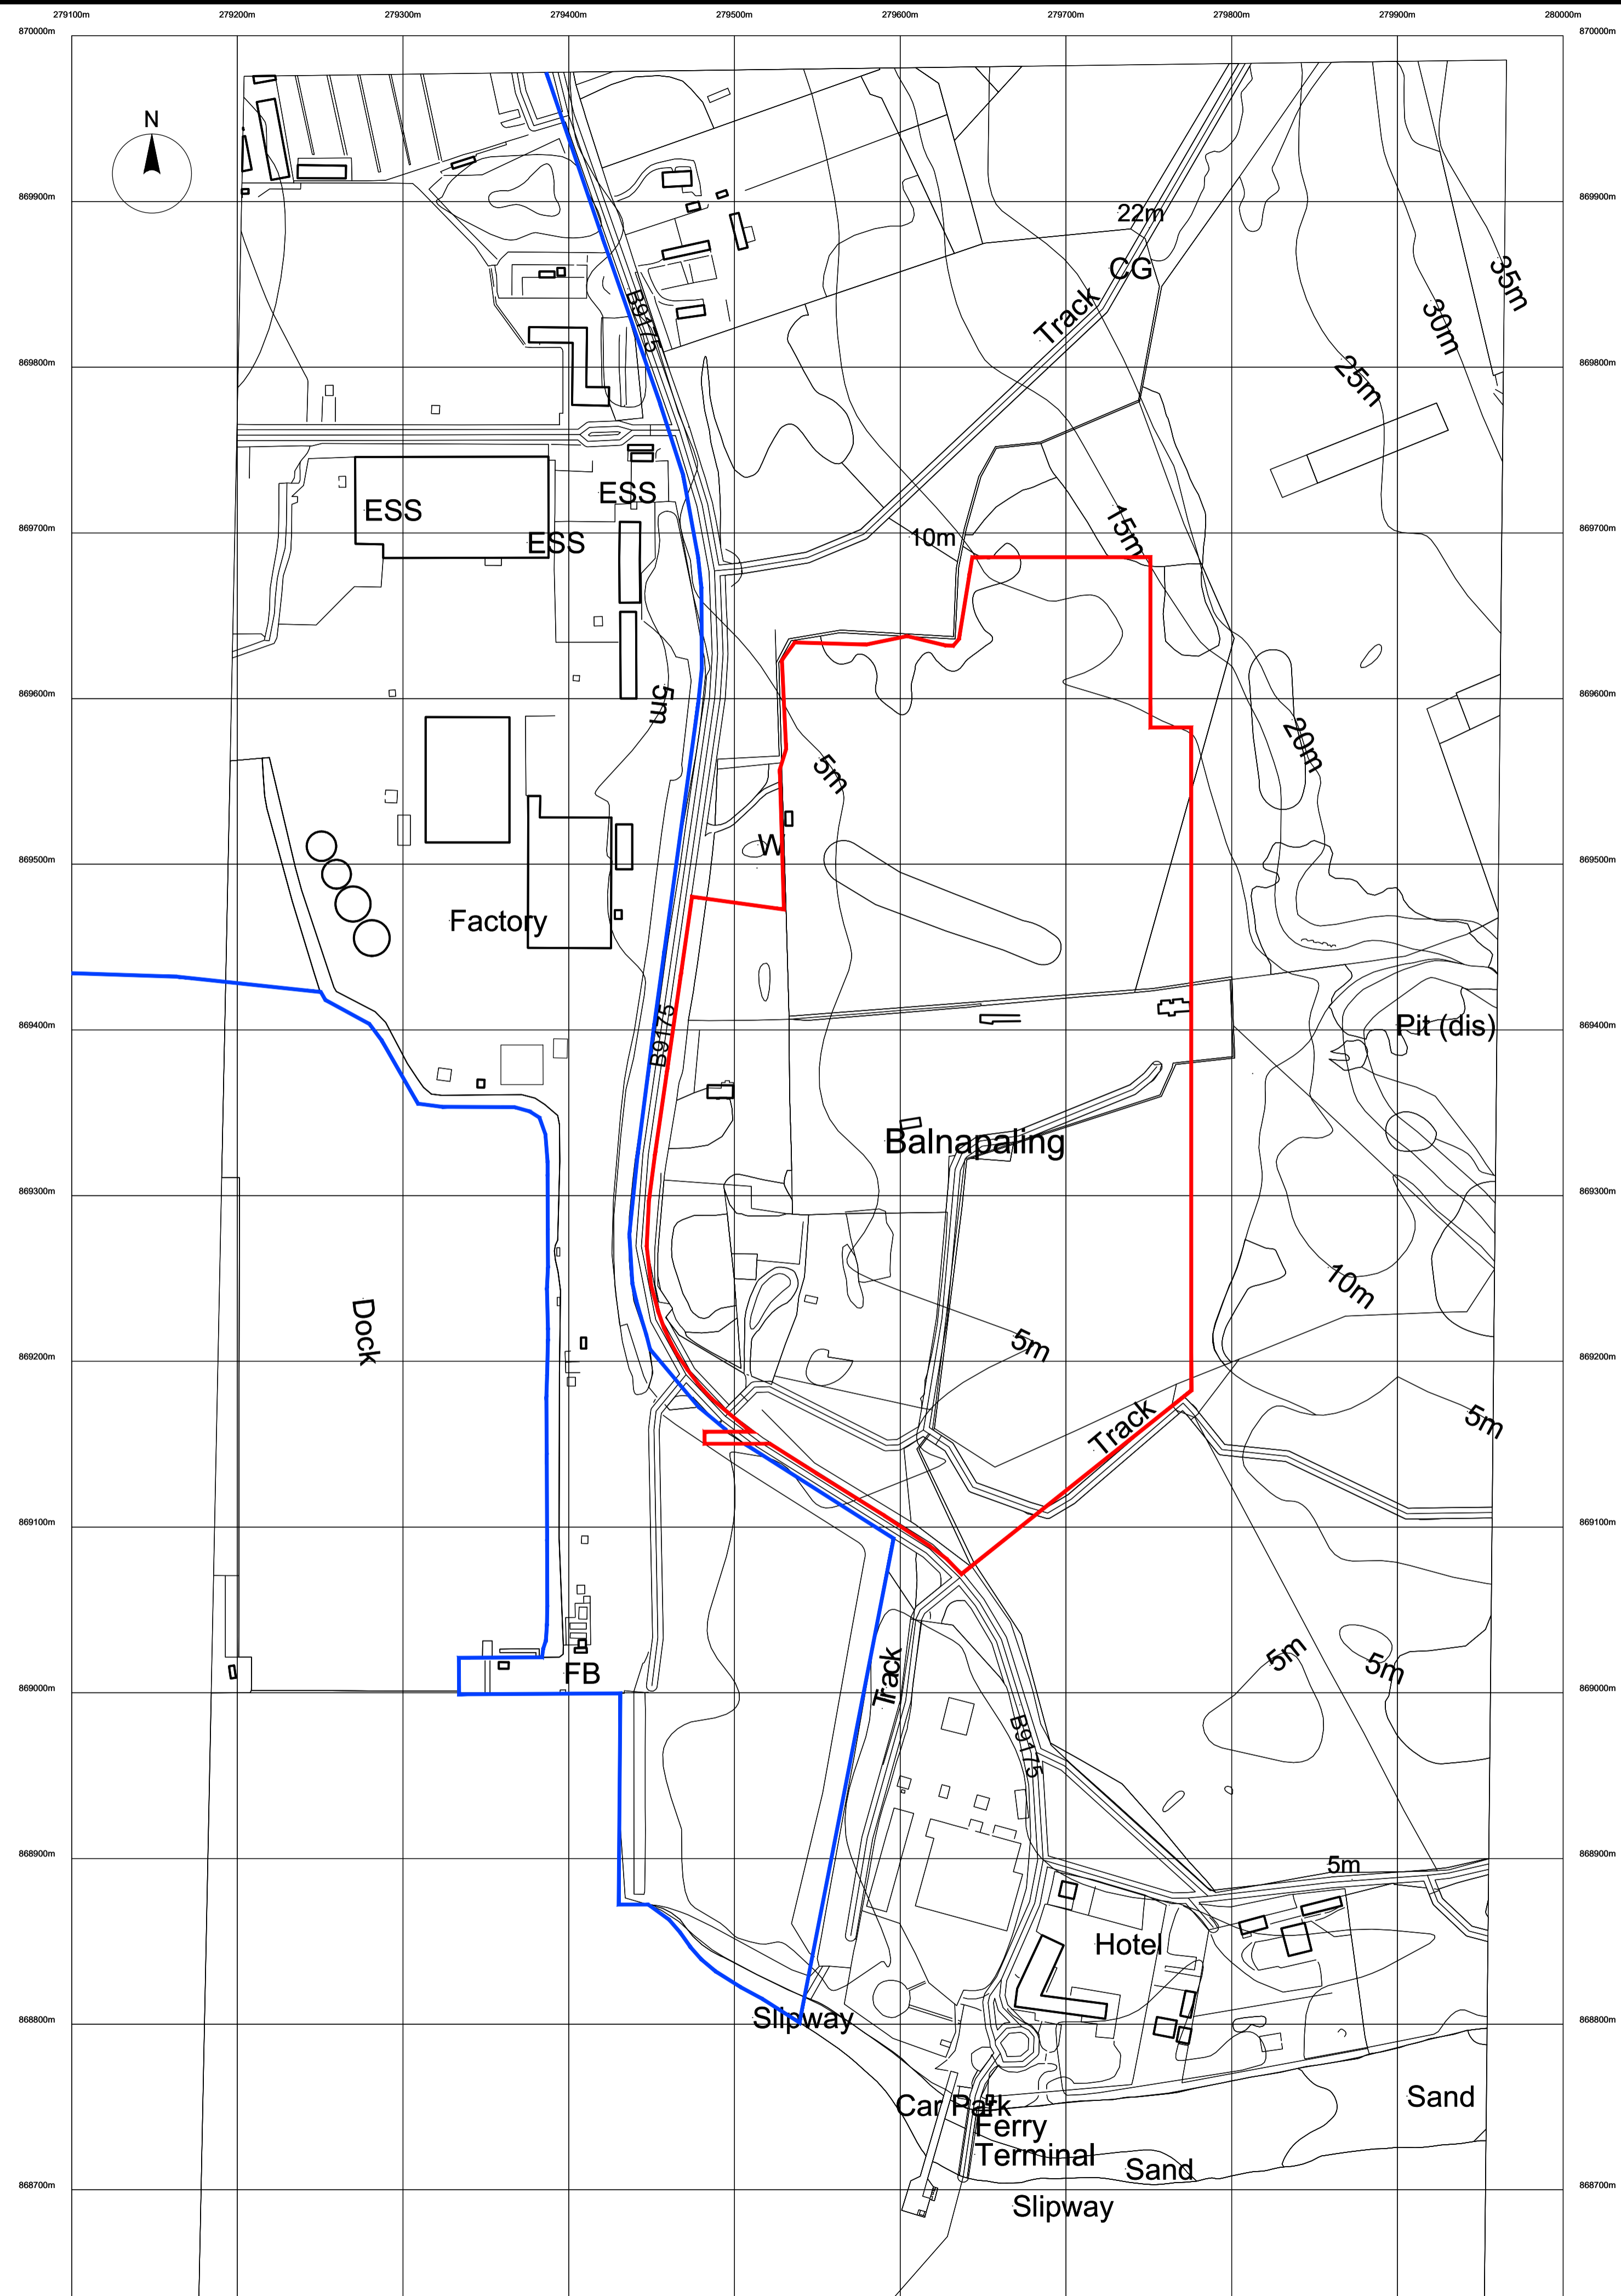**EUROPLAN GROUP**  
Parkview House, Beechill Office Campus,  
Clonskeagh, Dublin 4, Eire.  
Tel: +353 1 2606578  
staprojectteam@europlanservices.com




Site Location Map  
1:2500  
1:2500 scale bar  
0 25m 100m

**Project Design Team Members**

<b>Client</b>	Code <b>SUM/ CL</b>	 <b>SUMITOMO ELECTRIC</b> <small>SEI, Kaji-cho Hitachi City Japan</small>
<b>Project Management</b>	Code <b>EUR/ PMC</b>	 <b>EUROPLAN GROUP</b> <small>Parkview House, Beechill Office Campus, Clonskeagh, Dublin 4, Eire. Tel: +353 1 2606578 staprojectteam@europlanservices.com</small>
<b>Contractors</b>	<b>EUR/ CS</b>	
<b>Civil Engineers</b>	<b>EUR/ SE</b>	
<b>Structural Engineers</b>	<b>EUR/ MP</b>	
<b>Mechanical Engineers</b>	<b>EUR/ EL</b>	
<b>Electrical Engineers</b>	Code <b>EDA/ AR</b>	 <b>eda</b> <small>EDA Architects Ltd Orang Industrial Centre 41 Gurrah Ind Est, Orang #178 B-11 eople@eda-architects.com</small>

© Copyright EDA Architects Ltd. The Construction (Design and Management) Regulations 2015 apply to this project. Please refer to the 'Pre-Construction Information', 'Construction Phase Plan' and other relevant documents. All dimensions in millimeters. This drawing is subject to statutory approval (planning, building control etc)

Rev	Date	Description
P07	26.09.23	minor revisions.
P06	17.09.23	minor revisions.
P05	19.08.23	minor revisions.
P04	17.08.23	minor revisions.
P03	17.08.23	revised following client instruction
P02	16.08.23	minor revisions.
P01	15.08.23	minor revisions.

 **SEUK CL**  
**SUMITOMO ELECTRIC** **NIGG, TAIN IV19 1QU**

Discipline: ARCHITECT


Sheet Title:  
SITE LOCATION MAP



Sheet Number	PROJECT	ORIGINATOR	VOLUME	LEVEL
	<b>S263</b>	EDA	EXT	EX
TYPE	ROLE	NO.	SUIT.	REV.
DR	AR	101	S4	P07

Scale: 1:2500 (A1)

Date: 23.07.23

By: ED Chk: ED

  
**EUROPLAN GROUP**  
**Project Management Contractors**  
Parkview House, Beechill Office Campus,  
Clonskeagh, Dublin 4, Eire.  
Tel: +353 1 2606578  
staprojectteam@europlanservices.com

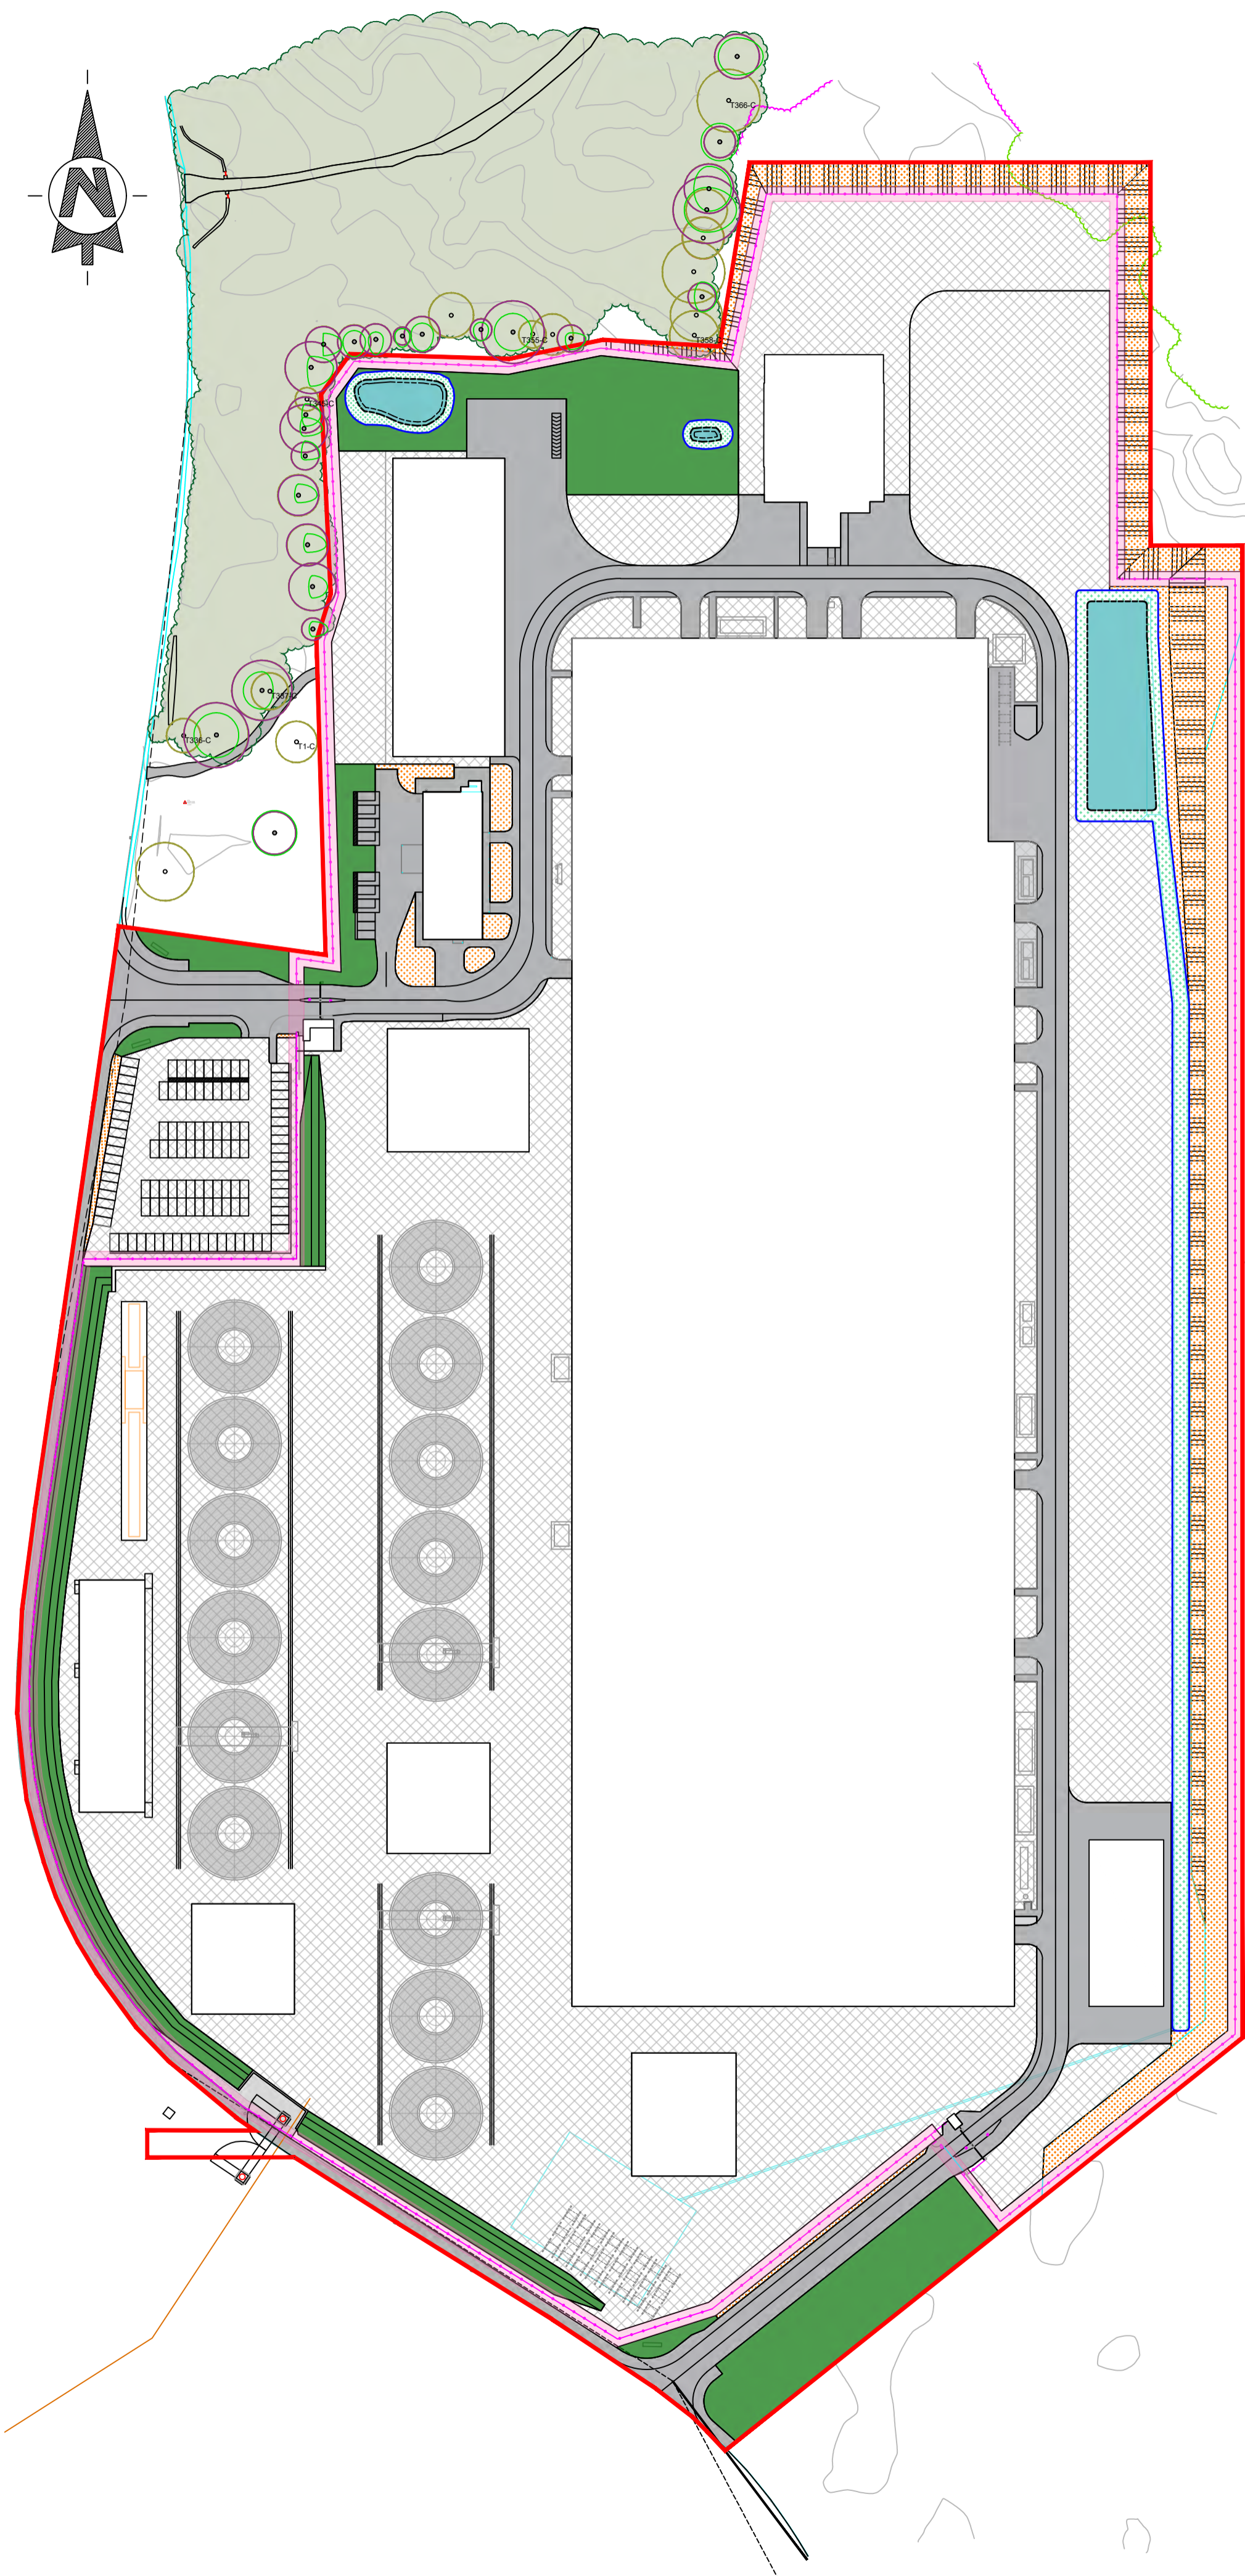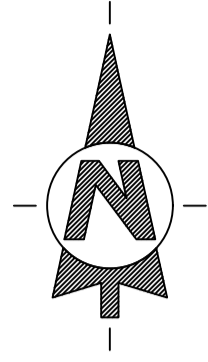

**Legend**

- Site Boundary
- Fence
- Reinforced Slope, refer to engineers specification
- Proposed Building Blocks, refer to architects drawing
- Hazardous zone
- Existing Trees, refer to tree survey
- Existing Mixed Ancient Woodland, refer to tree survey
- SuDs, Swale
- Proposed Woodland Edge Mix
- Proposed Wet Wildflower Mix
- Proposed Wildflower Meadow Mix
- Asphalt
- Compacted Hardcore

**Woodland Edge Mix**

% Mix	Code	Species	Height (cm)	Grown	Transplant	Height grade	Density
15%	Ac	Acer campestre	175-200	B	2x	Feathered	1no/m <sup>2</sup>
15%	Ag	Alnus glutinosa	175-200	B	2x	Feathered	1no/m <sup>2</sup>
15%	Cm	Crataegus monogyna	125-150	B	2x	Feathered	1no/m <sup>2</sup>
15%	Pa	Prunus avium	150-175	B	2x	Feathered	1no/m <sup>2</sup>
25%	Sv	Salix viminalis	200-250	B	2x	Feathered	1no/m <sup>2</sup>
15%	Sa	Sorbus aucuparia	200-250	B	2x	Feathered	1no/m <sup>2</sup>

**Meadowland Mix 2**

Woodland Meadow Mix by Scotia Seeds ([www.scotiaseeds.co.uk](http://www.scotiaseeds.co.uk)), sown at a rate of 3g/m<sup>2</sup>

**Wetland Marginal Areas**

'Wet Meadow Mix' seed mix by Scotia Seeds Ltd. sown at rate of 3g/m<sup>2</sup>.


**TGP LANDSCAPE ARCHITECTS**  
 Suite 4.01, 100 West Regent Street  
 Glasgow, G2 2QD Tel: 0141 429 2999  
[info@tgp.uk](mailto:info@tgp.uk) / [www.tgp.uk](http://www.tgp.uk)  
 Also in Edinburgh & Newcastle

<b>Project</b> NIGG CABLE FACTORY	
<b>Title</b> LANDSCAPE MITIGATION PLAN	
<b>Date</b> 26/09/23	<b>Scale</b> 1:1250 @ A2
<b>Drawn</b> AK	<b>Checked</b> GS
<b>Job</b> 2144	<b>Suitability</b> -
<b>No.</b>	<b>Issue</b> F05
<b>Revision</b> D	
<b>LI WORKSTAGE:</b> 0/1 2 3 4 5 6	
<input type="checkbox"/> <input type="checkbox"/> <input checked="" type="checkbox"/> <input type="checkbox"/> <input type="checkbox"/> <input type="checkbox"/>	


DISCLAIMER:  
 Do not scale from this drawing.  
 All dimensions to be verified on site prior to commencement of works.  
 Drawing to be read in conjunction with related TGP drawings, consultants drawings and any other relevant information.  
 This drawing is the copyright of TGP Landscape Architects Ltd. unless otherwise specified.

ALL DIMENSIONS TO BE CHECKED ON SITE.  
NO DIMENSIONS TO BE SCALED FROM THIS  
DRAWING. DRAWINGS TO BE READ IN  
CONJUNCTION WITH RELEVANT  
CONSULTANTS DRAWINGS.

SITE KEY PLAN

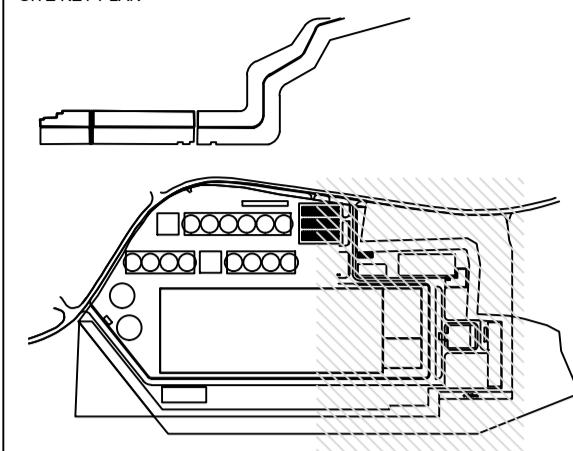

LEGEND

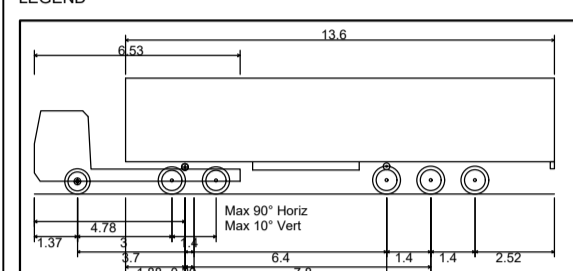

Max Legal Length (UK) Articulated Vehicle (16.5m) 16.500m  
Overall Length 2.550m  
Overall Width 3.681m  
Overall Body Height 0.411m  
Min Body Ground Clearance 2.500m  
Max Track Width 6.00m  
Lock to lock time 6.530m  
Kerb to Kerb Turning Radius 6.530m

**SUMITOMO ELECTRIC** STA CABLE FACTORY  
NIGG, TAIN IV19 1QU

**eda** ARCHITECTS  
EDA Architects Ltd  
Omagh Enterprise Centre,  
41 Gortnah 1st Est,  
Omagh BT78 5LU  
eoghan@eda-architects.com

REVISIONS

REV	DATE	DESCRIPTION	CHK	DRN
P02	27/09/23	UPDATED FOR 16.5m VEHICLE	DC	DG
P01	21/08/23	ISSUED FOR PLANNING	DC	DG

STATUS  
**PLANNING**

PROJECT  
**SEIUK - CL**

PROJECT ADDRESS  
-

DISCIPLINE  
**CIVIL**

DWG TITLE  
**Autotrack Sheet 1**

DWG NO.  
**S264-EUR-00-ZZ-DR-CS-2207**

STATUS CODE  
**C4**

PROJECT NO.  
**S264**

DATE  
**21/08/23**




DRAWN / CHECKED  
-- / --

SCALE NO.  
**1: 500**

REVISION NUMBER  
**P02**



**EUROPLAN GROUP**

Parkview House, Beechill Office Campus,  
Clonskeagh, Dublin 4, Eire.  
Tel: +353 1 2606578  
staprojectteam@europlanservices.com

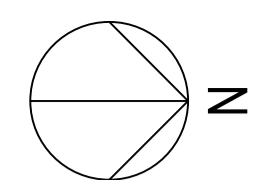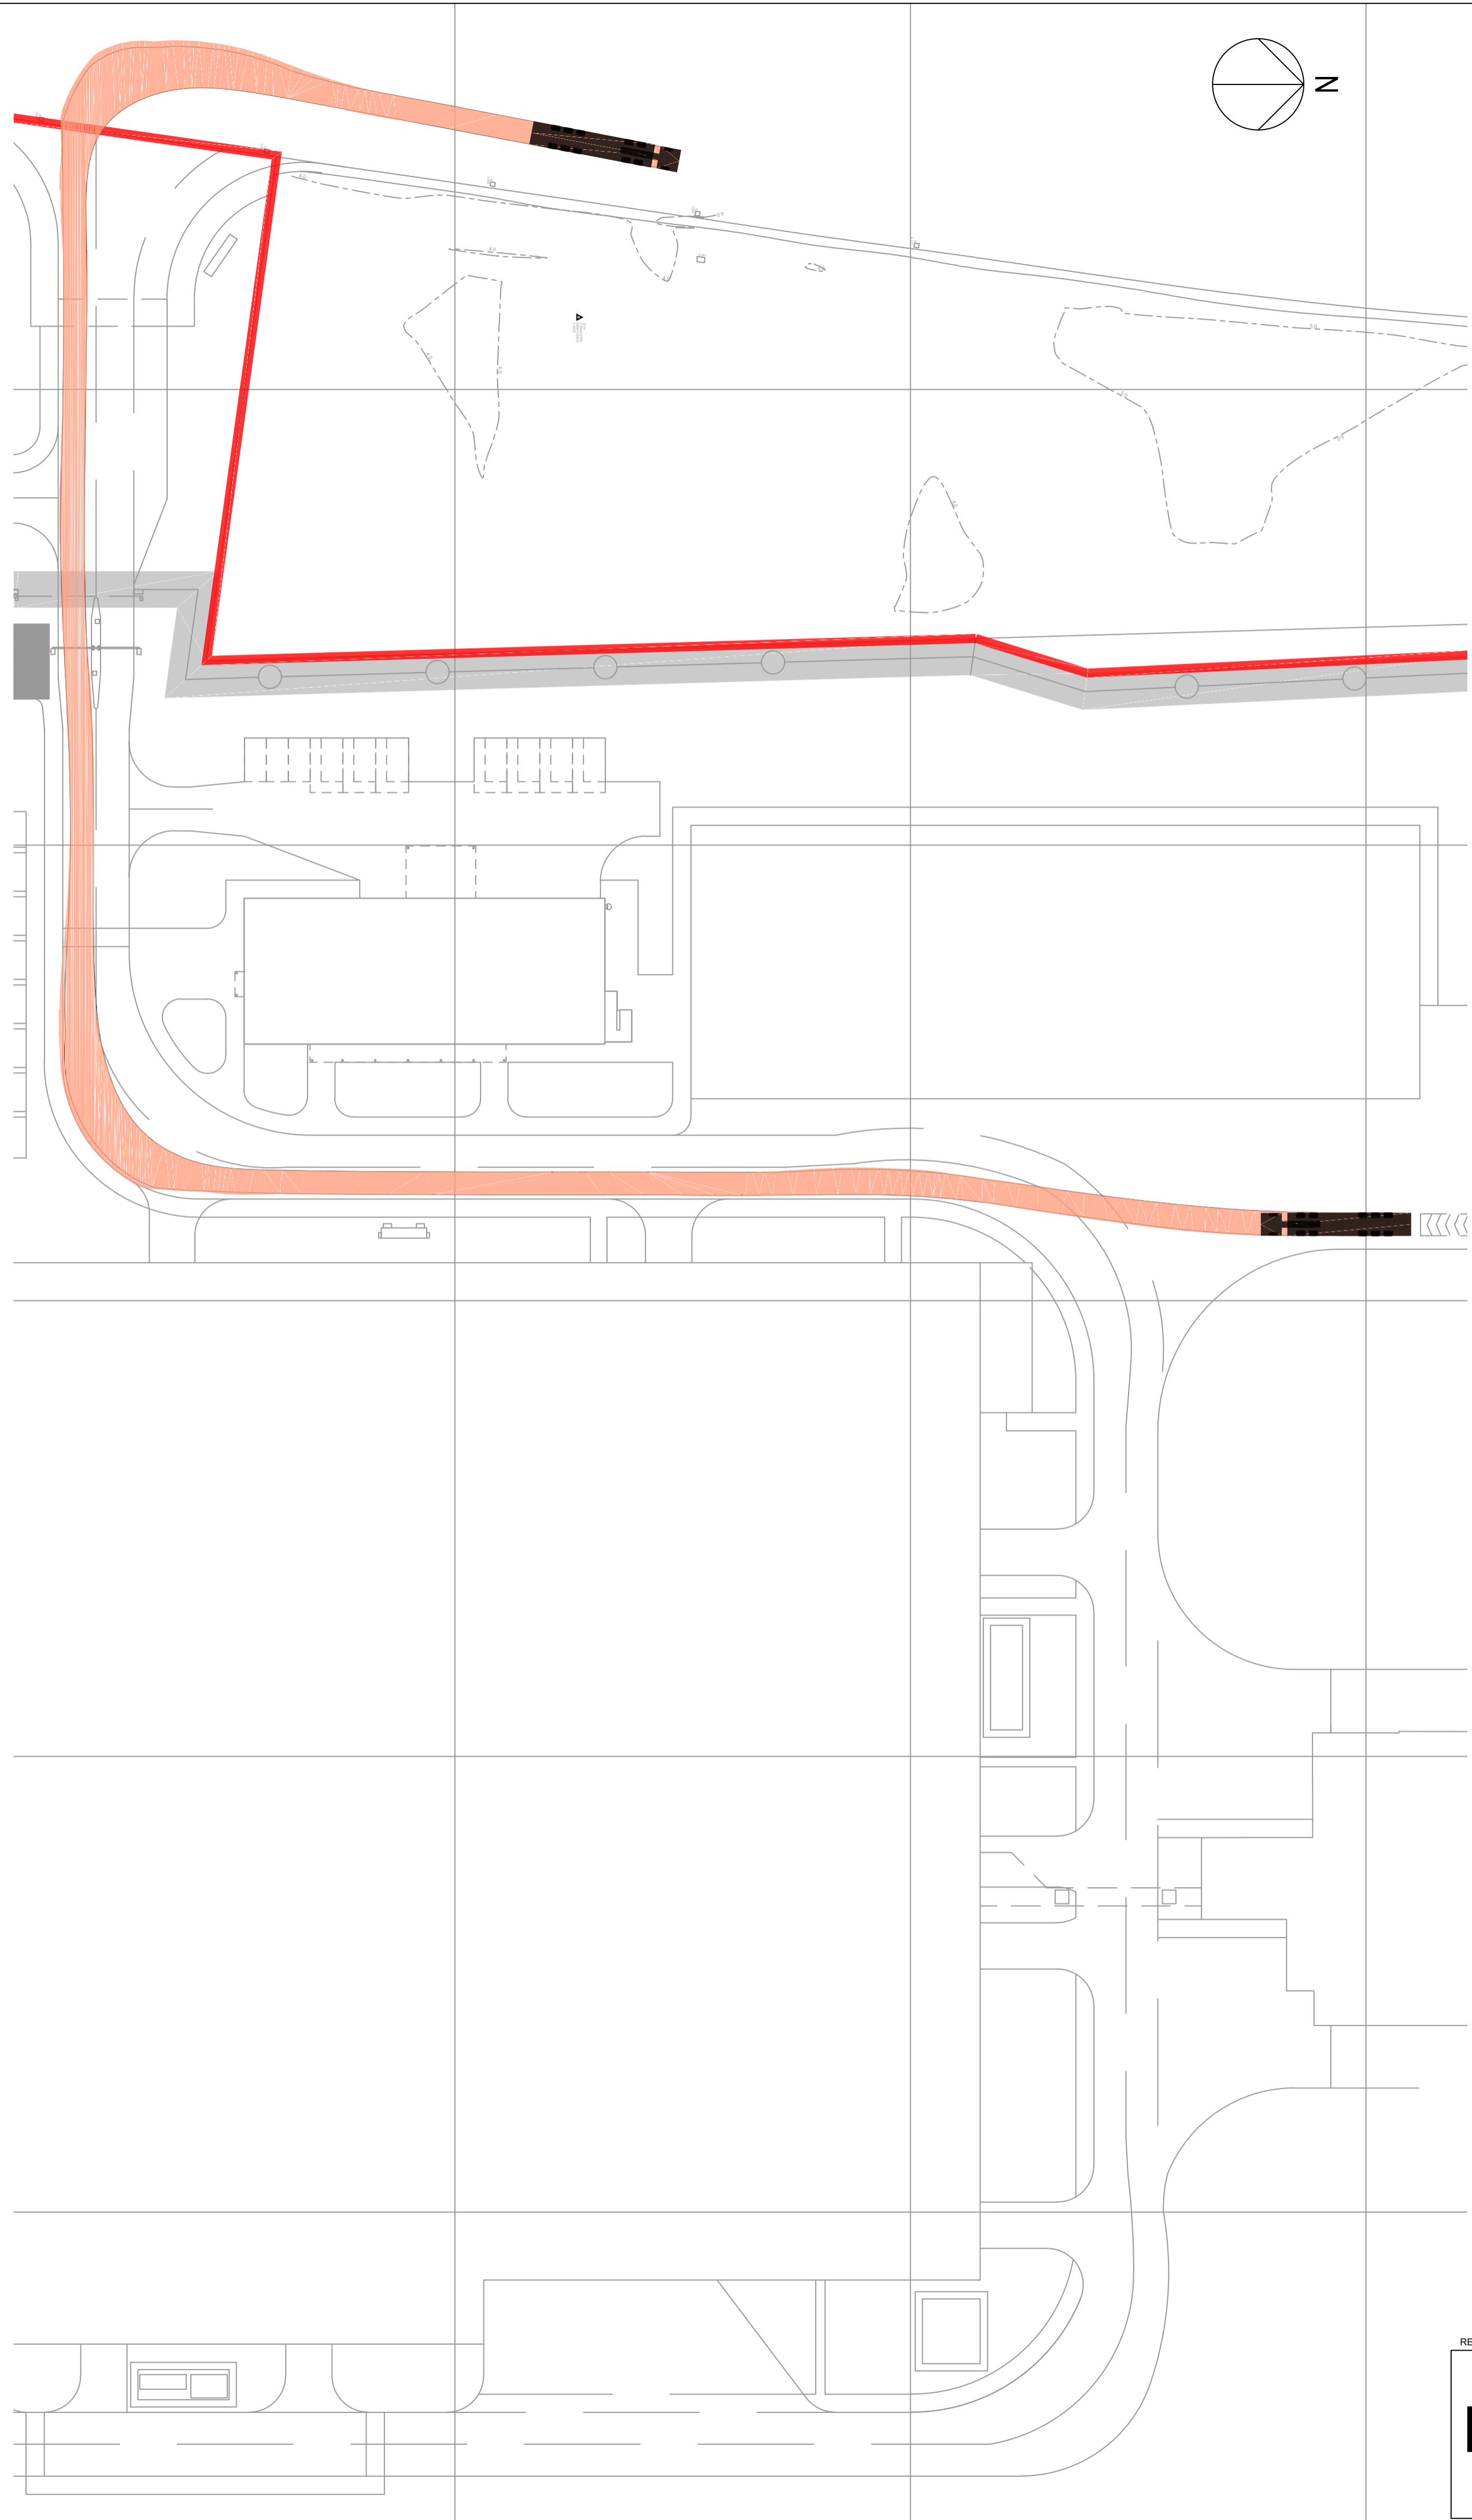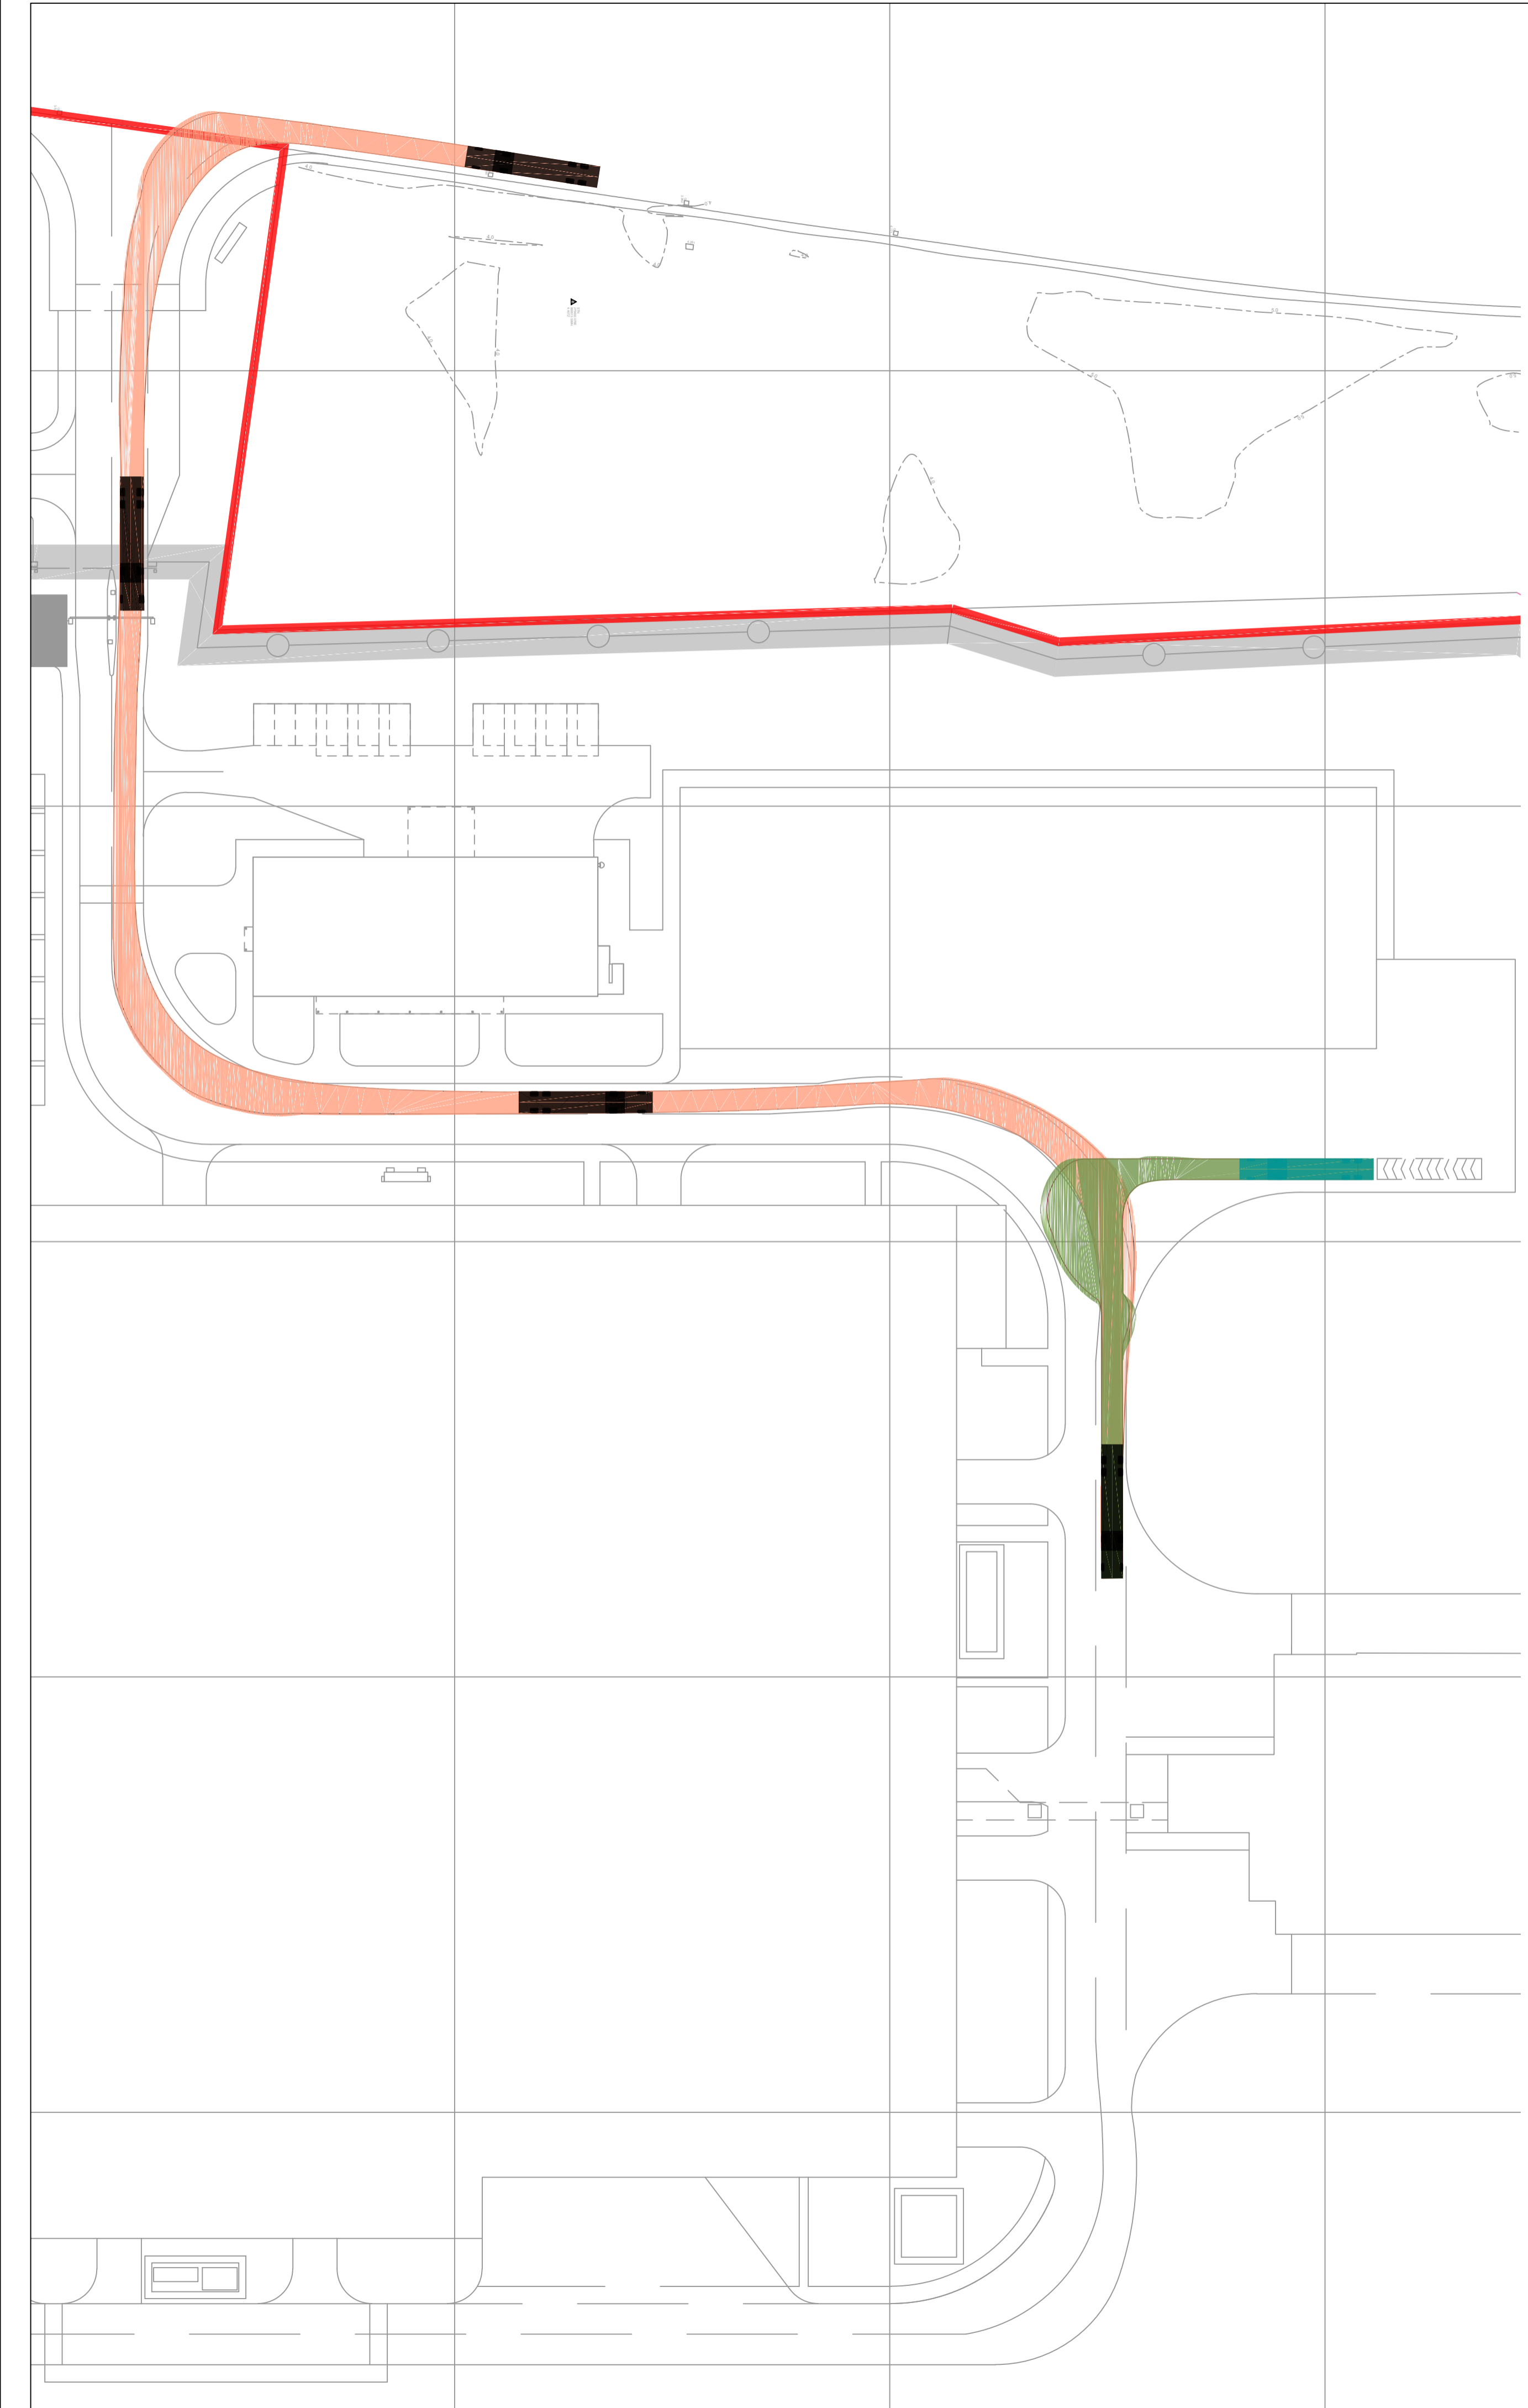

ALL DIMENSIONS TO BE CHECKED ON SITE. NO DIMENSIONS TO BE SCALED FROM THIS DRAWING. DRAWING IS TO BE READ IN CONJUNCTION WITH RELEVANT CONSULTANTS DRAWINGS.

SITE KEY PLAN

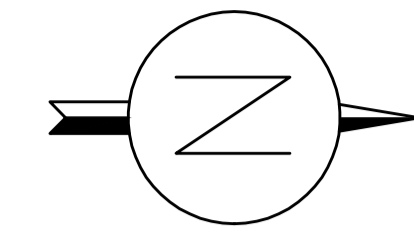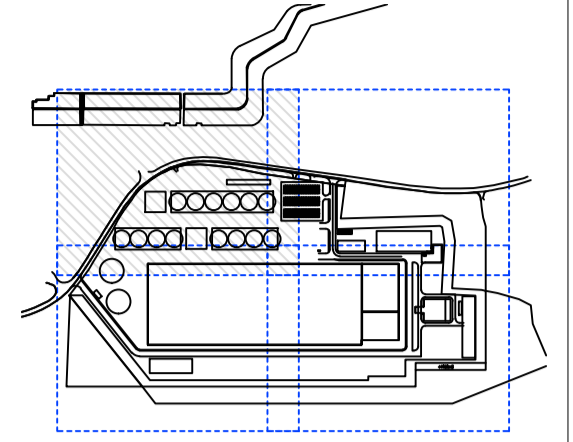

LEGEND

Legend table with columns for symbol, description, and material. Includes entries for '2.0m WIDE SOLAS ZONE', 'FLOOD DEFENSE CONCRETE WALL (TOW +5.200)', and various 'APPROX. FGL' and 'TOP OF BERM' markers.

**SUMITOMO ELECTRIC**  
STA CABLE FACTORY  
NIGG, TAIN IV19 1QU

**eda** ARCHITECTS  
EDA Architects Ltd  
Omagh Enterprise Centre,  
41 Corruish Ind Est,  
Omagh BT78 5LU  
eoghan@eda-architects.com

REVISIONS

REV	DATE	DESCRIPTION	DC	DG
P04	26/08/23	ISSUED FOR PLANNING	DC	DG
P03	22/08/23	ISSUED FOR PLANNING	DC	DG
P02	21/08/23	ISSUED FOR PLANNING	DC	DG
P01	20/08/23	BERM LAYOUT	DC	DG

STATUS  
**PLANNING**

PROJECT  
**SEIUK - CL**

PROJECT ADDRESS  
-

DISCIPLINE  
**CIVIL**

DWG TITLE  
**Site plan - Zone 1**

DWG NO.  
**S264-EUR-EXT-ZZ-DR-CS-2201**

STATUS CODE  
**S4**

PROJECT NO.  
**S264**

DATE  
**21/08/23**


DRAWN / CHECKED  
**SVM/DC**

SCALE NO.  
**1 : 500**

REVISION NUMBER

**EUROPLAN GROUP**

Parkview House, Beechill Office Campus,  
Clonskeagh, Dublin 4, Eire.  
Tel: +353 1 2606578  
staprojectteam@europlanservices.com

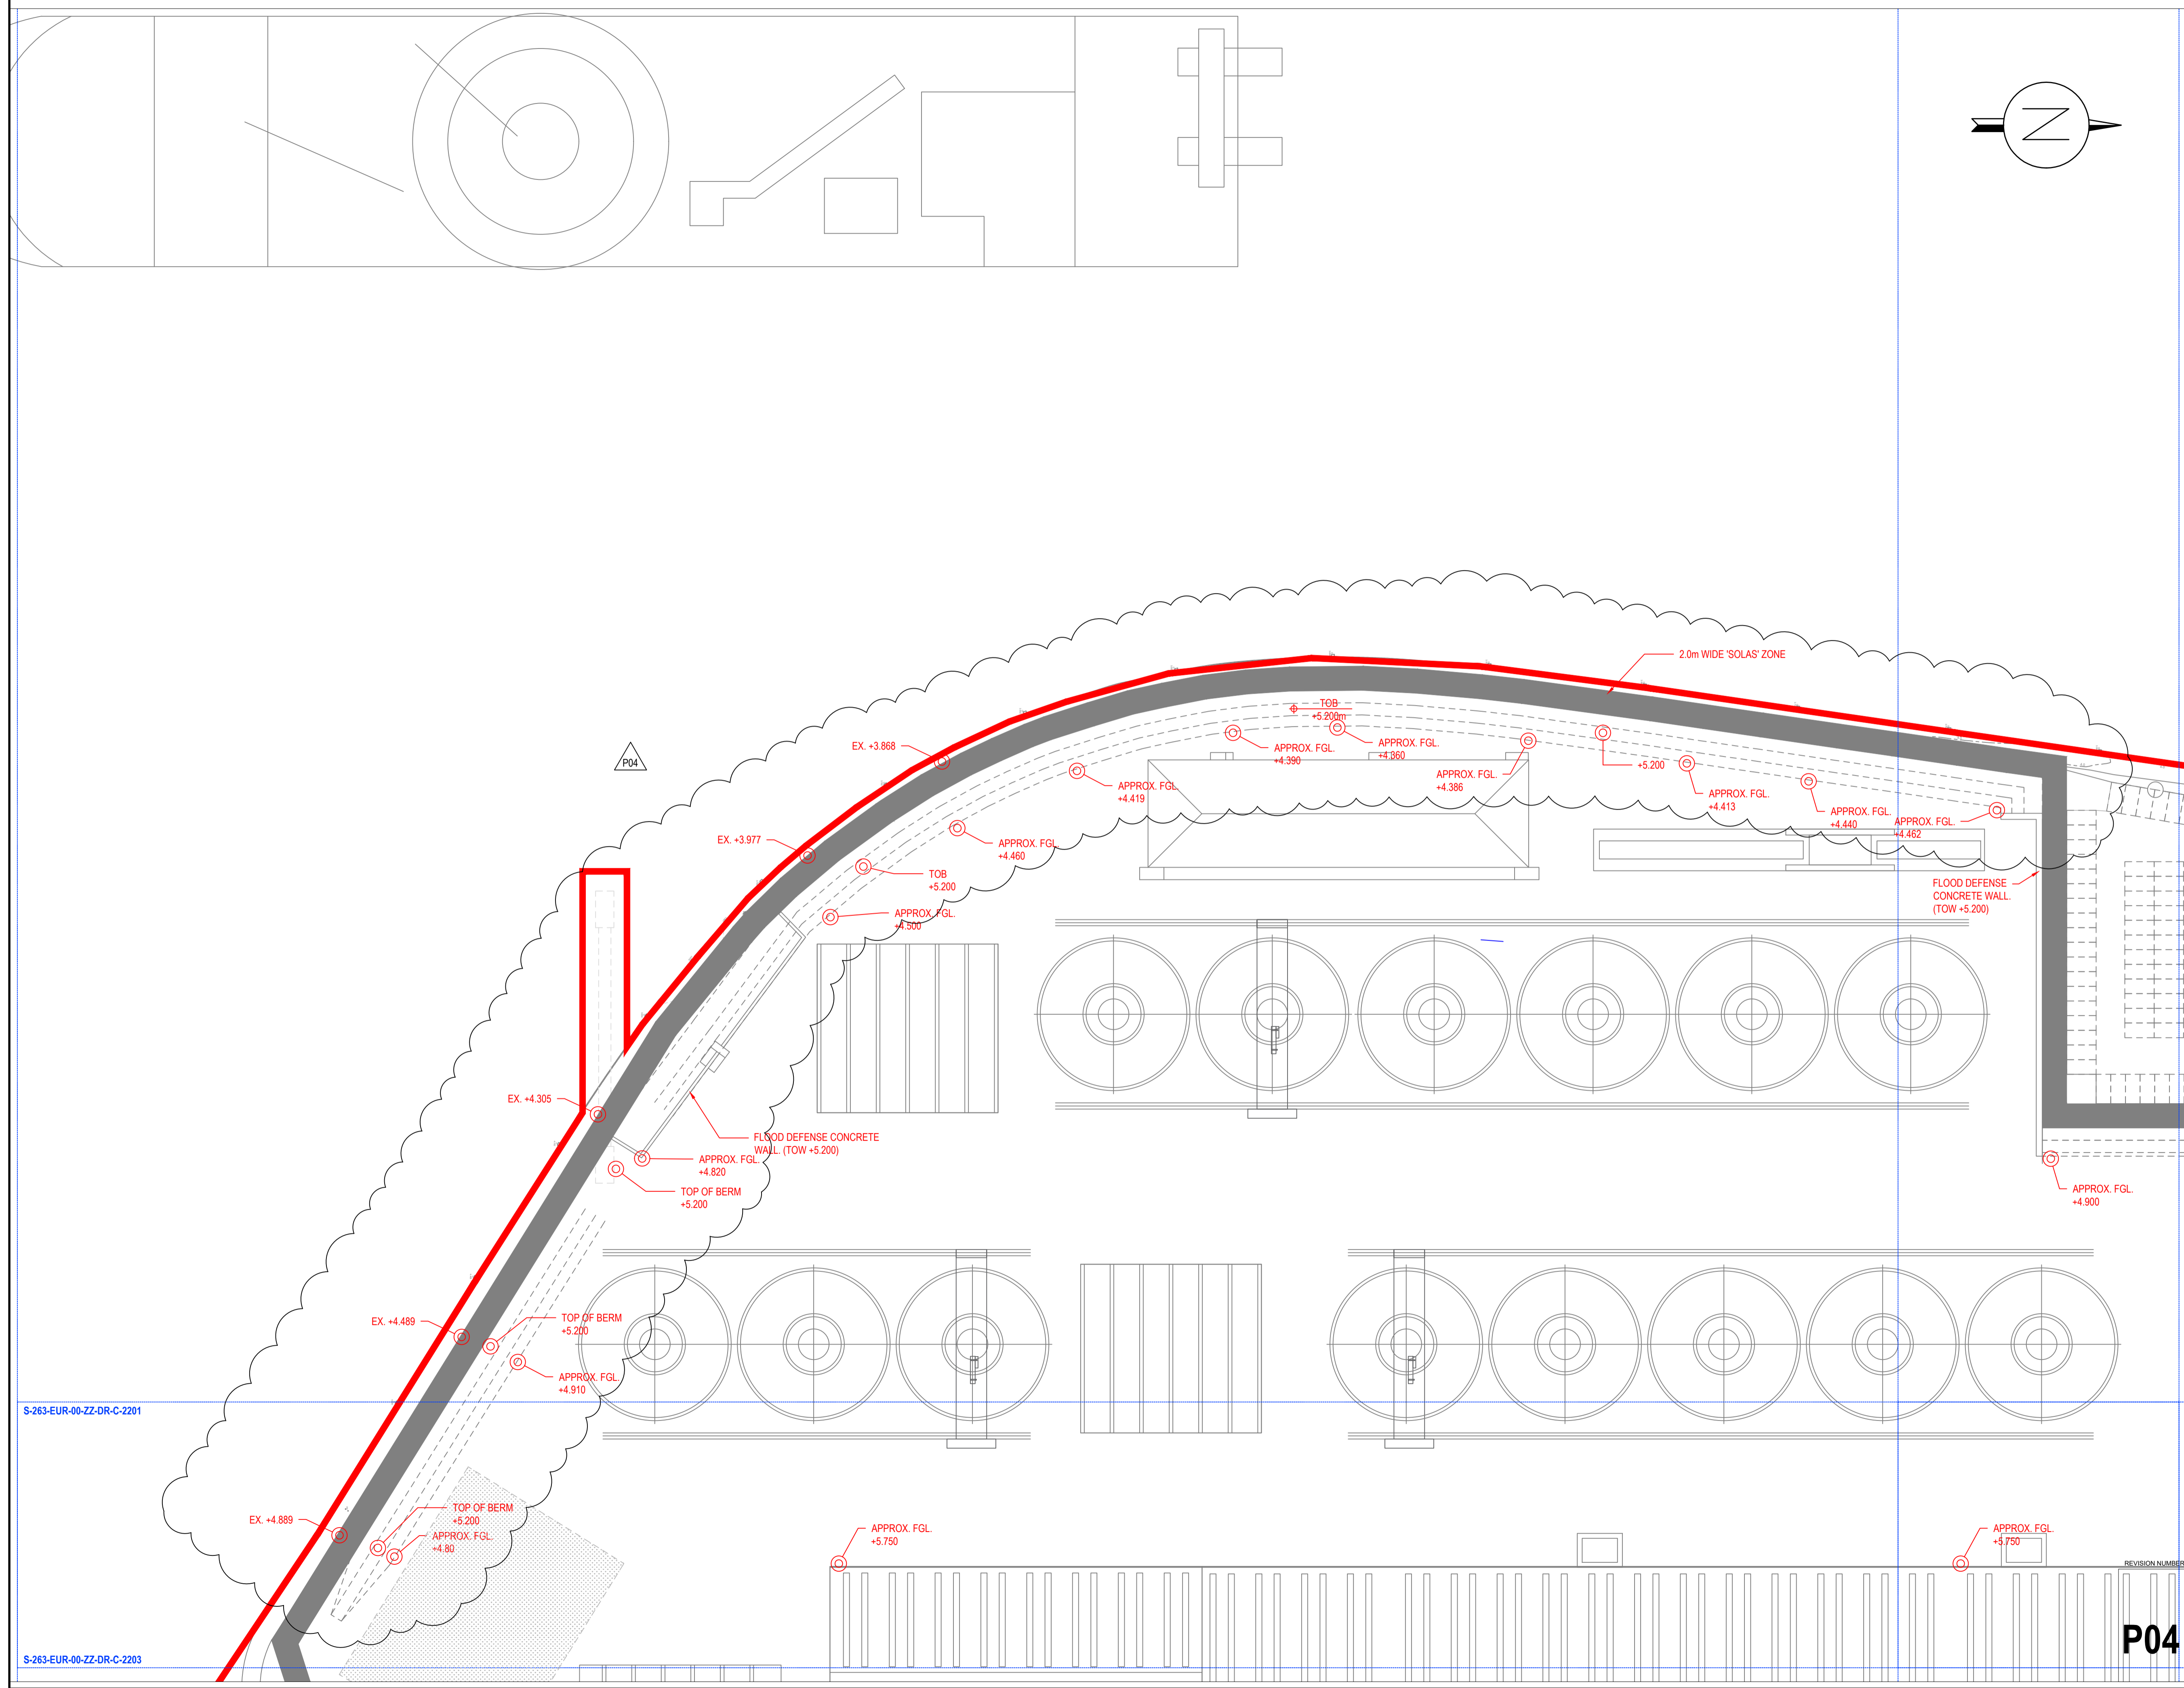

S-263-EUR-00-ZZ-DR-C-2201


S-263-EUR-00-ZZ-DR-C-2203

P04



ALL DIMENSIONS TO BE CHECKED ON SITE  
NO DIMENSIONS TO BE SCALED FROM THIS  
DRAWING. DRAWINGS TO BE READ IN  
CONJUNCTION WITH RELEVANT  
CONSULTANTS DRAWINGS

A1

SITE KEY PLAN

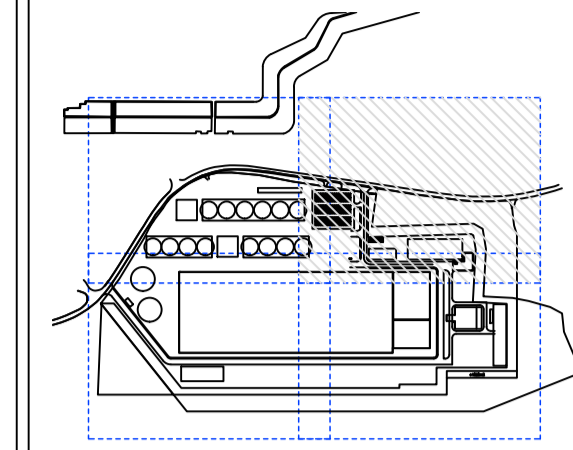

LEGEND

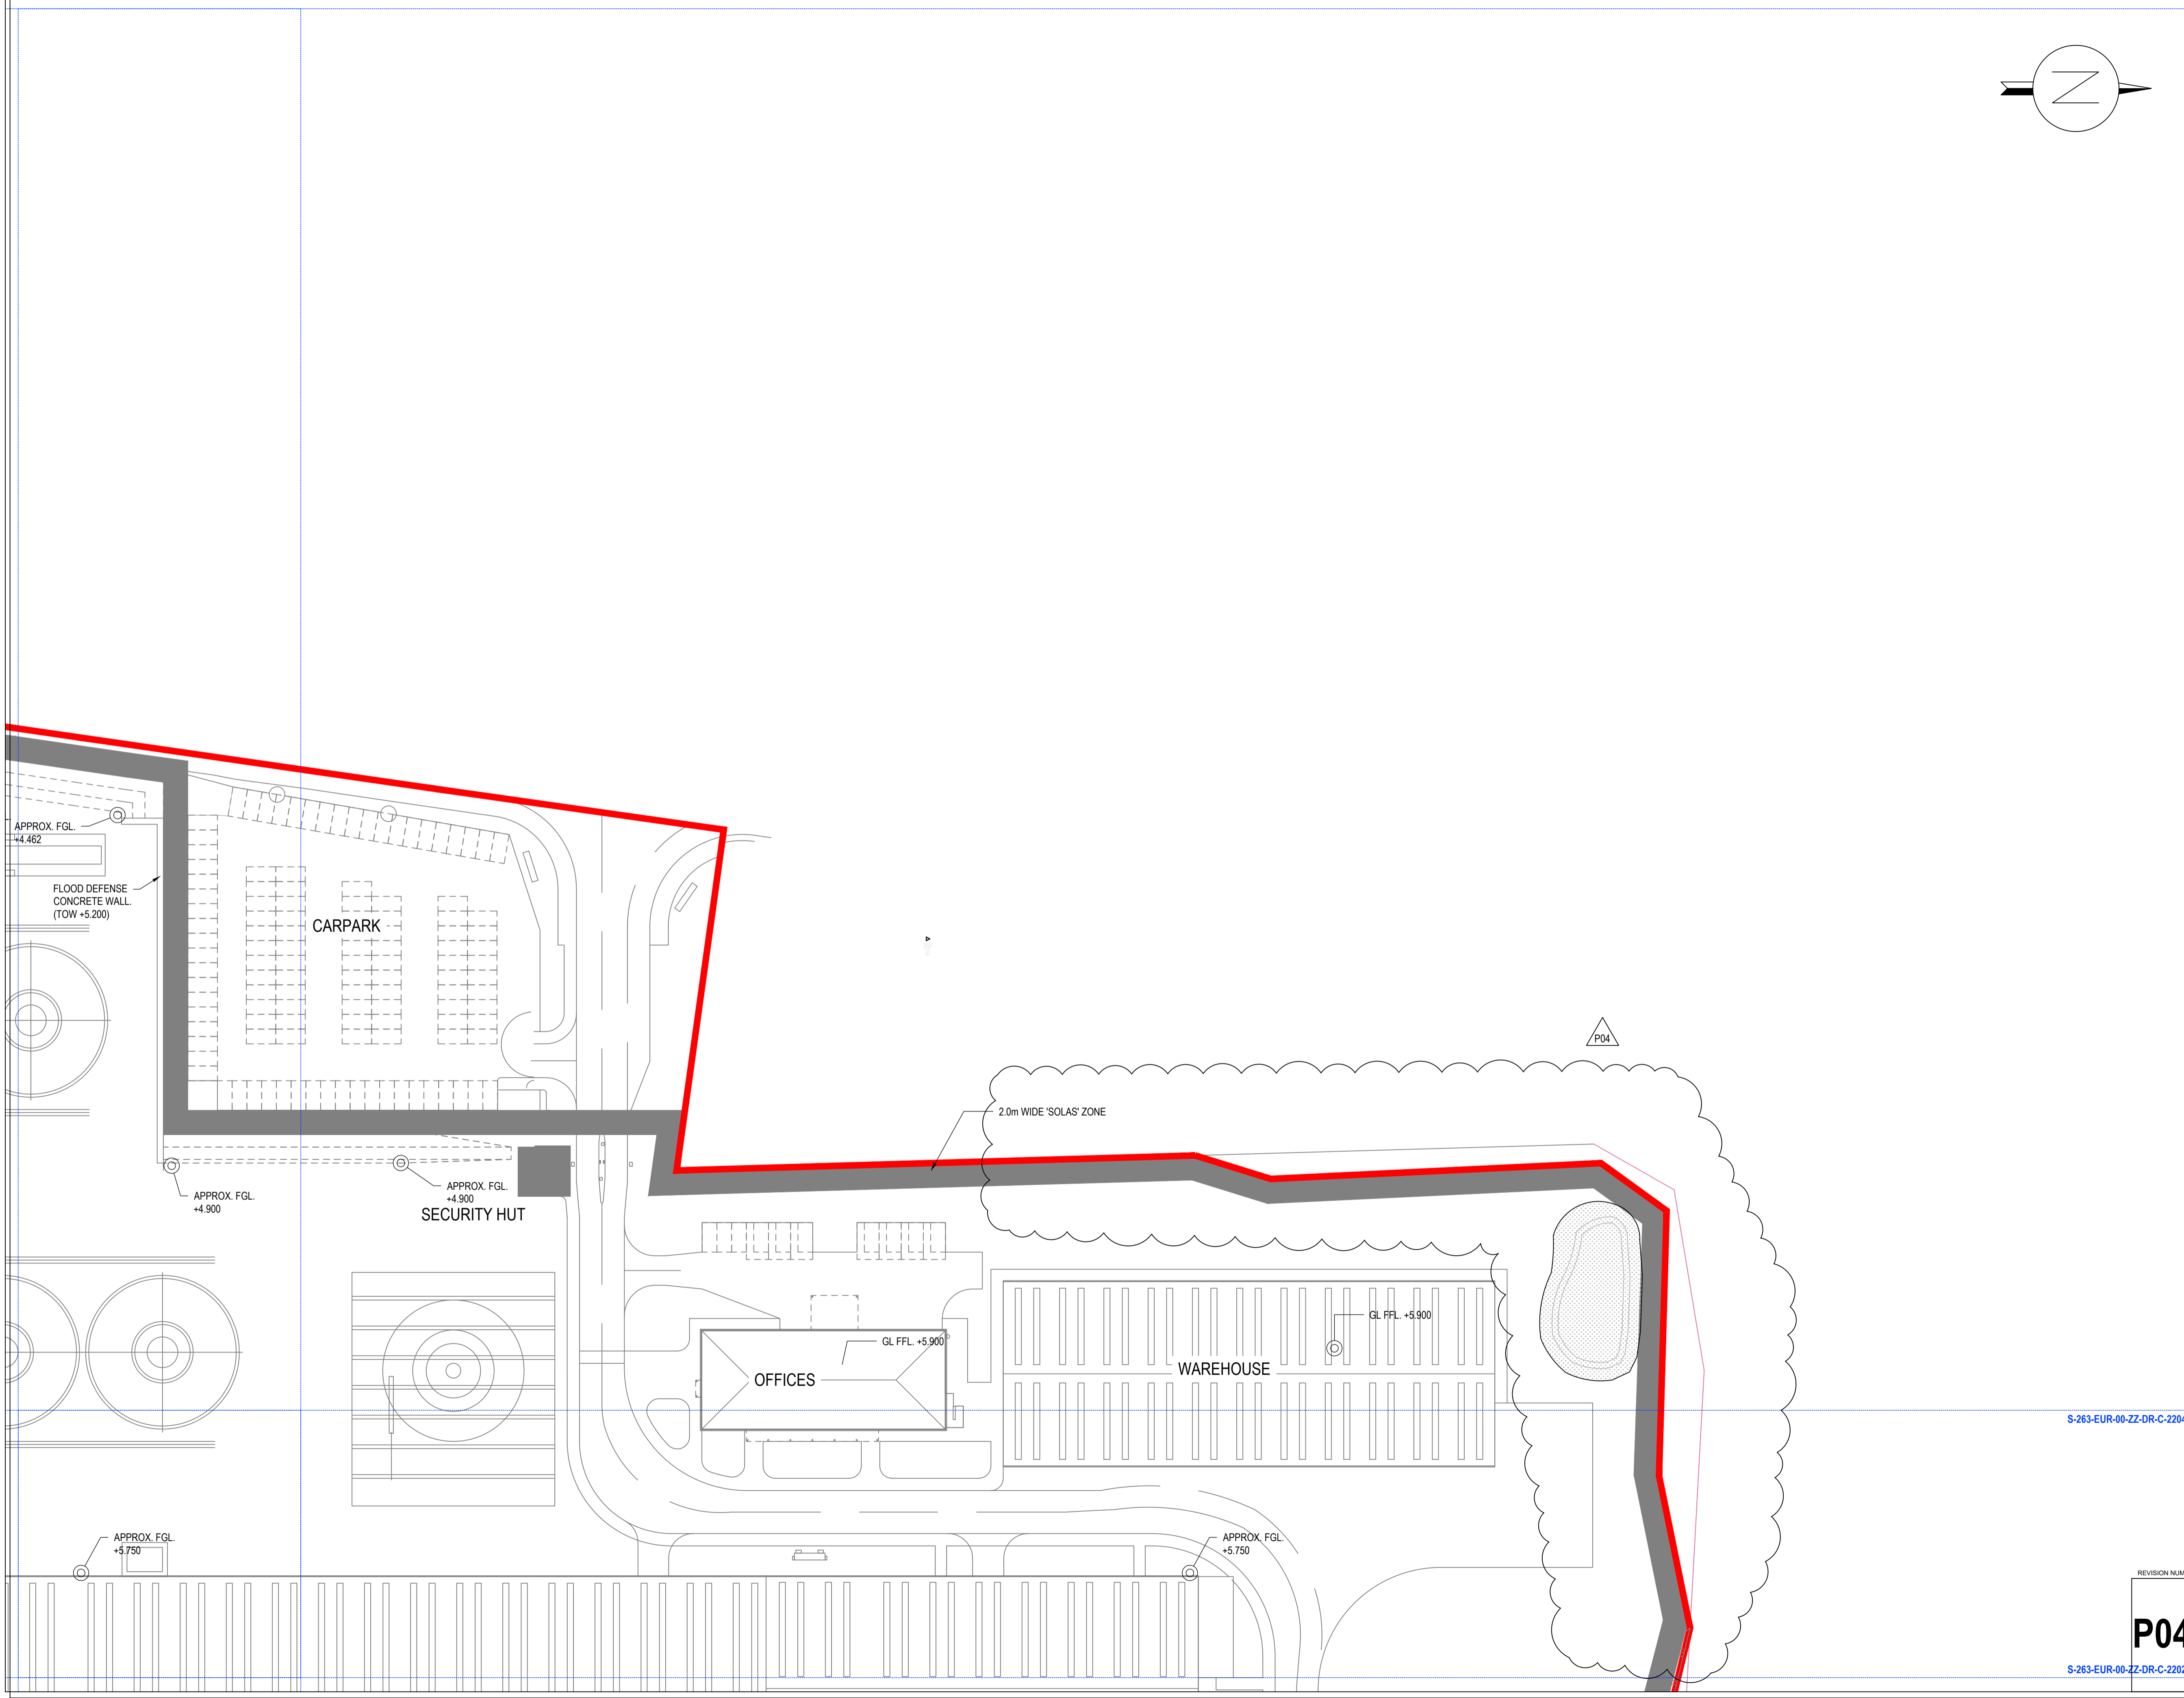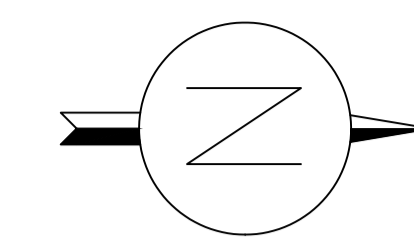

**SUMITOMO ELECTRIC**  
STA CABLE FACTORY  
NIGG, TAIN IV19 1QU

**eda** ARCHITECTS  
EDA Architects Ltd  
Omagh Enterprise Centre,  
41 Corryhugh Ind Est,  
Omagh BT78 5LU  
eoghan@eda-architects.com

REVISIONS

REV	DATE	DESCRIPTION	CHK	DRN
P04	26/08/23	ISSUED FOR PLANNING	DC	DG
P03	22/08/23	ISSUED FOR PLANNING	DC	DG
P02	21/08/23	ISSUED FOR PLANNING	DC	DG
P01	20/08/23	BIERM LAYOUT	DC	DG

STATUS

PLANNING

PROJECT

SEIUK - CL

PROJECT ADDRESS

-

DISCIPLINE

CIVIL

DWG TITLE

Site plan - Zone 2

DWG NO.

S264-EUR-EXT-ZZ-DR-CS-2202

STATUS CODE

S4

PROJECT NO.

S264

DATE

21/08/23

SCALE NO.

1 : 500

REVISION NUMBER  
**P04**

**EUROPLAN GROUP**

Parkview House, Beechill Office Campus,  
Clonskeagh, Dublin 4, Eire.  
Tel: +353 1 2606578  
staprojectteam@europlanservices.com


S-263-EUR-00-ZZ-DR-C-2204

S-263-EUR-00-ZZ-DR-C-2202


S-263-EUR-00-ZZ-DR-C-2204

A1

ALL DIMENSIONS TO BE CHECKED ON SITE. NO DIMENSIONS TO BE SCALED FROM THIS DRAWING. DRAWING IS TO BE READ IN CONJUNCTION WITH RELEVANT CONSULTANTS DRAWINGS.

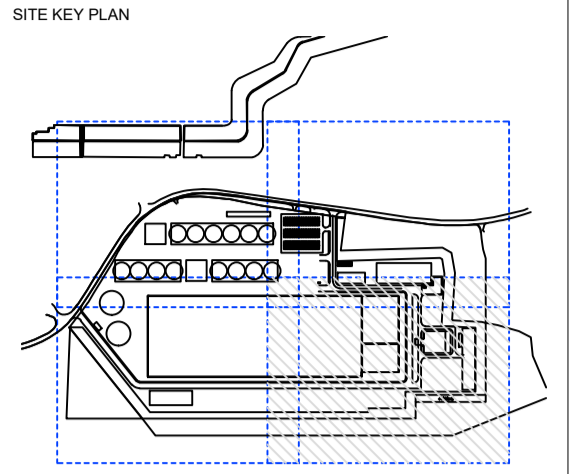

LEGEND

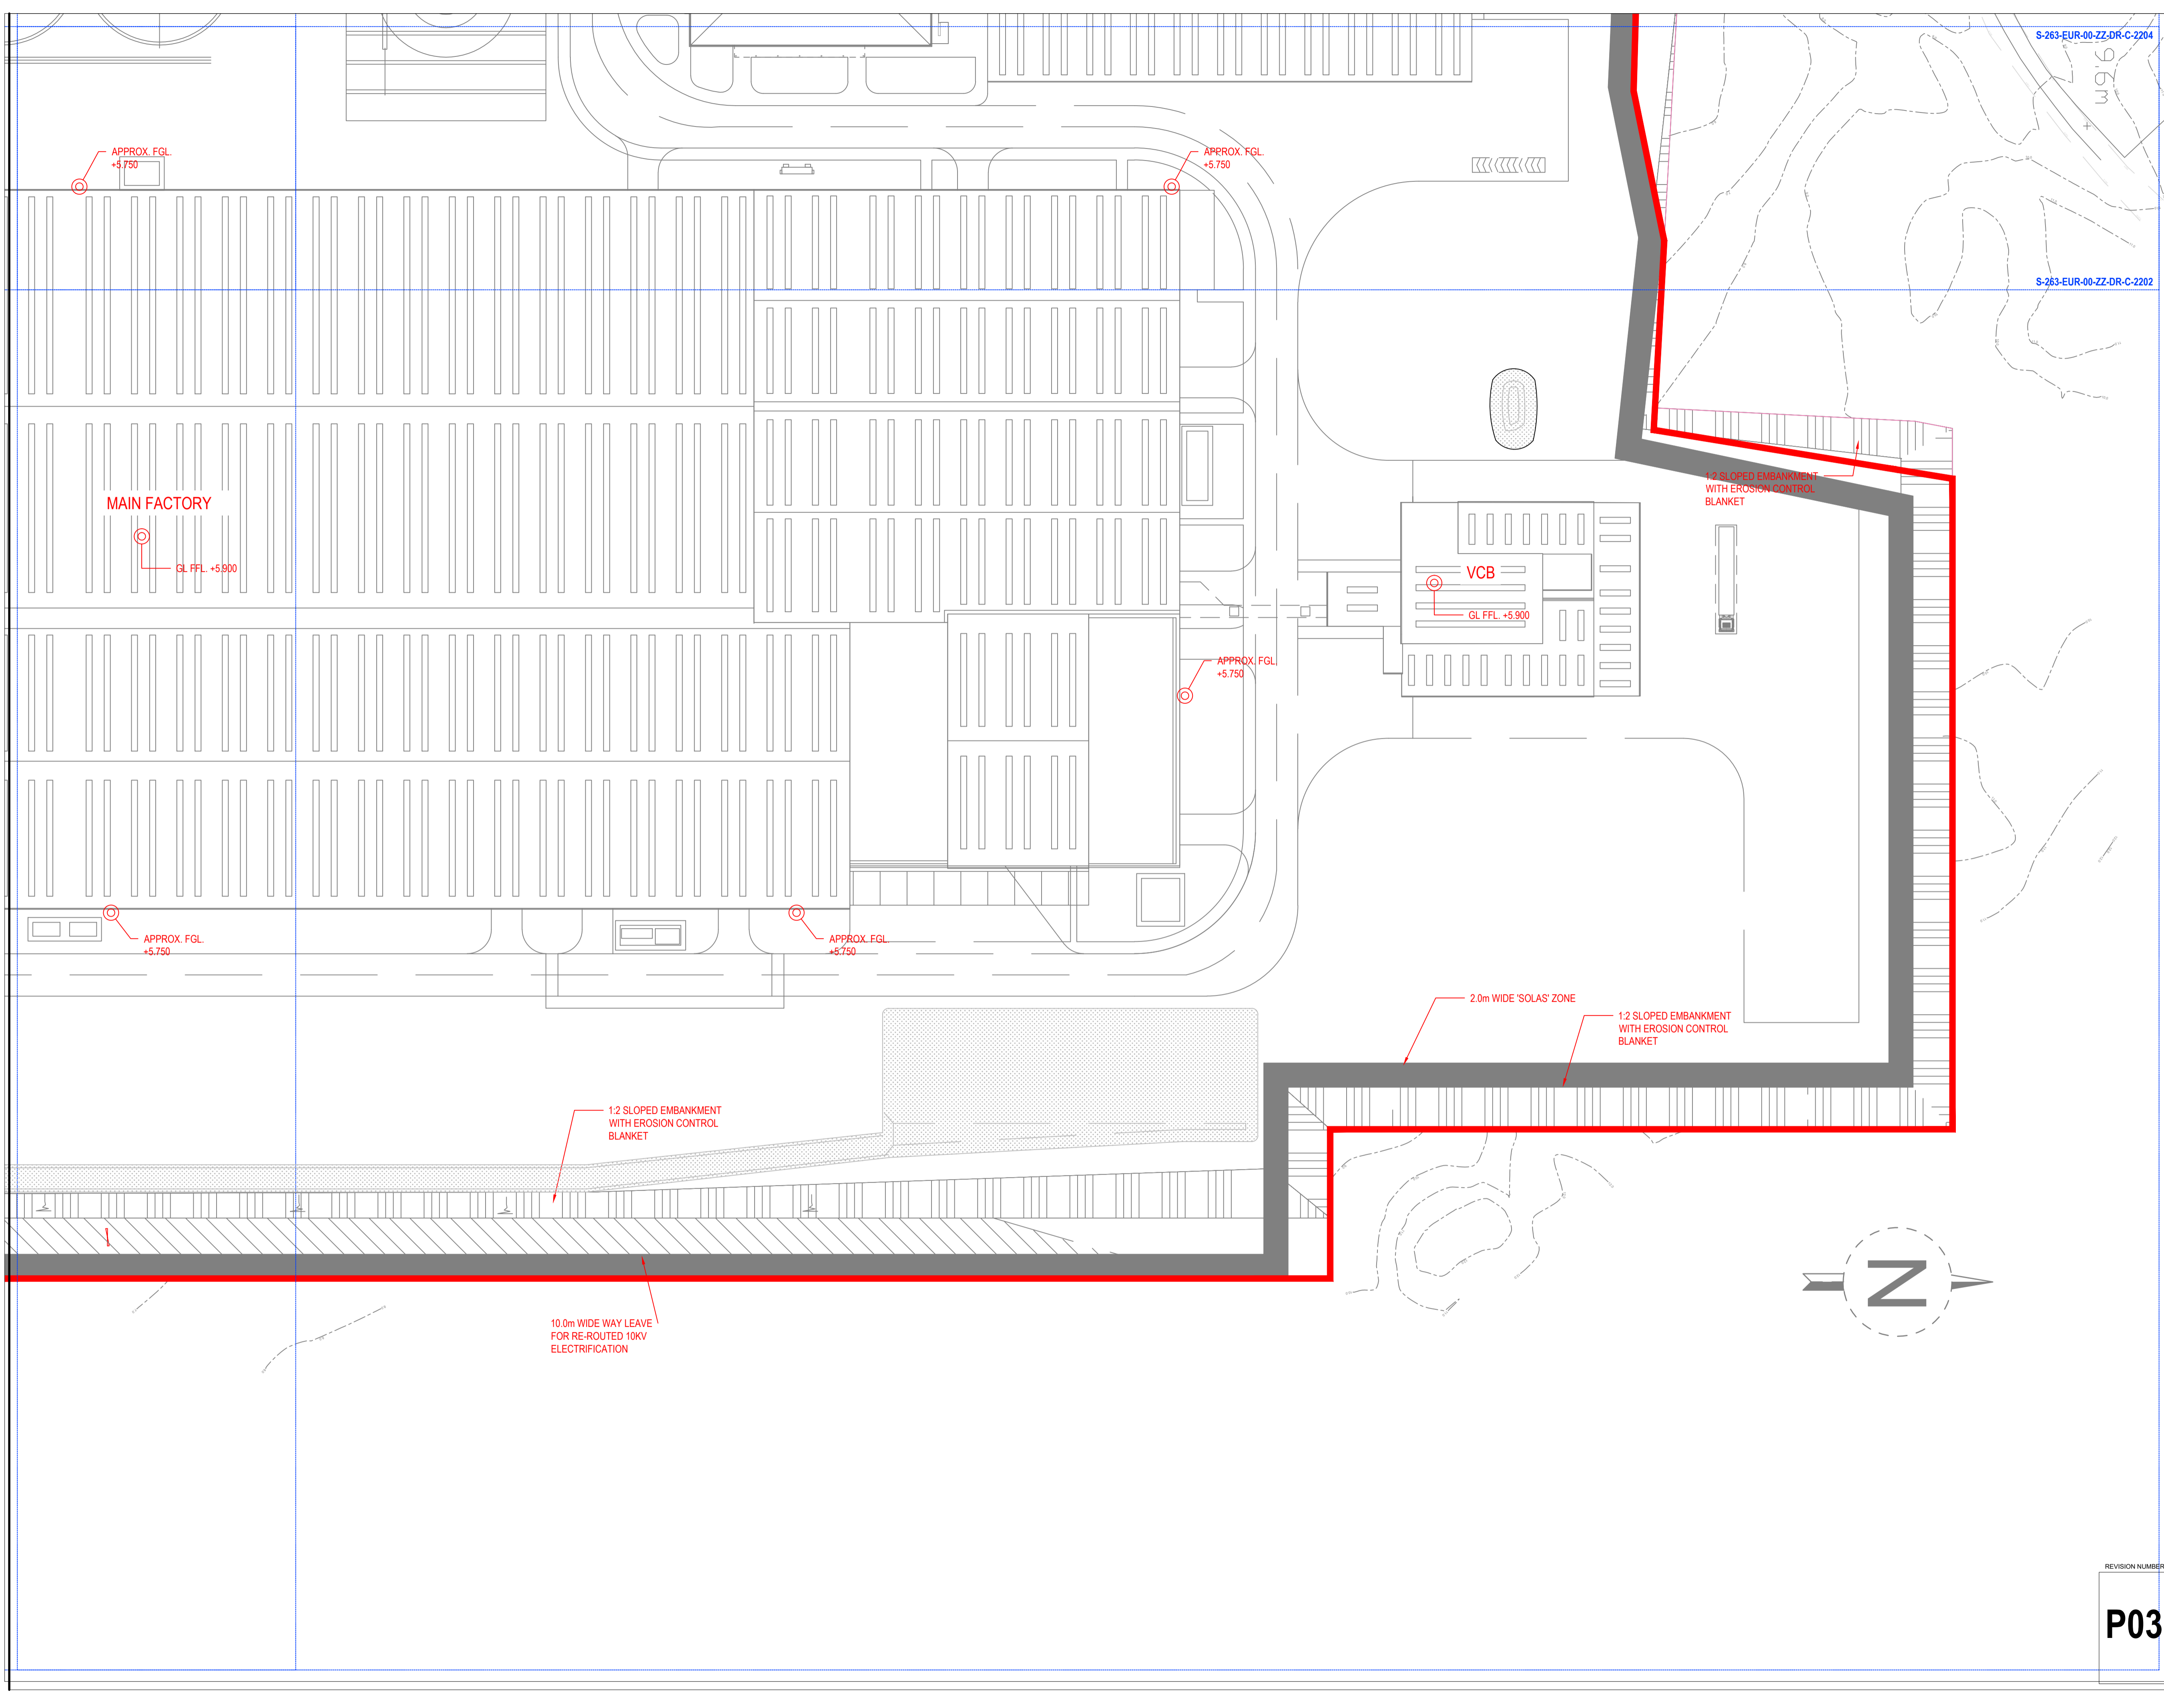

MAIN FACTORY

GL FFL +5.900

APPROX. FGL +5.750

APPROX. FGL +5.750

APPROX. FGL +5.750

VCB  
GL FFL +5.900


1:2 SLOPED EMBANKMENT WITH EROSION CONTROL BLANKET

1:2 SLOPED EMBANKMENT WITH EROSION CONTROL BLANKET

1:2 SLOPED EMBANKMENT WITH EROSION CONTROL BLANKET

2.0m WIDE 'SOLAS' ZONE

10.0m WIDE WAY LEAVE FOR RE-ROUTED 10KV ELECTRIFICATION

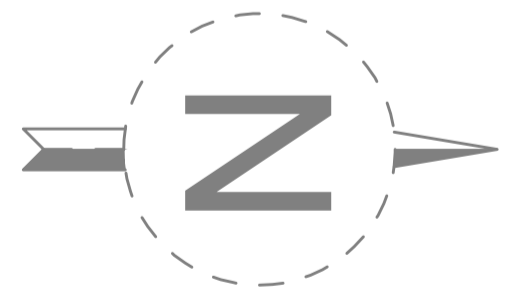

**SUMITOMO ELECTRIC**  
STA CABLE FACTORY  
NIGG, TAIN IV19 1QU

**eda** ARCHITECTS  
EDA Architects Ltd  
Omagh Enterprise Centre,  
41 Corrugh Ind Est,  
Omagh BT78 5LU  
eoghan@eda-architects.com

REV	DATE	DESCRIPTION	CHK	DRN

NO	DATE	DESCRIPTION	DC	DG
P03	22/09/23	ISSUED FOR PLANNING	DC	DG
P02	21/08/23	ISSUED FOR PLANNING	DC	DG
P01	20/06/23	BERM LAYOUT	DC	DG

STATUS  
**PLANNING**

PROJECT  
**SEIUK - CL**

PROJECT ADDRESS  
-

DISCIPLINE  
**CIVIL**

DWG TITLE  
**Site plan - Zone 4**

DWG NO.  
**S264-EUR-EXT-ZZ-DR-CS-2204**

STATUS CODE  
**C4**


PROJECT NO. <b>S264</b>	DATE <b>21/08/23</b>
DRAWN / CHECKED <b>SVM/DC</b>	SCALE NO. <b>1 : 500</b>

REVISION NUMBER  
**P03**


**EUROPLAN GROUP**  
Parkview House, Beechill Office Campus,  
Clonskeagh, Dublin 4, Eire.  
Tel: +353 1 2606578  
staprojectteam@europlanservices.com

ALL DIMENSIONS TO BE CHECKED ON SITE  
NO DIMENSIONS TO BE SCALED FROM THIS  
DRAWING. DRAWINGS TO BE READ IN  
CONJUNCTION WITH RELEVANT  
CONSULTANT DRAWINGS

SITE KEY PLAN

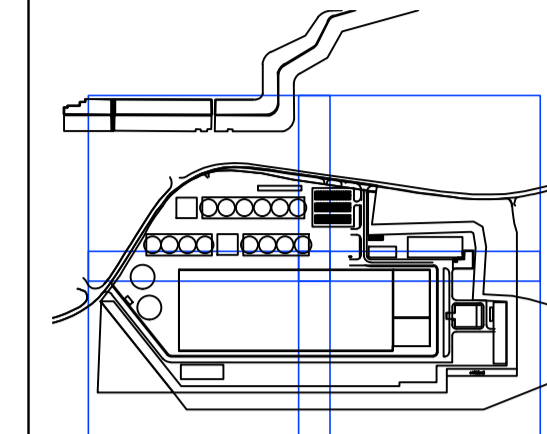

LEGEND

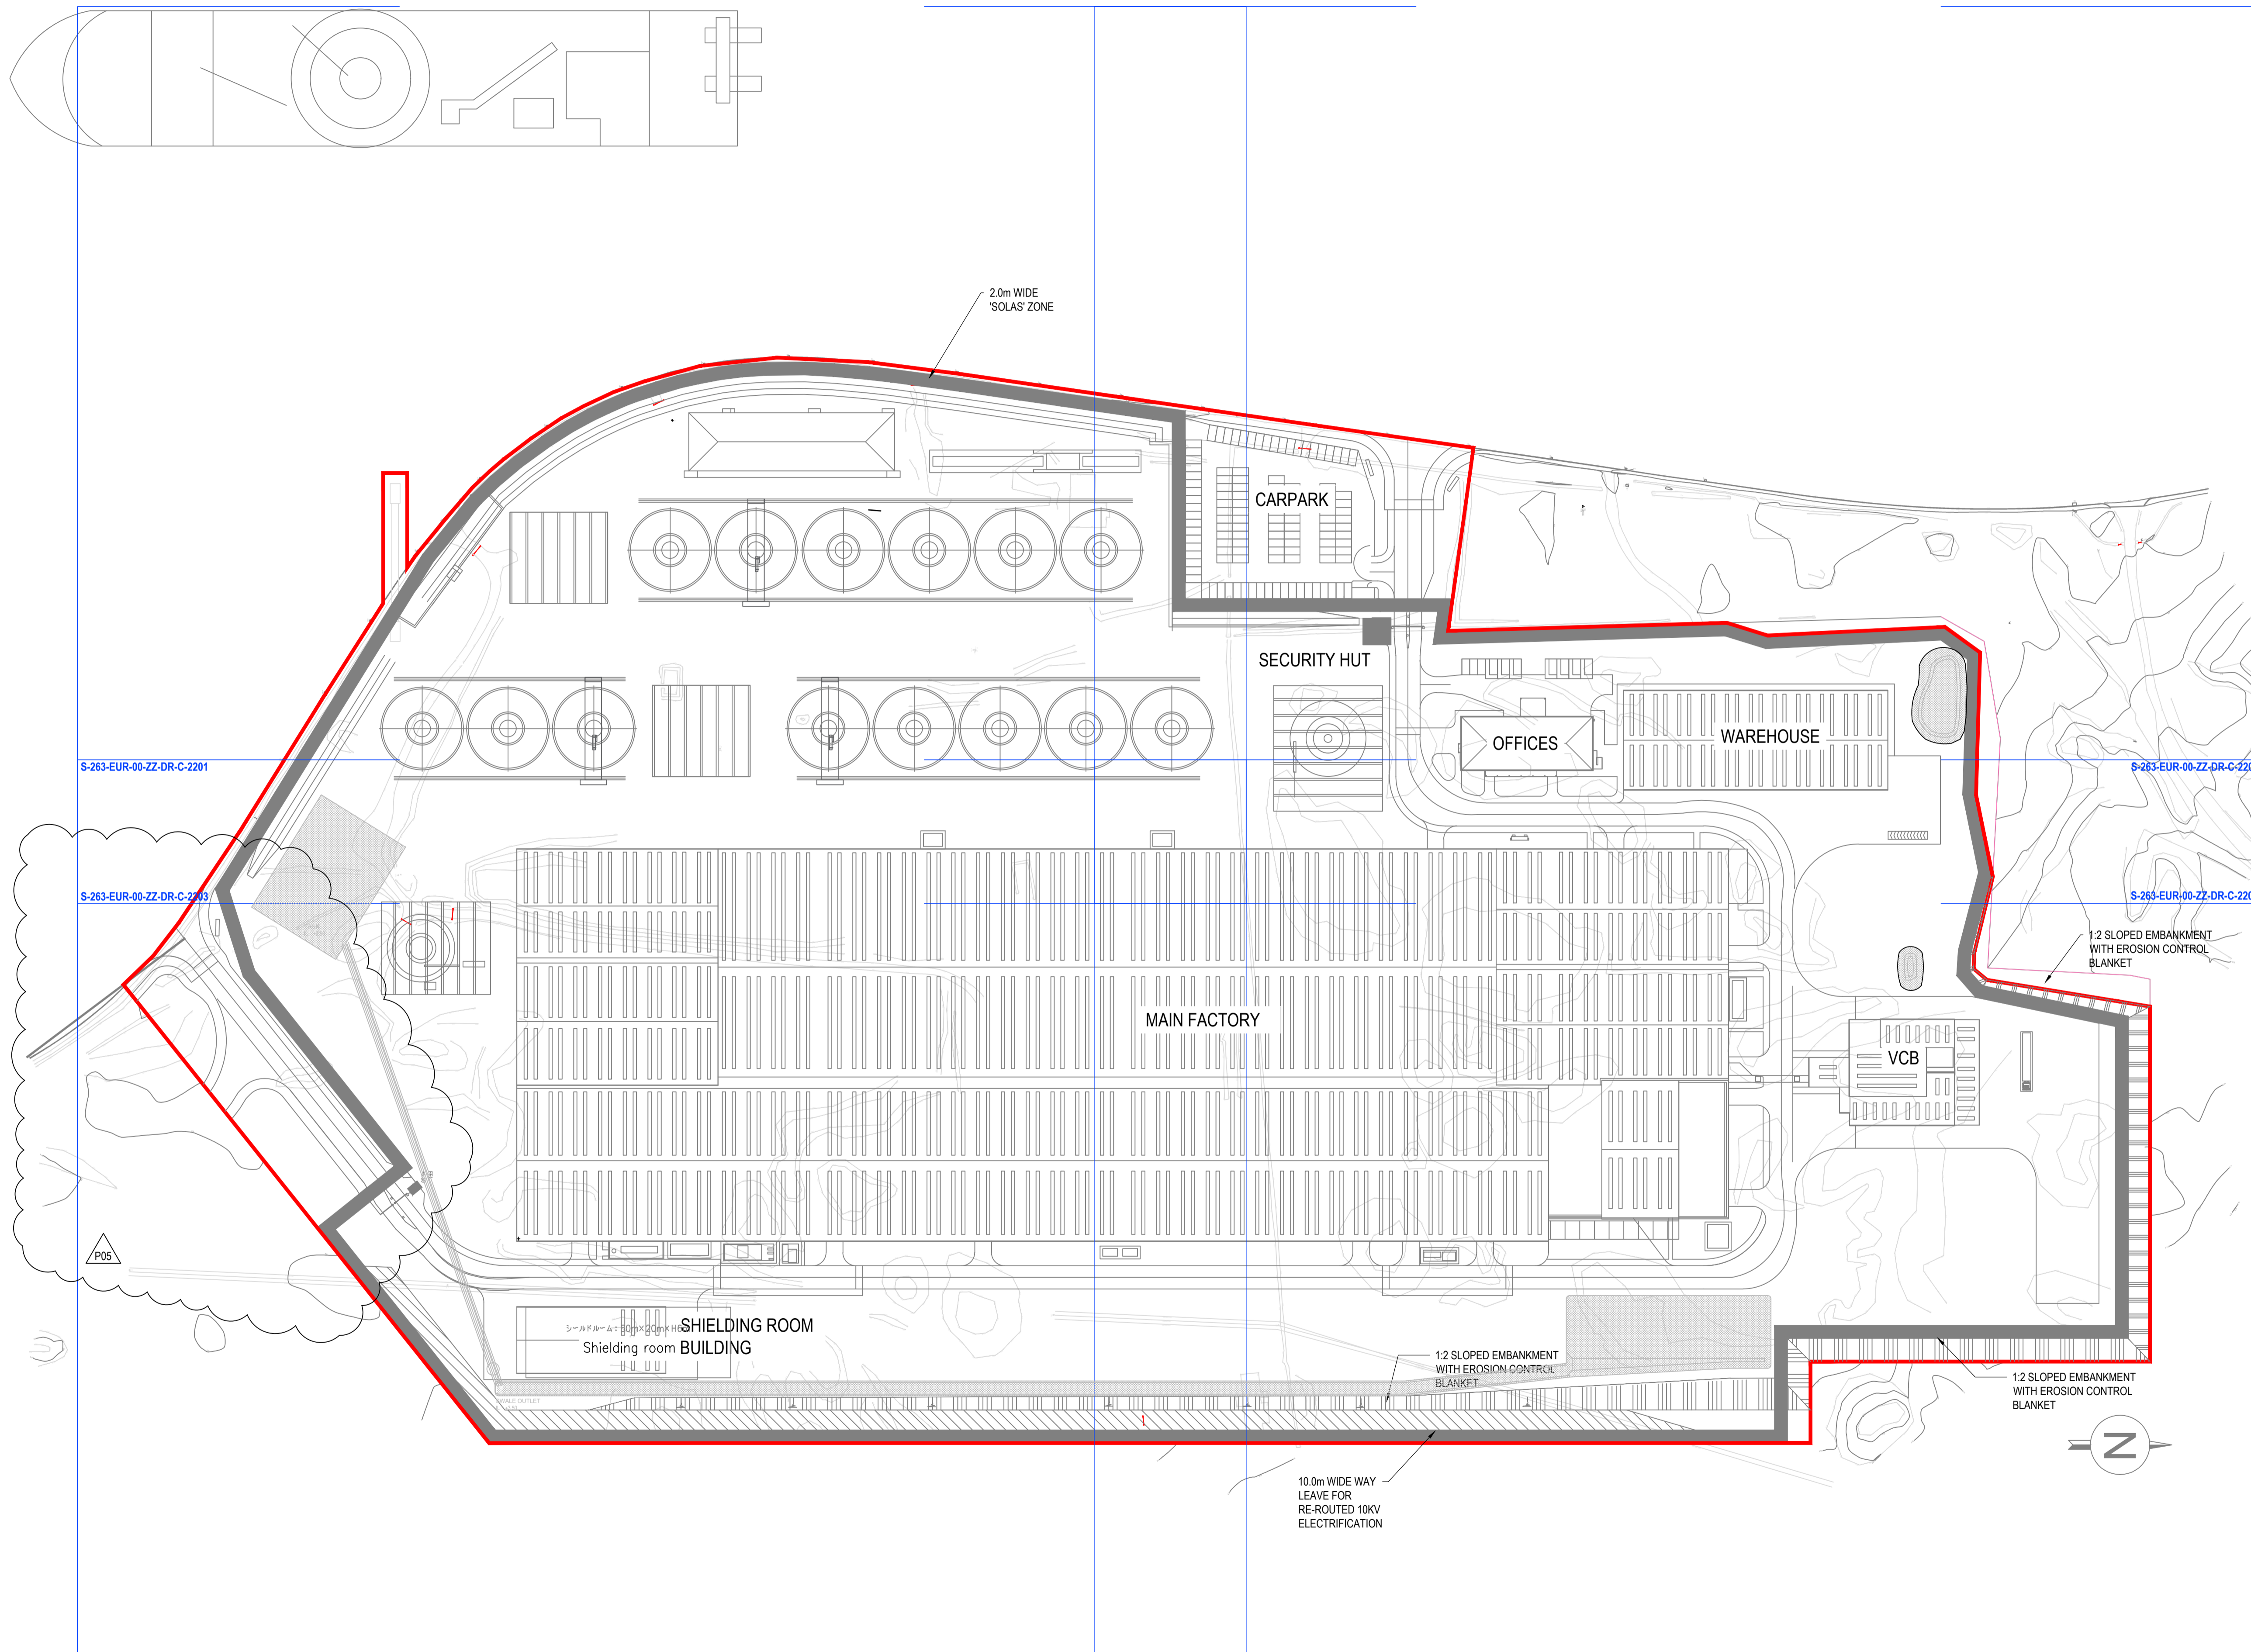

**SUMITOMO ELECTRIC**  
STA CABLE FACTORY  
NIGG, TAIN IV19 1QU

**eda** ARCHITECTS  
EDA Architects Ltd  
Omagh Enterprise Centre,  
41 Corneish Ind Est,  
Omagh BT78 5LU  
eoghan@eda-architects.com

REVISIONS

REV	DATE	DESCRIPTION	DC	DG
P05	20/08/23	ISSUED FOR PLANNING	DC	DG
P04	26/08/23	ISSUED FOR PLANNING	DC	DG
P03	22/08/23	ISSUED FOR PLANNING	DC	DG
P02	21/08/23	ISSUED FOR PLANNING	DC	DG
P01	20/08/23	BERN LAYOUT	DC	DG

STATUS  
**PLANNING**

PROJECT  
**SEUK - CL**

PROJECT ADDRESS  
-

DISCIPLINE  
**CIVIL**

DWG TITLE  
**Site plan - Overall view**

DWG NO.  
**S264-EUR-EXT-ZZ-DR-CS-2200**

STATUS CODE  
**S4**

PROJECT NO.  
**S264**

DATE  
**21/08/23**

DRAWN / CHECKED  
**SVW/DC**

SCALE NO.  
**1 : 1000**

REVISION NUMBER

**P05**

**EUROPLAN GROUP**


Parkview House, Beechill Office Campus,  
Clonskeagh, Dublin 4, Eire.  
Tel: +353 1 2606578  
staprojectteam@europlanservices.com




S-263-EUR-00-ZZ-DR-C-2201

S-263-EUR-00-ZZ-DR-C-2203

A1

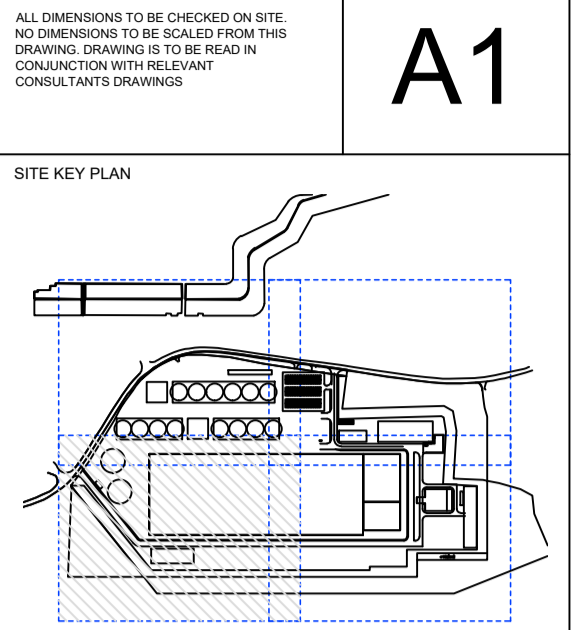

LEGEND

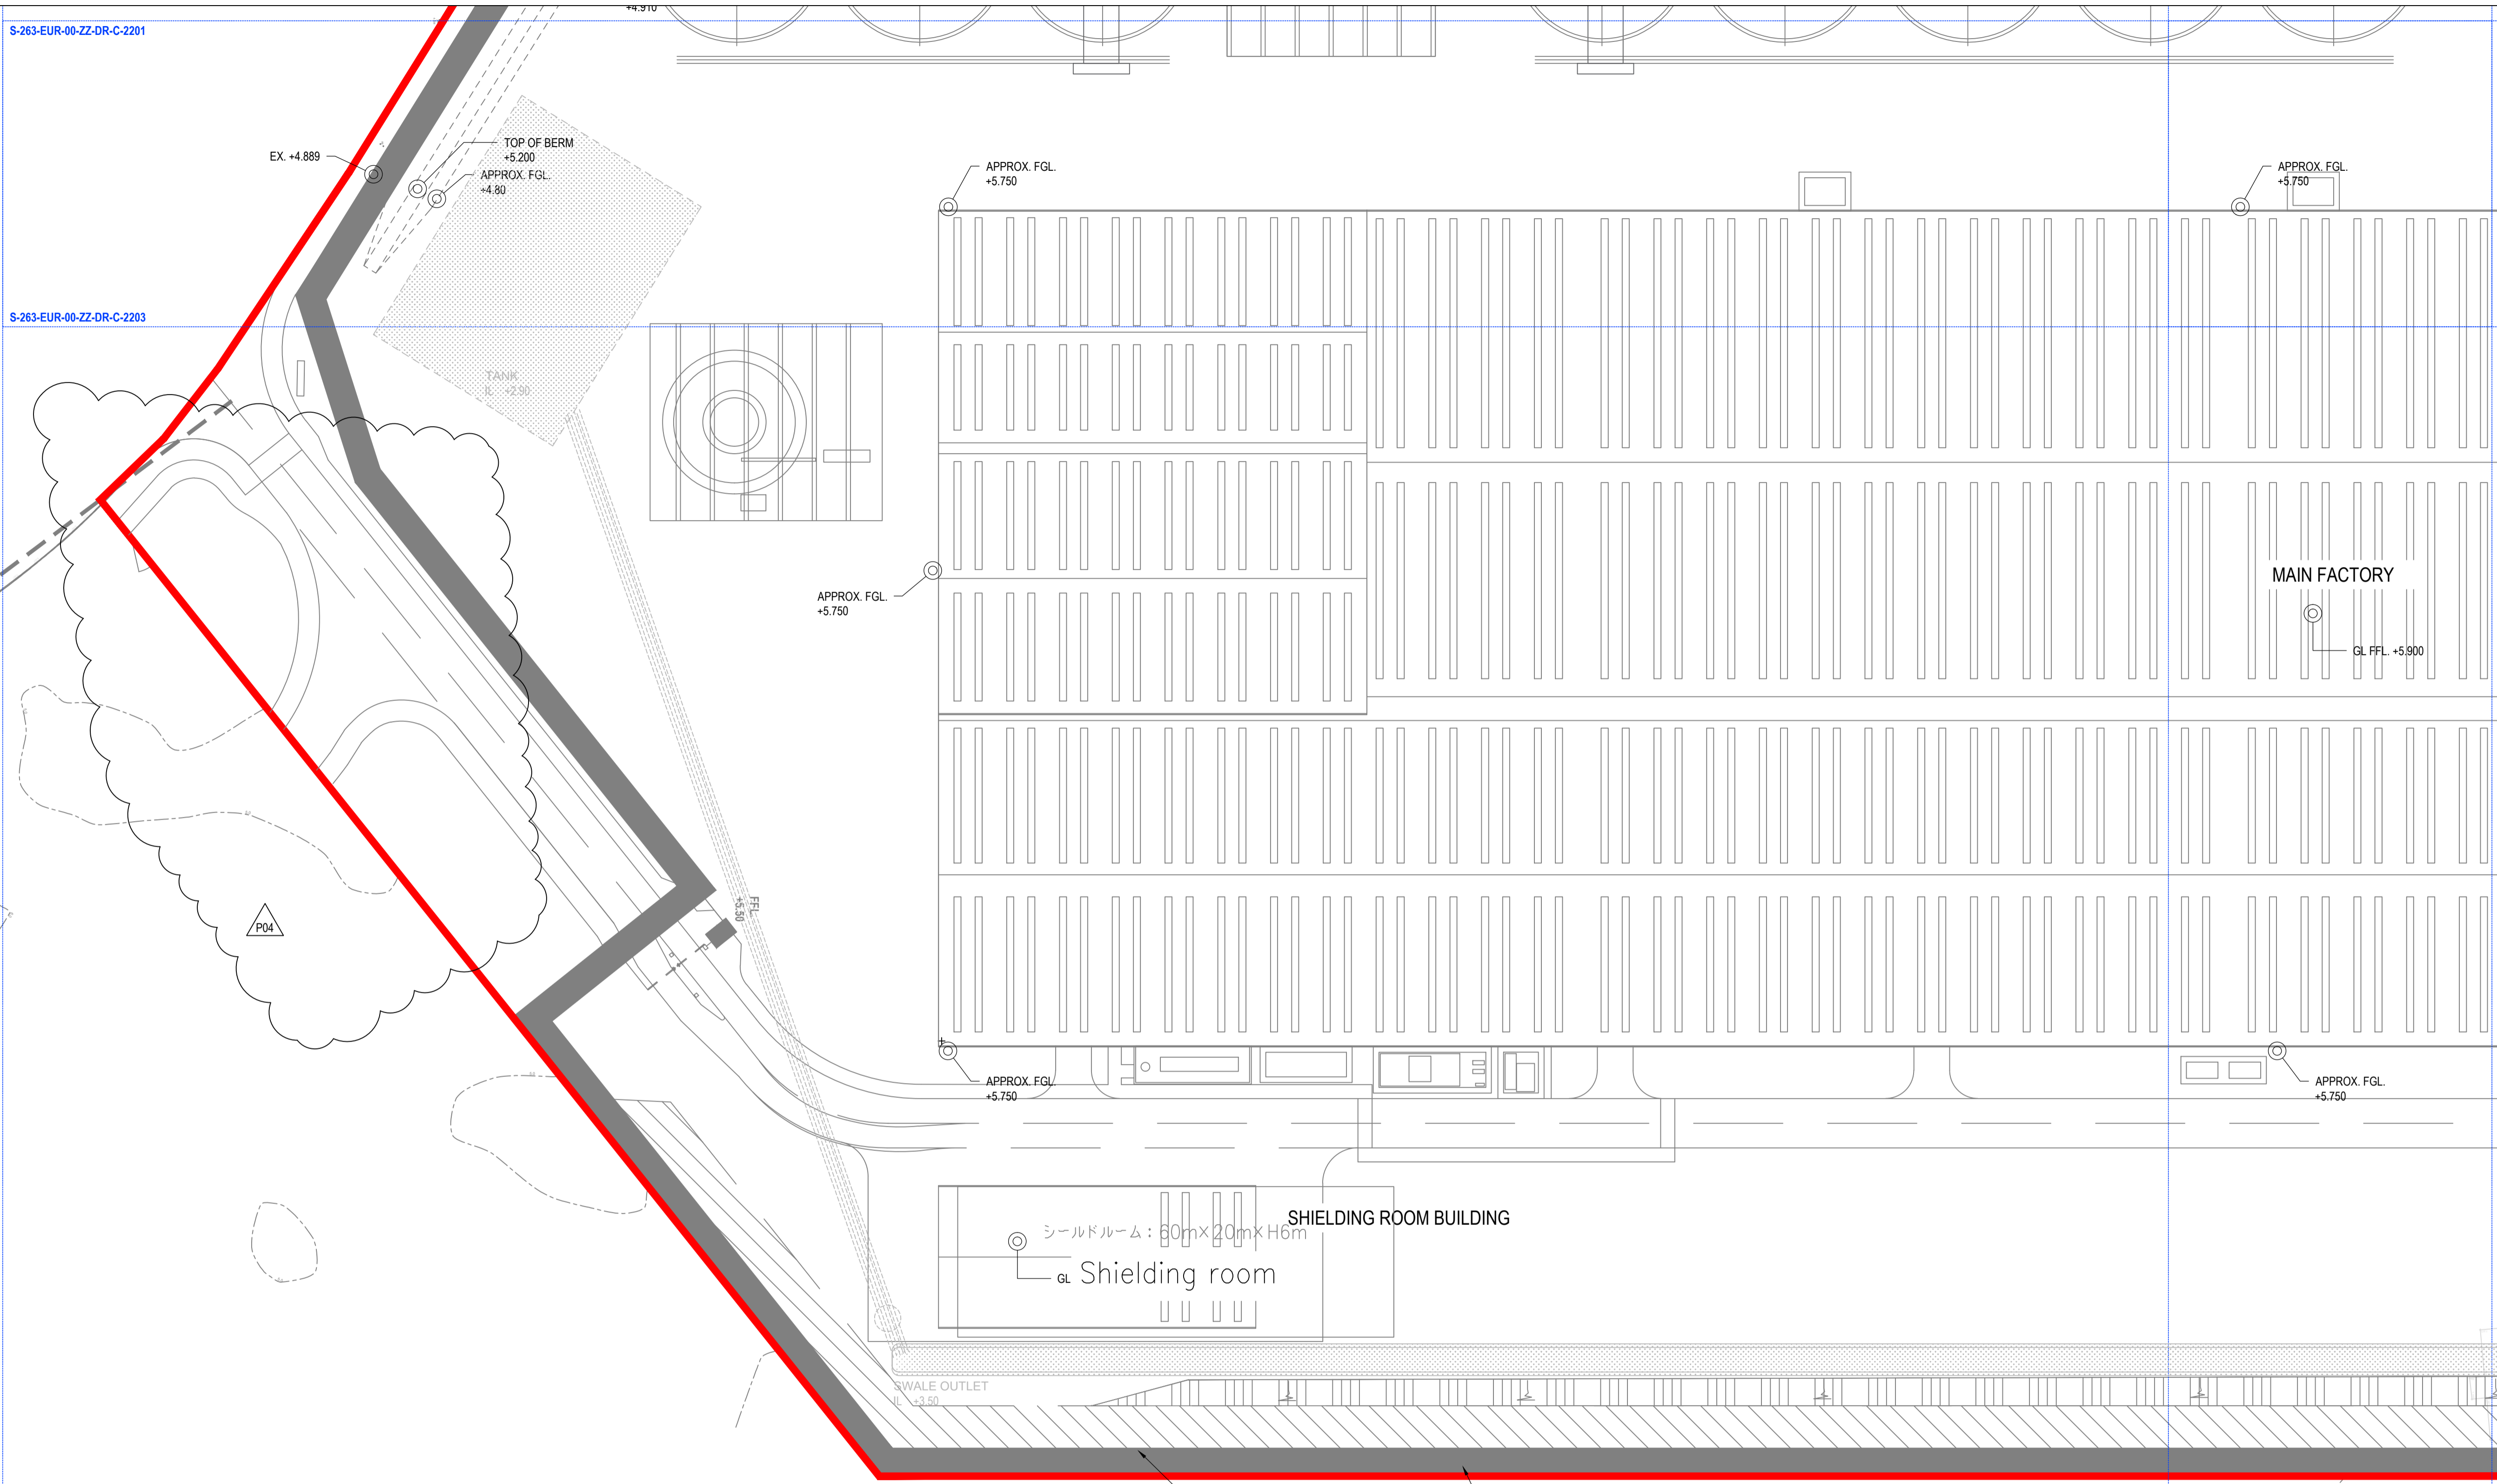

**SUMITOMO ELECTRIC**  
STA CABLE FACTORY  
NIGG, TAIN IV19 1QU

**eda**  
ARCHITECTS

EDA Architects Ltd  
Omagh Enterprise Centre,  
41 Corruish Ind Est,  
Omagh BT78 5LU  
eoghan@eda-architects.com

REVISIONS

REV	DATE	DESCRIPTION	CHK	DRN
P04	20/08/23	ISSUED FOR PLANNING	DC	DG
P03	22/08/23	ISSUED FOR PLANNING	DC	DG
P02	21/08/23	ISSUED FOR PLANNING	DC	DG
P01	20/08/23	BERM LAYOUT	DC	DG

STATUS

PROJECT

PROJECT ADDRESS


DISCIPLINE  
**CIVIL**

DWG TITLE  
**Site plan - Zone 3**

DWG NO.  
**S264-EUR-EXT-ZZ-DR-C-2203**

STATUS CODE  
**S4**

PROJECT NO. <b>S264</b>	DATE <b>21/08/23</b>
DRAWN / CHECKED <b>SVW/DC</b>	SCALE NO. <b>1 : 500</b>

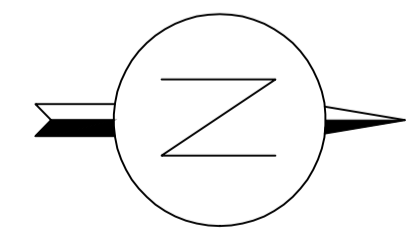

REVISION NUMBER


**P04**

**EUROPLAN GROUP**

Parkview House, Beechill Office Campus,  
Clonskeagh, Dublin 4, Eire.  
Tel: +353 1 2606578  
staprojectteam@europlanservices.com

SITE KEY PLAN

LEGEND

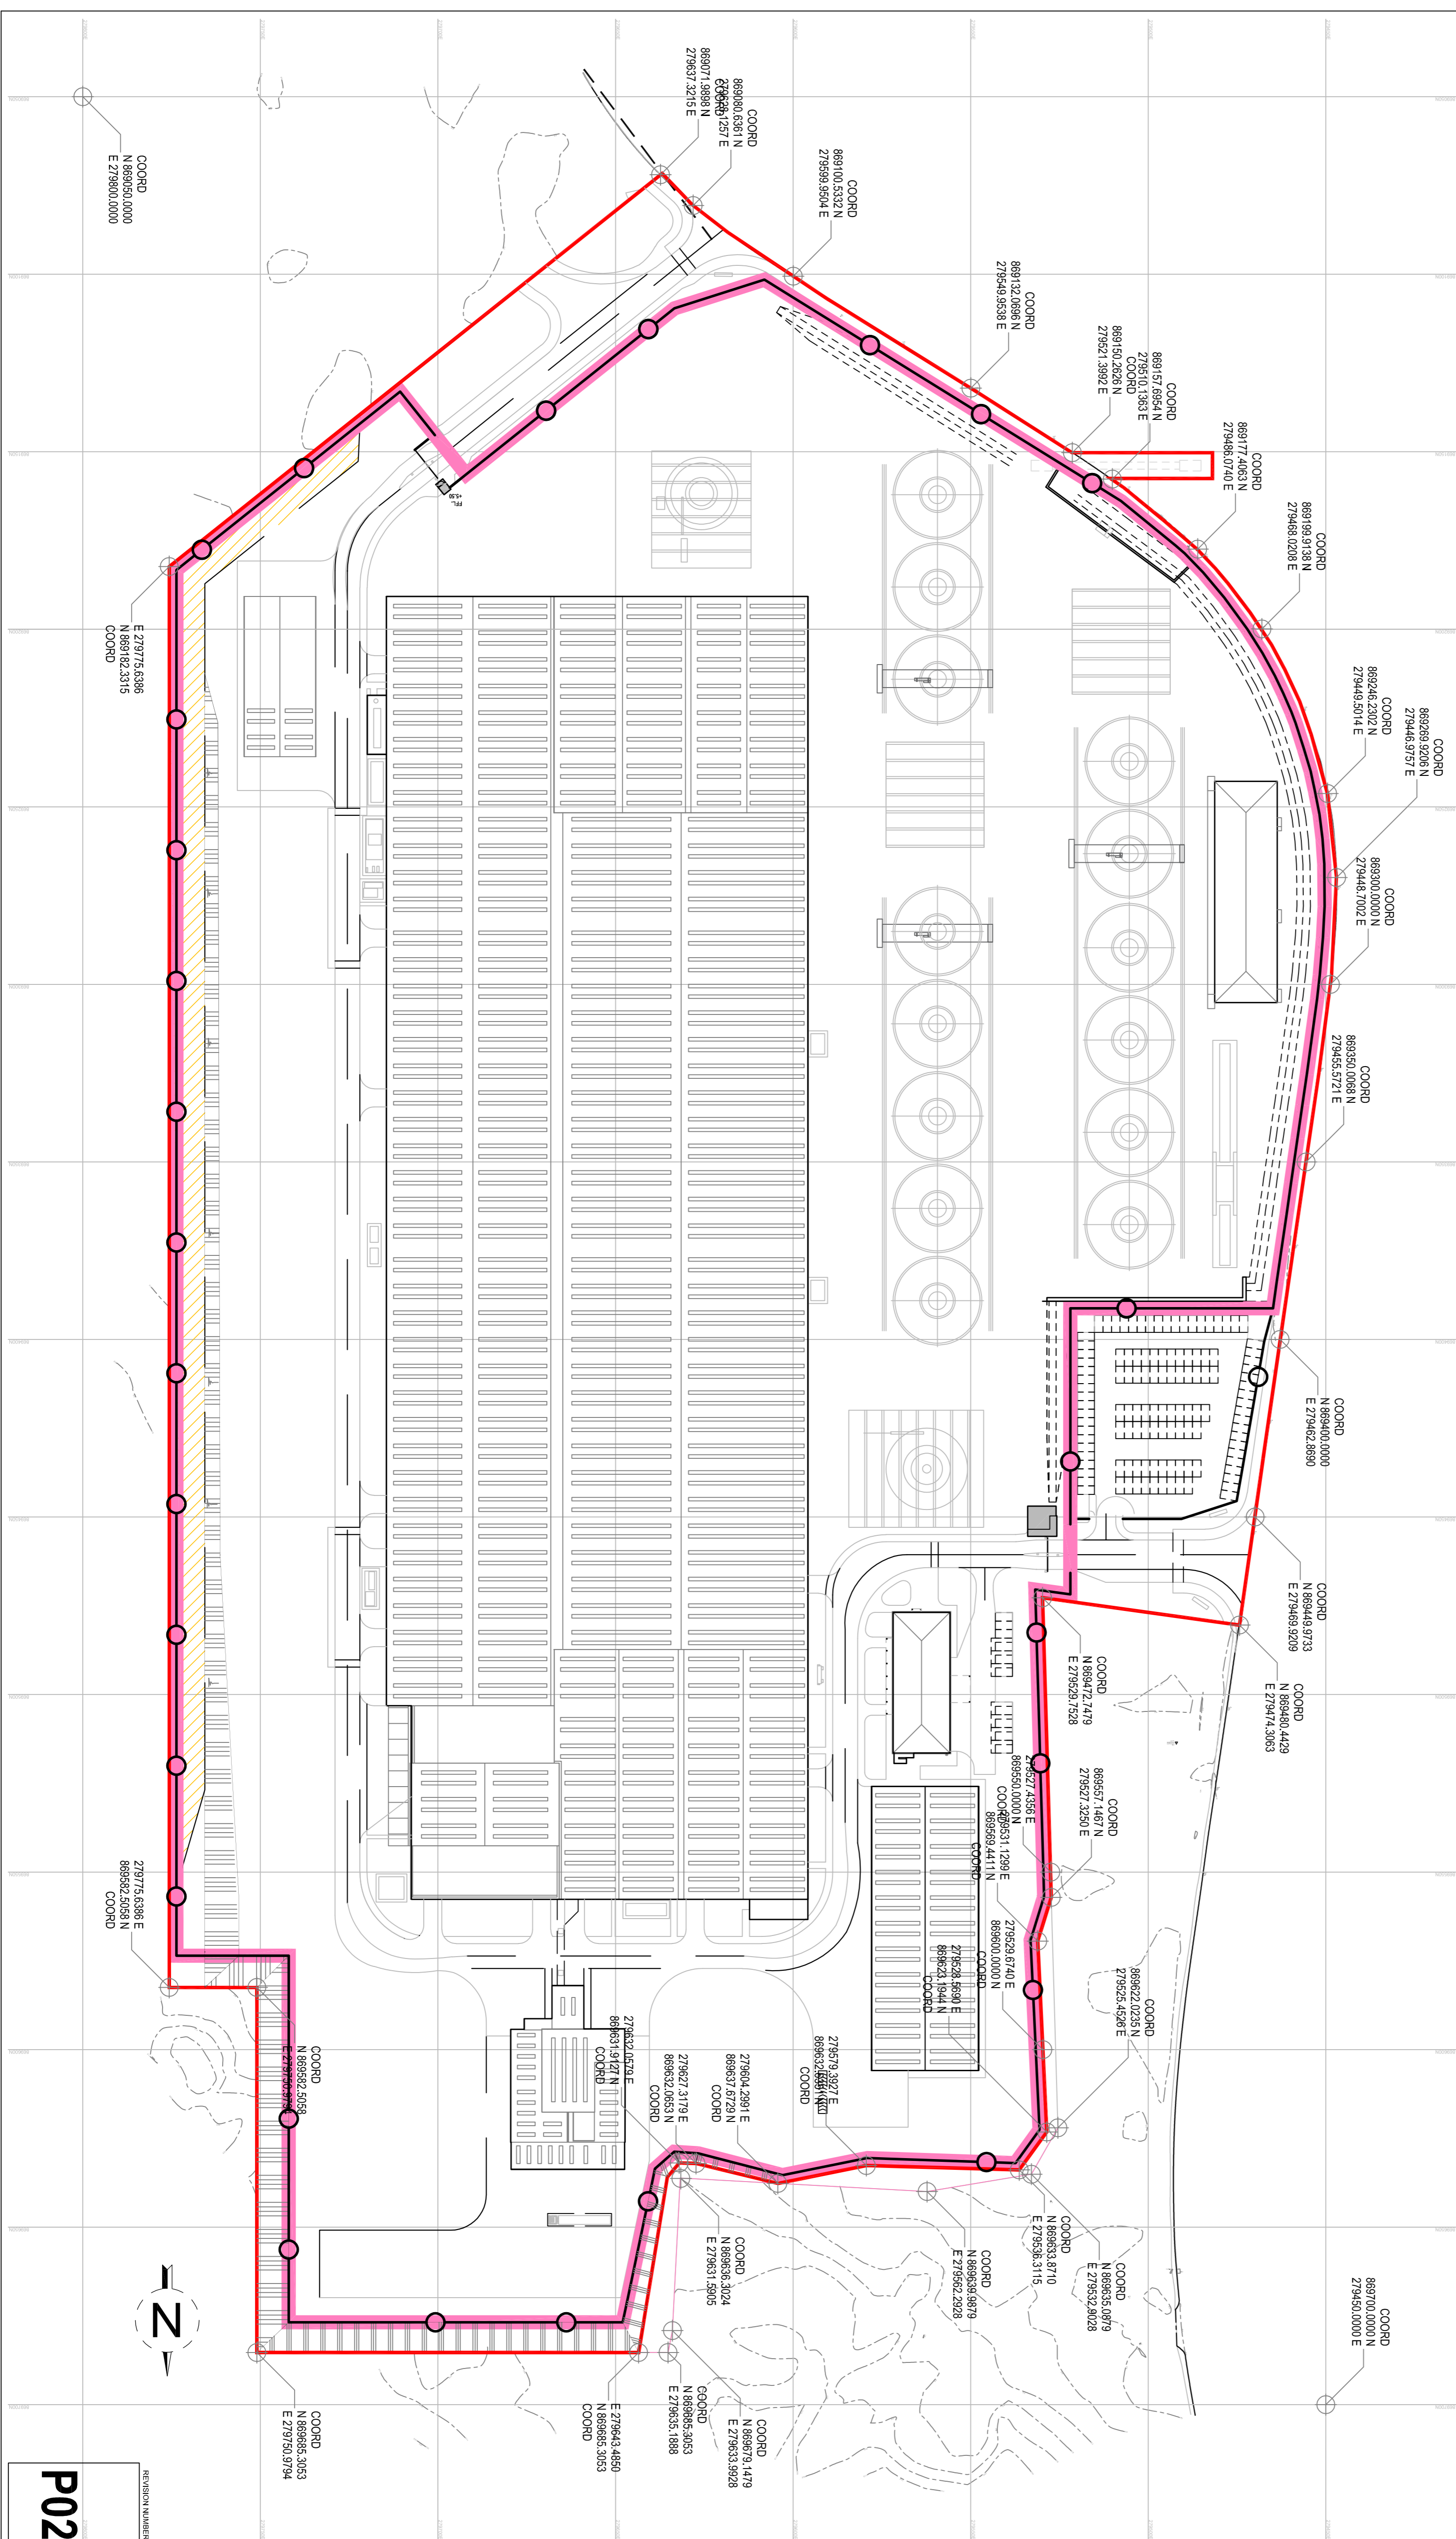

**STA CABLE FACTORY**  
ELECTRIC  
SUNTOWO  
INGG. TAINI IV19 1QU

**eda**  
ARCHITECTS  
EDA Architects Ltd  
Omni Enterprise Centre,  
Omni BT19 5LU  
edainfo@eda-architects.com

REVISIONS

NO	DATE	DESCRIPTION	BY	CHK	APP
001	12/20/23	REVISION SUBMITTED	CG	CG	CG
002	12/20/23	REVISION SUBMITTED	CG	CG	CG
003	12/20/23	REVISION SUBMITTED	CG	CG	CG

PROJECT ADDRESS  
**SEURK - CL**

DESCRIPTION  
**CIVIL**

DWG TITLE  
**Red Line Coordinates**

DWG NO.  
**S24-EUR-00-ZZ-DR-C-2015**

PROJECT NO.  
**S24**




DATE  
**05/11/23**

SCALE NO.  
**1:1000/800**


REVISION NUMBER  
**P02**

**EUROPLAN GROUP**  
Parkview House, Beechill Office Campus,  
Omskeagh, Dublin 4, Eire.  
Tel: +353 1 2605578  
saproductteam@europlan-services.com

Refer to civil engineer's drawings for site levels and SUDS design details.


Project Design Team Members			
<b>Client</b>	Code <b>SUM/ CL</b>	 <b>SUMITOMO ELECTRIC</b>	SEI, Kujicho Hitachi City Japan
<b>Project Management Contractors</b>	Code <b>EUR/ PMC</b>	 <b>EUROPLAN GROUP</b>	Parkview House, Beechill Office Campus, Clonskeagh, Dublin 4, Eire. Tel: +353 1 2606578 staprojectteam@europlanservices.com
<b>Civil Engineers</b>	<b>EUR/ CS</b>		
<b>Structural Engineers</b>	<b>EUR/ SE</b>		
<b>Mechanical Engineers</b>	<b>EUR/ MP</b>		
<b>Electrical Engineers</b>	<b>EUR/ EL</b>		
<b>Architects</b>	Code <b>EDA/ AR</b>	 <b>eda</b>	EDA Architects Ltd Orang Energy Centre, Clonskeagh, Dublin 4, Eire. Company No. 117781 sophan@eda-architects.com

© Copyright EDA Architects Ltd. The Construction (Design and Management) Regulations 2015 apply to this project. Please refer to the 'Pre-Construction Information', 'Construction Phase Plan' and other relevant documents. All dimensions in millimeters. This drawing is subject to statutory approval (planning, building control etc)

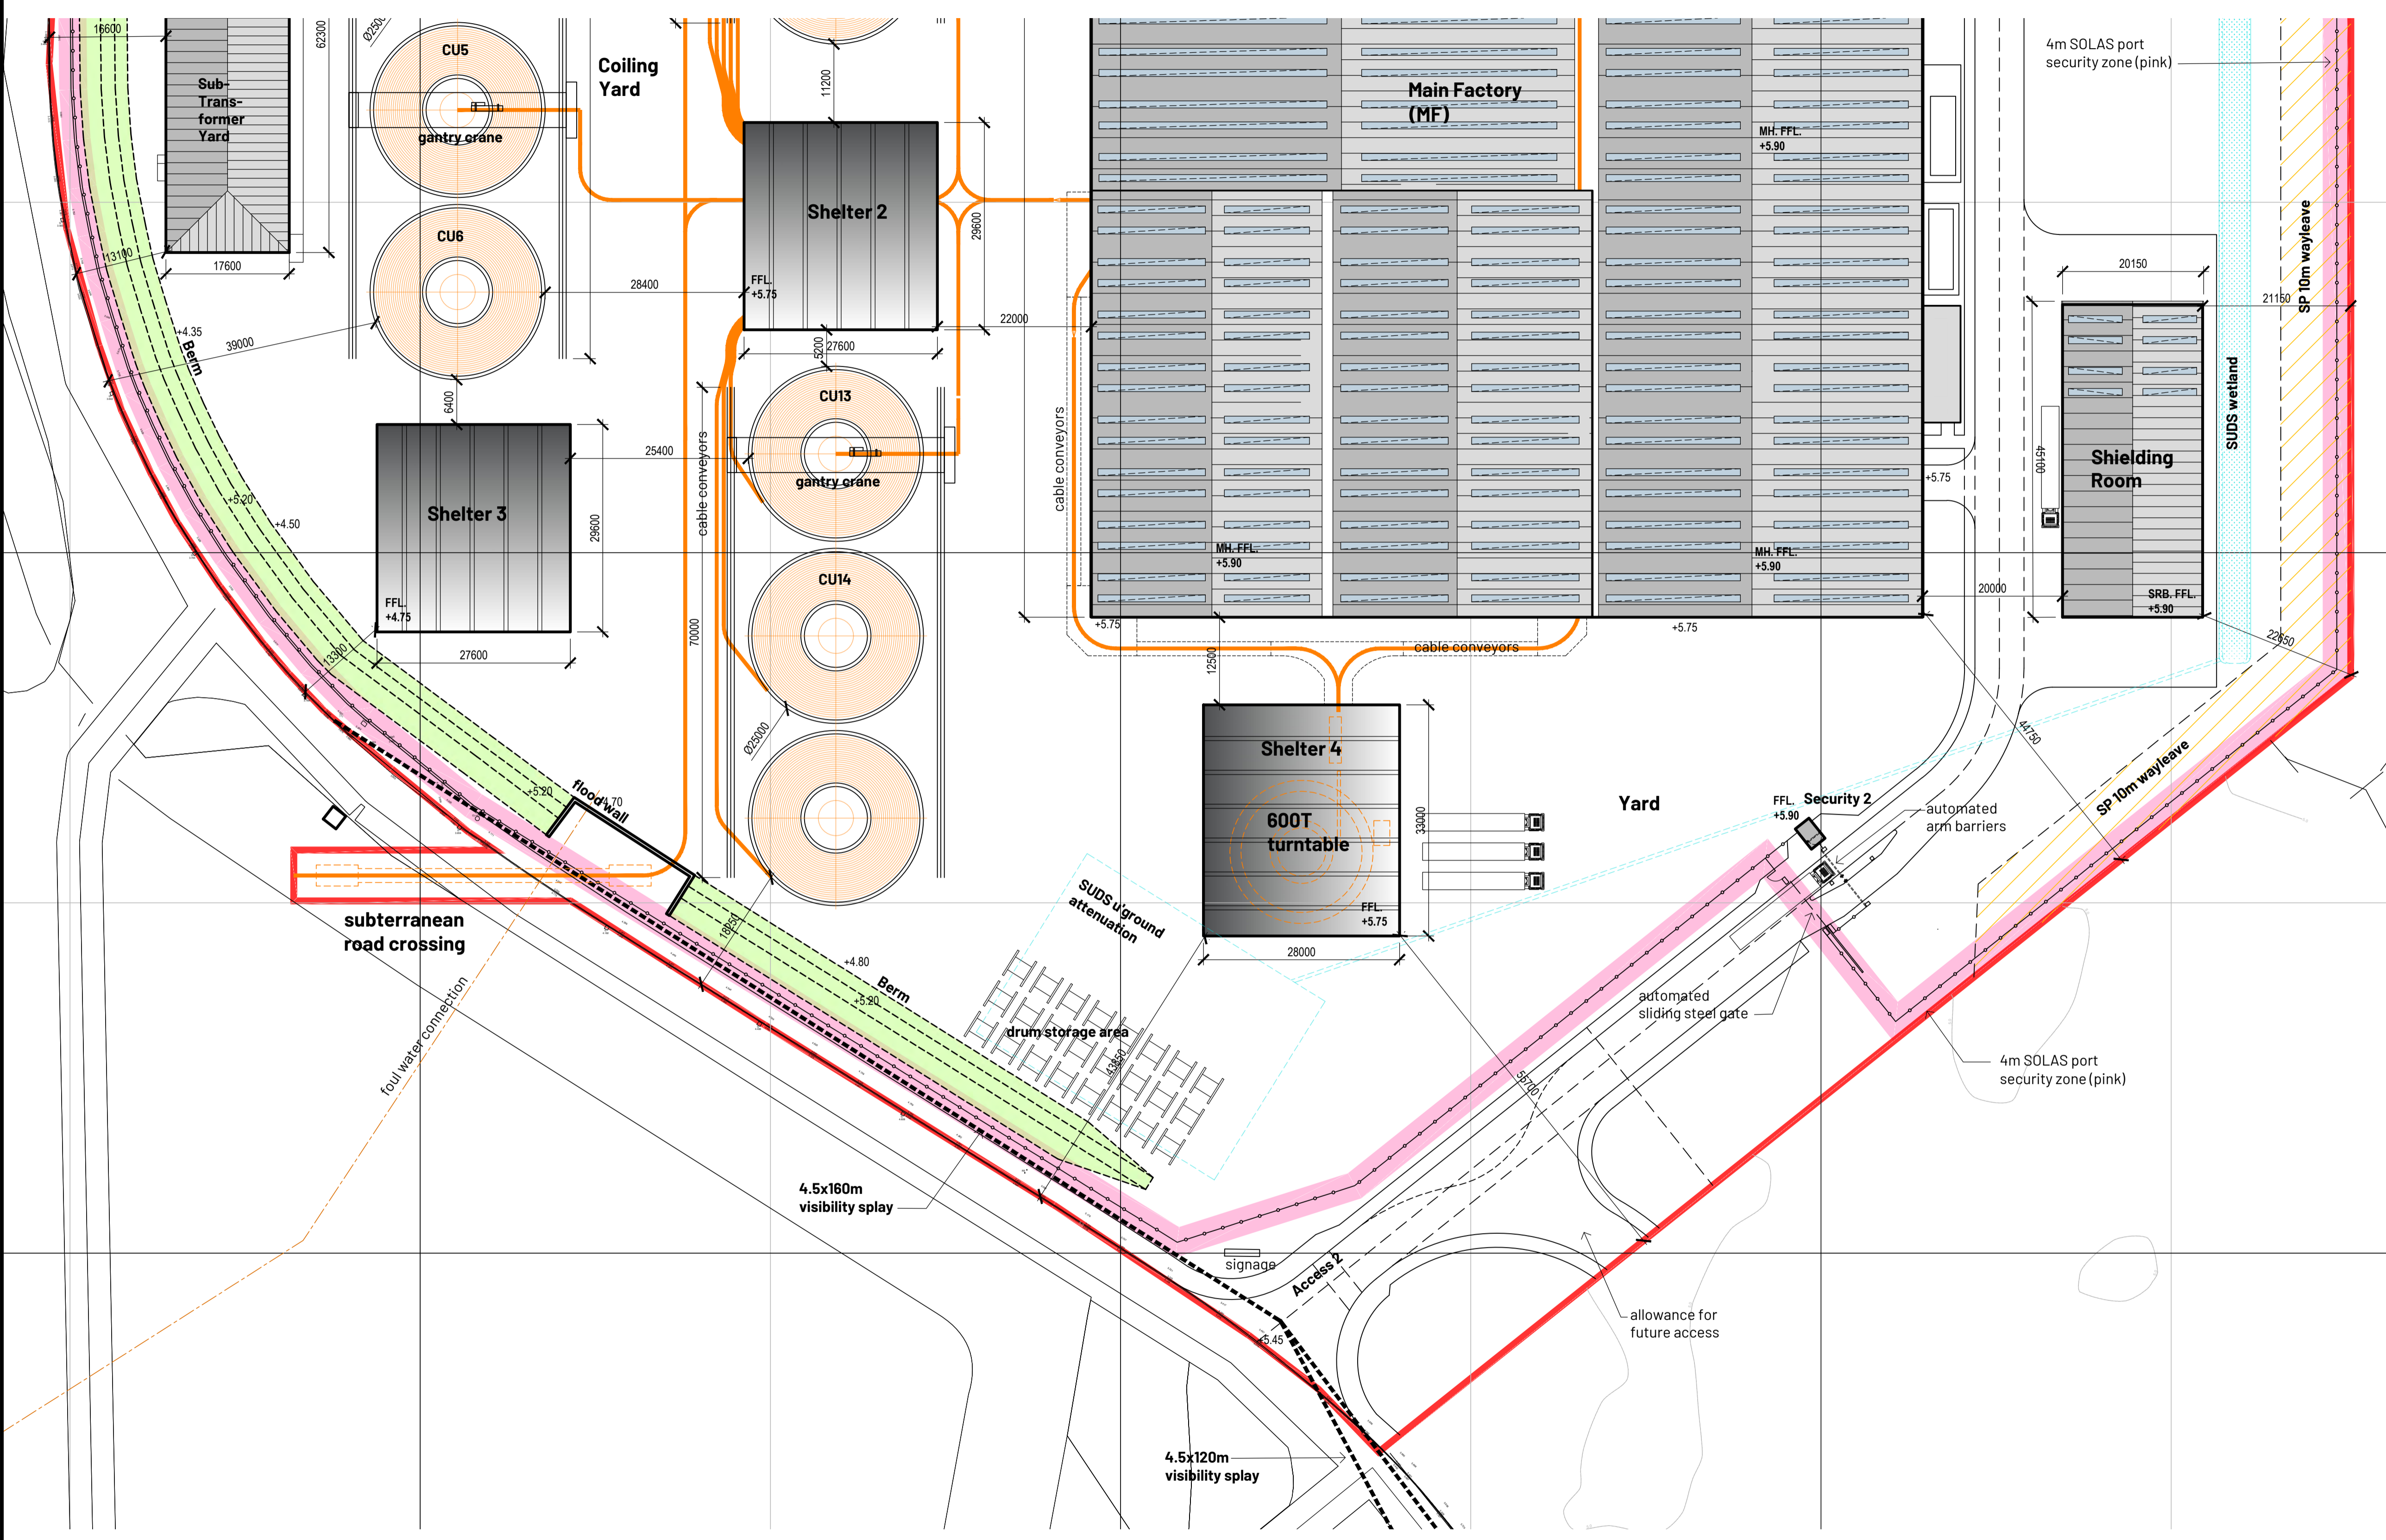

Rev	Date	Description
P08	29.09.23	minor revision
P07	28.09.23	minor revision
P06	24.09.23	revised FFL. RPA's shown.
P05	17.09.23	RIBA3 revisions: red line, embankment, SUDS.
P04	21.08.23	revised layout. RIBA3 stage issue.
P03	17.08.23	revised layout. RIBA3 stage issue.
P02	15.08.23	revised layout. issued for RIBA3 stage approval.

**Proposed Site Layout (sheet 3)**  
1:500 scale bar  
0 5m 25m


 **SEUK CL**  
**SUMITOMO ELECTRIC** NIGG, TAIN IV19 1QU


Discipline: ARCHITECT

Sheet Title:  
SITE LAYOUT. SHEET 3:  
COILING YARD, SHELTERS 3, 4, SECURITY HUT 2,  
DRUM STORAGE AREA, SHIELDING ROOM.

Sheet Number	PROJECT	ORIGINATOR	VOLUME	LEVEL
	<b>S263</b>	EDA	EXT	EX
TYPE	ROLE	NO.	SUIT.	REV.
DR	AR	153	S4	P08

Scale: 1:500 (A1)  
Date: 21.07.23  
By: ED Chk: ED

  
**EUROPLAN GROUP**  
Project Management Contractors  
Parkview House, Beechill Office Campus,  
Clonskeagh, Dublin 4, Eire.  
Tel: +353 1 2606578  
staprojectteam@europlanservices.com

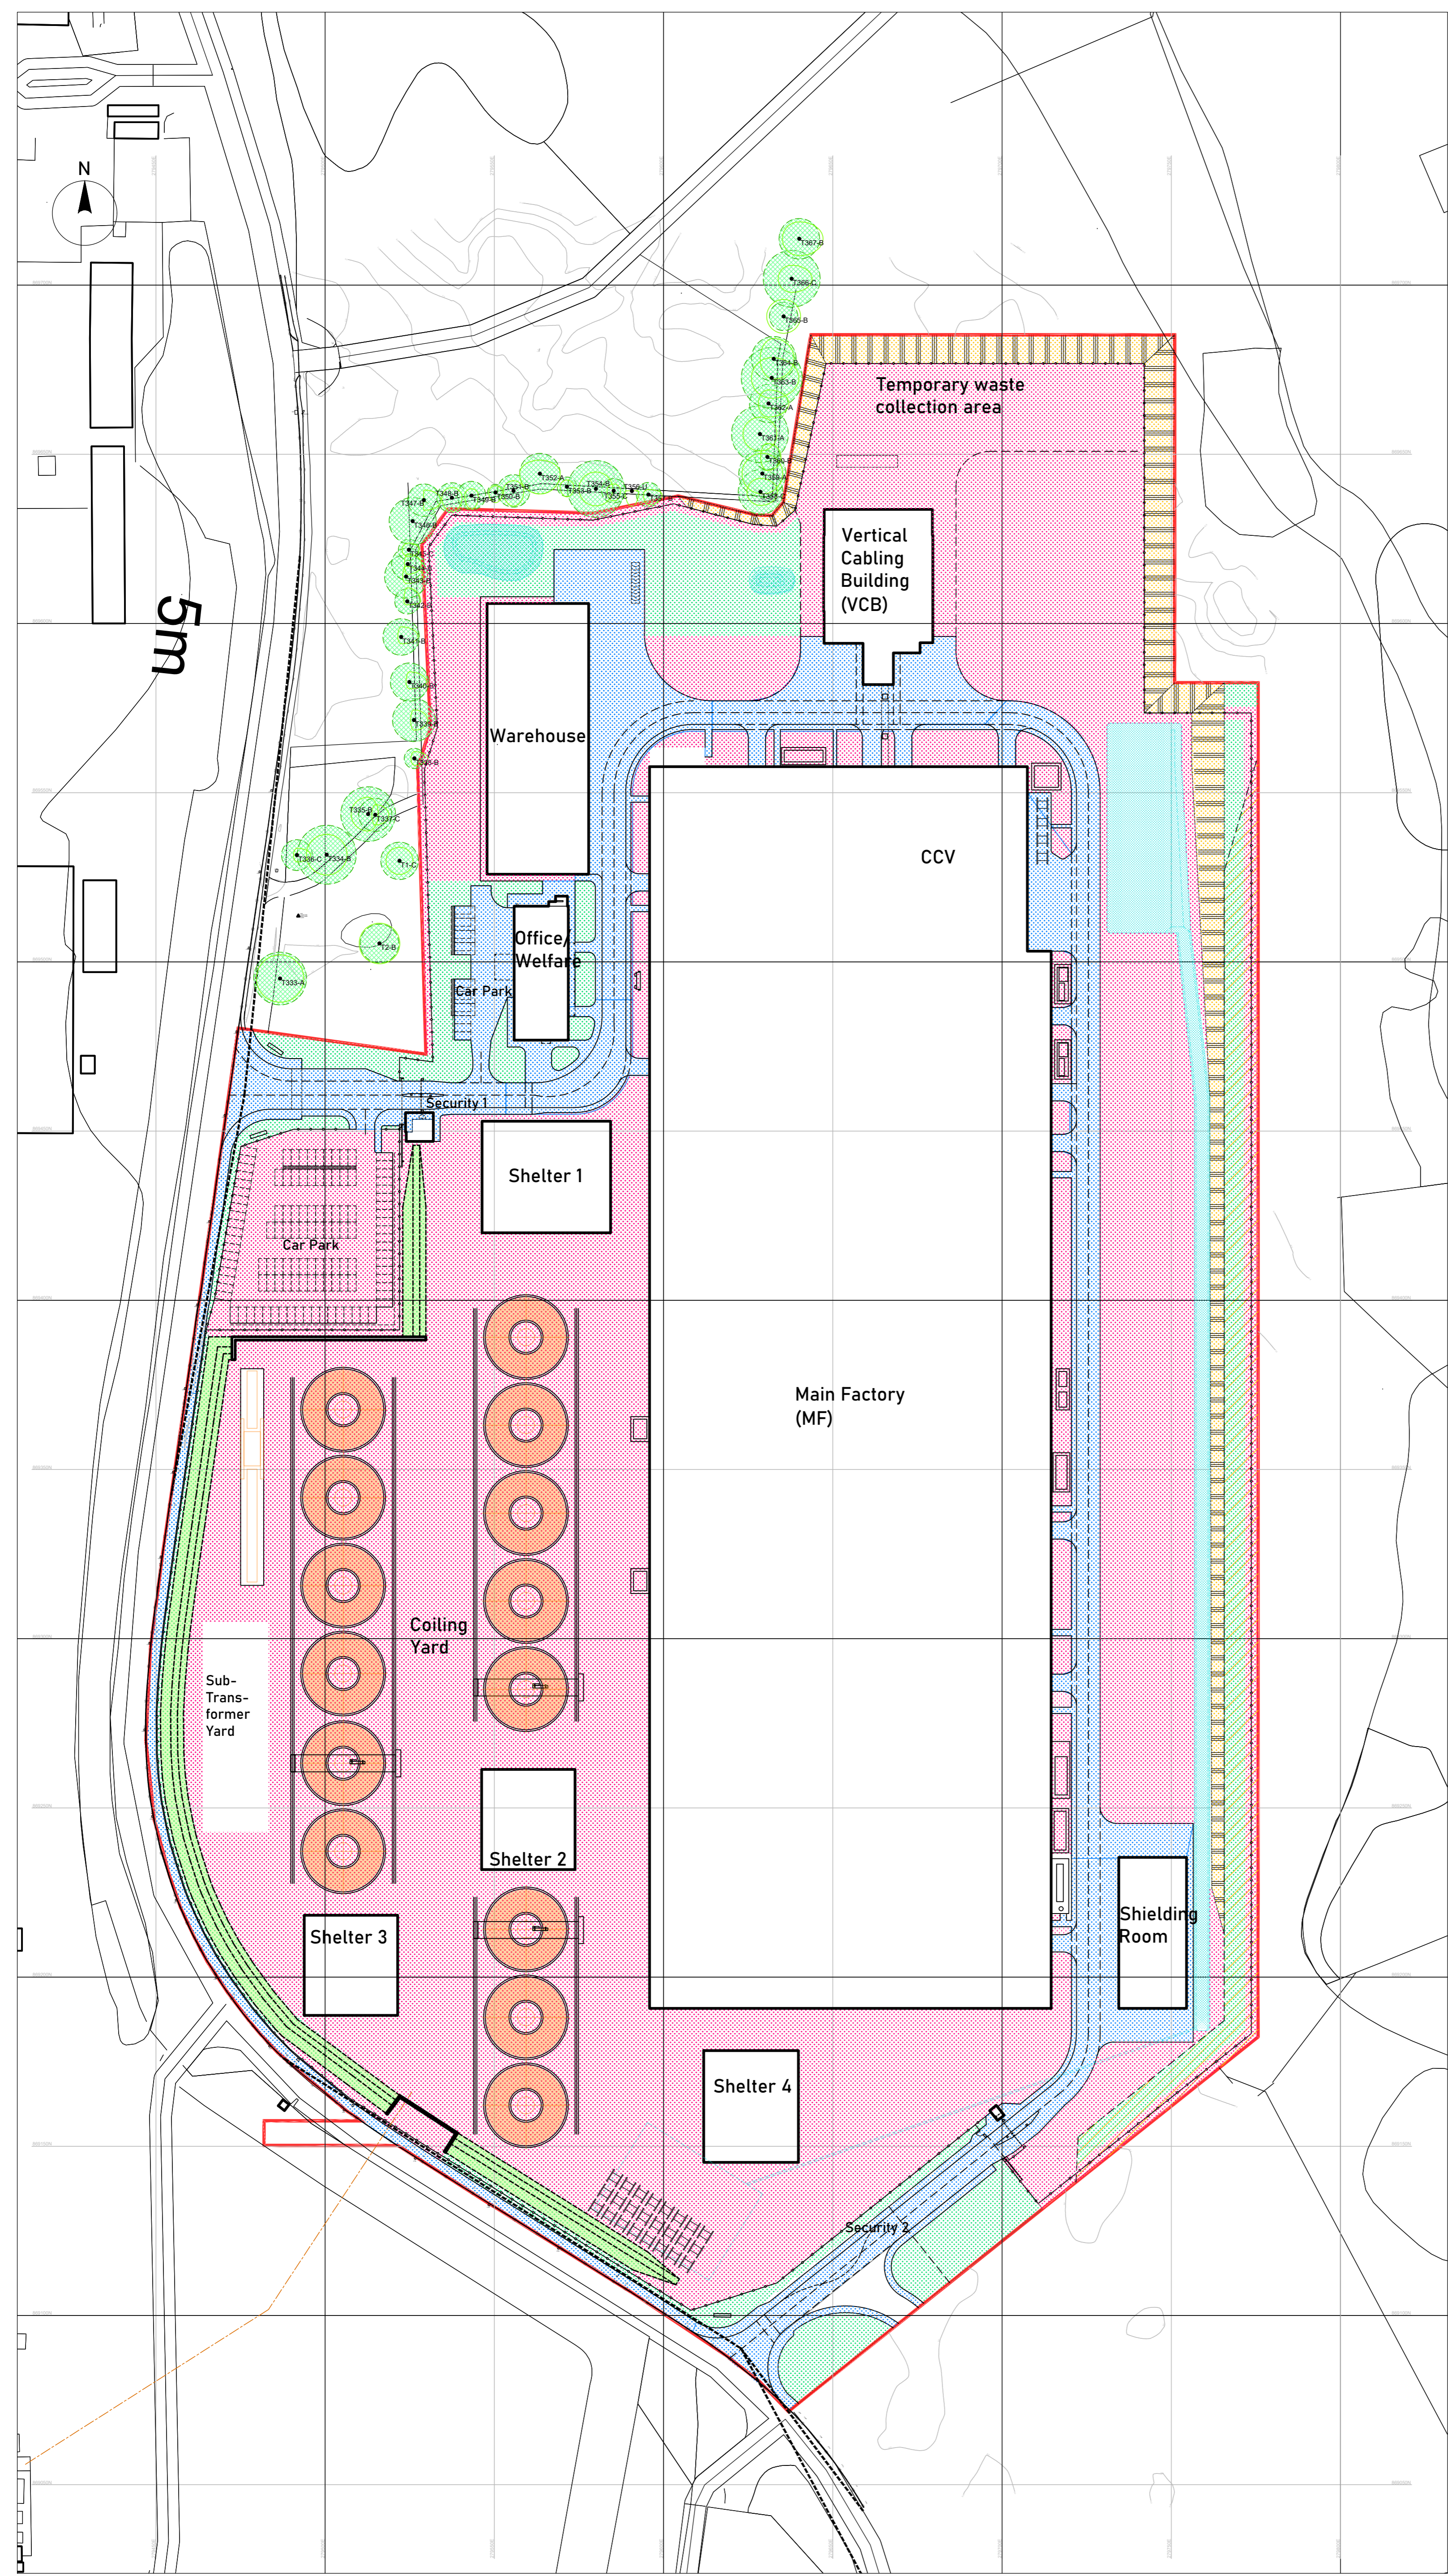

Project Design Team Members			
<b>Client</b>	Code <b>SUM/ CL</b>	<b>SUMITOMO ELECTRIC</b>	SEI, Kaji-cho Hiachi City Japan
<b>Project Management Contractors</b>	Code <b>EUR/ PMC</b>	<b>EUROPLAN GROUP</b>	
<b>Civil Engineers</b>	<b>EUR/ CS</b>		
<b>Structural Engineers</b>	<b>EUR/ SE</b>		Parkview House, Beechill Office Campus, Clonskeagh, Dublin 4, Ire. Tel: +353 1 2606578 staprojectteam@europlanservices.com
<b>Mechanical Engineers</b>	<b>EUR/ MP</b>		
<b>Electrical Engineers</b>	<b>EUR/ EL</b>		
<b>Architects</b>	Code <b>EDA/ AR</b>	<b>eda</b>	EDA Architects Ltd Orang Enterprise Centre, 41 Capwell Road, Orang BT18 5JL eoghan@eda-architects.com

© Copyright EDA Architects Ltd. The Construction (Design and Management) Regulations 2015 apply to this project. Please refer to the "Pre-Construction Information", "Construction Phase Plan" and other relevant documents. All dimensions in millimeters. This drawing is subject to statutory approval (planning, building control etc)

Legend	
	soft landscaping. see landscape architects landscape strategy.
	asphalt
	compacted hardcore
	wetland attenuation. see landscape architects landscape strategy.
	reinforced slope. see engineers specification and landscape architect's landscape strategy.
	concrete, rubble finish.

Rev	Date	Description
P05	29.09.23	minor revisions
P04	26.09.23	revised following feedback from landscape architect.
P03	24.09.23	revised boundary to suit RPA.
P02	21.08.23	revised layout. RIBA3 stage issue.
P01	17.08.23	revised layout. RIBA3 stage issue.

**SEUK CL**  
**SUMITOMO ELECTRIC** NIGG, TAIN IV19 1QU

Discipline: ARCHITECT


Sheet Title:  
EXTERNAL SURFACING  
KEY PLAN

Sheet Number	PROJECT	ORIGINATOR	VOLUME	LEVEL
	<b>S263</b>	AR	EXT	EX
TYPE	ROLE	NO.	SUIT.	REV.
DR	AR	700	S4	P05

Scale:	1:1000 (A1)	<b>EUROPLAN GROUP</b> Project Management Contractors Parkview House, Beechill Office Campus, Clonskeagh, Dublin 4, Ire. Tel: +353 1 2606578 staprojectteam@europlanservices.com
Date:	07.08.23	
By: ED	Chk: ED	

External Surfacing  
1:1000

1:1000 scale bar  
0 10m 50m

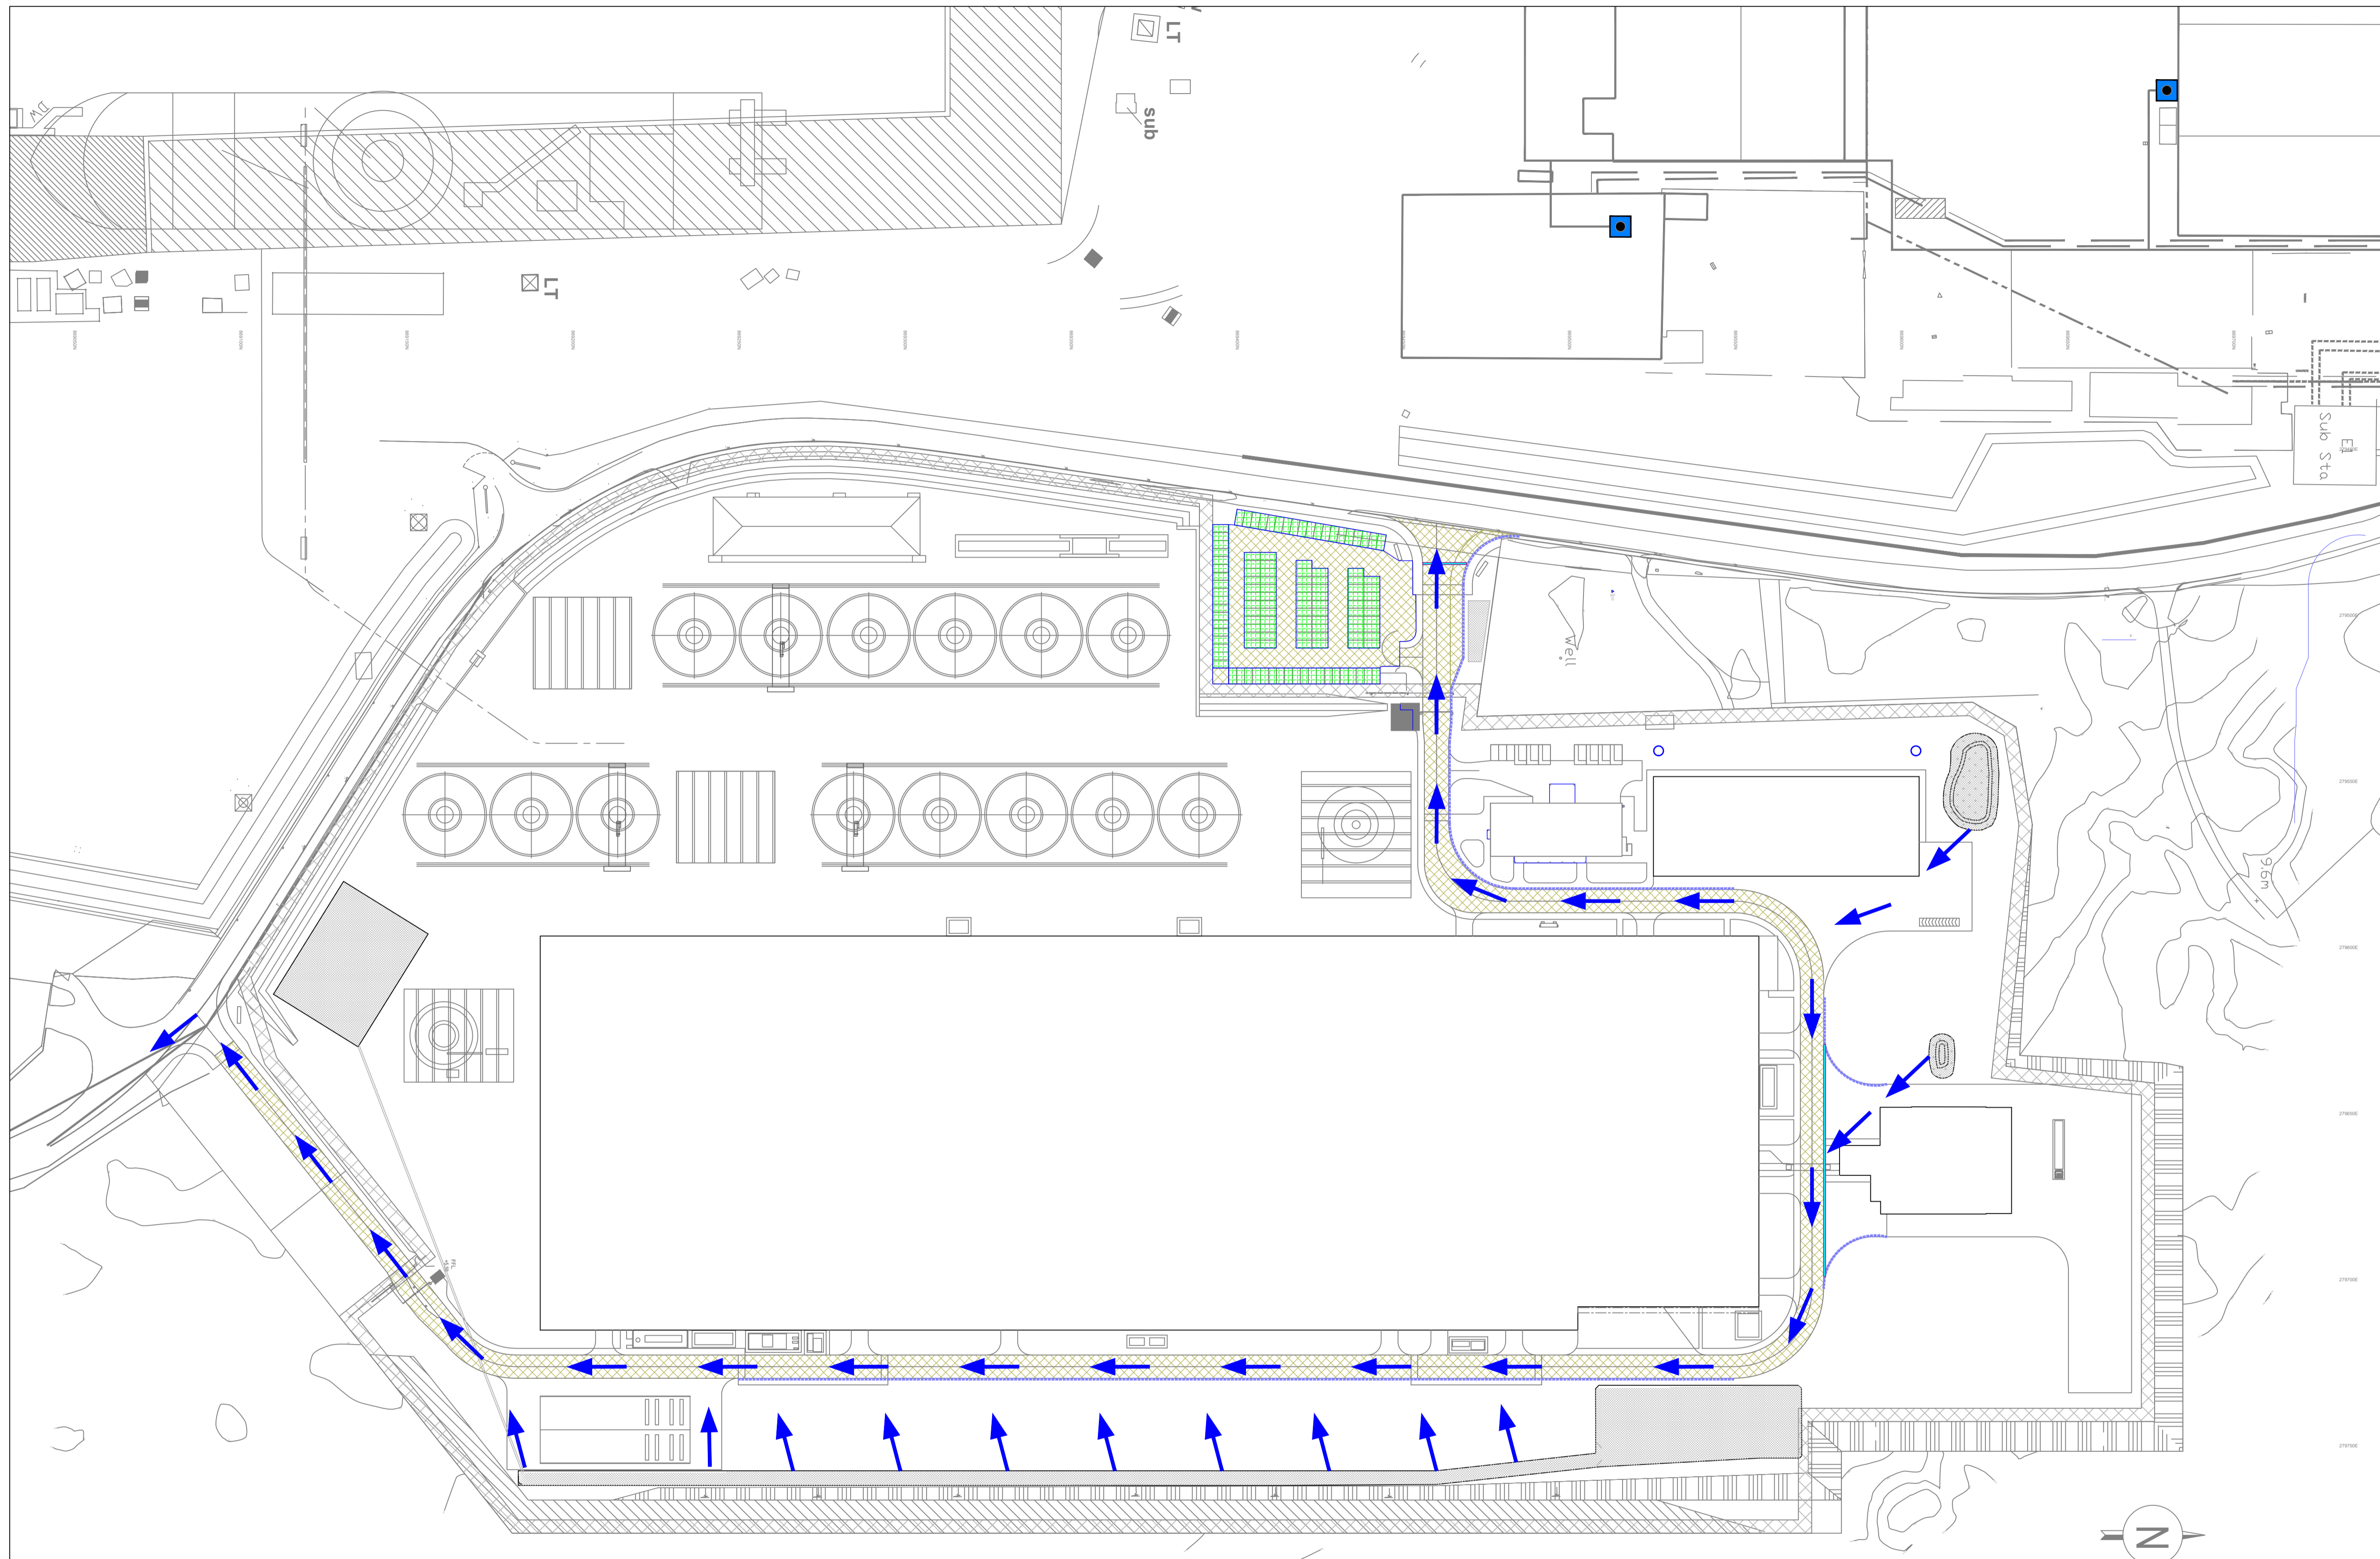

ALL DIMENSIONS TO BE CHECKED ON SITE. NO DIMENSIONS TO BE SCALED FROM THIS DRAWING. DRAWING IS TO BE READ IN CONJUNCTION WITH RELEVANT CONSULTANTS DRAWINGS.

**A1**

SITE KEY PLAN

LEGEND

→ Direction of flow

**STA CABLE FACTORY**  
 SUMITOMO NIGG, TAIN IV19 1QU  
 ELECTRIC

eda ARCHITECTS  
 EDA Architects Ltd  
 Omagh Enterprise Centre,  
 41 Gortash Ind Est,  
 Omagh BT78 5LU  
 eoghan@eda-architects.com

REVISIONS

REV	DATE	DESCRIPTION	CHK	DRN

STATUS  
 PLANNING

PROJECT  
 SEIUK - CL

PROJECT ADDRESS  
 -

DISCIPLINE  
 CIVIL

DWG TITLE  
 Storm Water - Flow Direction

DWG NO.  
 S264-EUR-EXT-ZZ-DR-CS-26200

STATUS CODE  
 C4

PROJECT NO. S264	DATE 12/07/23
DRAWN / CHECKED DG	SCALE NO. 1:1000

REVISION NUMBER

**P03**

**EUROPLAN GROUP**  
 Parkview House, Beechill Office Campus,  
 Clonskeagh, Dublin 4, Eire.  
 Tel: +353 1 2606578  
 staprojectteam@europlanservices.com